




GARAGE PAINTERS BENCH
DETAILS AND LOCATION
SEE 54-5

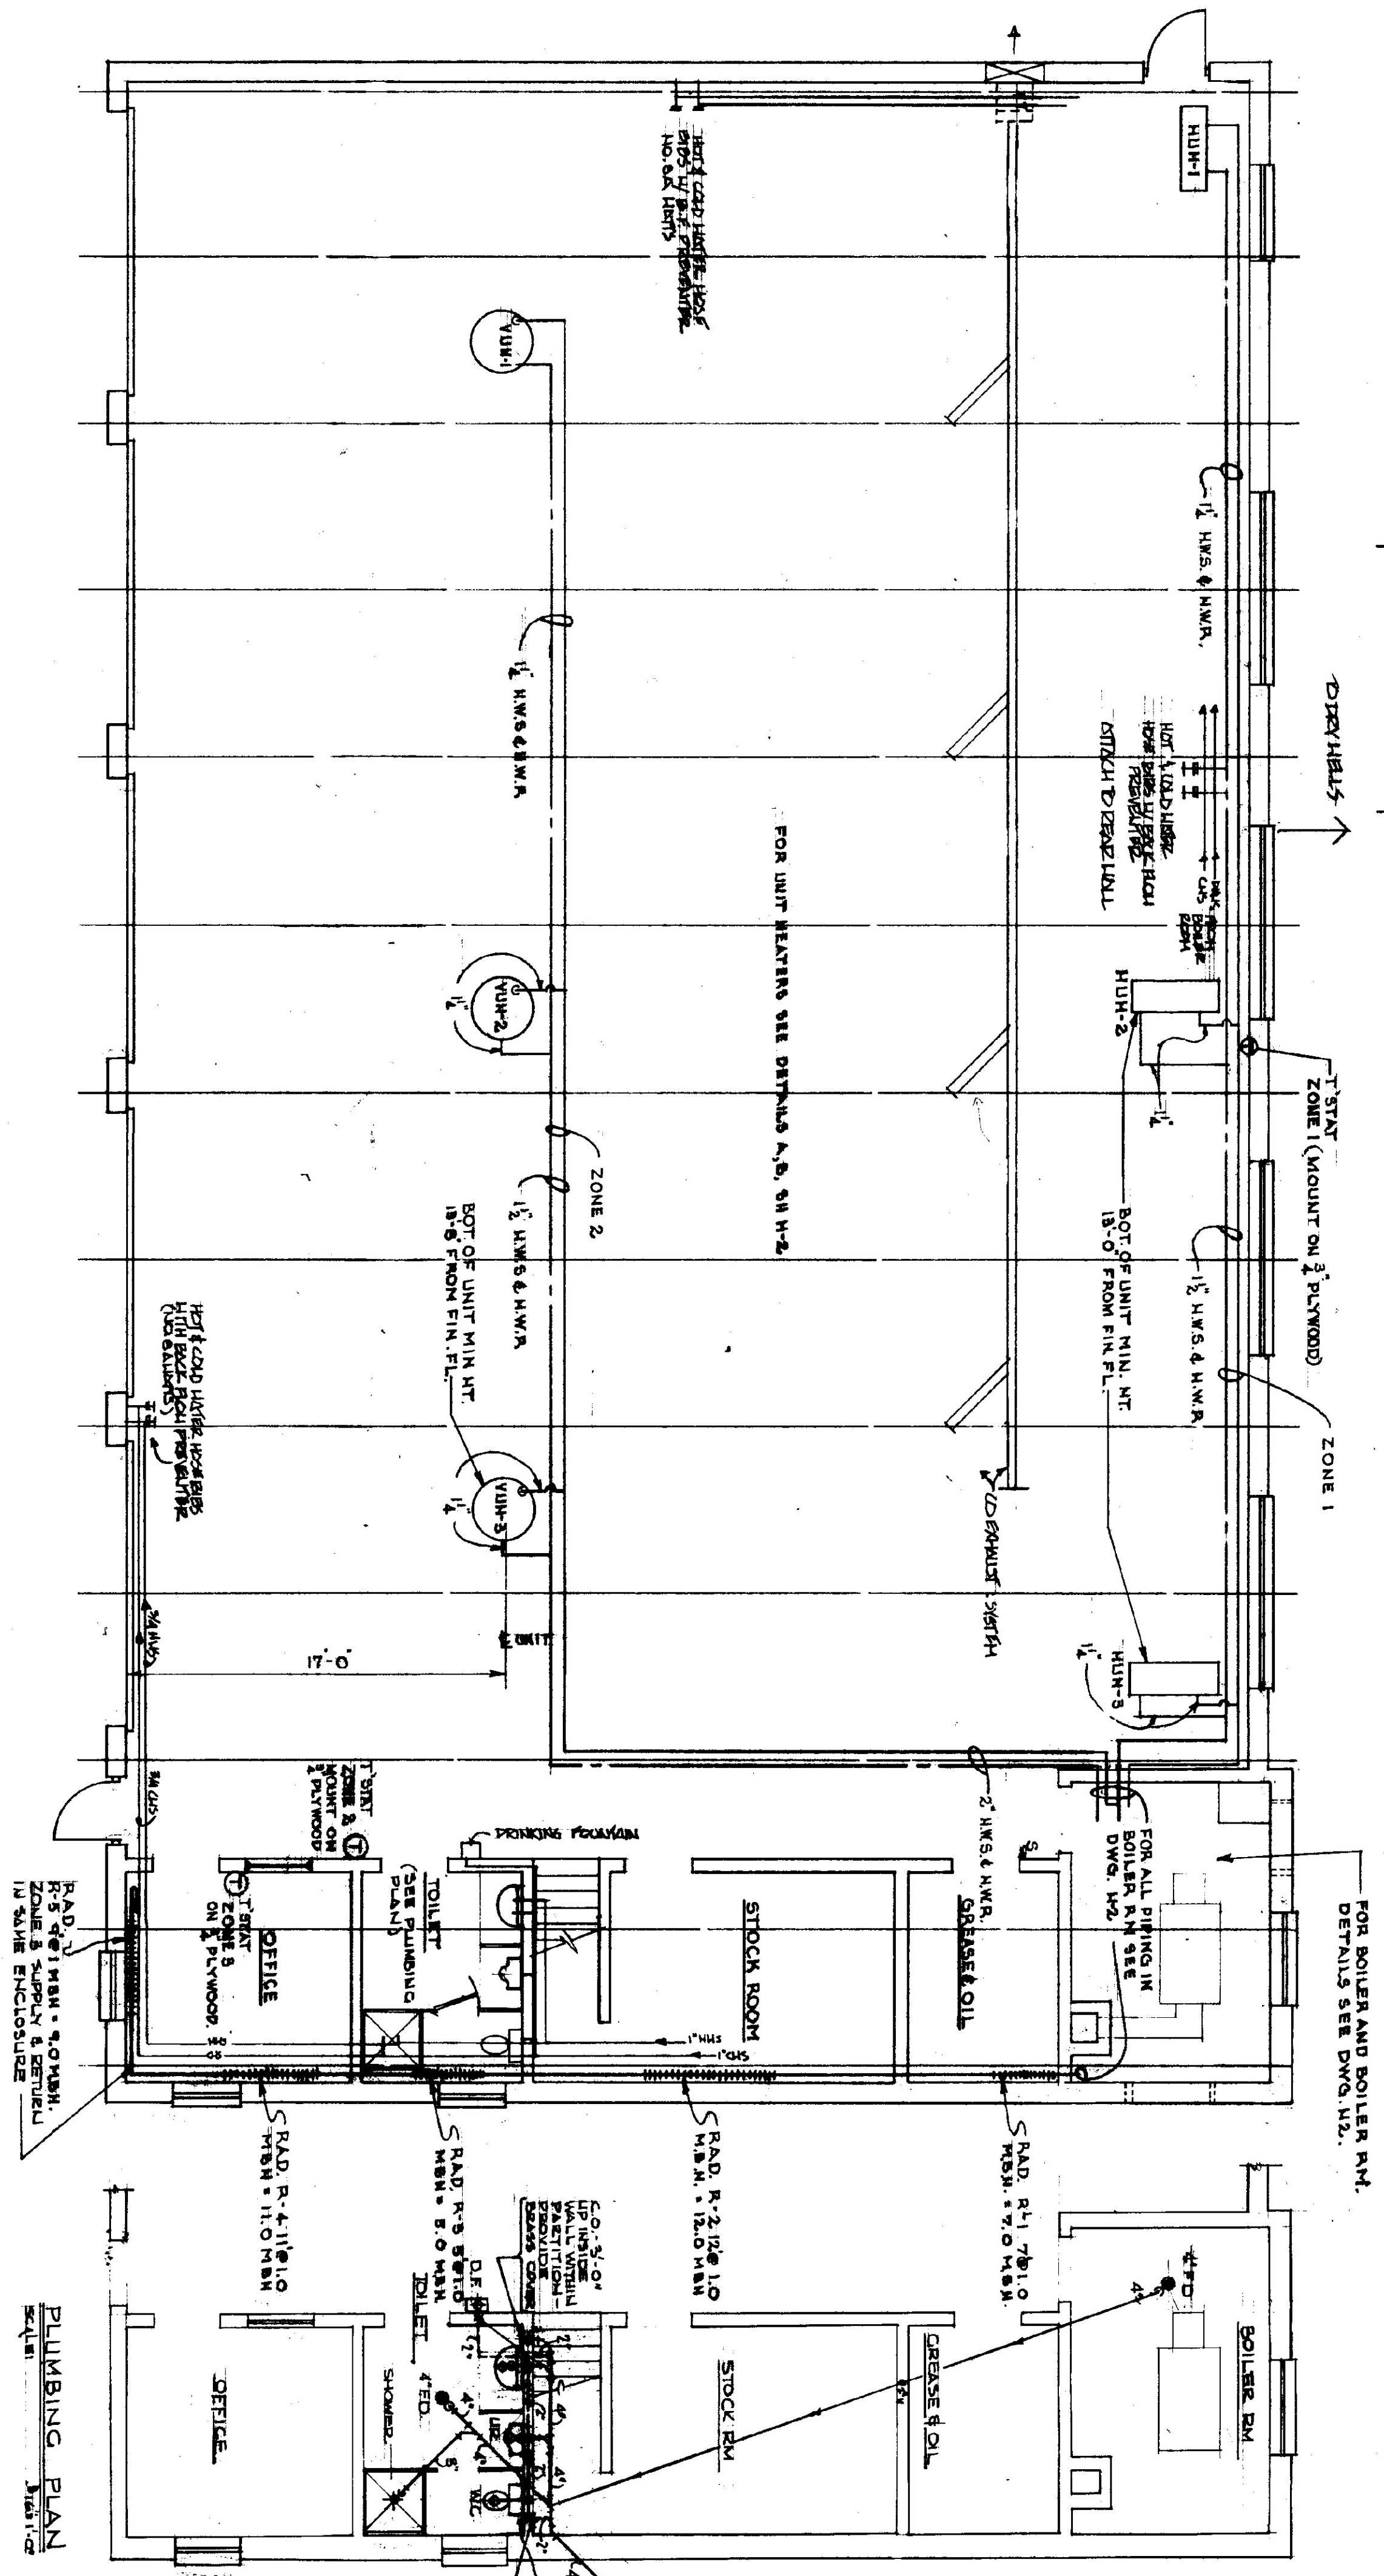


HEATING PLAN
(5 BAY)
SCALE: 1/8" = 1'-0"

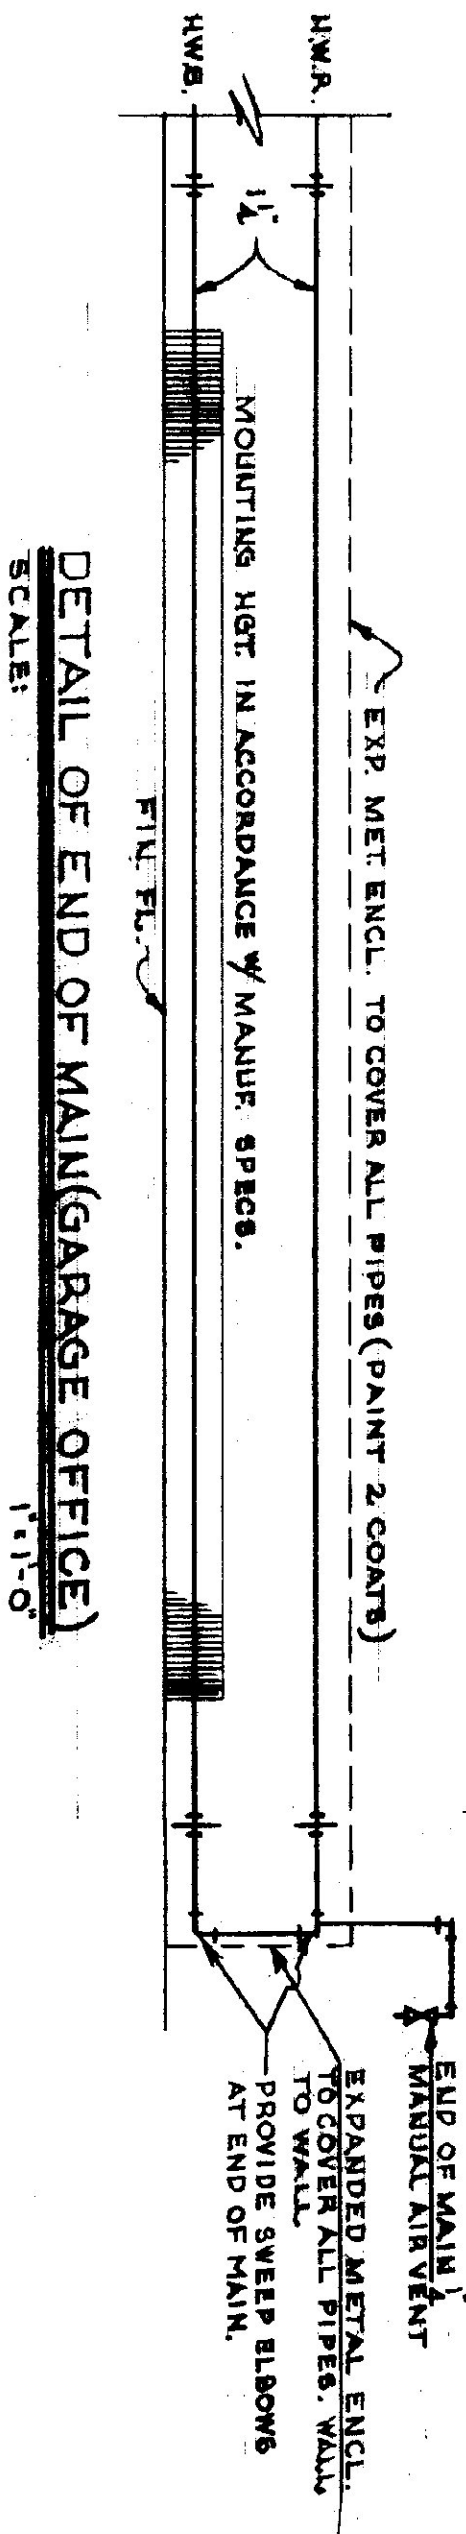


DETAIL OF END OF MAIN (GARAGE OFFICE)
SCALE: 1/4" = 1'-0"

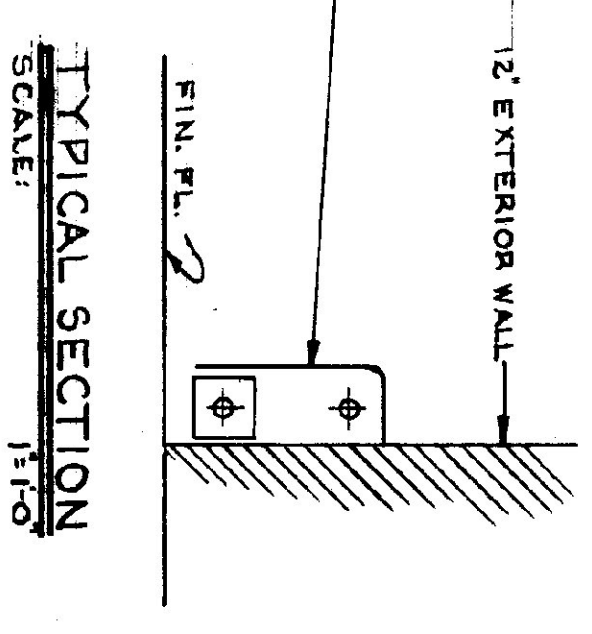


TYPICAL SECTION
SCALE: 1/4" = 1'-0"

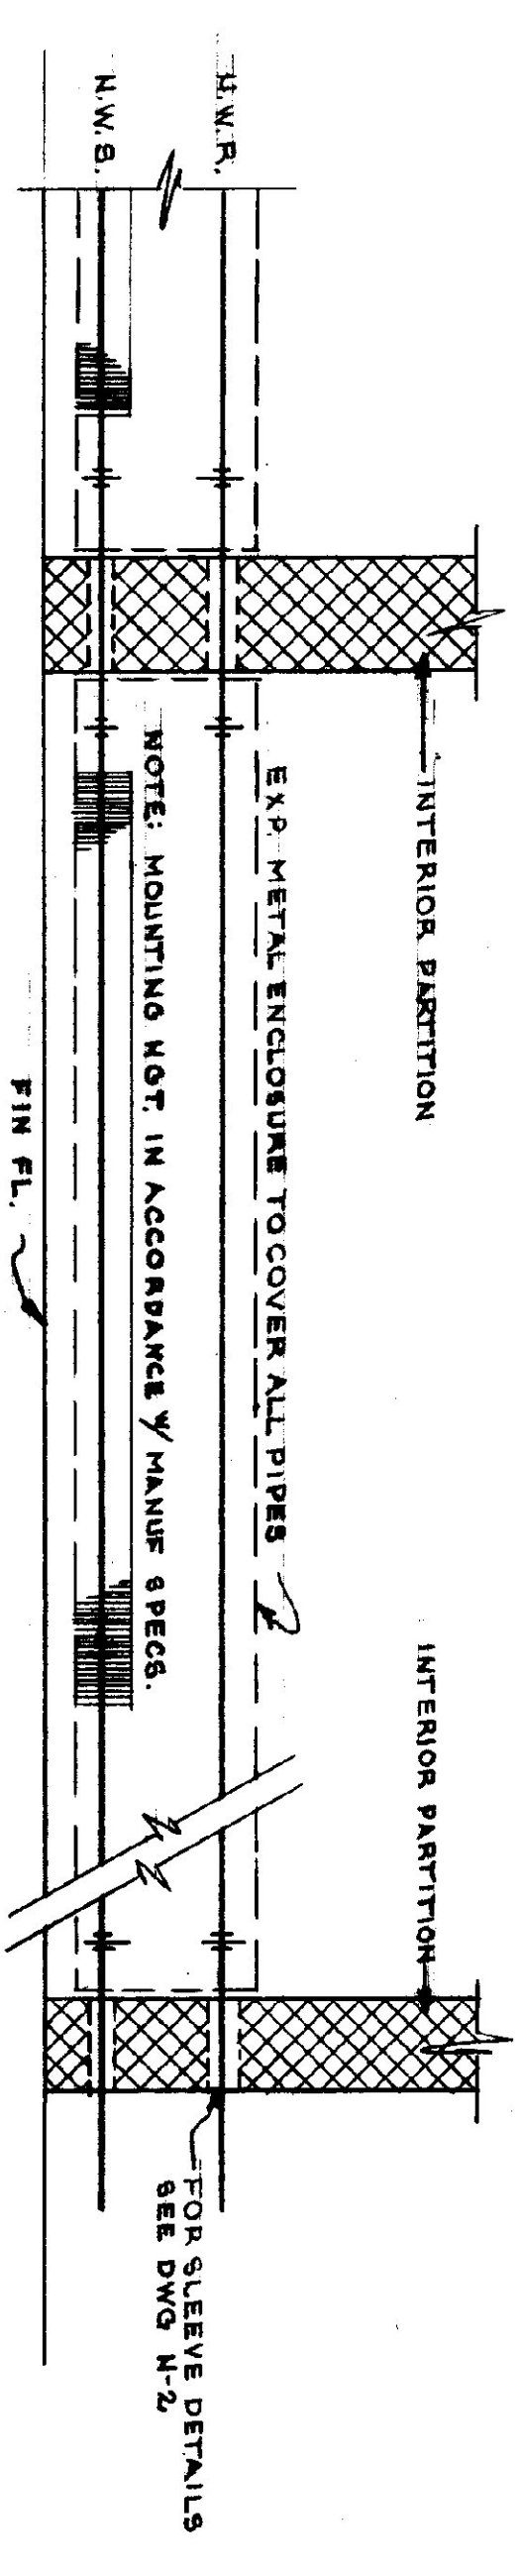

TYPICAL BASEBOARD RADIATION PIPING
SCALE: 1/4" = 1'-0"

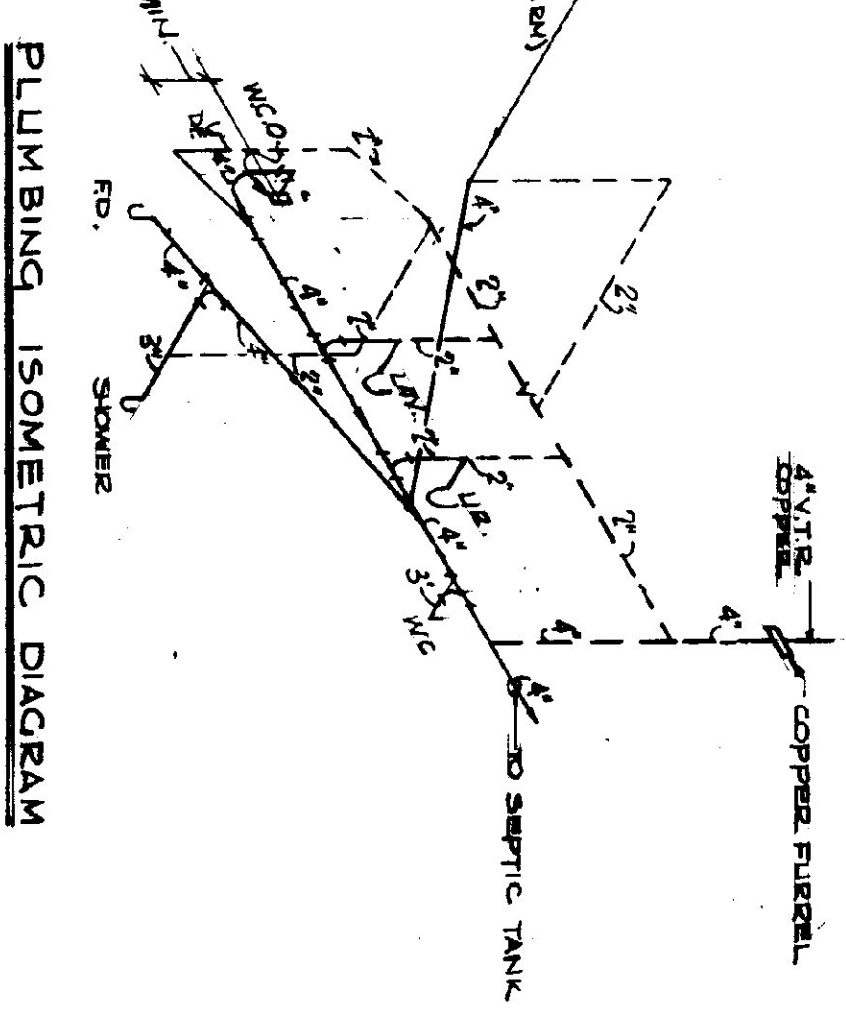

PLUMBING ISOMETRIC DIAGRAM

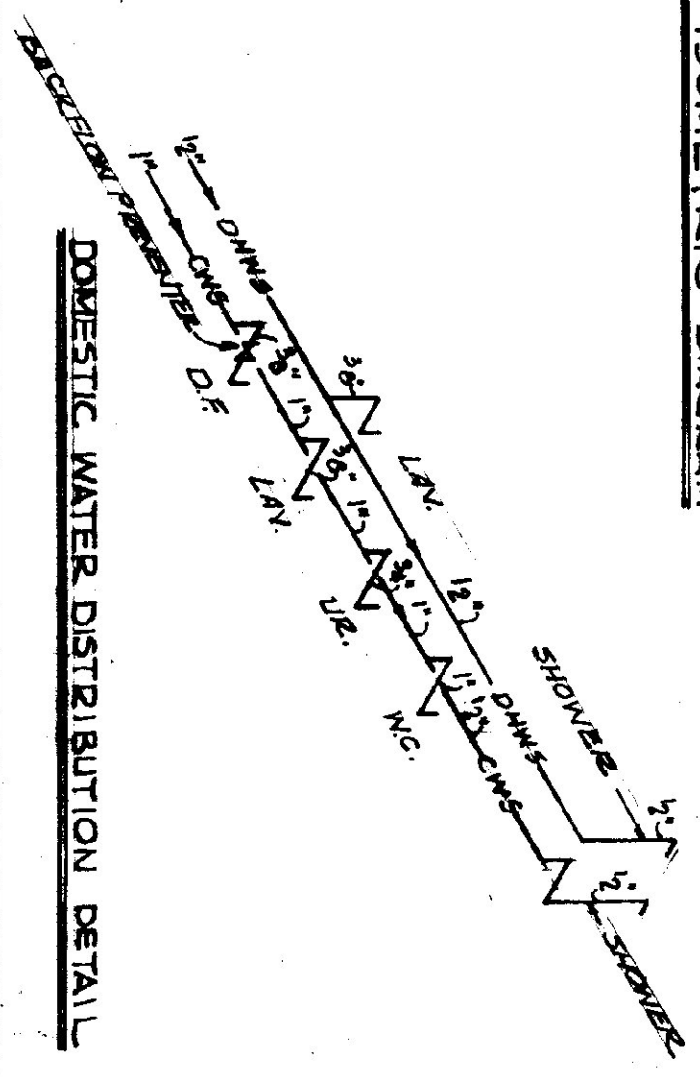

DOMESTIC WATER DISTRIBUTION DETAIL

SEE DRAWING H-2 FOR SCHEDULES & GENERAL NOTES

- LEGEND
- H.W.S. --- HEATING WATER SUPPLY
 - H.W.R. --- HEATING WATER RETURN
 - ⊕ BURNER SAFETY SWITCH (GAS) & GAS VALVE
 - ⊕ T STATE PIPE SUPPLY TO BOTTOM & RETURN TO TOP
 - H.U.H. --- HANGING UP HOOK
 - ⊕ GATE VALVE
 - ⊕ CHECK VALVE
 - ⊕ BALANCING COCK
 - ⊕ FLOW CONTROL VALVE
 - ⊕ LIQUID FUSIBLE LEVER-HYDRA-TIC VALVE
 - ⊕ STRAINER
 - ⊕ P.V. --- ALL BRONZE
 - ⊕ B.K. --- BACK FROM REPAIRS

DATE: 10-18-74	DESIGNED BY: C.W. MAZUR	DRAWN BY: H.I.
CHECKED BY: J. STUBBS	APPROVED BY: J. STUBBS	SCALE: AS SHOWN
STATE OF VERMONT DIVISION OF STATE BUILDINGS AGENCY OF ADMINISTRATION VERMONT Standard Five Bay Highway Garage Bldg. HEATING PLAN		