




FLOOR PLAN 1/4"=1'-0"

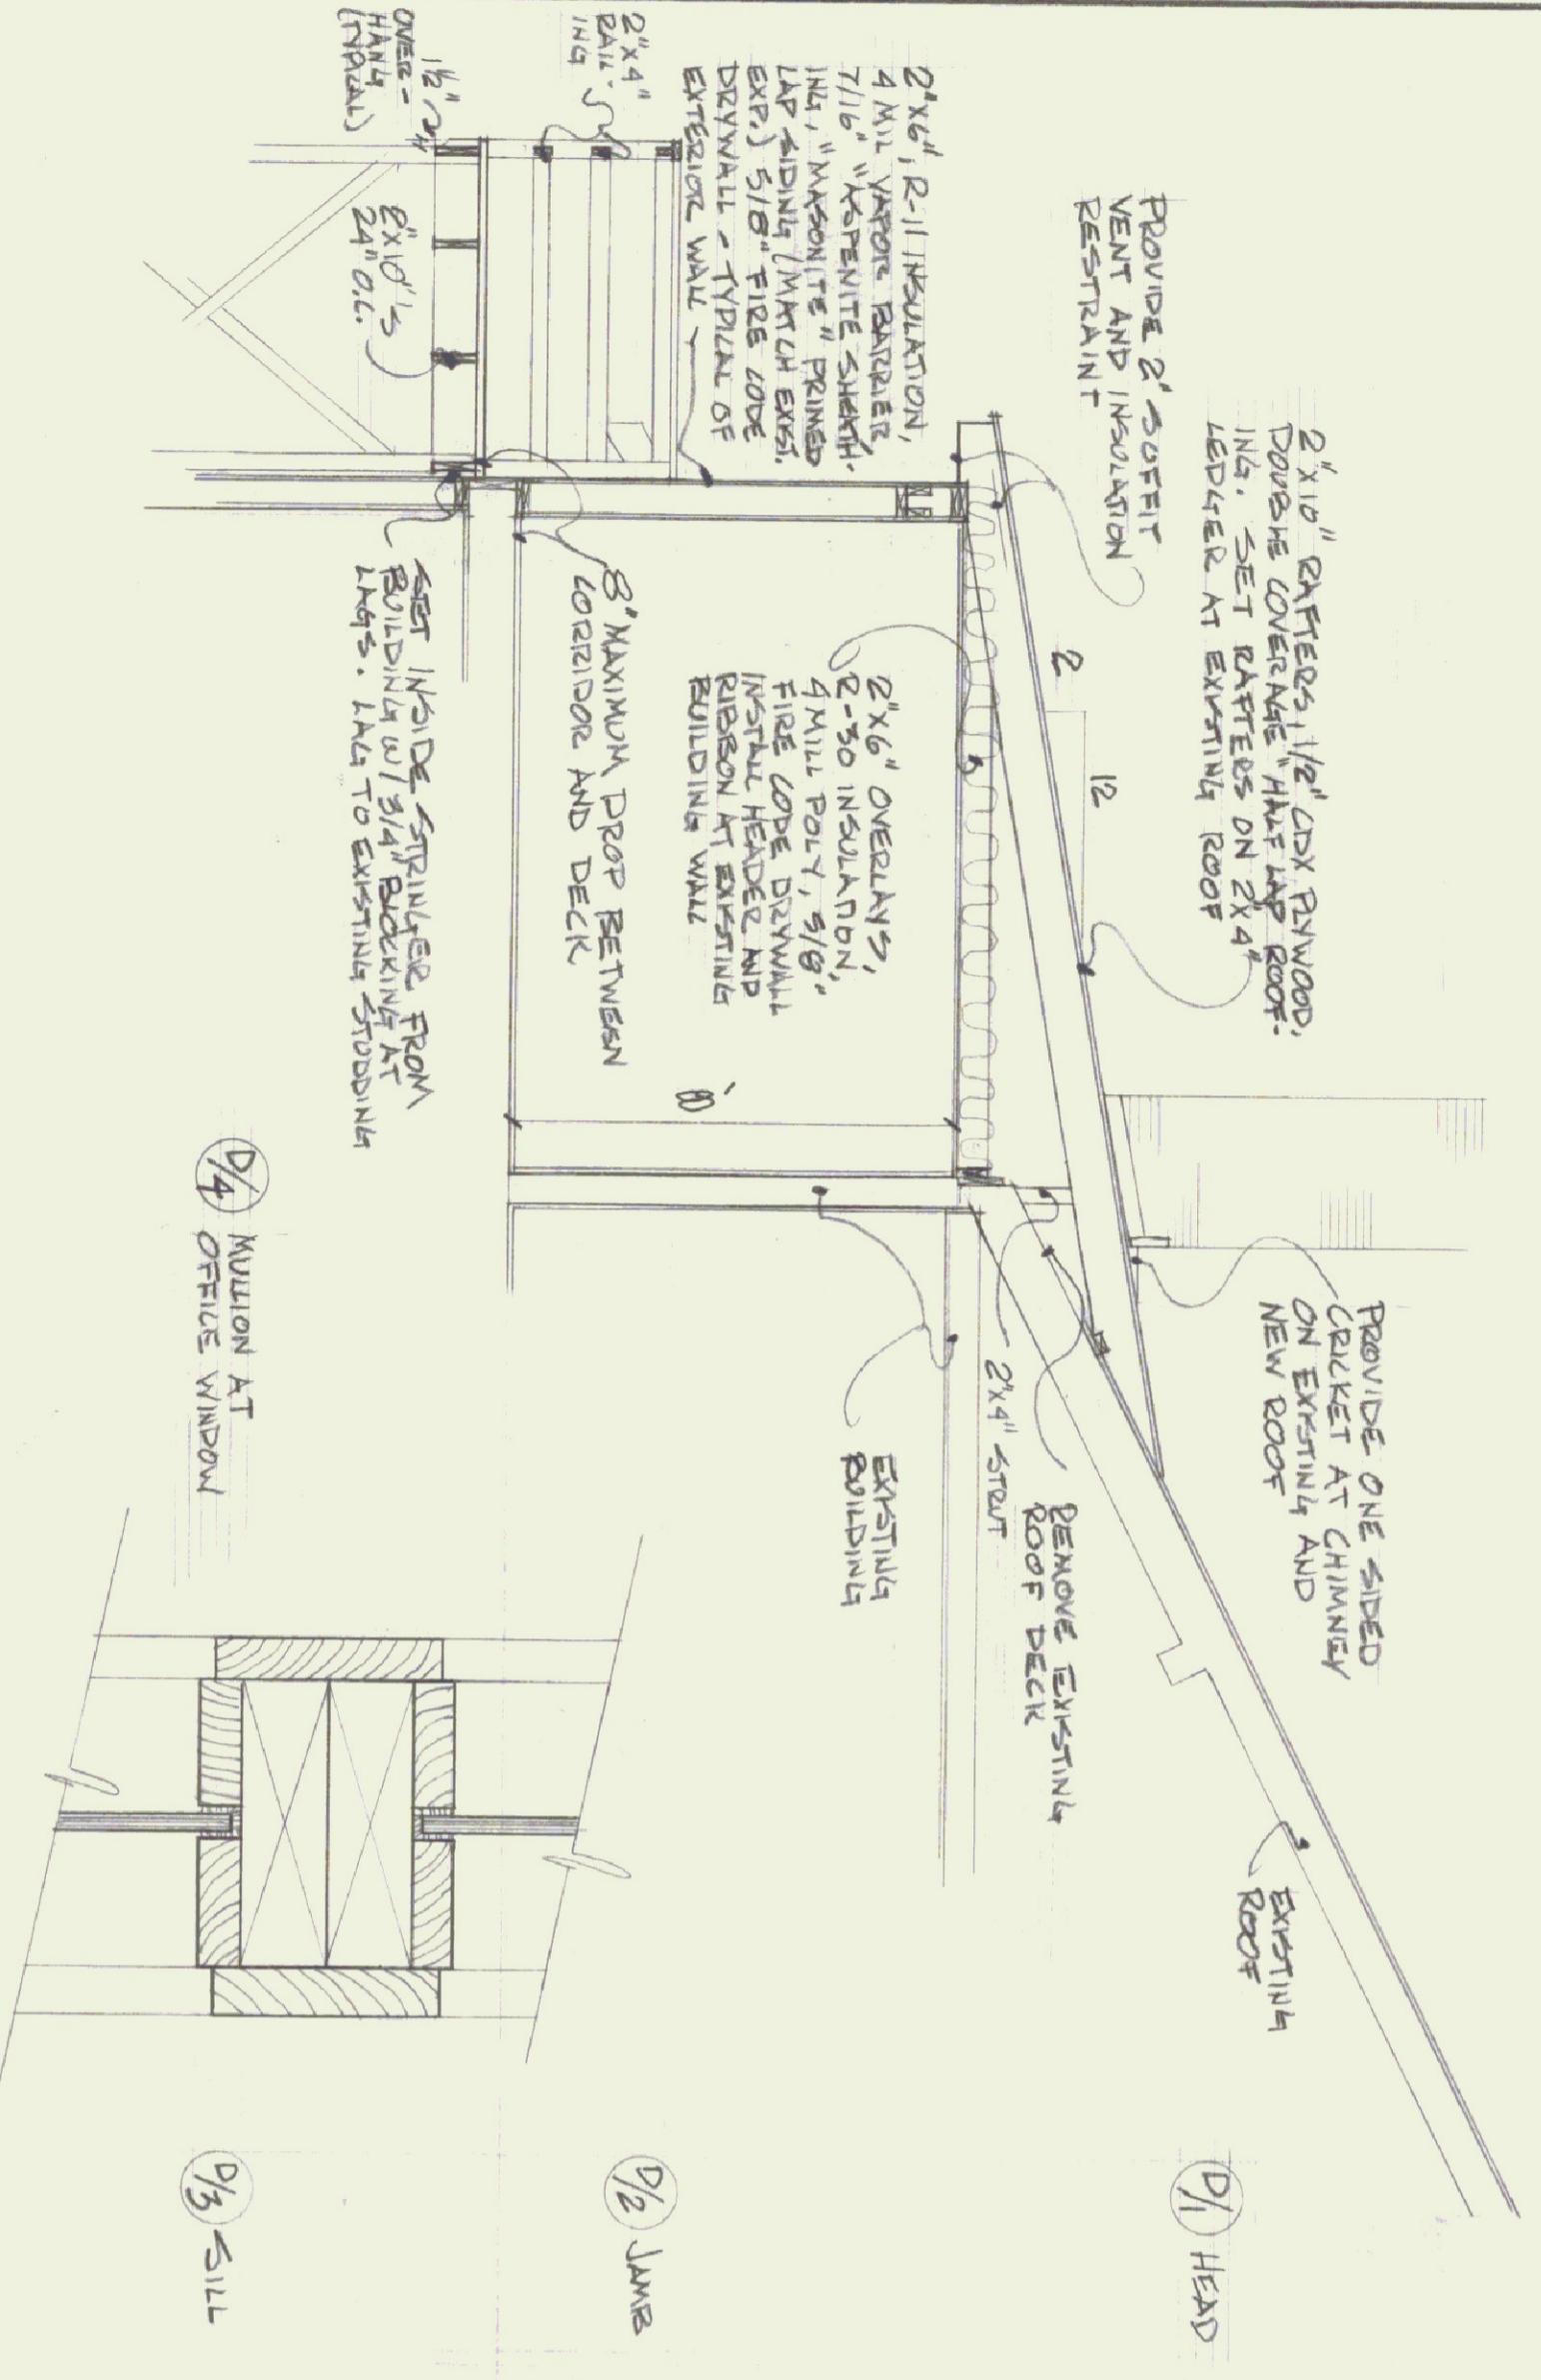


SECTION "A-A" 1/4"=1'-0"

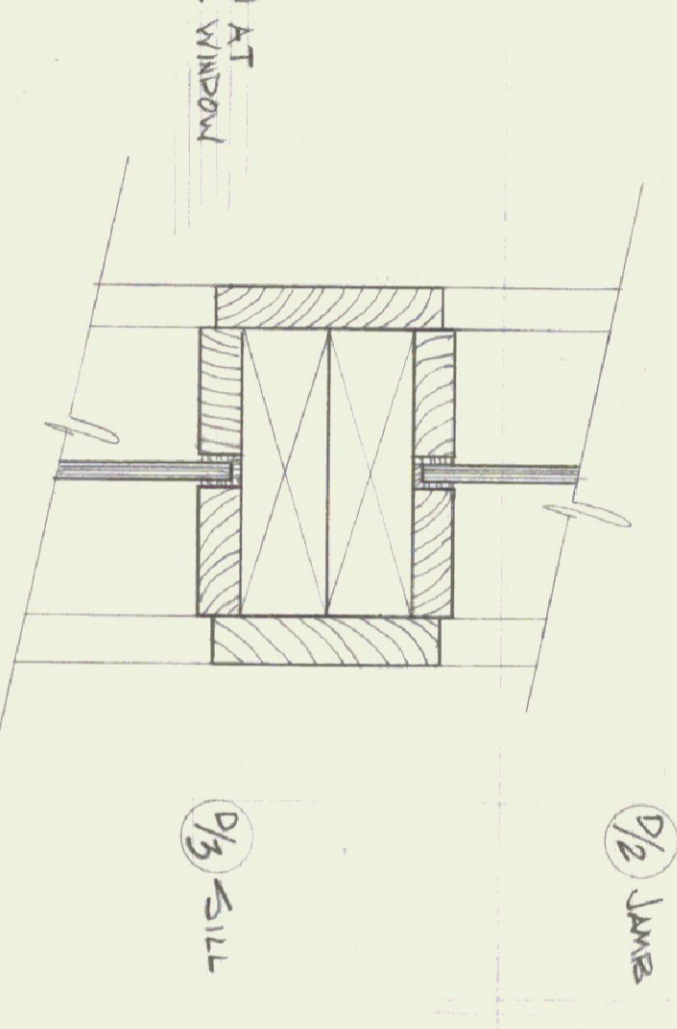

TYPICAL WINDOW DETAILS 3/4"=1'-0"

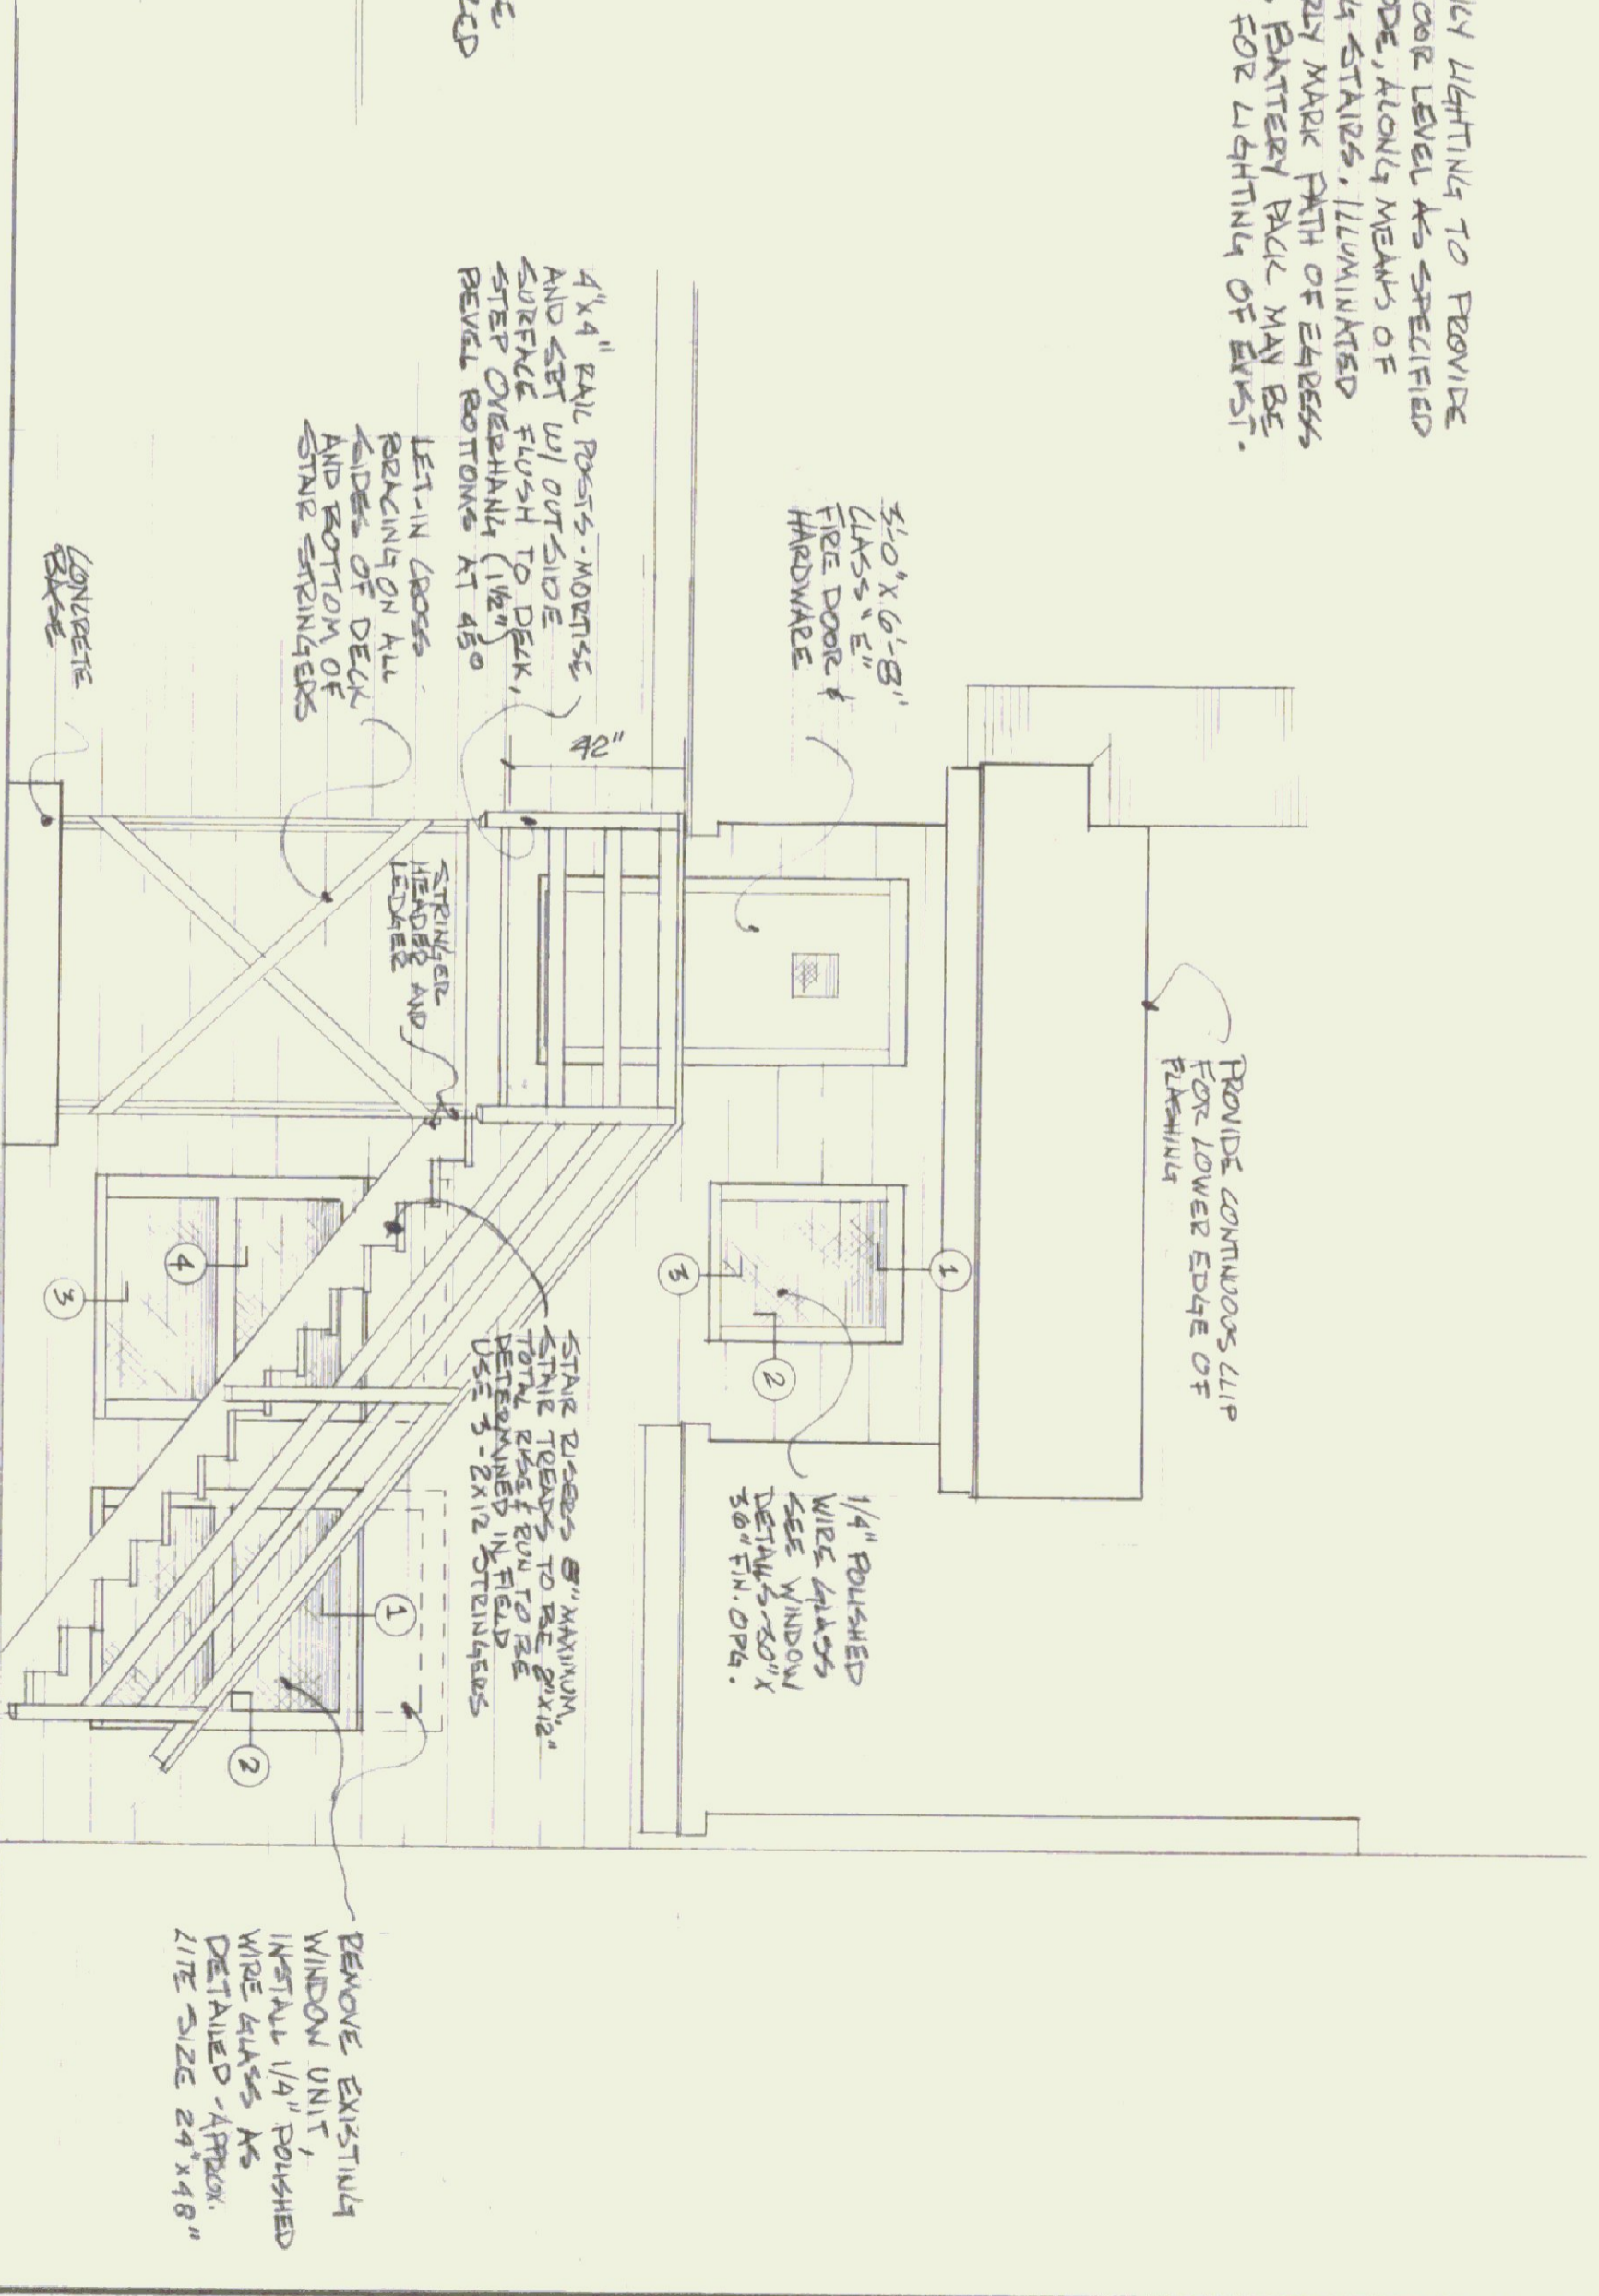

ELEVATION E/1 1/4"=1'-0"

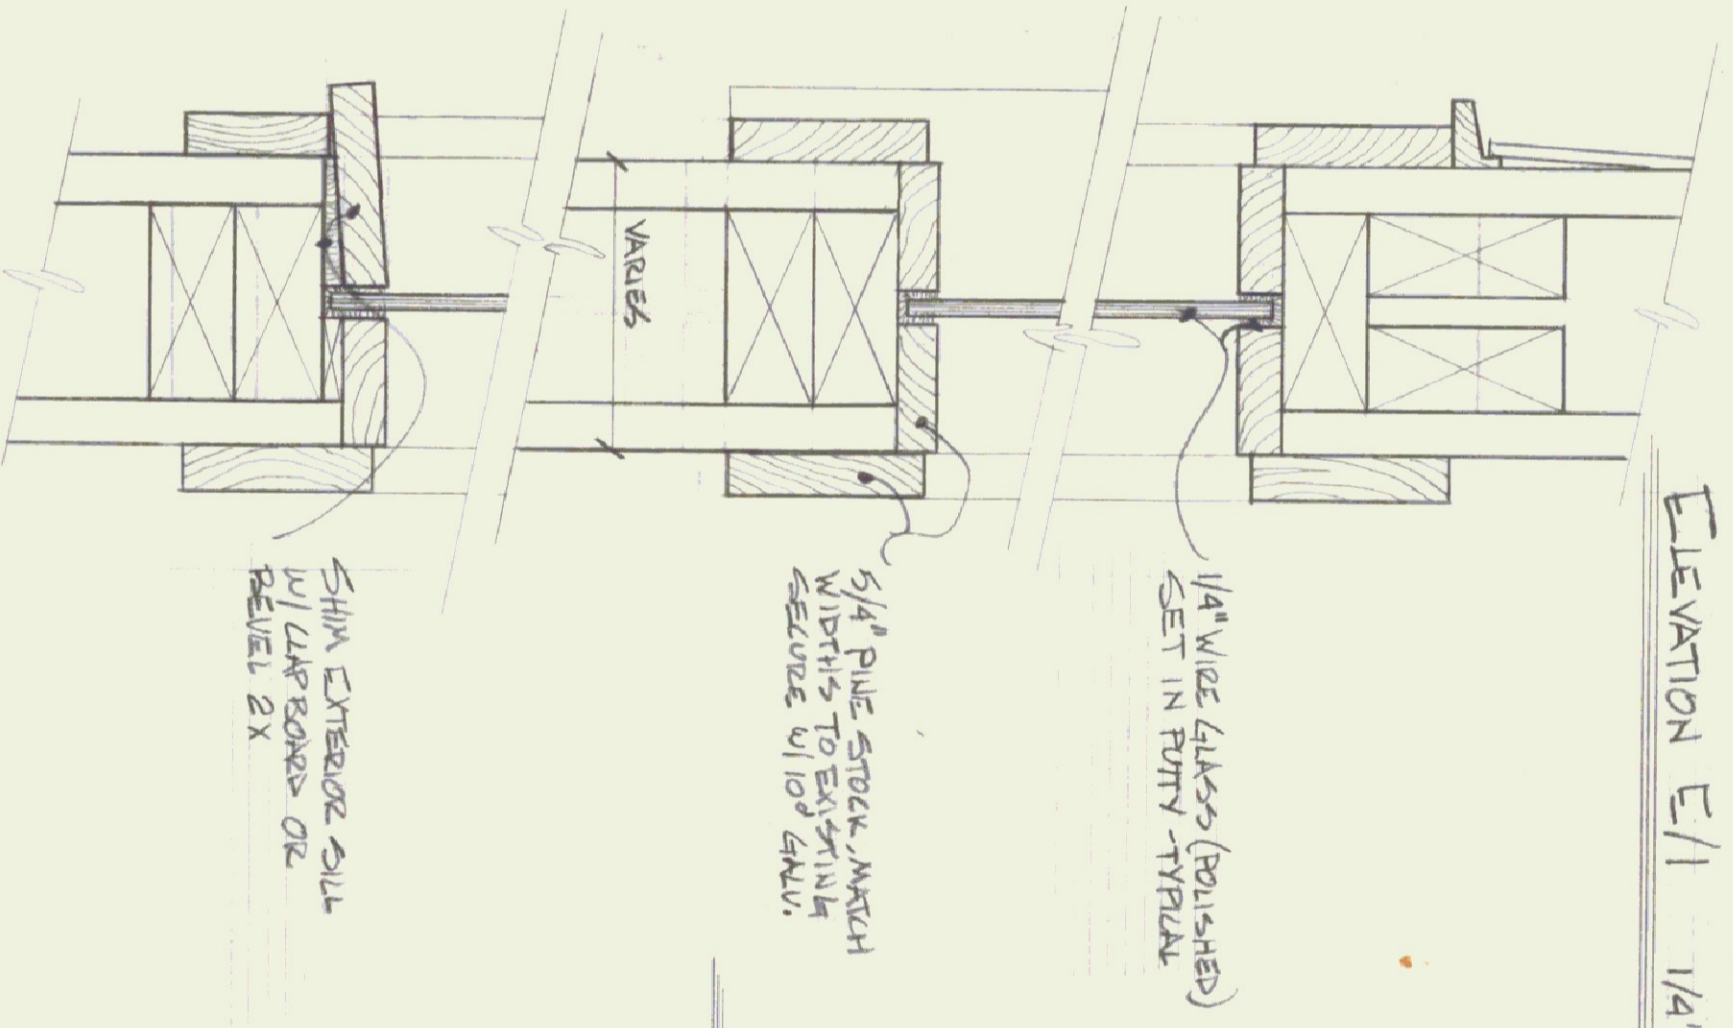

SCHEMATIC LIGHTING DIAGRAM

STATE OF VERMONT			
DIVISION OF STATE BUILDINGS			
AGENCY OF ADMINISTRATION			
MONTPELIER, VERMONT			
RENOVATIONS TO PROVIDE SECOND FLOOR FIRE EXIT			
A.O.T. DISTRICT OFFICE BUILDING			
BRATTLEBORO VERMONT			
DATE: NOV 10, 1981	SCALE: AS SHOWN	REVISIONS: 11/81/81	DWG. NO. 1
DRAWN BY: HAWSON	APPROVED BY: [Signature]	DATE: 11/81/81	1 OF 1