




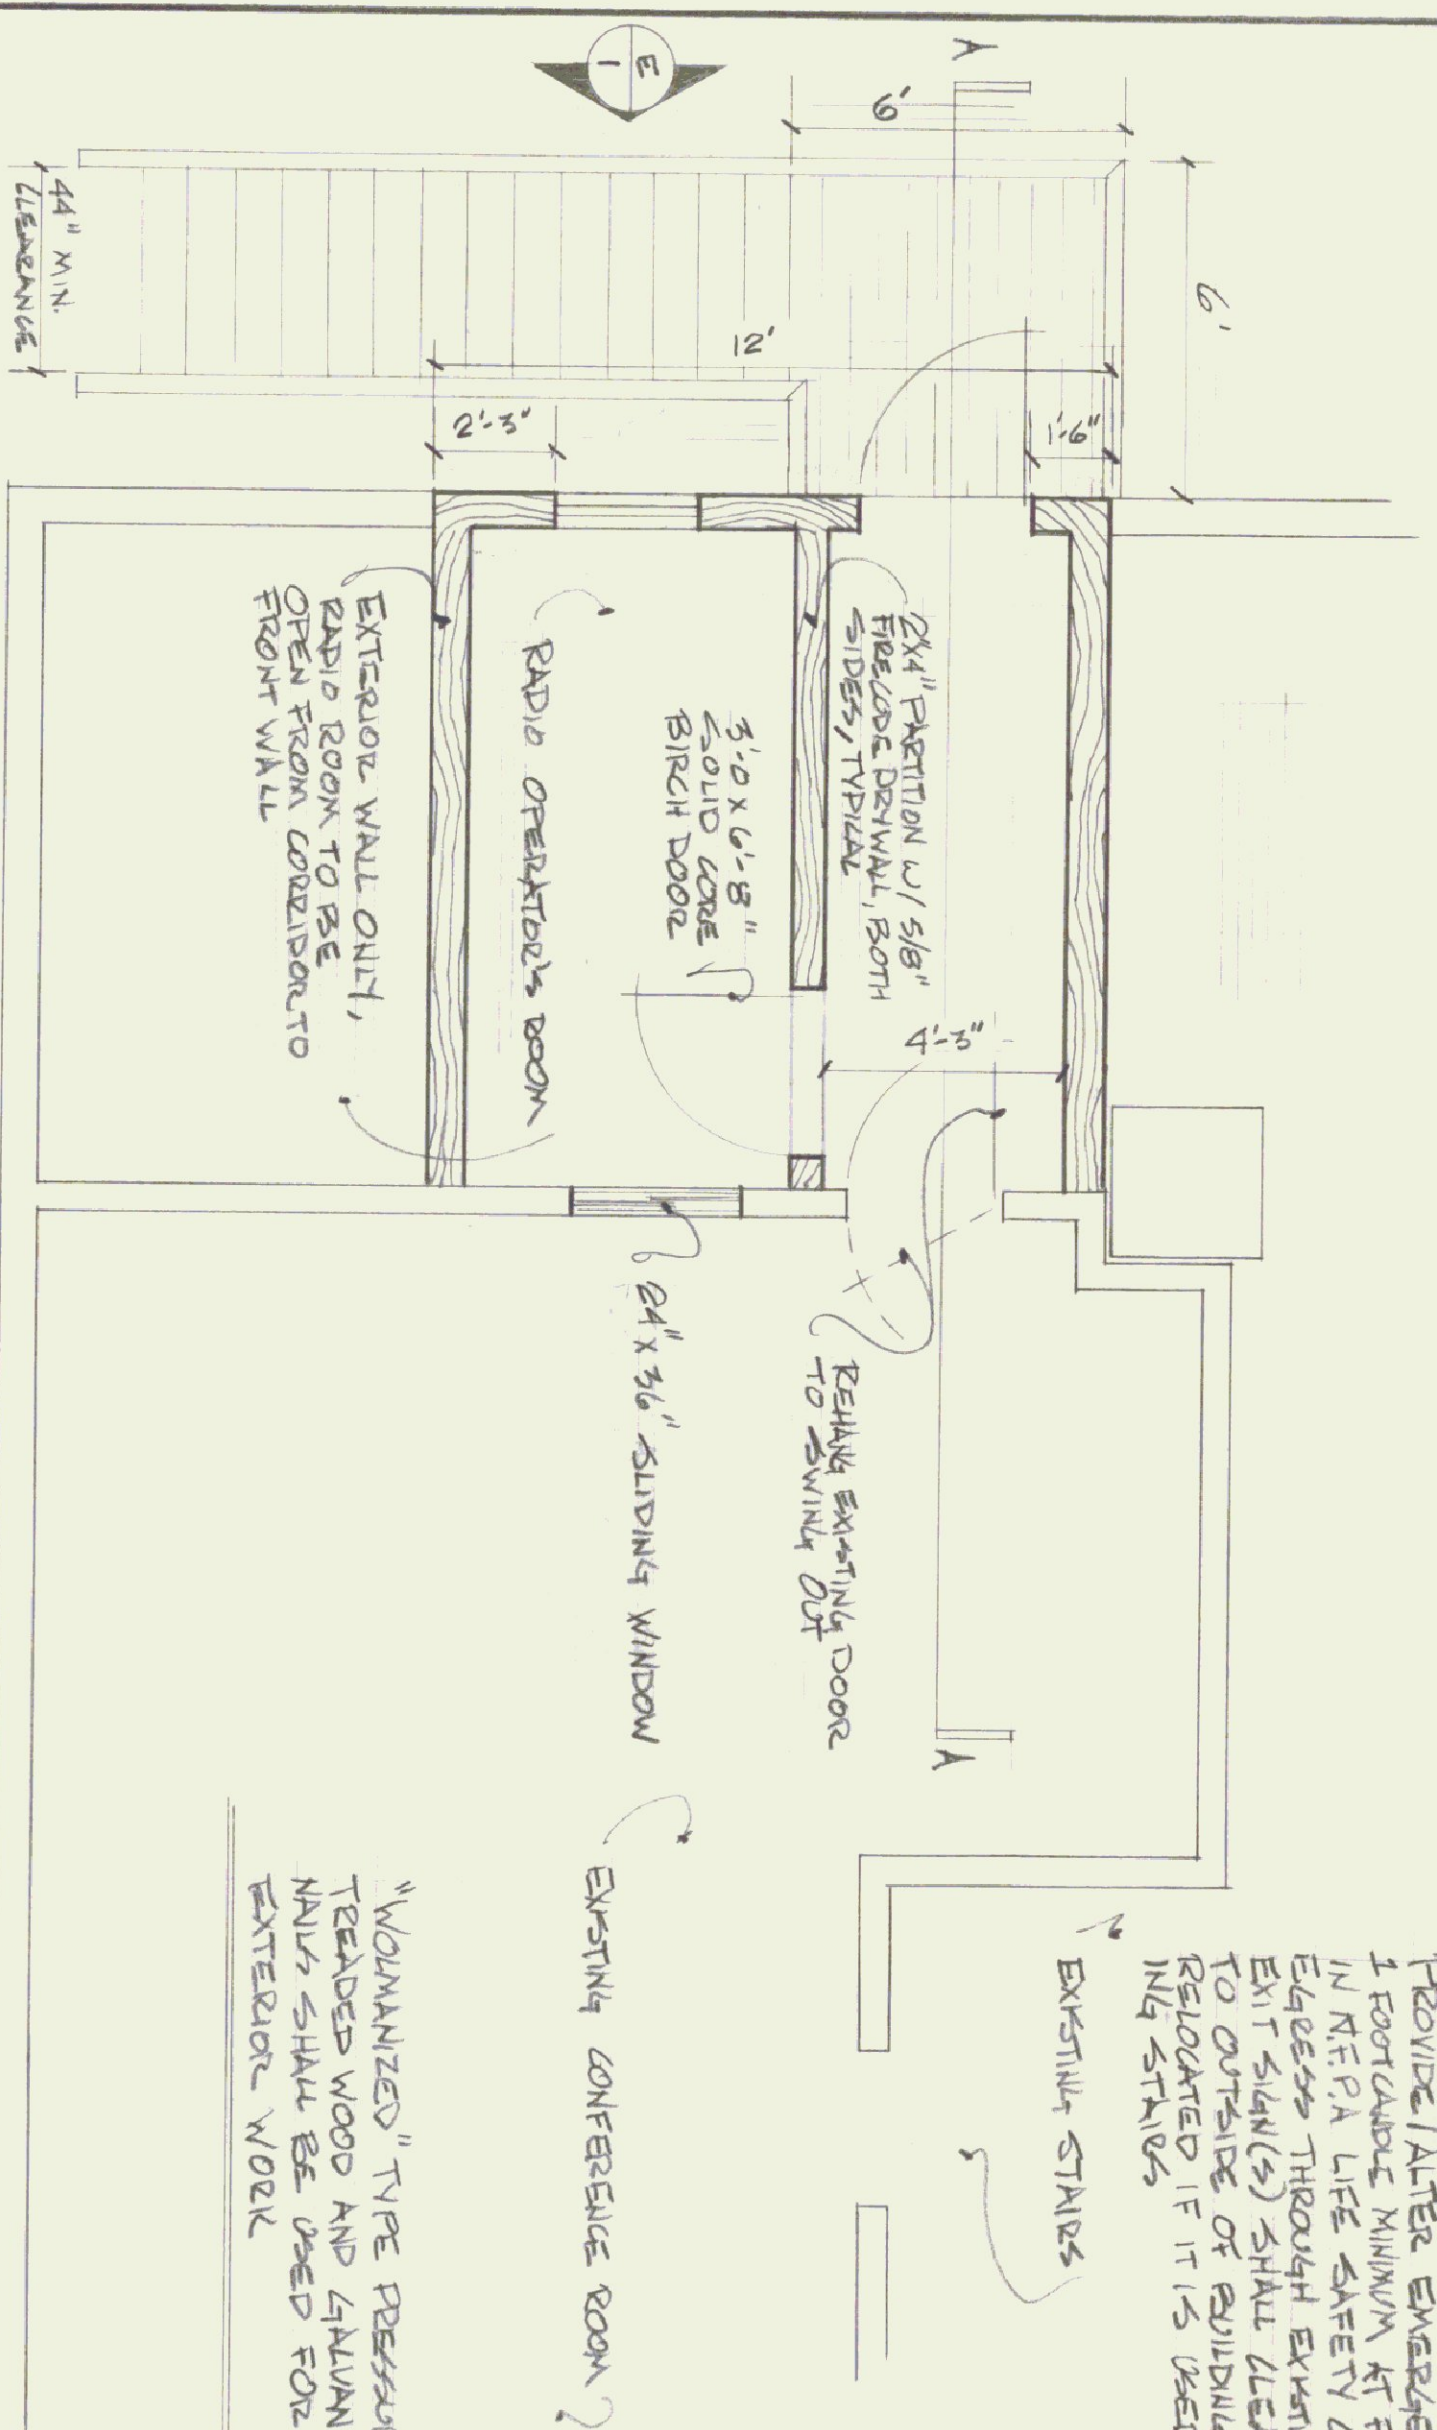


PROVIDE/ALTER EMERGENCY LIGHTING TO PROVIDE 1 FOOT CANDLE MINIMUM AT FLOOR LEVEL AS SPECIFIED IN NFPA LIFE SAFETY CODE. ALTERNATE MEANS OF EGRESS THROUGH EXISTING STAIRS, ILLUMINATED EXIT SIGN(S) SHALL CLEARLY MARK PATH OF EGRESS TO OUTSIDE OF BUILDING. BATTERY BACK MAY BE REPLACED IF IT IS USED FOR LIGHTING OF EXISTING STAIRS.

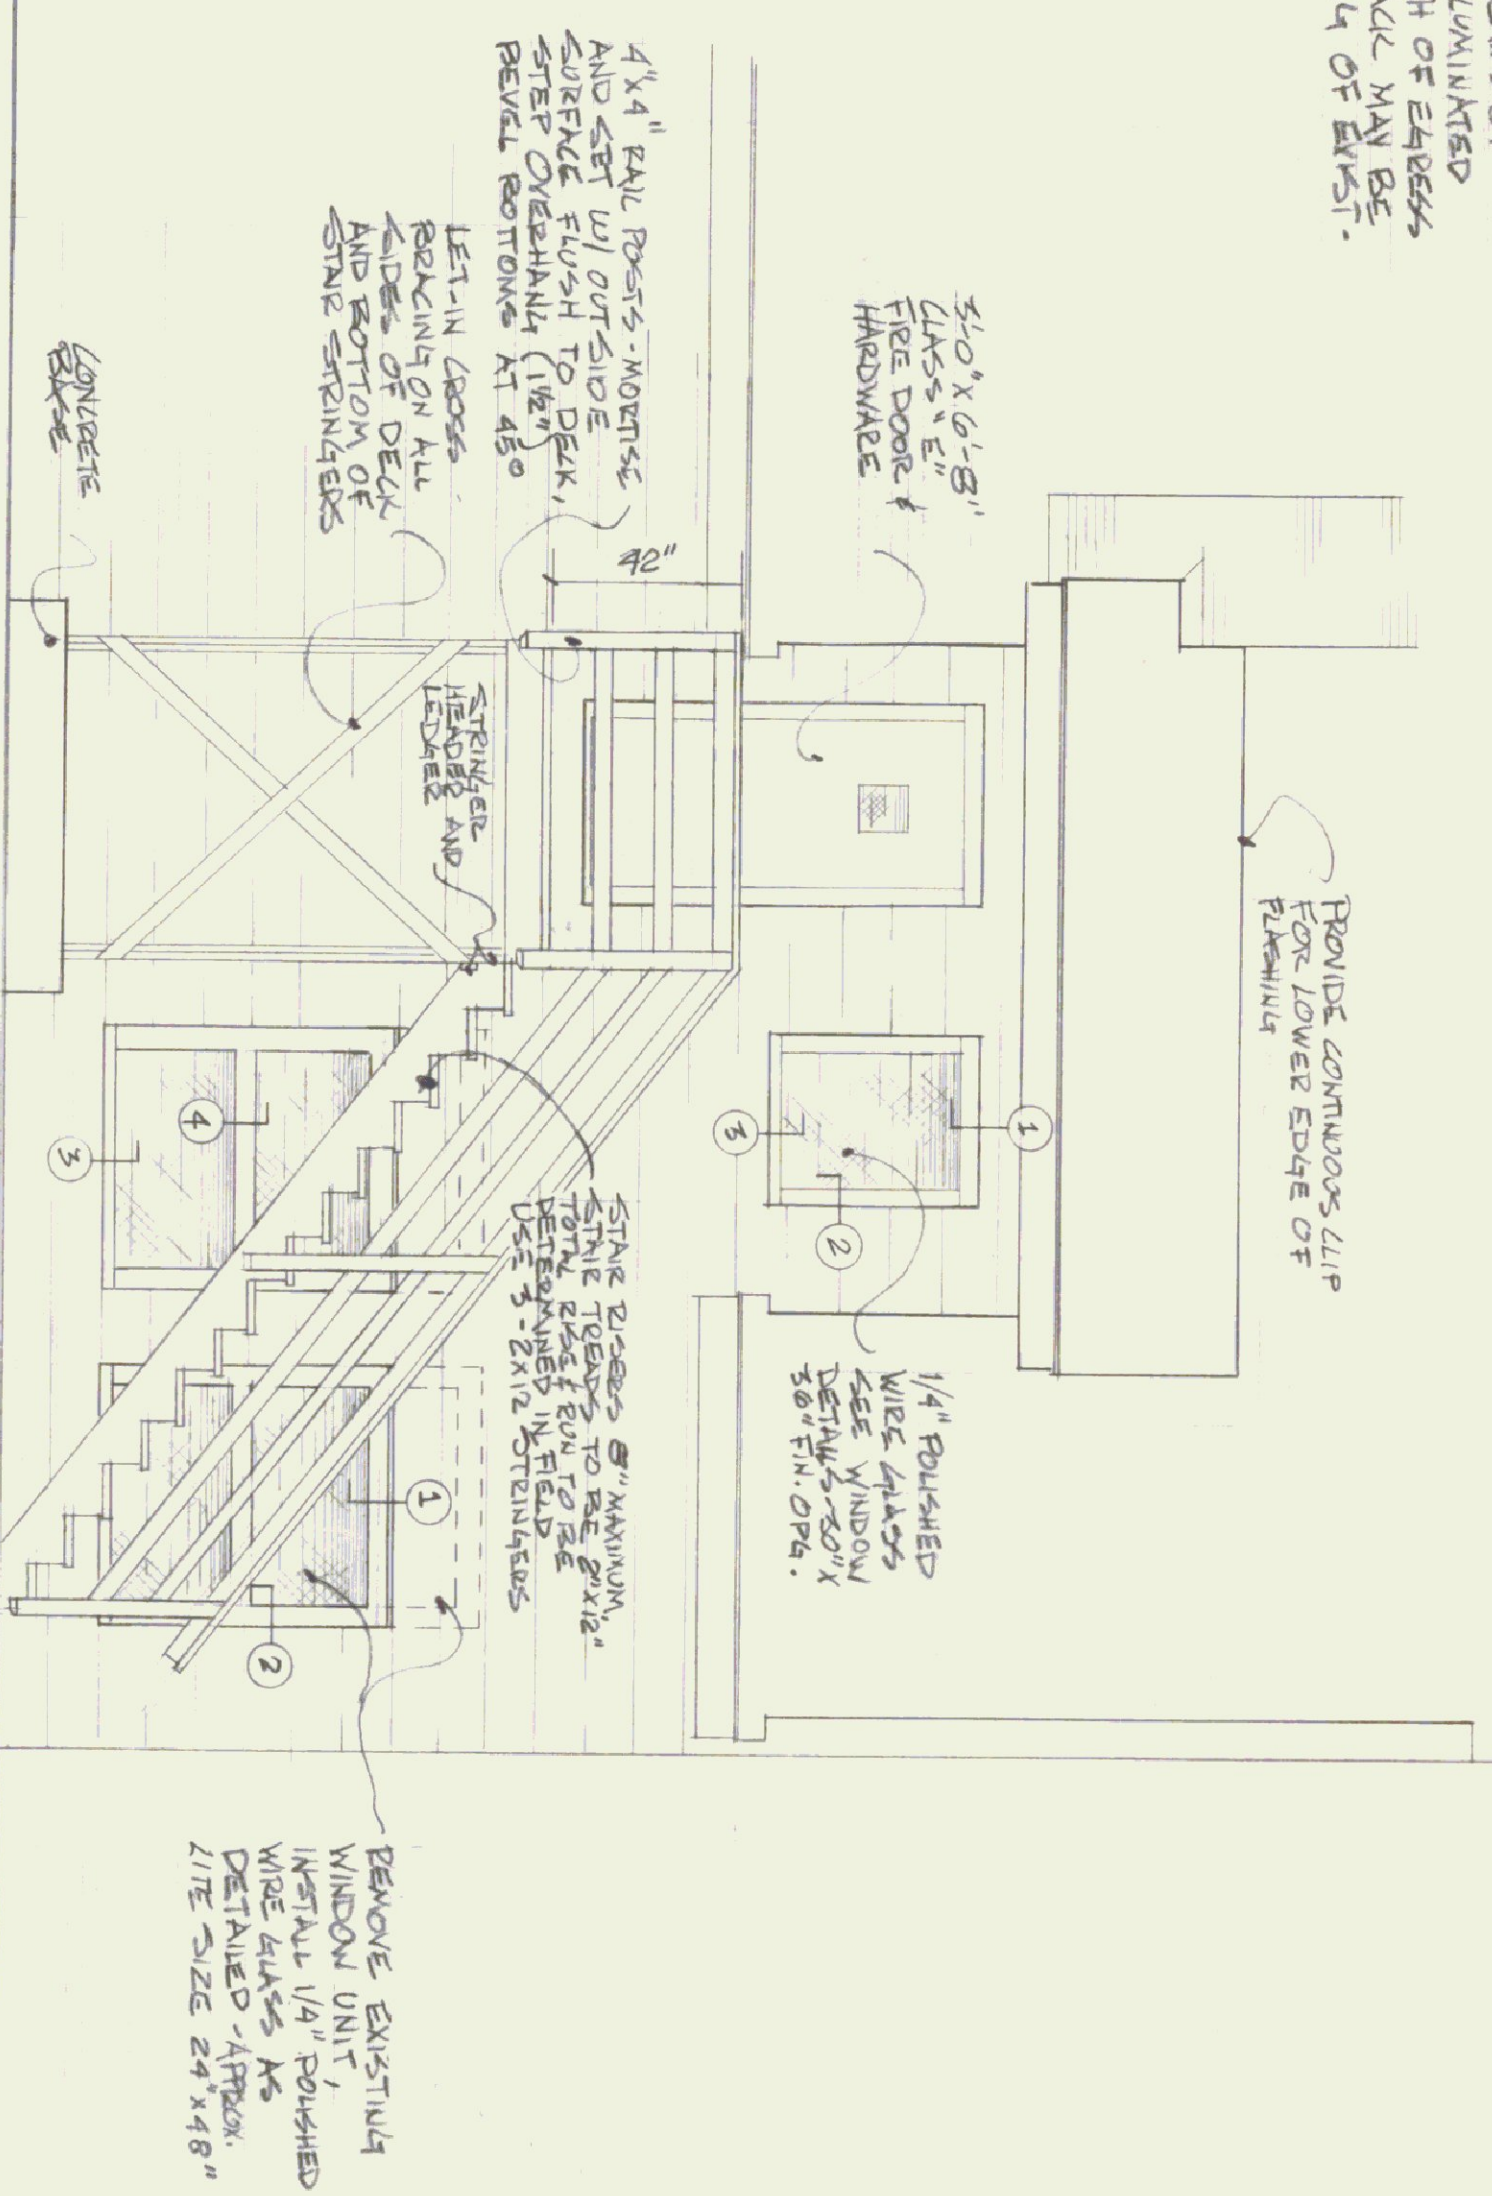


FLOOR PLAN  $1/4" = 1'-0"$

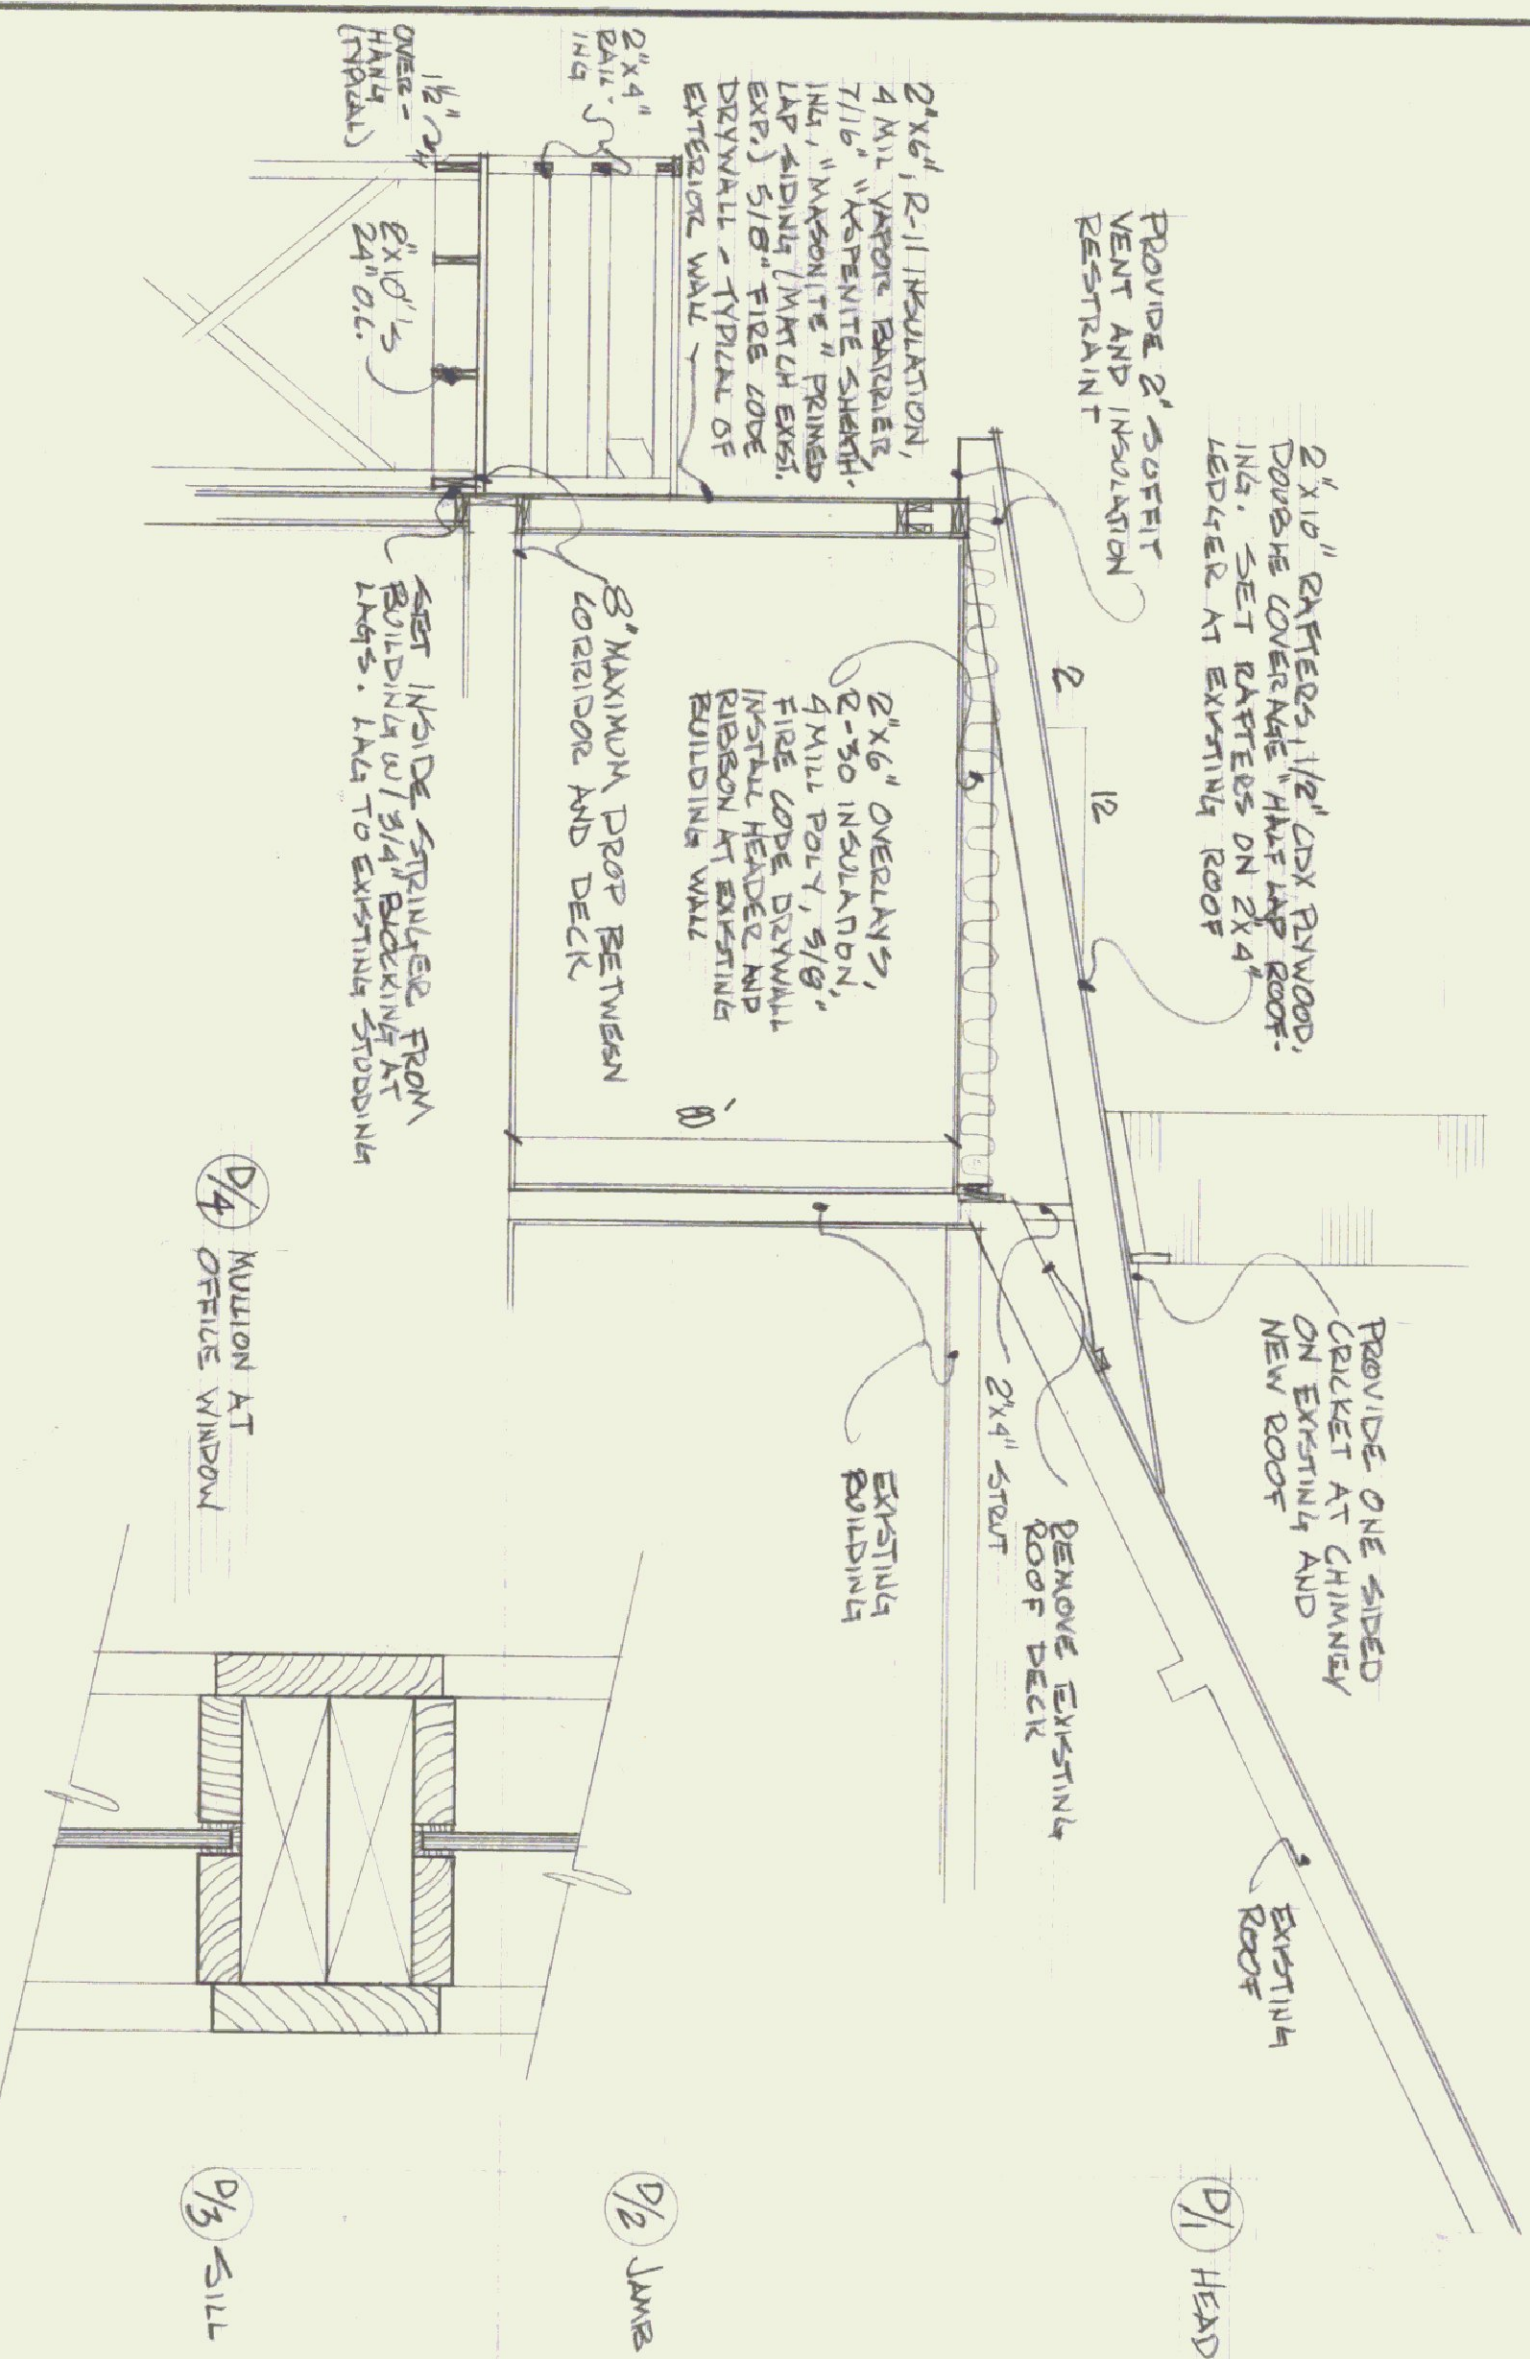


SECTION "A-A" 1/4"=1'-0"

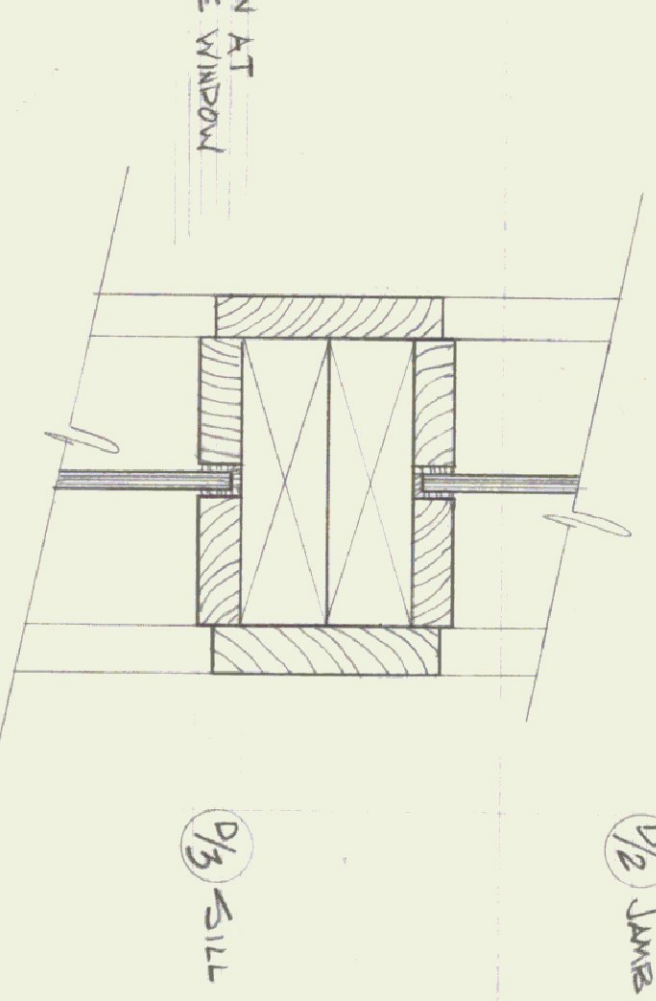

## TYPICAL WINDOW DETAILS

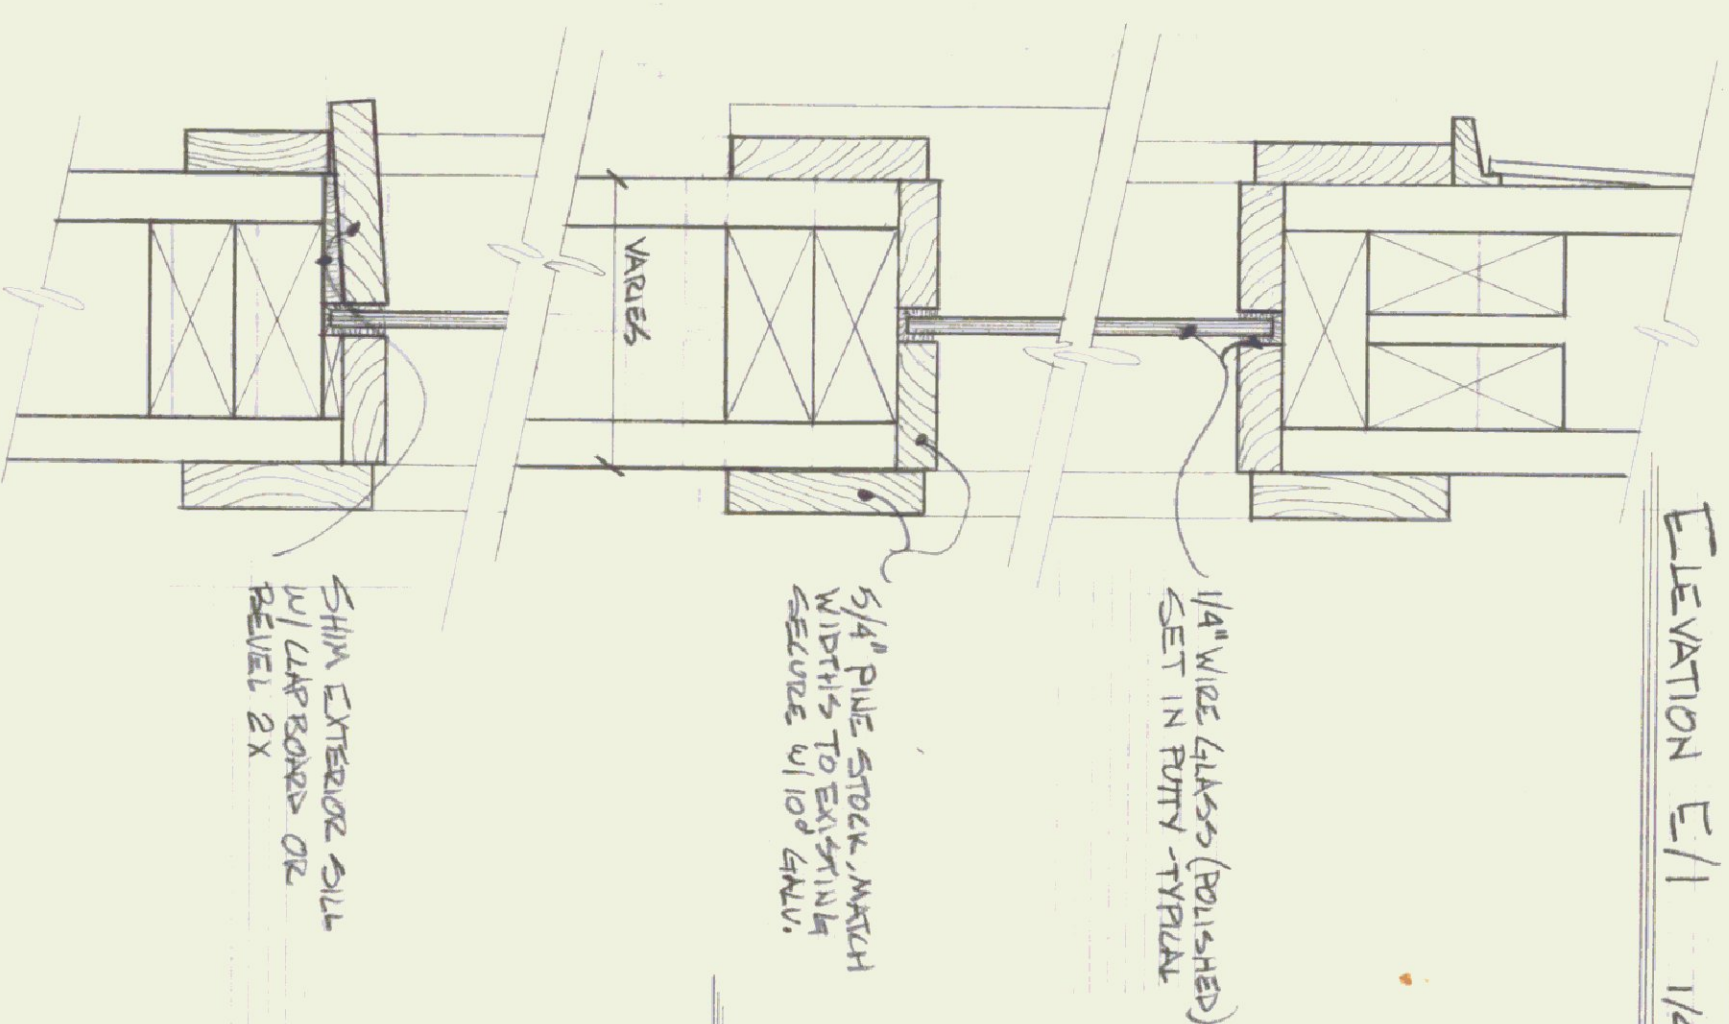

ELEVATION E/1 1/4"±1'-0"

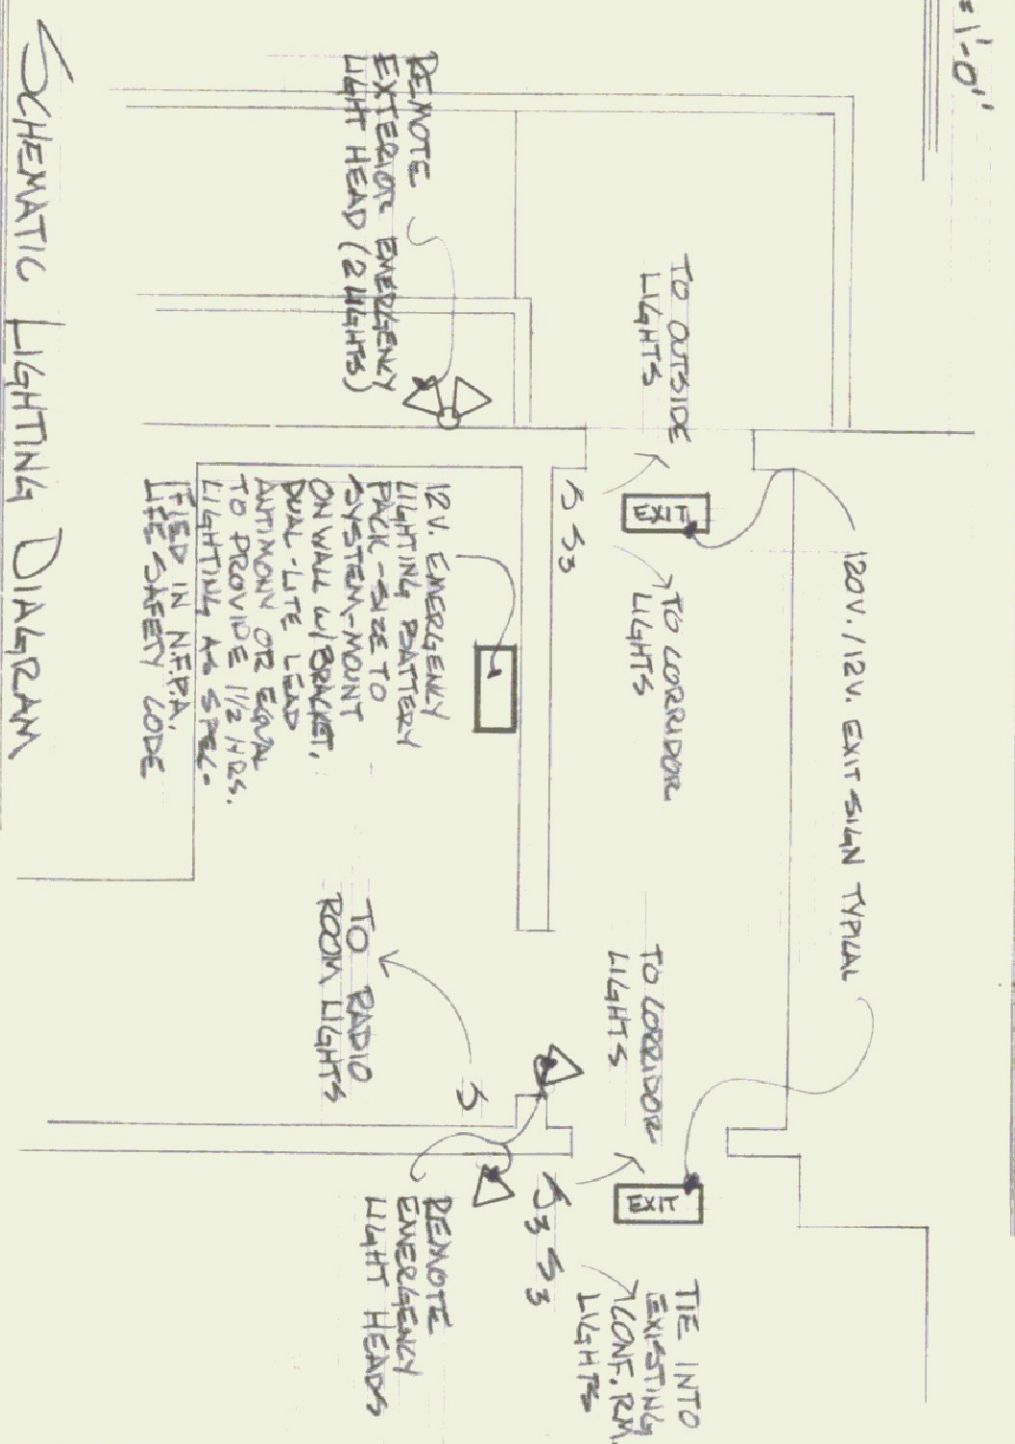

## SCHEMATIC LIGHTING DIAGRAM

|                                                                                                         |                                                                                                                                   |
|---------------------------------------------------------------------------------------------------------|-----------------------------------------------------------------------------------------------------------------------------------|
| STATE OF VERMONT<br>DIVISION OF STATE BUILDINGS<br>AGENCY OF ADMINISTRATION<br>MONTPELIER, VERMONT      |                                                                                                                                   |
| RENOVATIONS TO PROVIDE SECOND FLOOR FIRE EXIT<br>A.O.T. DISTRICT OFFICE BUILDING<br>BRATTLEBORO VERMONT | DATE: Nov 10, 1981<br>SCALE: AS SHOWN<br>REVISIONS: 11/18/81<br>DWG. NO. 1<br>DRAWN BY: HANSON<br>APPROVED BY: E. Pratt<br>1 OF 1 |