


REFLECTED CEILING PLAN

NOTES: 1. SHADDED PANELS INDICATE RECESSED LIGHT FIXTURES.
 2. ALL MAIN PANELS TO BE 1'x4'.
 3. ALL MAIN PANELS TO BE 1'x4'.
 4. SPECIAL PANELS AT EDGES AS INDICATED.
 5. ACTUAL LAYOUT MAY VARY DUE TO JOB CONDITIONS.

BRANCH CIRCUIT SCHEDULE

No.	BRANCH	PHASE	COMM. LOAD	H.P.	EQUIPMENT	WIRING
1	BEVERLY	1	20	1	RECEPTACLES	2-12
2	FIXTURES	1	20	1	RECEPTACLES	2-12
3	FIXTURES	1	20	1	RECEPTACLES	2-12
4	FIXTURES	1	20	1	RECEPTACLES	2-12
100	FIXTURES	1	20	1	RECEPTACLES	2-12

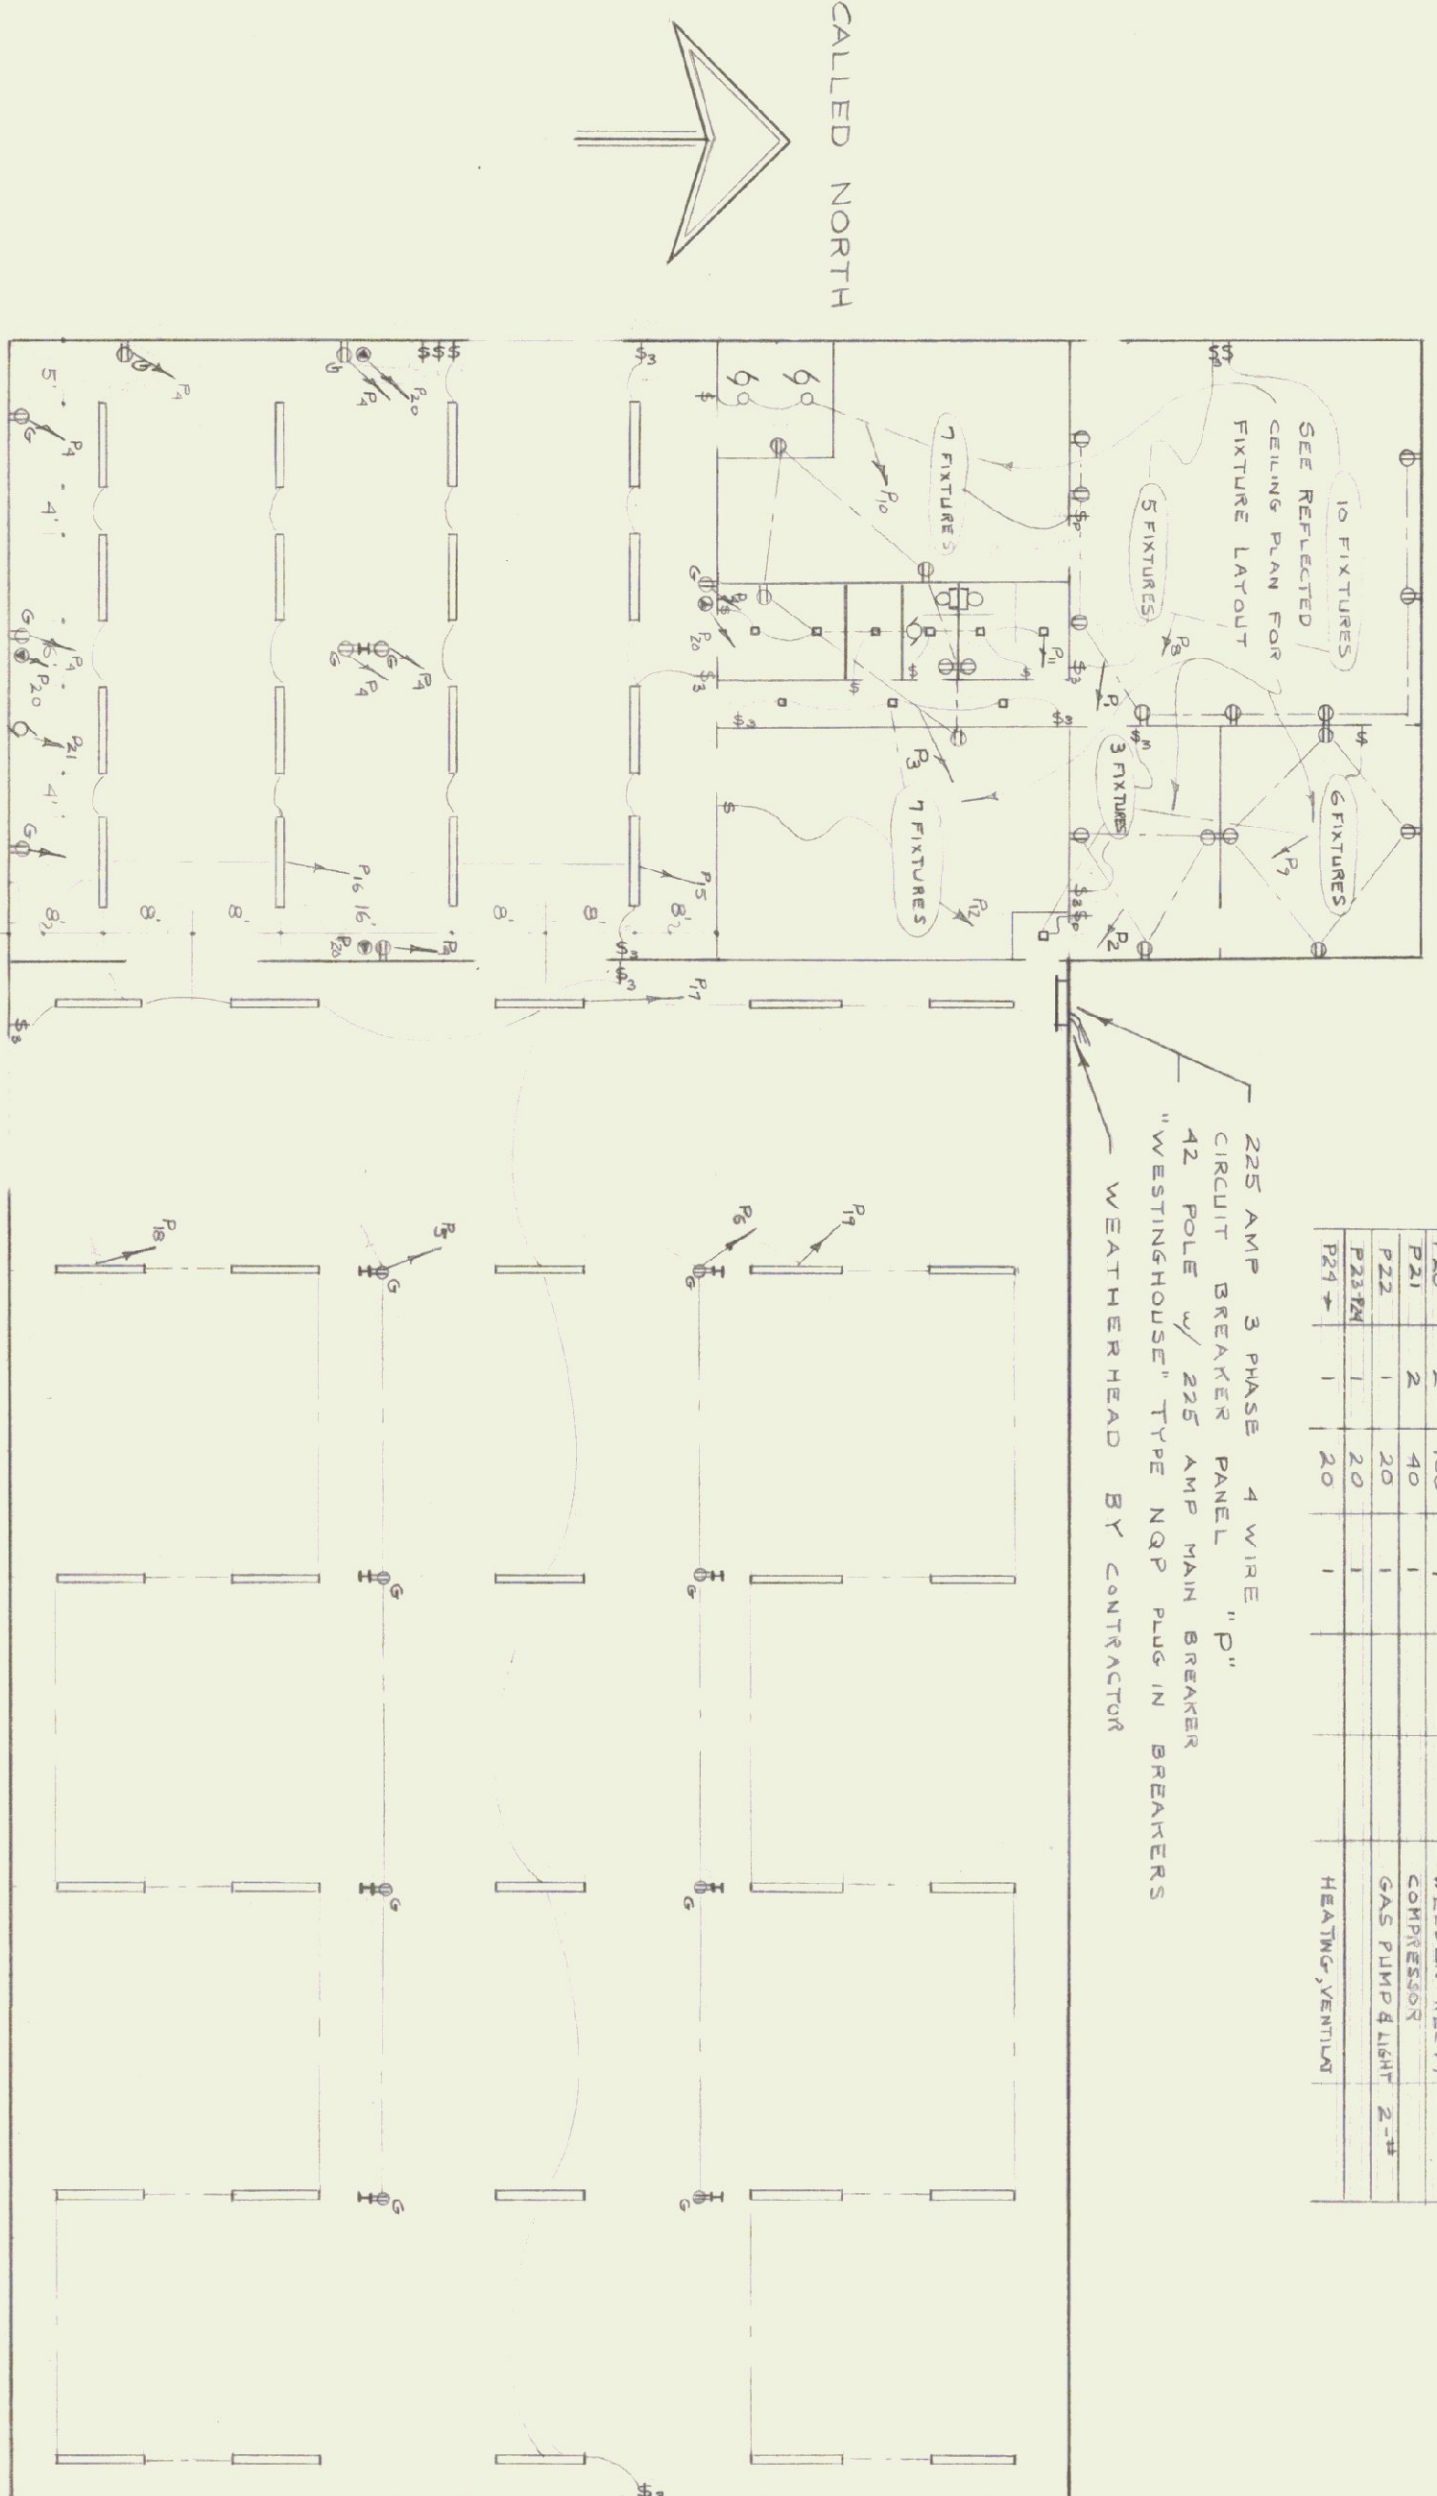


ELECTRICAL LAYOUT

LEGEND:

- ⊕ DUREX RECEPT w/ GROUND
- ⊙ DUREX RECEPT
- ⊕ RECEPT FOR WELDER
- ⊕ SINGLE POLE SWITCH w/ PILOT
- ⊕ SWITCH, 3 WAY
- ⊕ MOTOR


FIXTURE SCHEDULE:

- PRELUMINAIRE, No. C-668, CUBIC, SURFACE MOUNT
- PASS & SEPHOR, No. 44, PANEL HOLDER
- SMITHCRAFT, "TECH" FOR MANS-STRAT BR-10N LAMPS (40W)
- TEC-2-725 FOR 4F40T12RS LAMPS, B' HOUSING
- SMITHCRAFT, "TRIPPER" ACAPTES, PLASTIC - SERIES SP
- ICP-2-40 FOR 2F40T12RS LAMPS FOR EXPOSED INVERTED T SYSTEMS

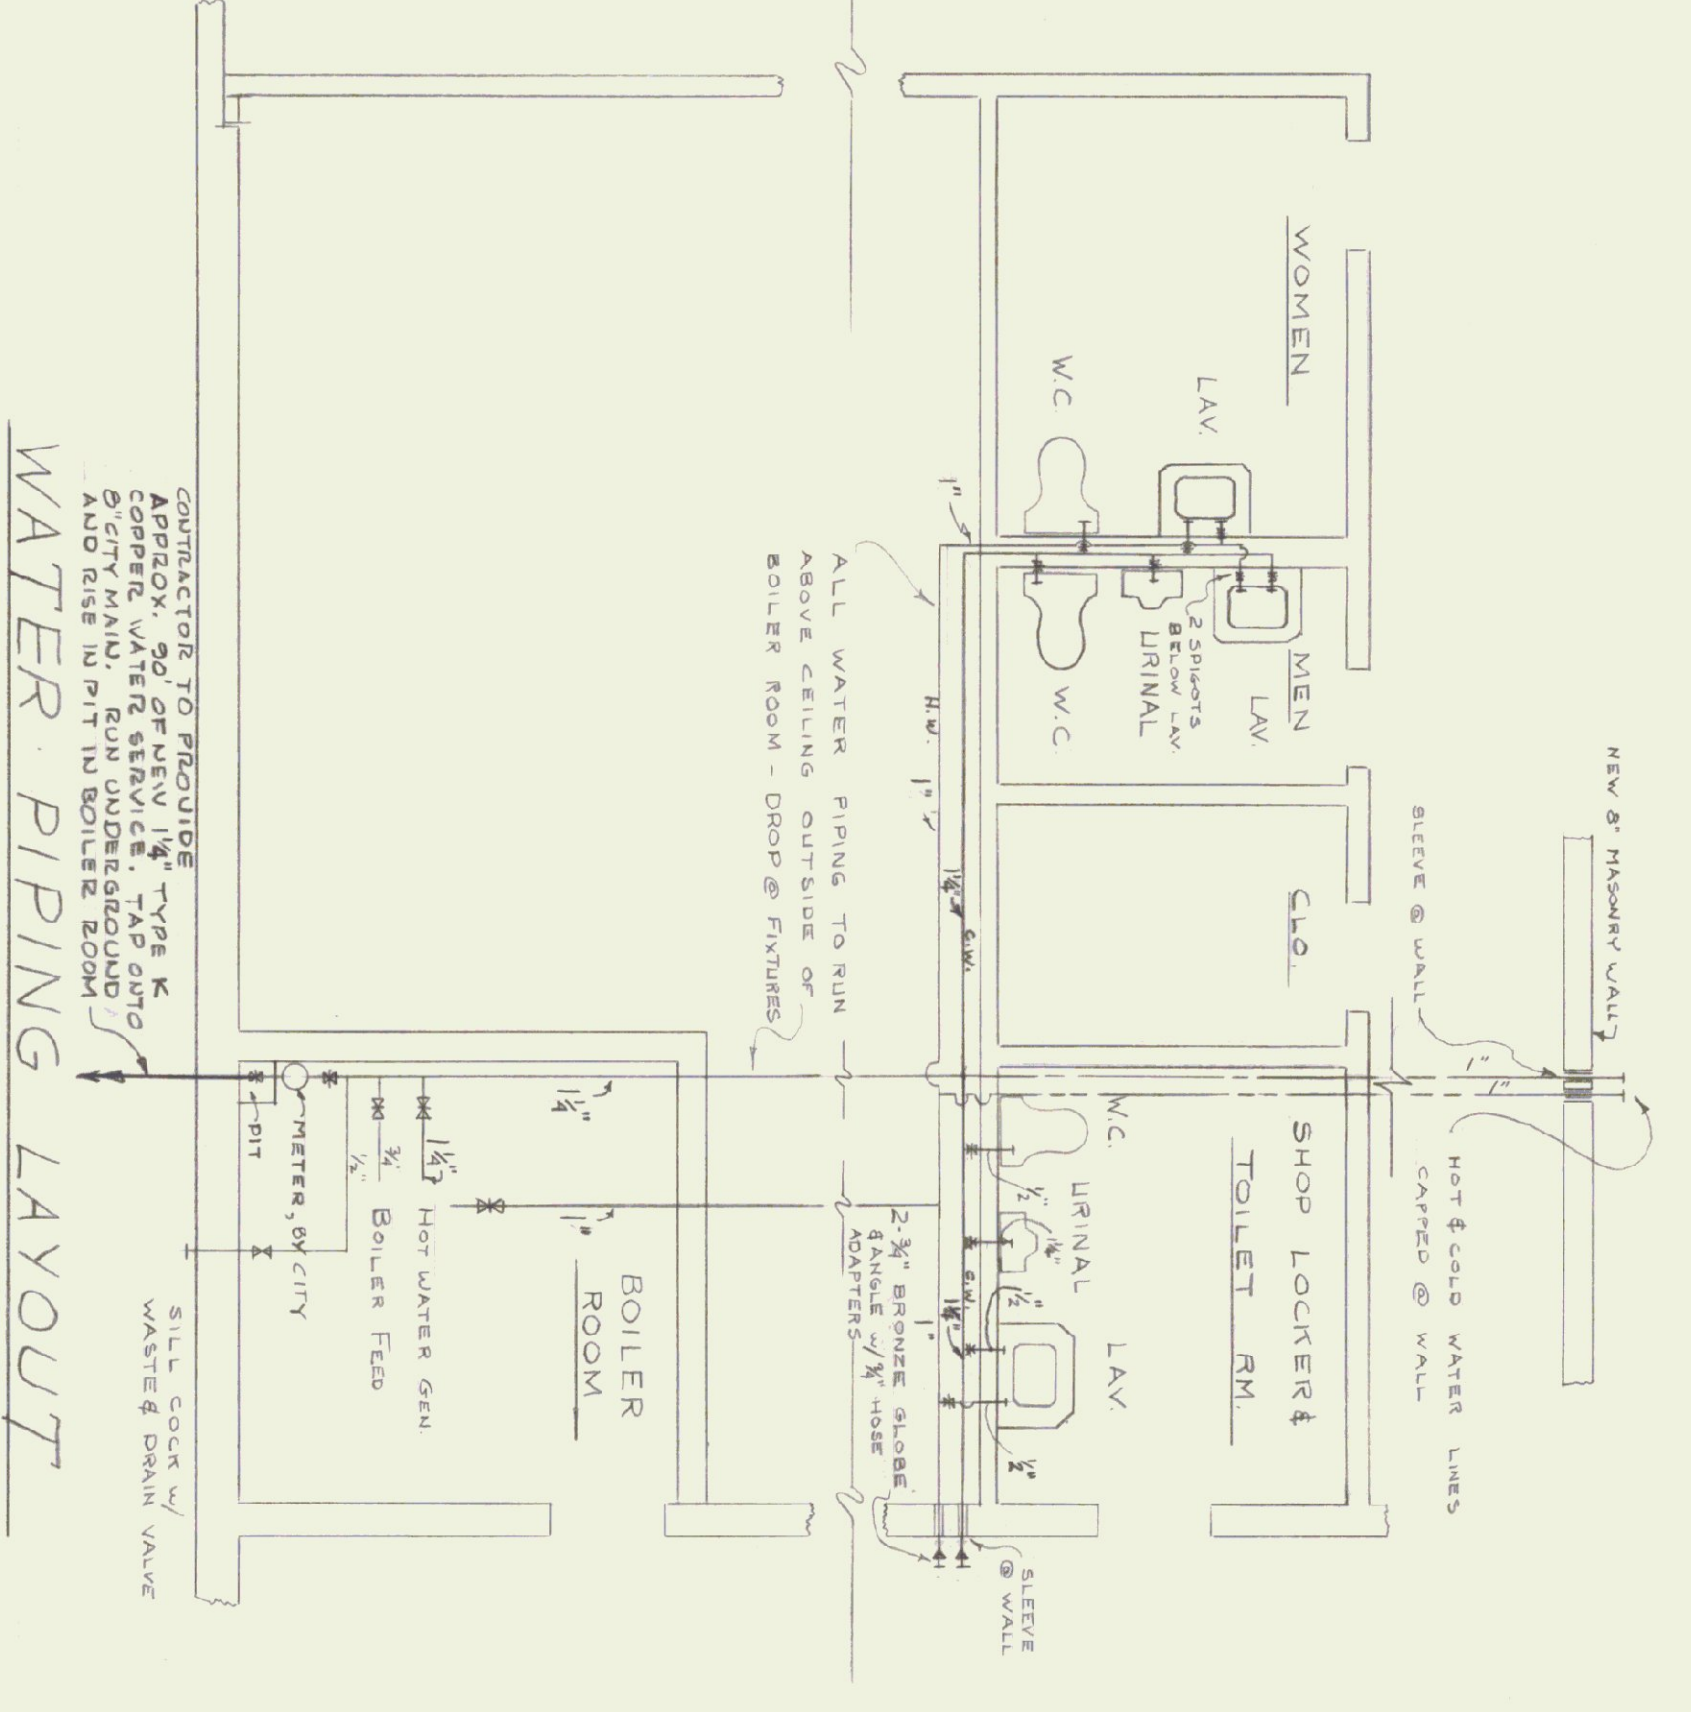

WATER PIPING LAYOUT

CONTRACTOR TO PROVIDE APPROX. 90' OF NEW 1 1/2" TYPE K COPPER WATER SERVICE, TAP OFF TO BOILER ROOM. ALSO TO BE IN PIT IN BOILER ROOM.

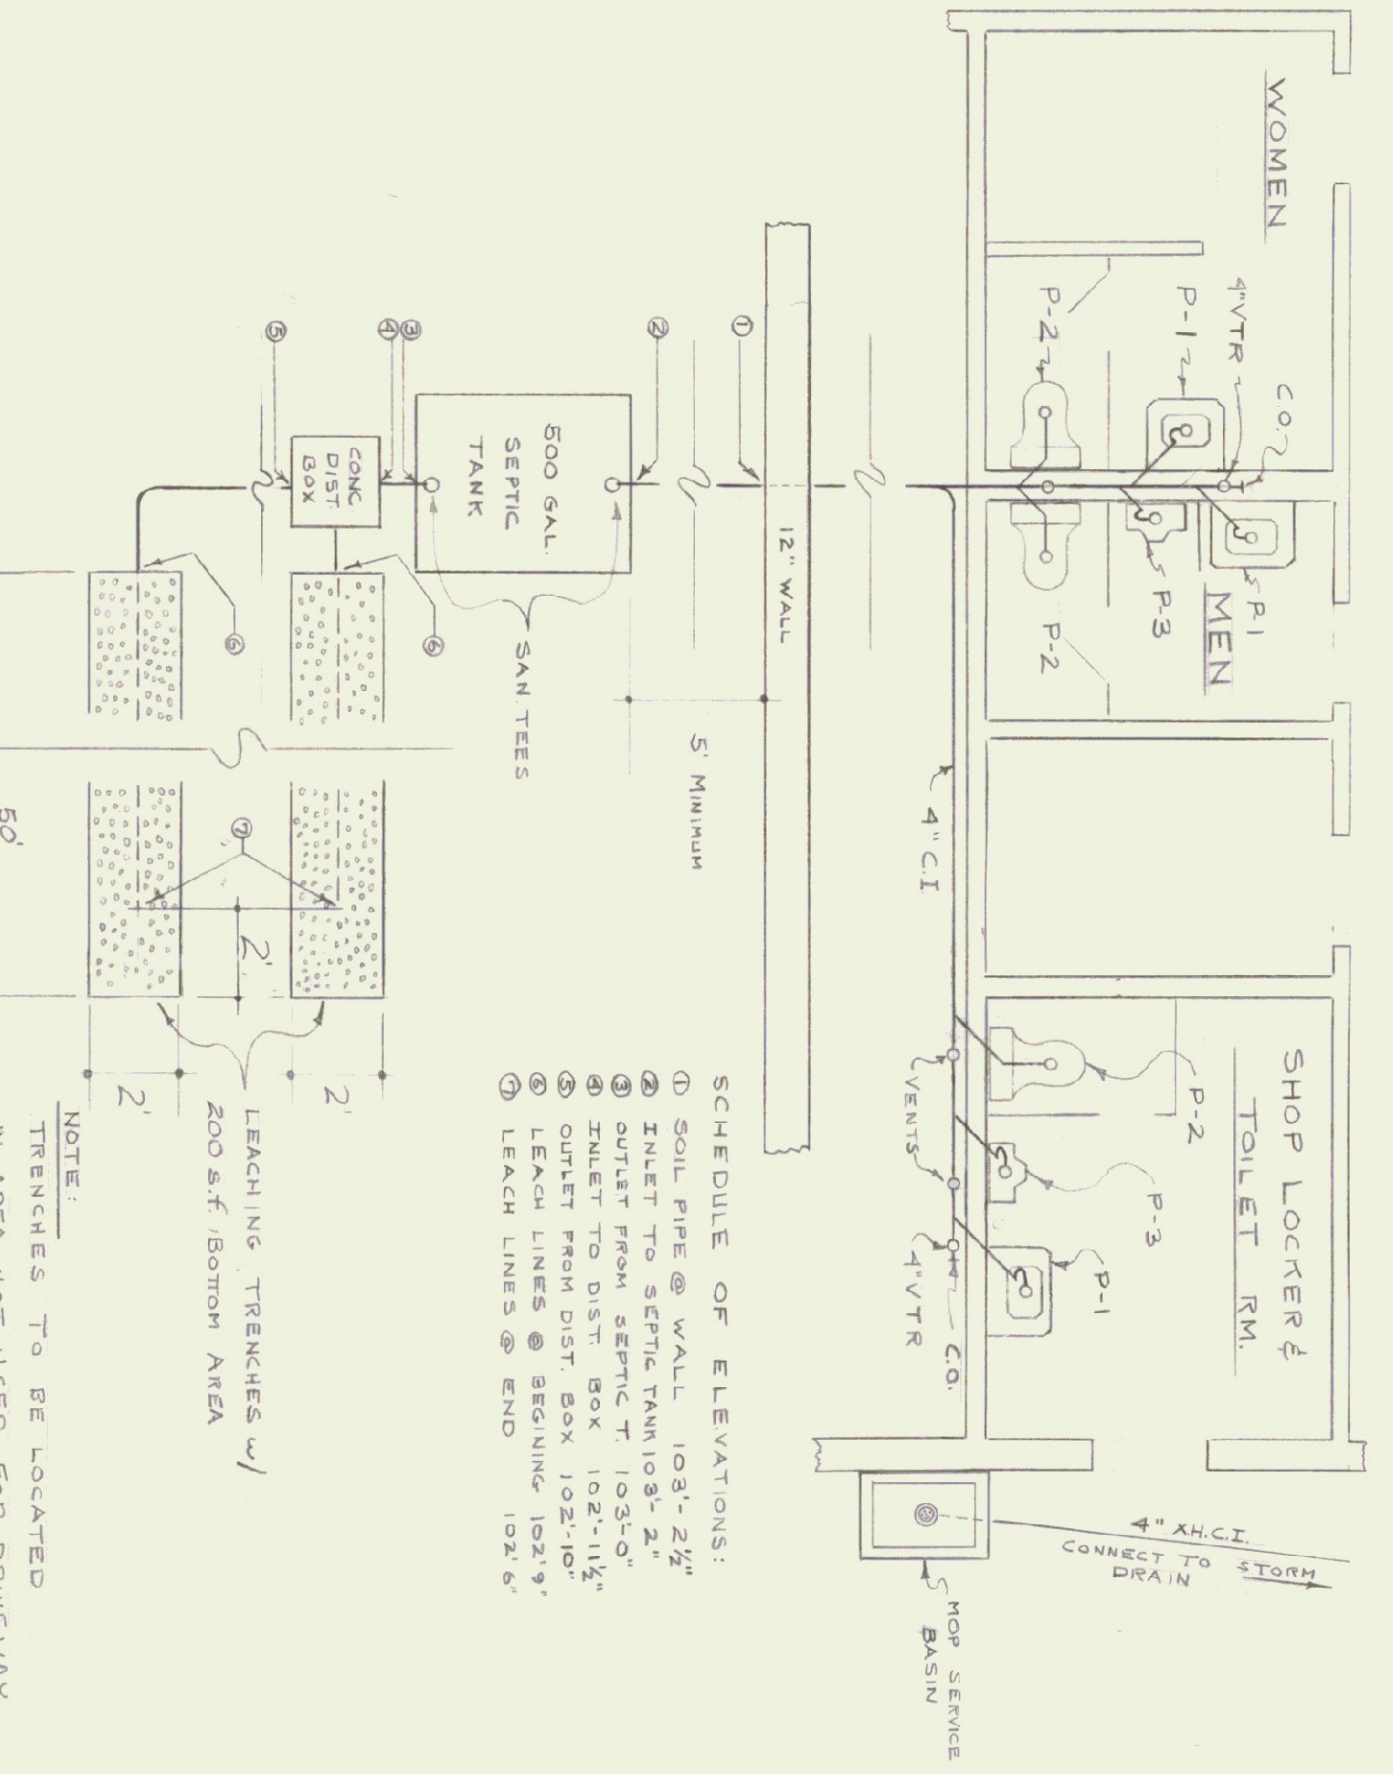


SANITARY PLUMBING LAYOUT

SCHEDULE OF ELEVATIONS:

- SOIL PIPE @ WALL 108'-2 1/2"
- INLET TO SEPTIC TANK 108'-2 1/2"
- INLET TO DIST. BOX 102'-11 1/2"
- OUTLET FROM DIST. BOX 102'-10"
- LEACH LINES @ BEGINNING 102'-9"
- LEACH LINES @ END 102'-6"


NOTE: TRENCHES TO BE LOCATED IN AREA NOT USED FOR DRIVEWAY

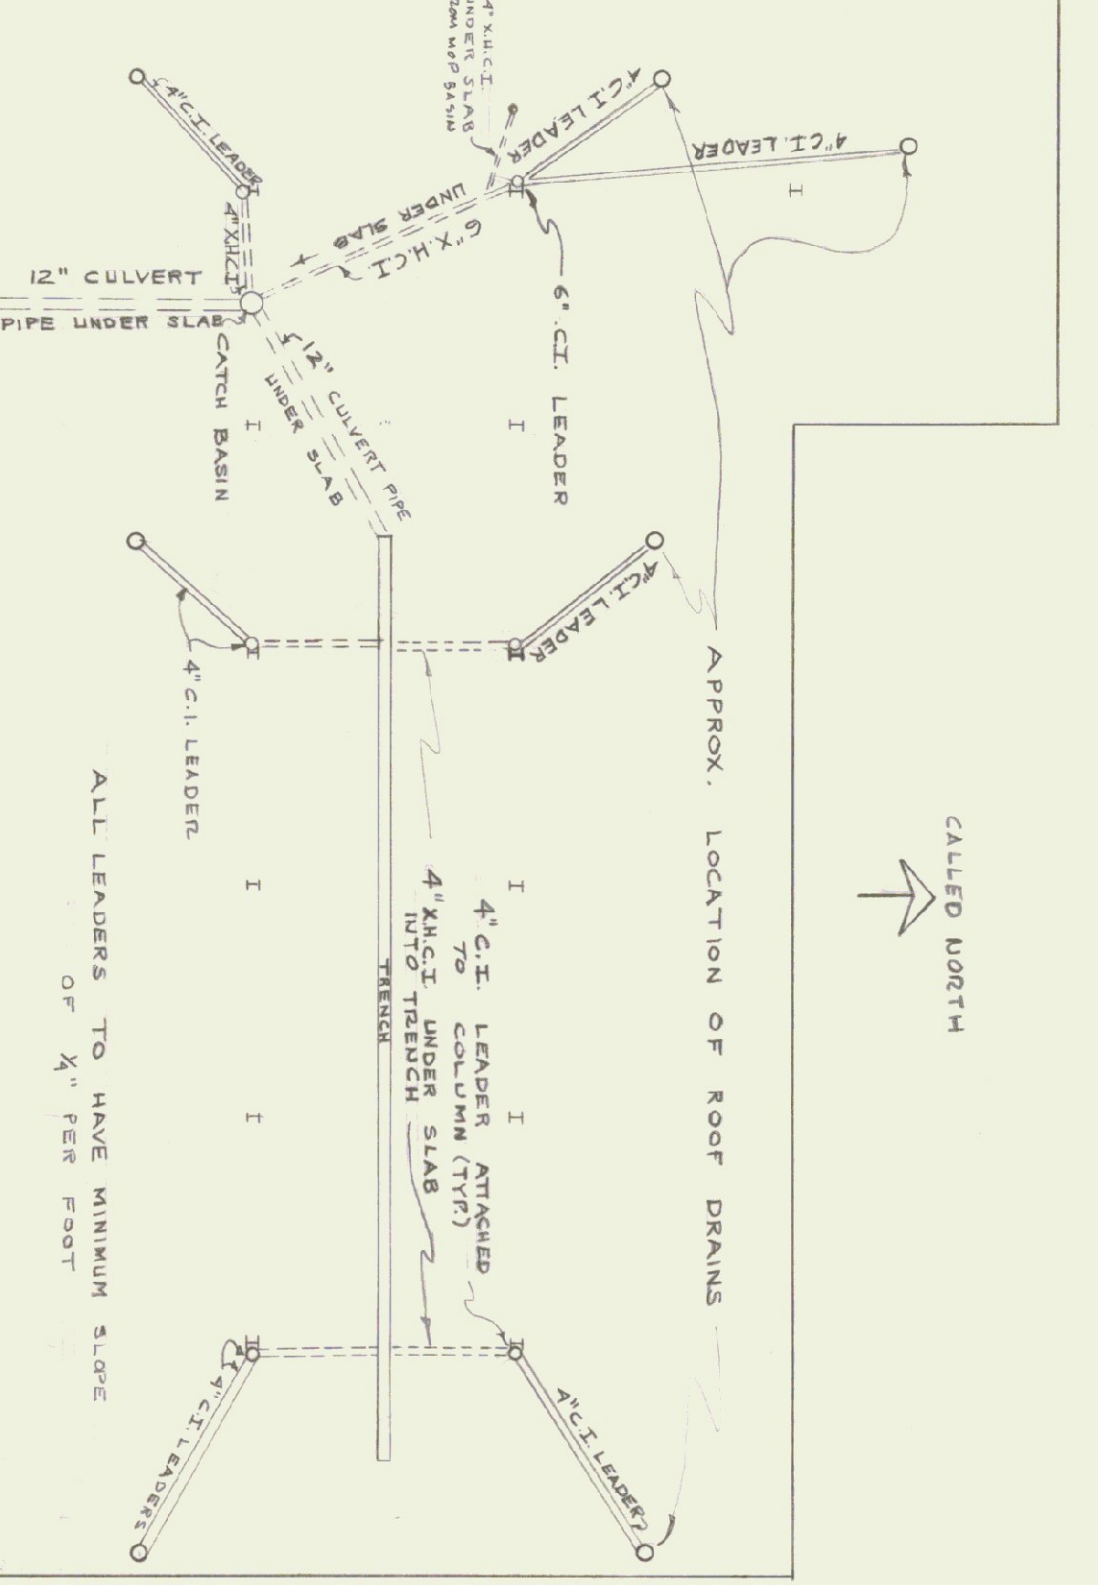

ROOF DRAIN & LEADER PLAN

APPROX. LOCATION OF ROOF DRAINS

ALL LEADERS TO HAVE MINIMUM SLOPE OF 1/4" PER FOOT

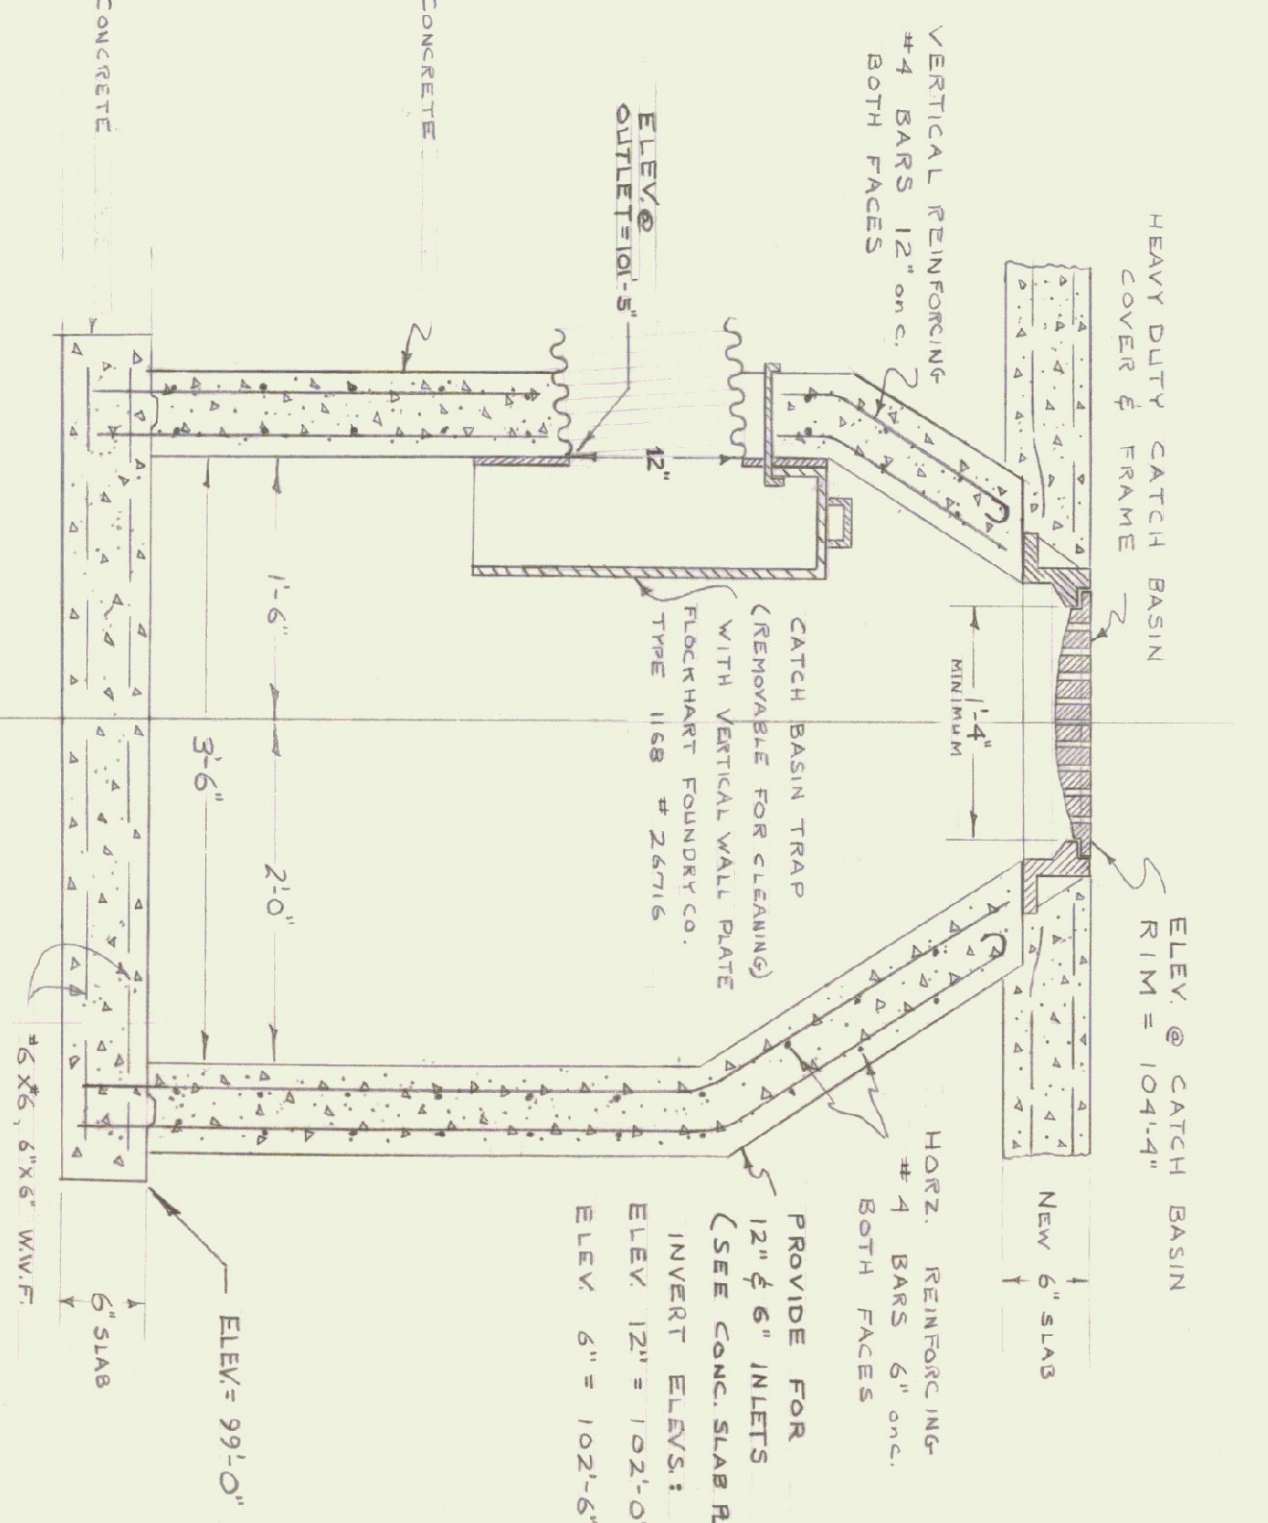

CROSS SECTION - CATCH BASIN

SCALE: 1" = 1'-0"

DISTRICT #1 GARAGE AND OFFICE BUILDING
 VERMONT DEPT. OF HIGHWAYS
 BENNINGTON, VERMONT
 DATE: MAY 12, 1965
 DRAWN BY: R.A. H. MONTPELLIER, VERMONT
 STATE BUILDINGS DIVISION
 DEPT. OF ADMINISTRATION
 DRAWING NO. 3