


X:\031201-bennindrawings\Plumb\031201P01.dwg, P.1, 09/02/2003 11:48:45 AM, © LANE ASSOCIATES CONSULTING ENGINEERS P.C. 2003

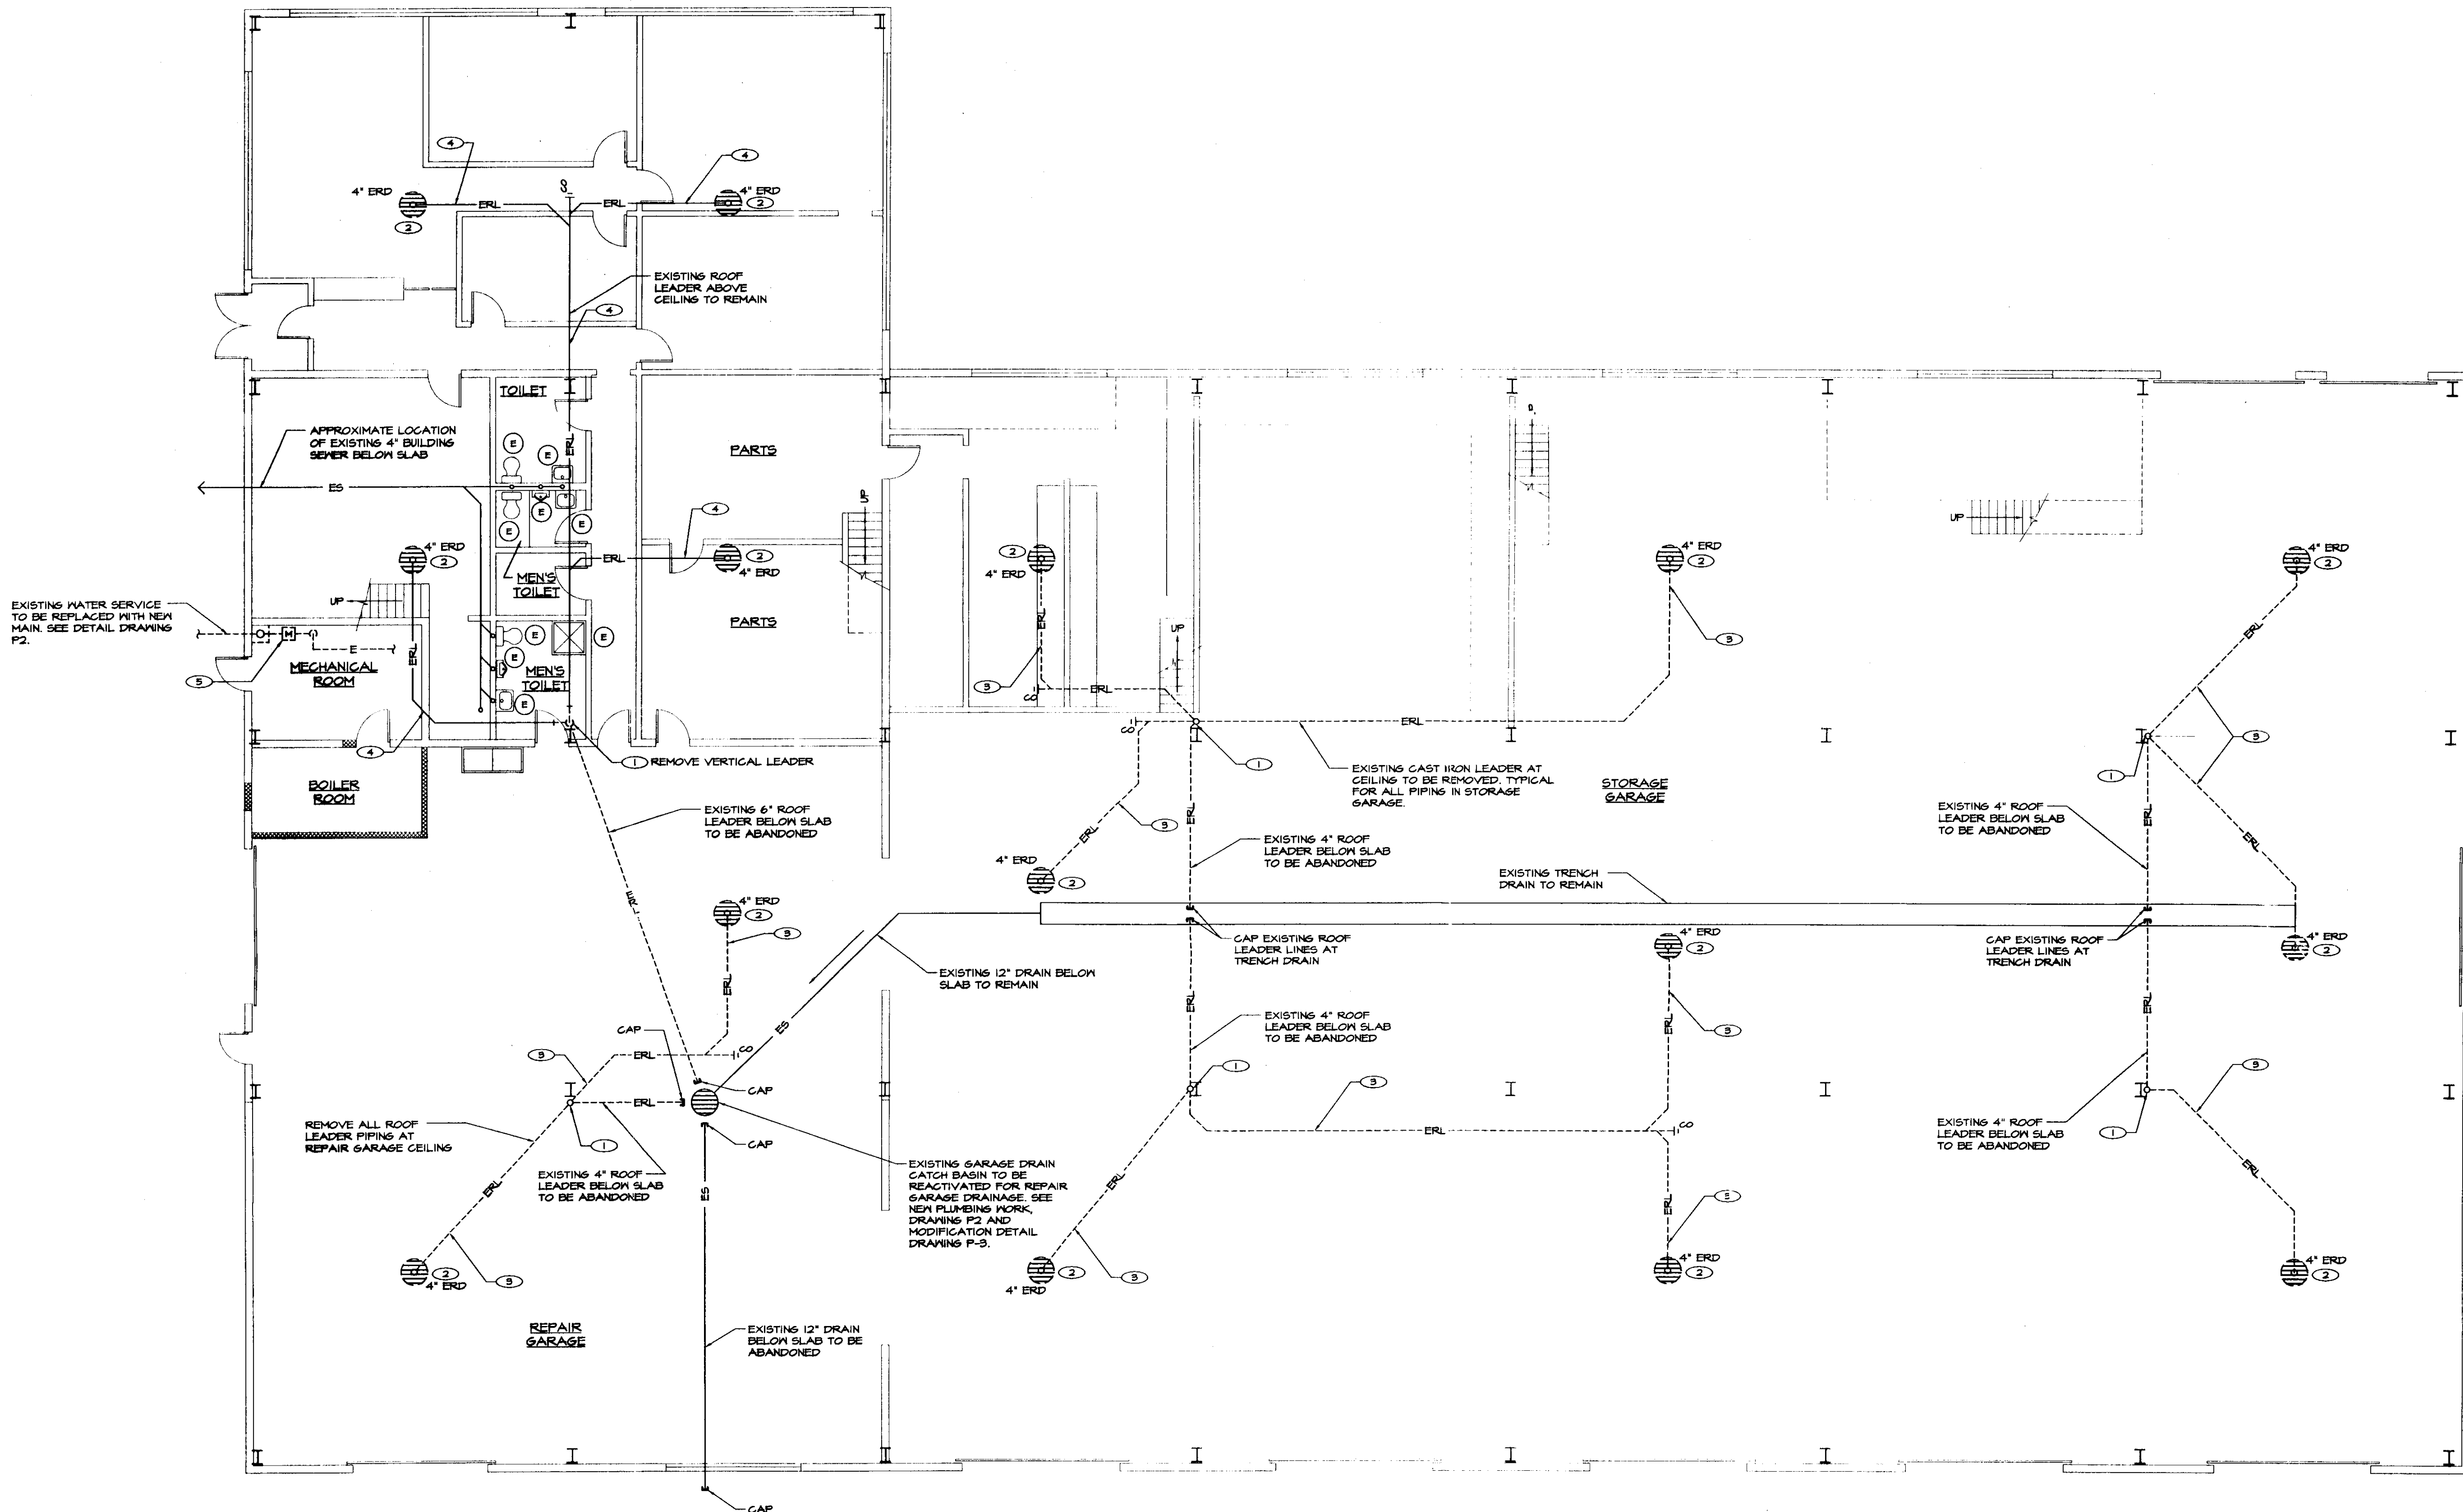


**FIRST FLOOR PLAN - PLUMBING DEMOLITION**  
SCALE: 1/8"=1'-0"

**DEMOLITION NOTES:** (APPLY TO THIS DRAWING ONLY)

- ① CAP EXISTING 4" ROOF LEADER AT FLOOR.
- ② EXISTING ROOF DRAIN TO REMAIN.
- ③ REMOVE EXISTING ROOF LEADER PIPING.
- ④ EXISTING ROOF LEADER TO REMAIN.
- ⑤ REMOVE EXISTING WATER SERVICE VALVES, METER, AND PIPING AS REQUIRED TO INSTALL NEW WATER SERVICE. SEE DRAWING P2 FOR NEW WORK REQUIRED.

**GENERAL NOTE:**

THE EXISTING CONDITIONS INDICATED ON THIS DRAWING ARE BASED ON FIELD OBSERVATIONS WHERE PIPING AND EQUIPMENT WERE ACCESSIBLE TO VIEW. WHERE LOCATED IN INACCESSIBLE LOCATIONS, THE LAYOUT HAS BASED ON STATE BUILDING DRAWINGS DATED MAY 12, 1965. THE CONTRACTOR SHALL FIELD VERIFY EXISTING CONDITIONS PRIOR TO CONSTRUCTION.

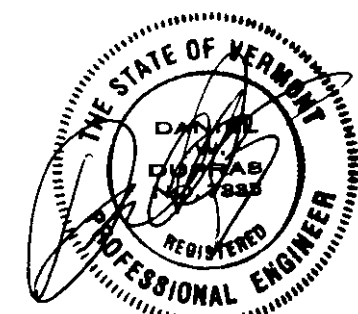

NO.	ISSUED FOR	DATE
1	BIDDING AND CONSTRUCTION	SEPT 1, 2003

**LANE ASSOCIATES**  
CONSULTING ENGINEERS, P.C.

HEATING, VENTILATION, & AIR CONDITIONING,  
PLUMBING, FIRE PROTECTION, & ELECTRICAL

CHARLES F. LANE, P.E.  
DANIEL W. DUPRAS, P.E.

51 KILLINGTON AVENUE,  
RUTLAND, VERMONT 05701  
TELEPHONE: (802)747-3346  
FAX/MODEM: (802)747-3356

<b>FIRST FLOOR PLAN - PLUMBING DEMOLITION</b>		<b>P 1</b>		
<b>BENNINGTON AOT GARAGE DRAINAGE AND UTILITY IMPROVEMENTS</b>				
APPR:	DVD	DRAWN: DVD/KPC	SCALE: AS NOTED	PROJ. NO. 0312-01