


X:\031201-benn\Drawings\Plumb\031201P02.dwg, P2, 09/02/2003 11:45:15 AM, © LANE ASSOCIATES CONSULTING ENGINEERS P.C. 2003

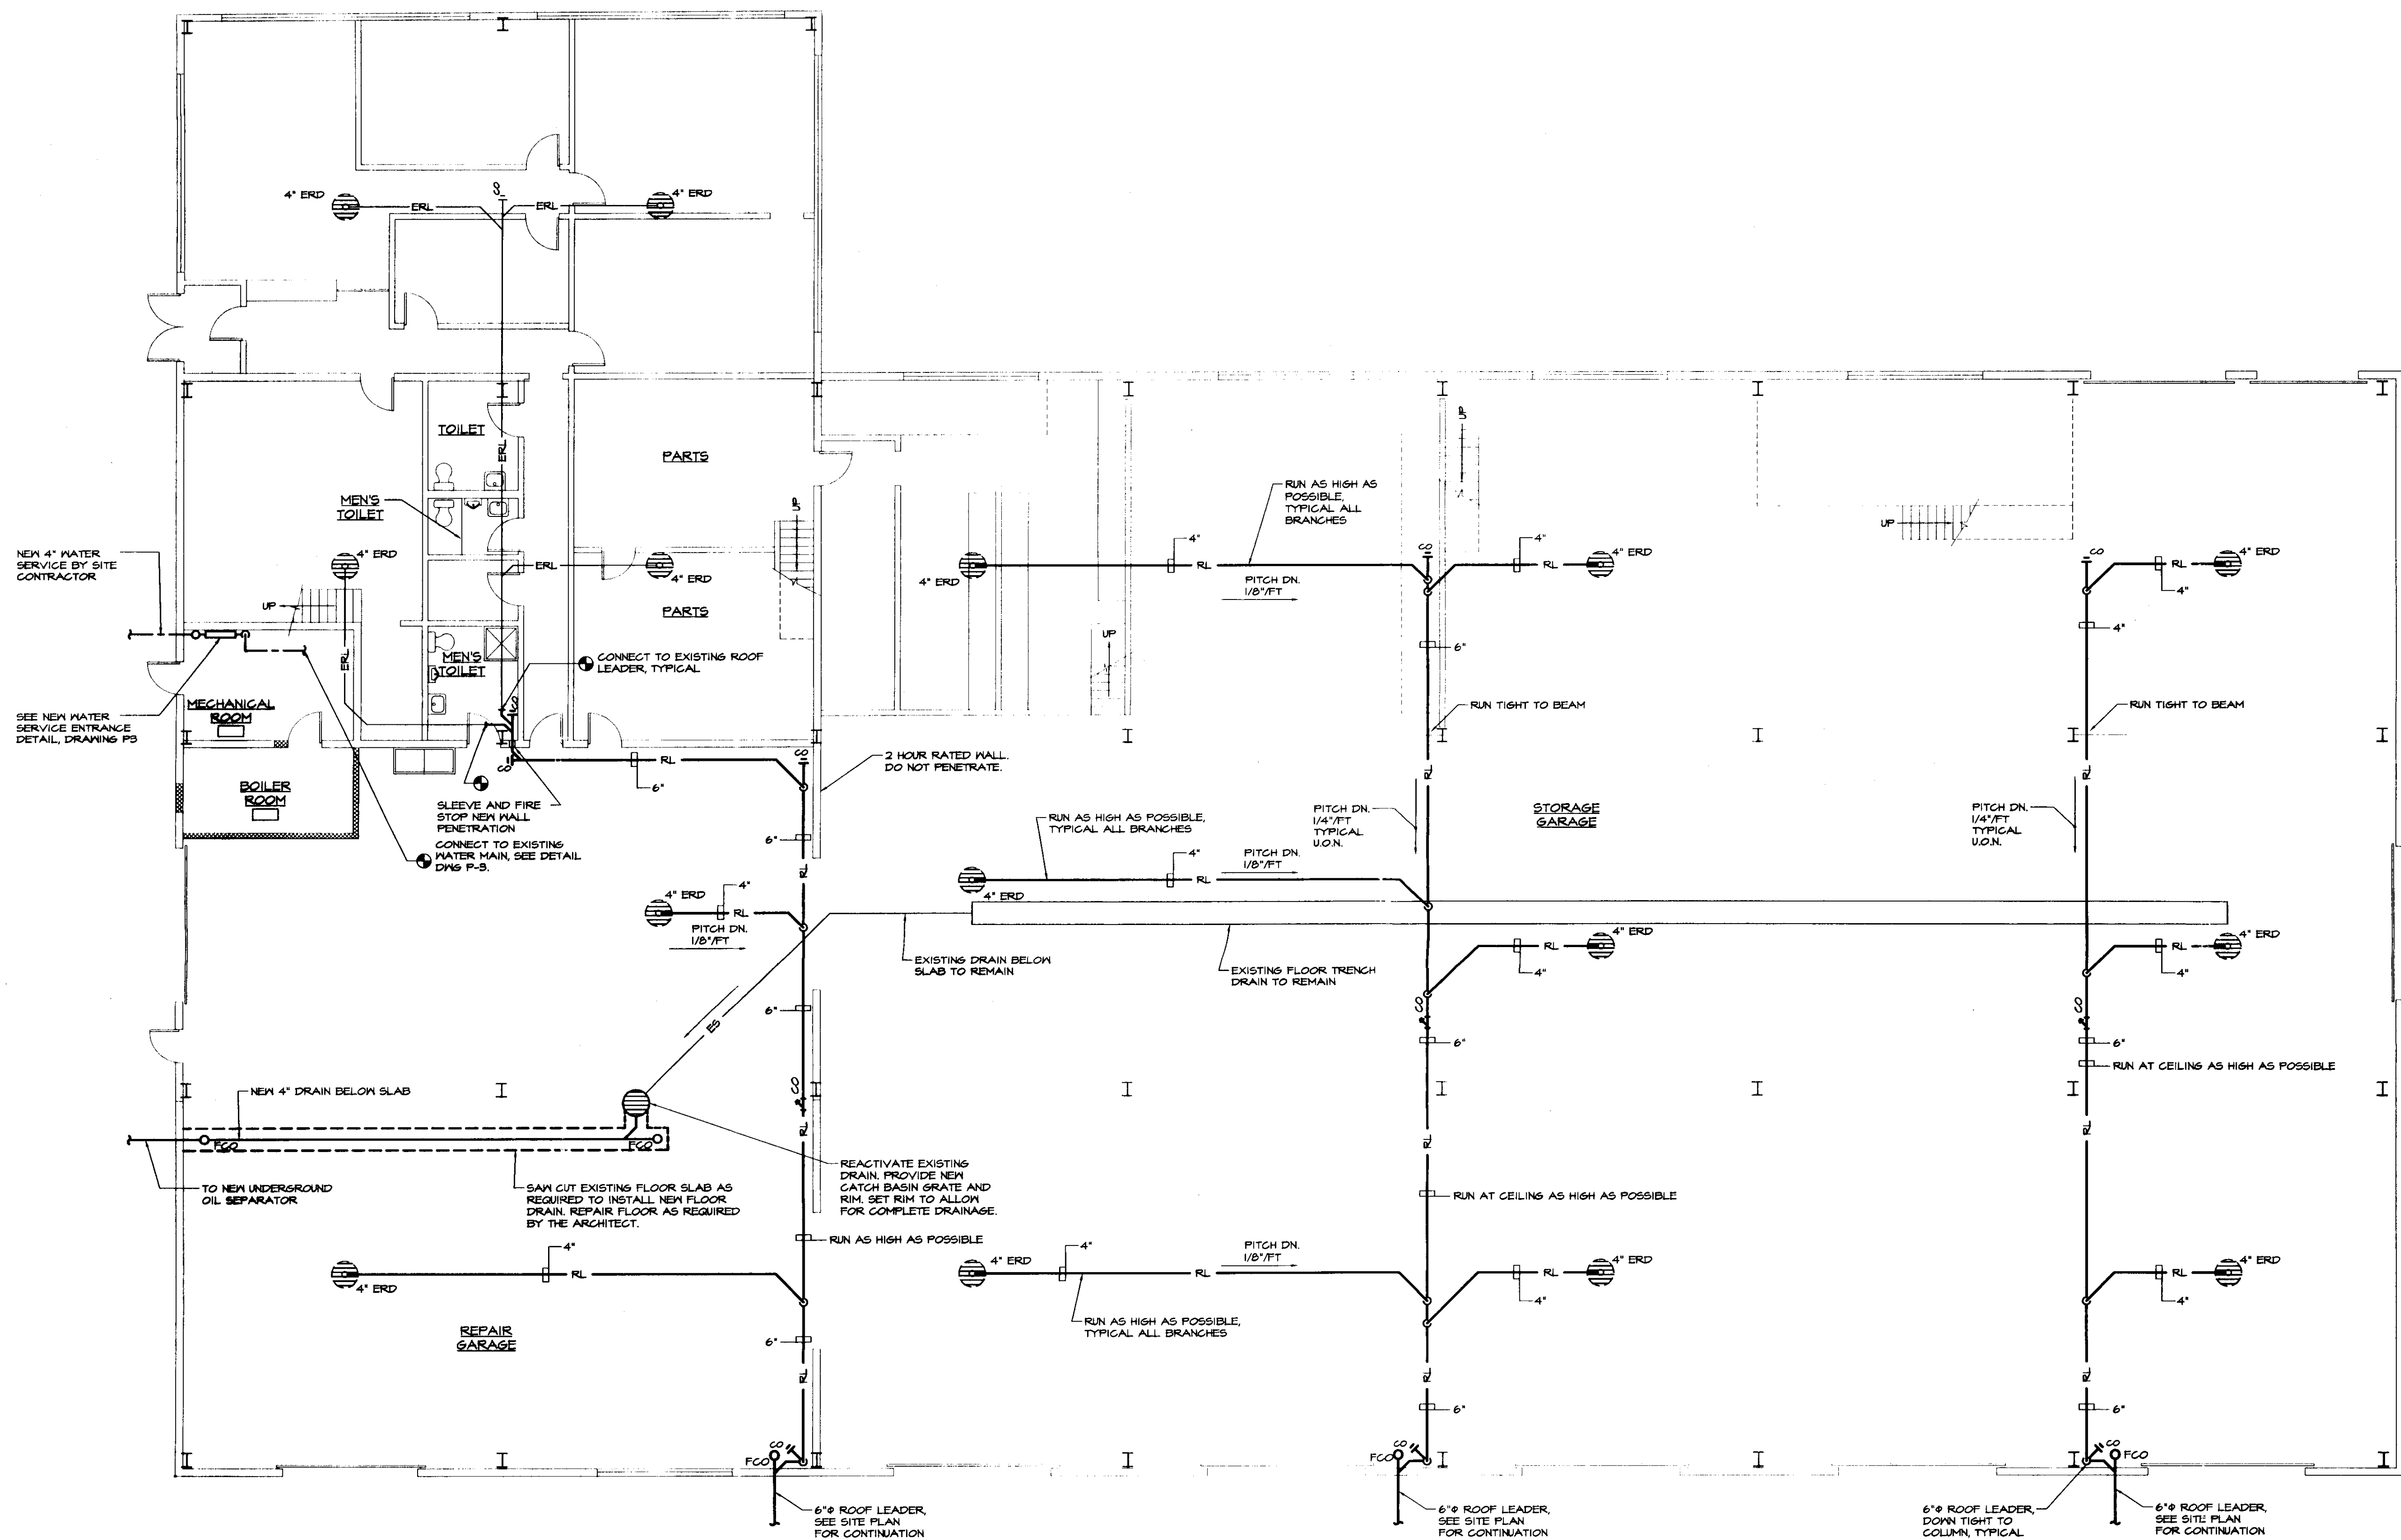

**FIRST FLOOR PLAN - NEW PLUMBING WORK**  
SCALE: 1/8"=1'-0"

	NO.	ISSUED FOR	DATE
	1	BIDDING AND CONSTRUCTION	SEPT 1, 2003

**LANE ASSOCIATES**  
CONSULTING ENGINEERS, P.C.

HEATING, VENTILATION, & AIR CONDITIONING,  
PLUMBING, FIRE PROTECTION, & ELECTRICAL

CHARLES F. LANE, P.E.  
DANIEL W. DUPRAS, P.E.

51 KILLINGTON AVENUE,  
RUTLAND, VERMONT 05701  
TELEPHONE: (802)747-3346  
FAX/MODEM: (802)747-3356

FIRST FLOOR PLAN - NEW PLUMBING WORK				P 2
BENNINGTON AOT GARAGE DRAINAGE AND UTILITY IMPROVEMENTS				
APPR:	DND	DRAWN:	DND/KPG	SCALE: AS NOTED
PROJ. NO.			0312-01	