


X:\031207-beinn\Drawings\Mech\031207M04.dwg, 04/19/2004 01:30:08 PM, © LANE ASSOCIATES CONSULTING ENGINEERS P.C. 2003

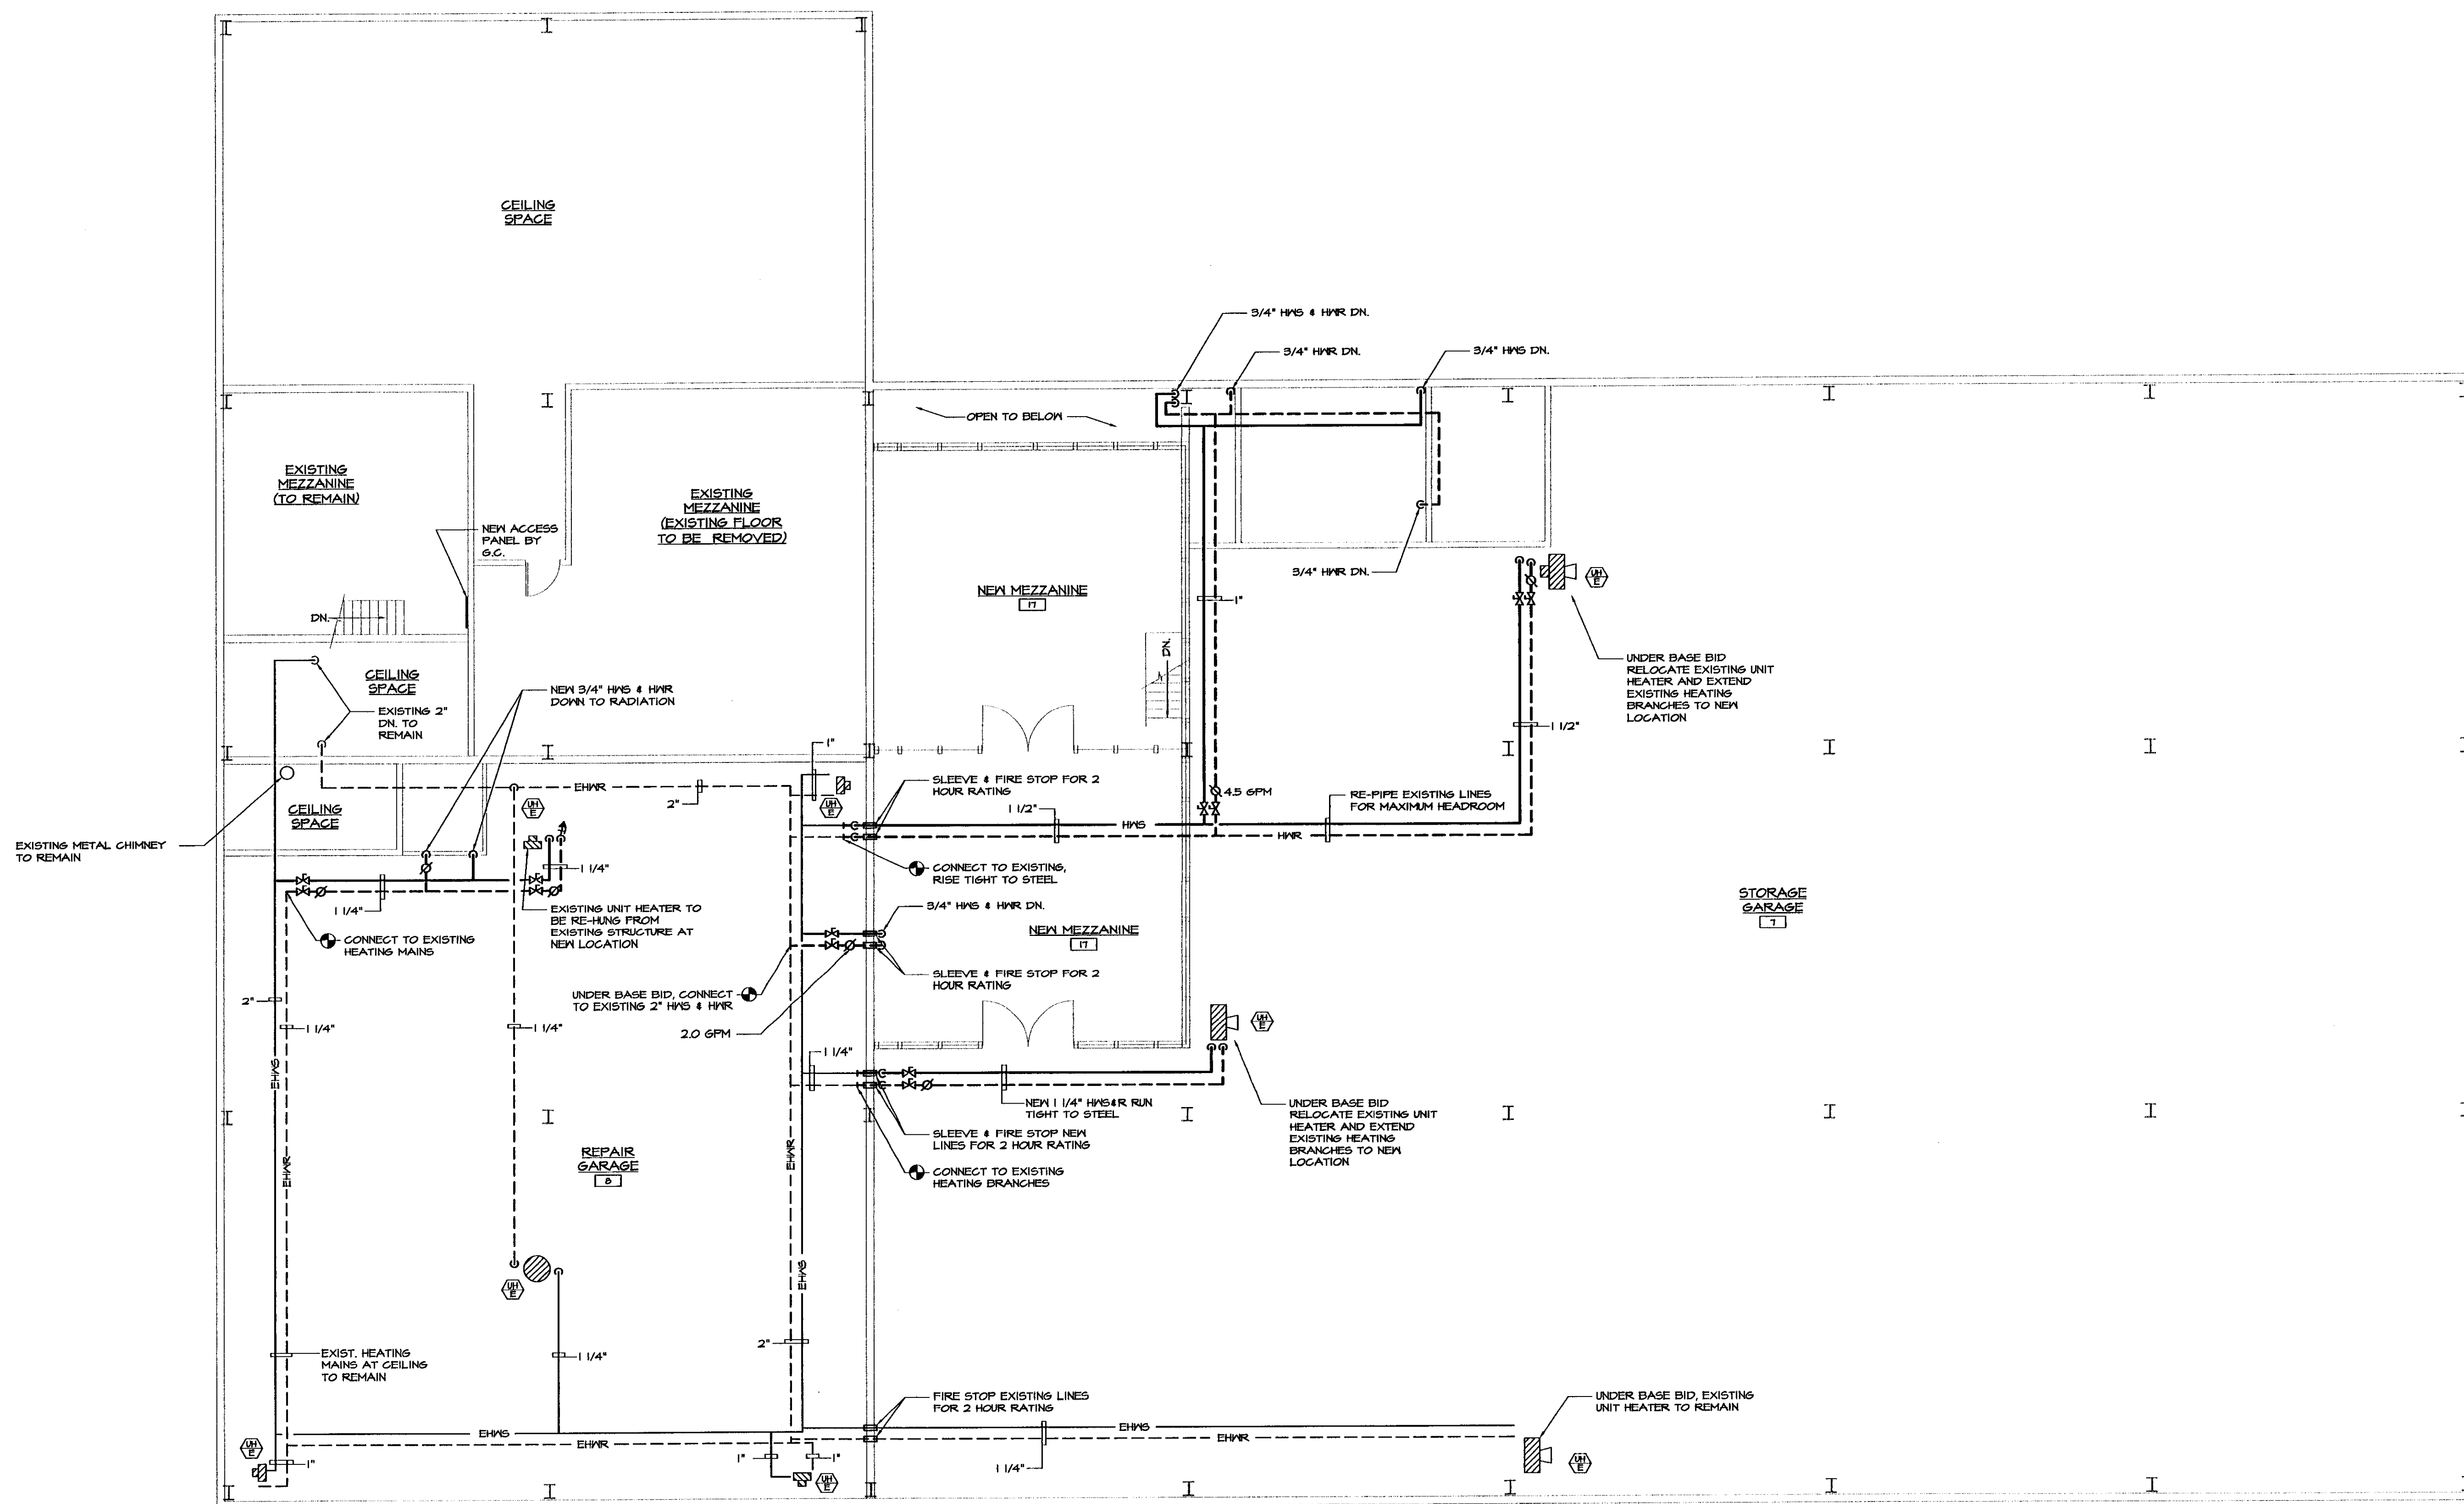

MEZZANINE PLAN - NEW HEATING BASE BID
SCALE: 1/8"=1'-0"

| | | | |
|--|-----|------------|-----------|
| | | | |
| | 1 | BIDDING | 1/19/2004 |
| | NO. | ISSUED FOR | DATE |

LANE ASSOCIATES
CONSULTING ENGINEERS, P.C.

HEATING, VENTILATION, & AIR CONDITIONING,
PLUMBING, FIRE PROTECTION, & ELECTRICAL

CHARLES F. LANE, P.E.
DANIEL W. DUPRAS, P.E.

51 KILLINGTON AVENUE,
RUTLAND, VERMONT 05701
TELEPHONE: (802)747-3346
FAX/MODEM: (802)747-3356

| | | | | | | | |
|--|-----|--------|---------|--------|----------|-----------|---------|
| MEZZANINE FLOOR PLAN NEW HEATING - BASE BID | | | | M 4 | | | |
| BENNINGTON AOT GARAGE INTERIOR RENOVATIONS | | | | | | | |
| APPR: | DWD | DRAWN: | DWD/KPC | SCALE: | AS NOTED | PROJ. NO. | 0912-07 |