


AIR CONDITIONING SYSTEM SCHEDULE:

SYSTEM MODEL: CARRIER, MODEL 59GAB-024-3
 CONDENSING UNIT (CU): CARRIER, MODEL 59HDC-024-3 208/230-1 PHASE-60 HERTZ
 FAN COIL UNIT (FCU): CARRIER, MODEL 40GAB-024-3 208/230-1 PHASE-60 HERTZ
 ACCESSORIES: CONDENSATE PUMP, PROGRAMMABLE ELECTRONIC THERMOSTAT,
 CRANKCASE HEATER, WINTER STAT CONTROL, LOW AMBIENT KIT TO -20°F, LIQUID LINE
 SOLENOID VALVE, WIND BAFFLES, FRESH AIR INTAKE KIT

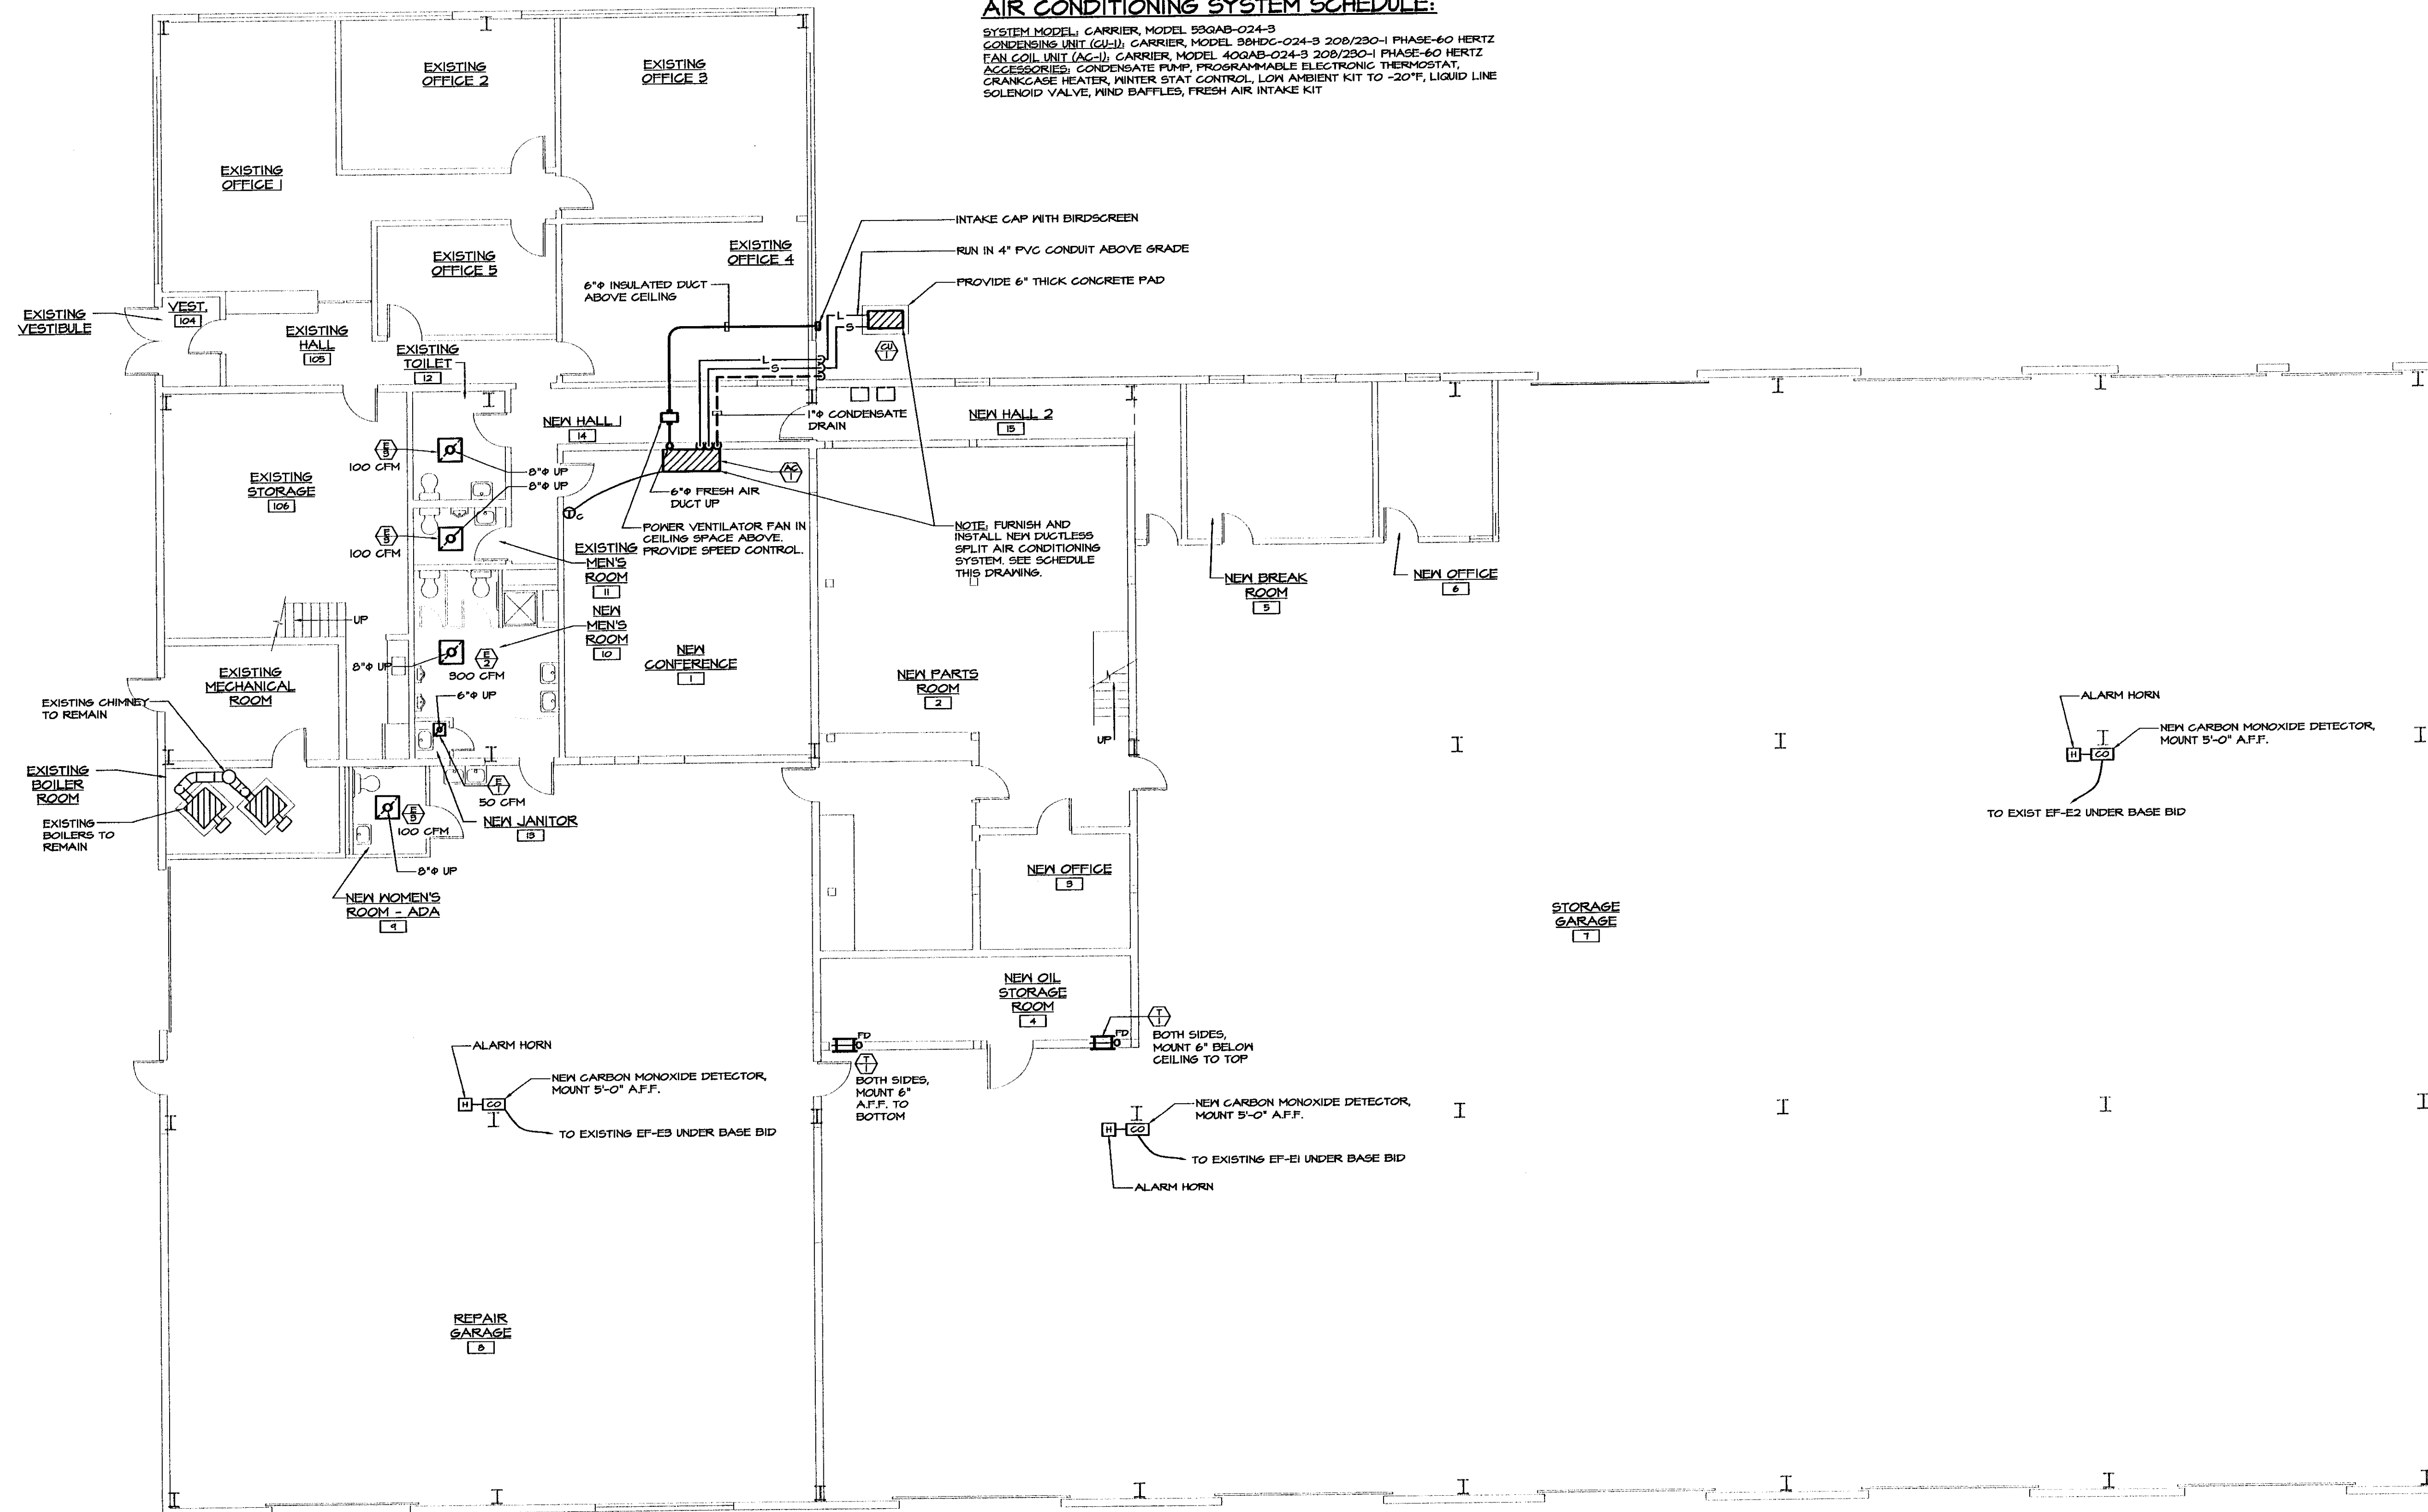

MAIN FLOOR PLAN - NEW VENTILATION BASE BID
 SCALE: 1/8"=1'-0"

X:\031207-bennDrawings\Mech\031207M05.dwg, NS, 01/19/2004, 01:29:39 PM, © LANE ASSOCIATES CONSULTING ENGINEERS PC, 2003

NO.	ISSUED FOR	DATE
1	BIDDING	1/19/2004



LANE ASSOCIATES
 CONSULTING ENGINEERS, P.C.
 HEATING, VENTILATION, & AIR CONDITIONING,
 PLUMBING, FIRE PROTECTION, & ELECTRICAL
 CHARLES F. LANE, P.E.
 DANIEL W. DUPRAS, P.E.
 51 KILLINGTON AVENUE,
 RUTLAND, VERMONT 05701
 TELEPHONE: (802)747-3346
 FAX/MODEM: (802)747-3356

MAIN FLOOR PLAN NEW VENTILATION - BASE BID				M 5
BENNINGTON AOT GARAGE INTERIOR RENOVATIONS				
APPR:	DVD	DRAWN:	DVD/KPC	SCALE: AS NOTED
				PROJ. NO. 0312-07