


X:\031207_benn\Drawings\Mech\031207\003.dwg, MS, 01/19/2004 01:24:04 PM, © LANE ASSOCIATES CONSULTING ENGINEERS PC, 2003

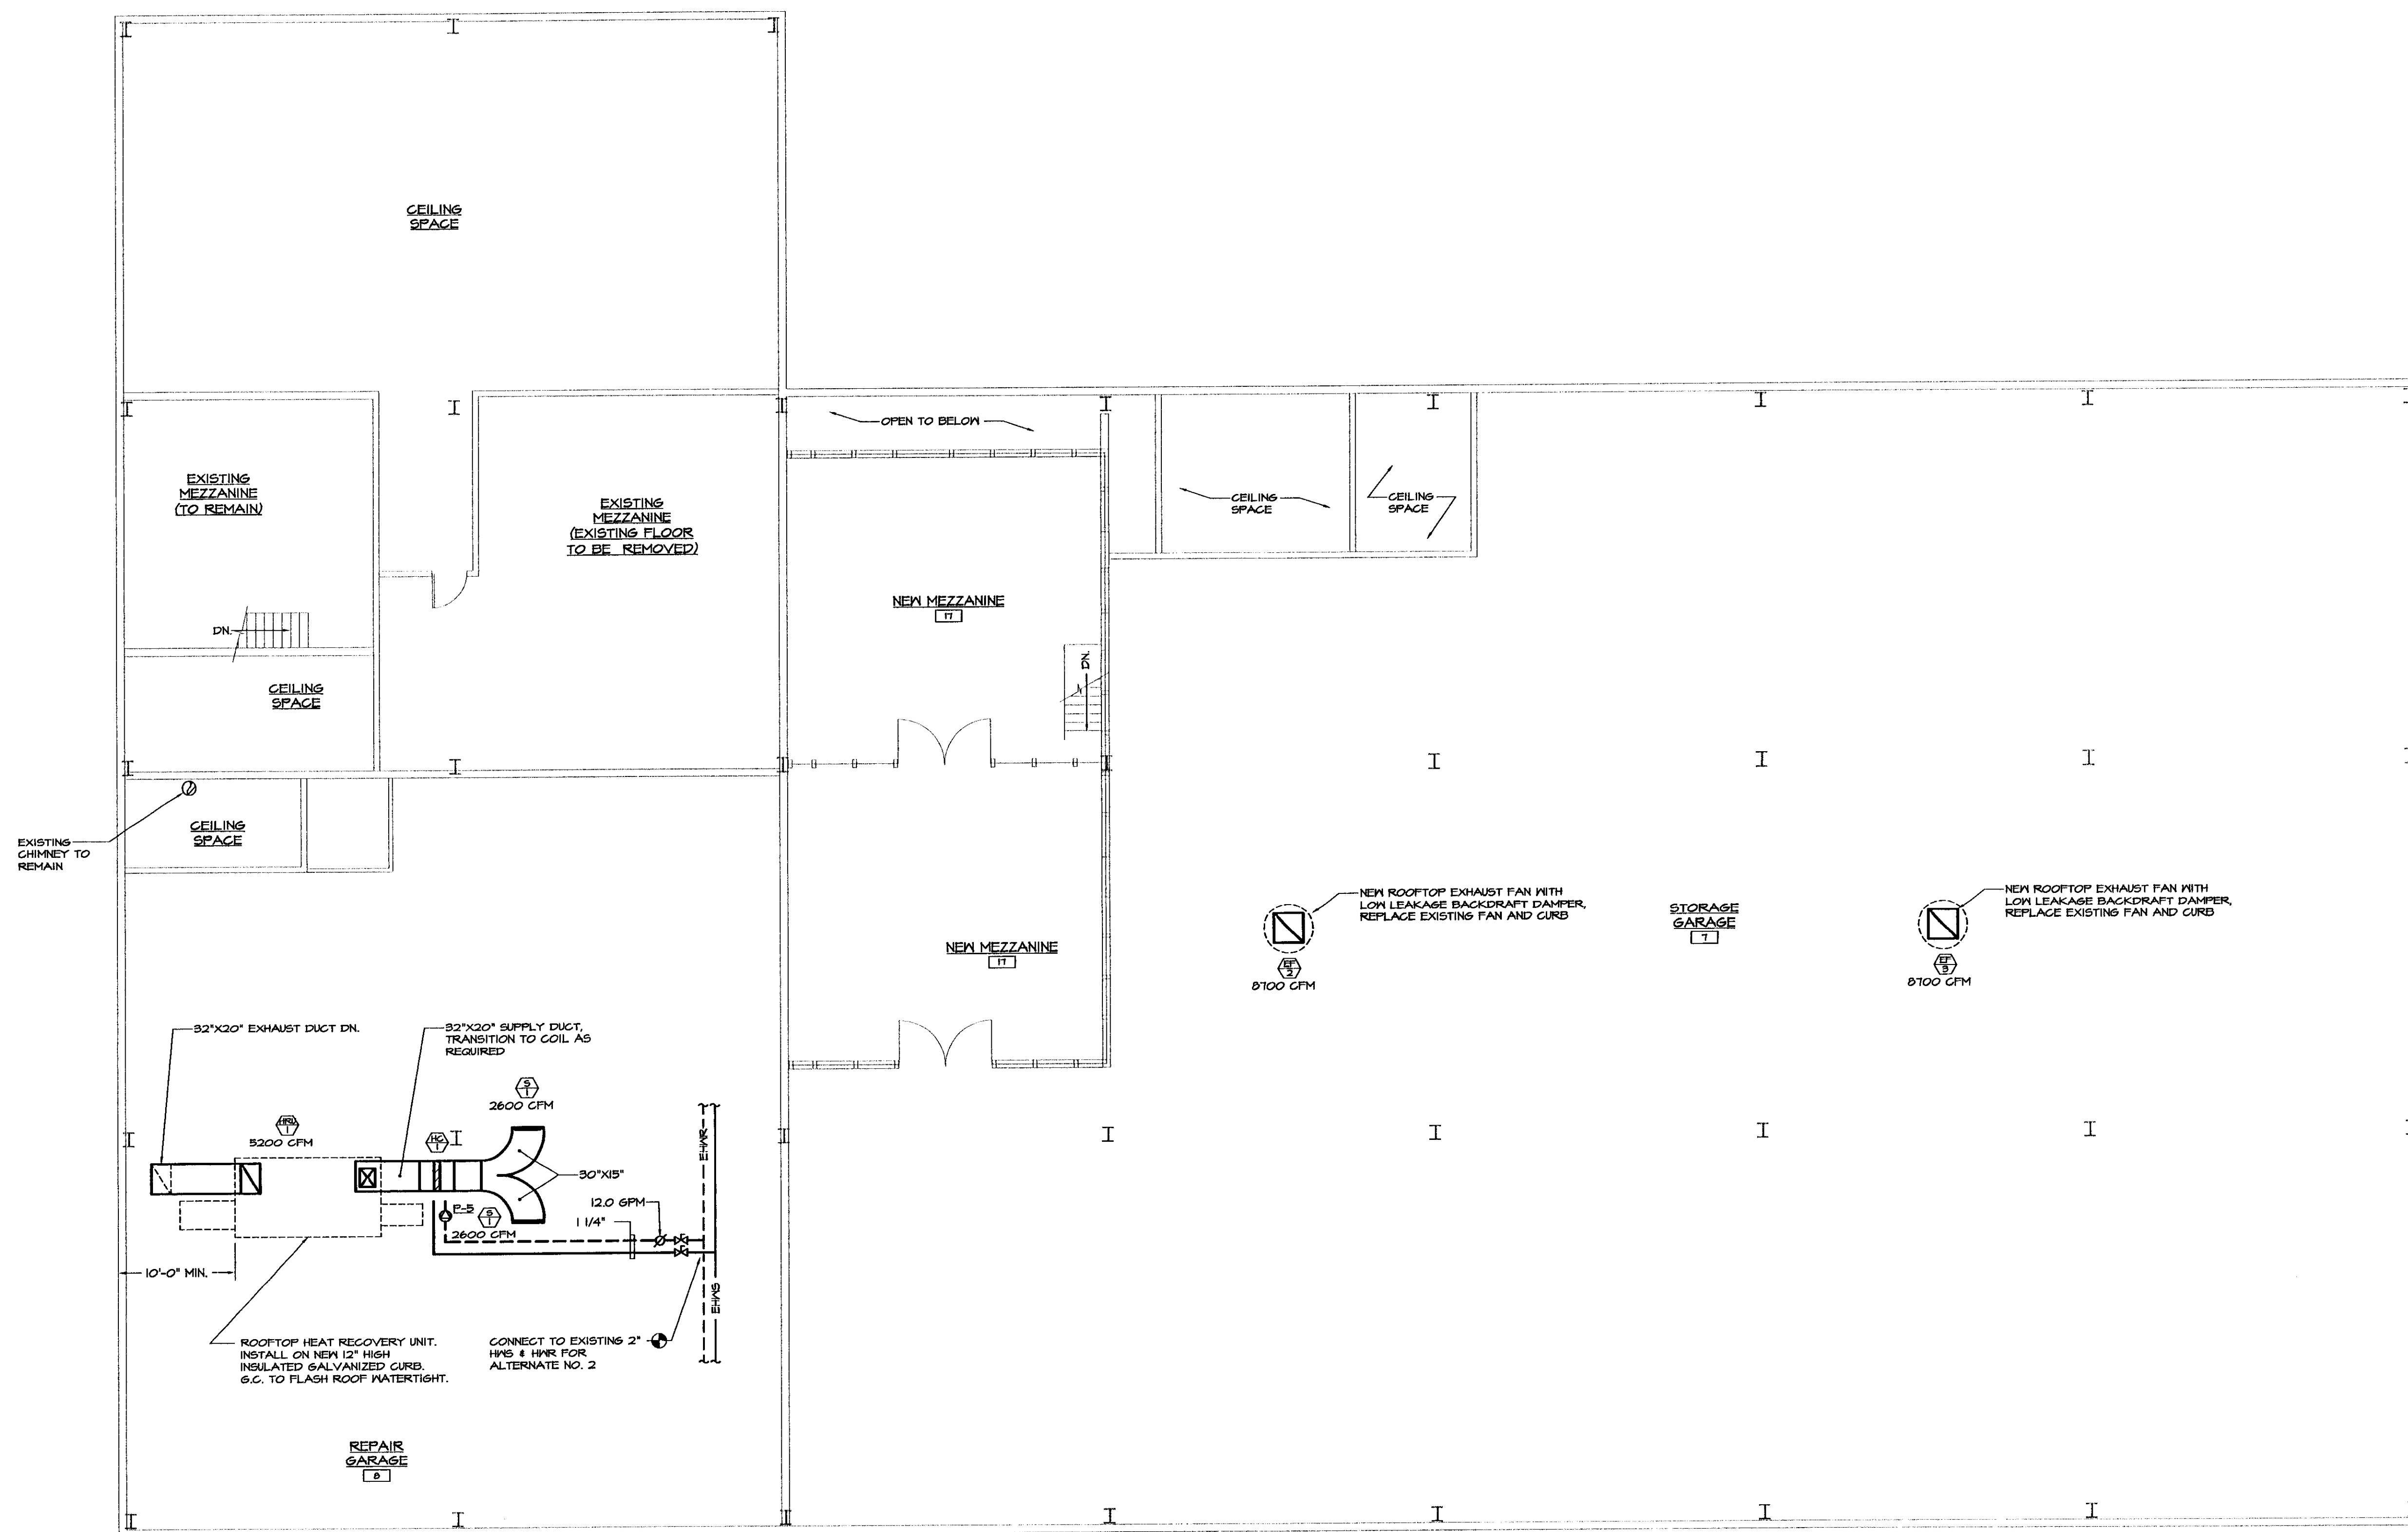

MEZZANINE FLOOR PLAN - NEW VENTILATION
ADD ALTERNATE NO. 2
 SCALE: 1/8"=1'-0"

	BIDDING	1/19/2004
NO.	ISSUED FOR	DATE

LANE ASSOCIATES
 CONSULTING ENGINEERS, P.C.

HEATING, VENTILATION, & AIR CONDITIONING,
 PLUMBING, FIRE PROTECTION, & ELECTRICAL

CHARLES F. LANE, P.E.
 DANIEL W. DUPRAS, P.E.

51 KILLINGTON AVENUE,
 RUTLAND, VERMONT 05701
 TELEPHONE: (802)747-3346
 FAX/MODEM: (802)747-3356

MEZZANINE FLOOR PLAN
 NEW VENTILATION - ADD ALTERNATE NO. 2

BENNINGTON AOT GARAGE
 INTERIOR RENOVATIONS

APPR: DWD DRAWN: DWD/KPC SCALE: AS NOTED PROJ. NO. 0312-07

M
9