


X:\031207-beam\Drawings\Fire\031207FP01.dwg, FP1, 01/19/2004 01:14:55 PM, © LANE ASSOCIATES CONSULTING ENGINEERS P.C. 2003

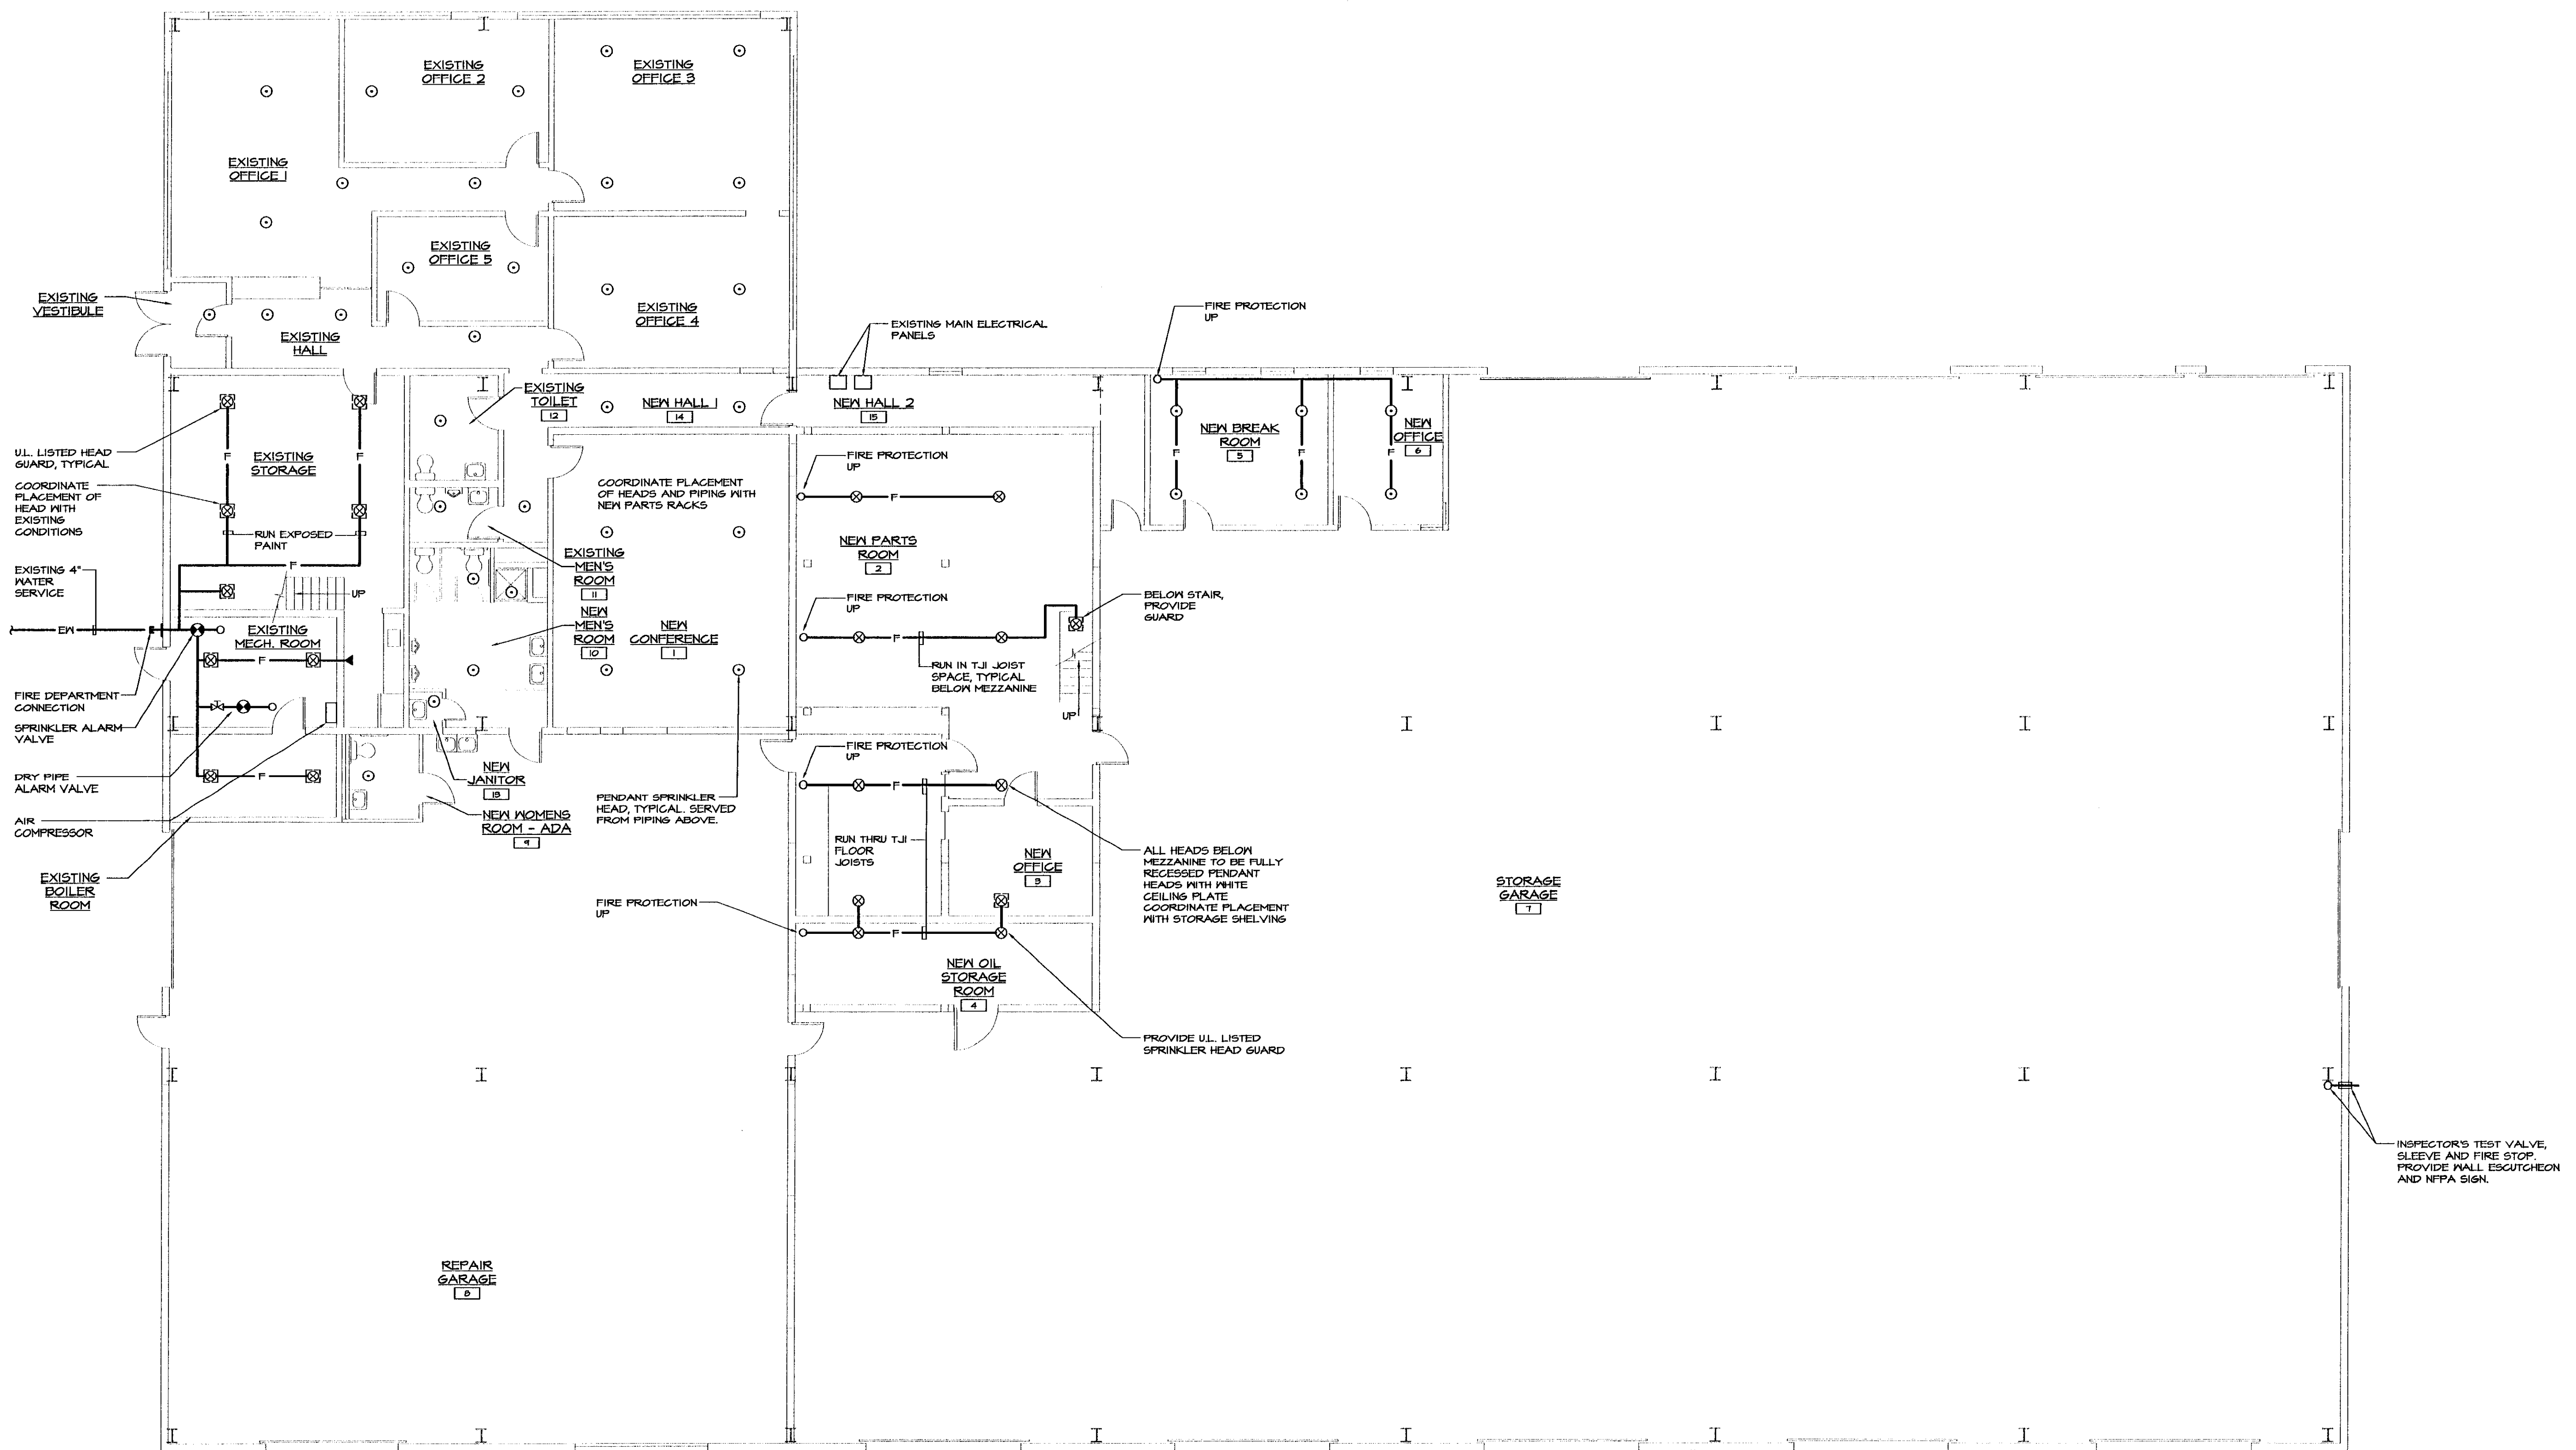

**PARTIAL MAIN FLOOR PLAN - FIRE PROTECTION**  
SCALE: 1/8"=1'-0"

I	BIDDING	1/19/2004
NO.	ISSUED FOR	DATE



HEATING, VENTILATION, & AIR CONDITIONING,  
PLUMBING, FIRE PROTECTION, & ELECTRICAL  
CHARLES F. LANE, P.E.  
DANIEL W. DUPRAS, P.E.  
51 KILLINGTON AVENUE,  
RUTLAND, VERMONT 05701  
TELEPHONE: (802)747-3346  
FAX/MODEM: (802)747-3356

PARTIAL MAIN FLOOR PLAN - FIRE PROTECTION				FP1
BENNINGTON AOT GARAGE INTERIOR RENOVATIONS				
APPR.	DND	DRAWN: DWD/KPC	SCALE: AS NOTED	PROJ. NO. 0312-07