



X:\031207\beam\Drawings\Fire\031207FP02.dwg, FP2, 01/19/2004 01:16:55 PM, © LANE ASSOCIATES CONSULTING ENGINEERS P.C. 2003

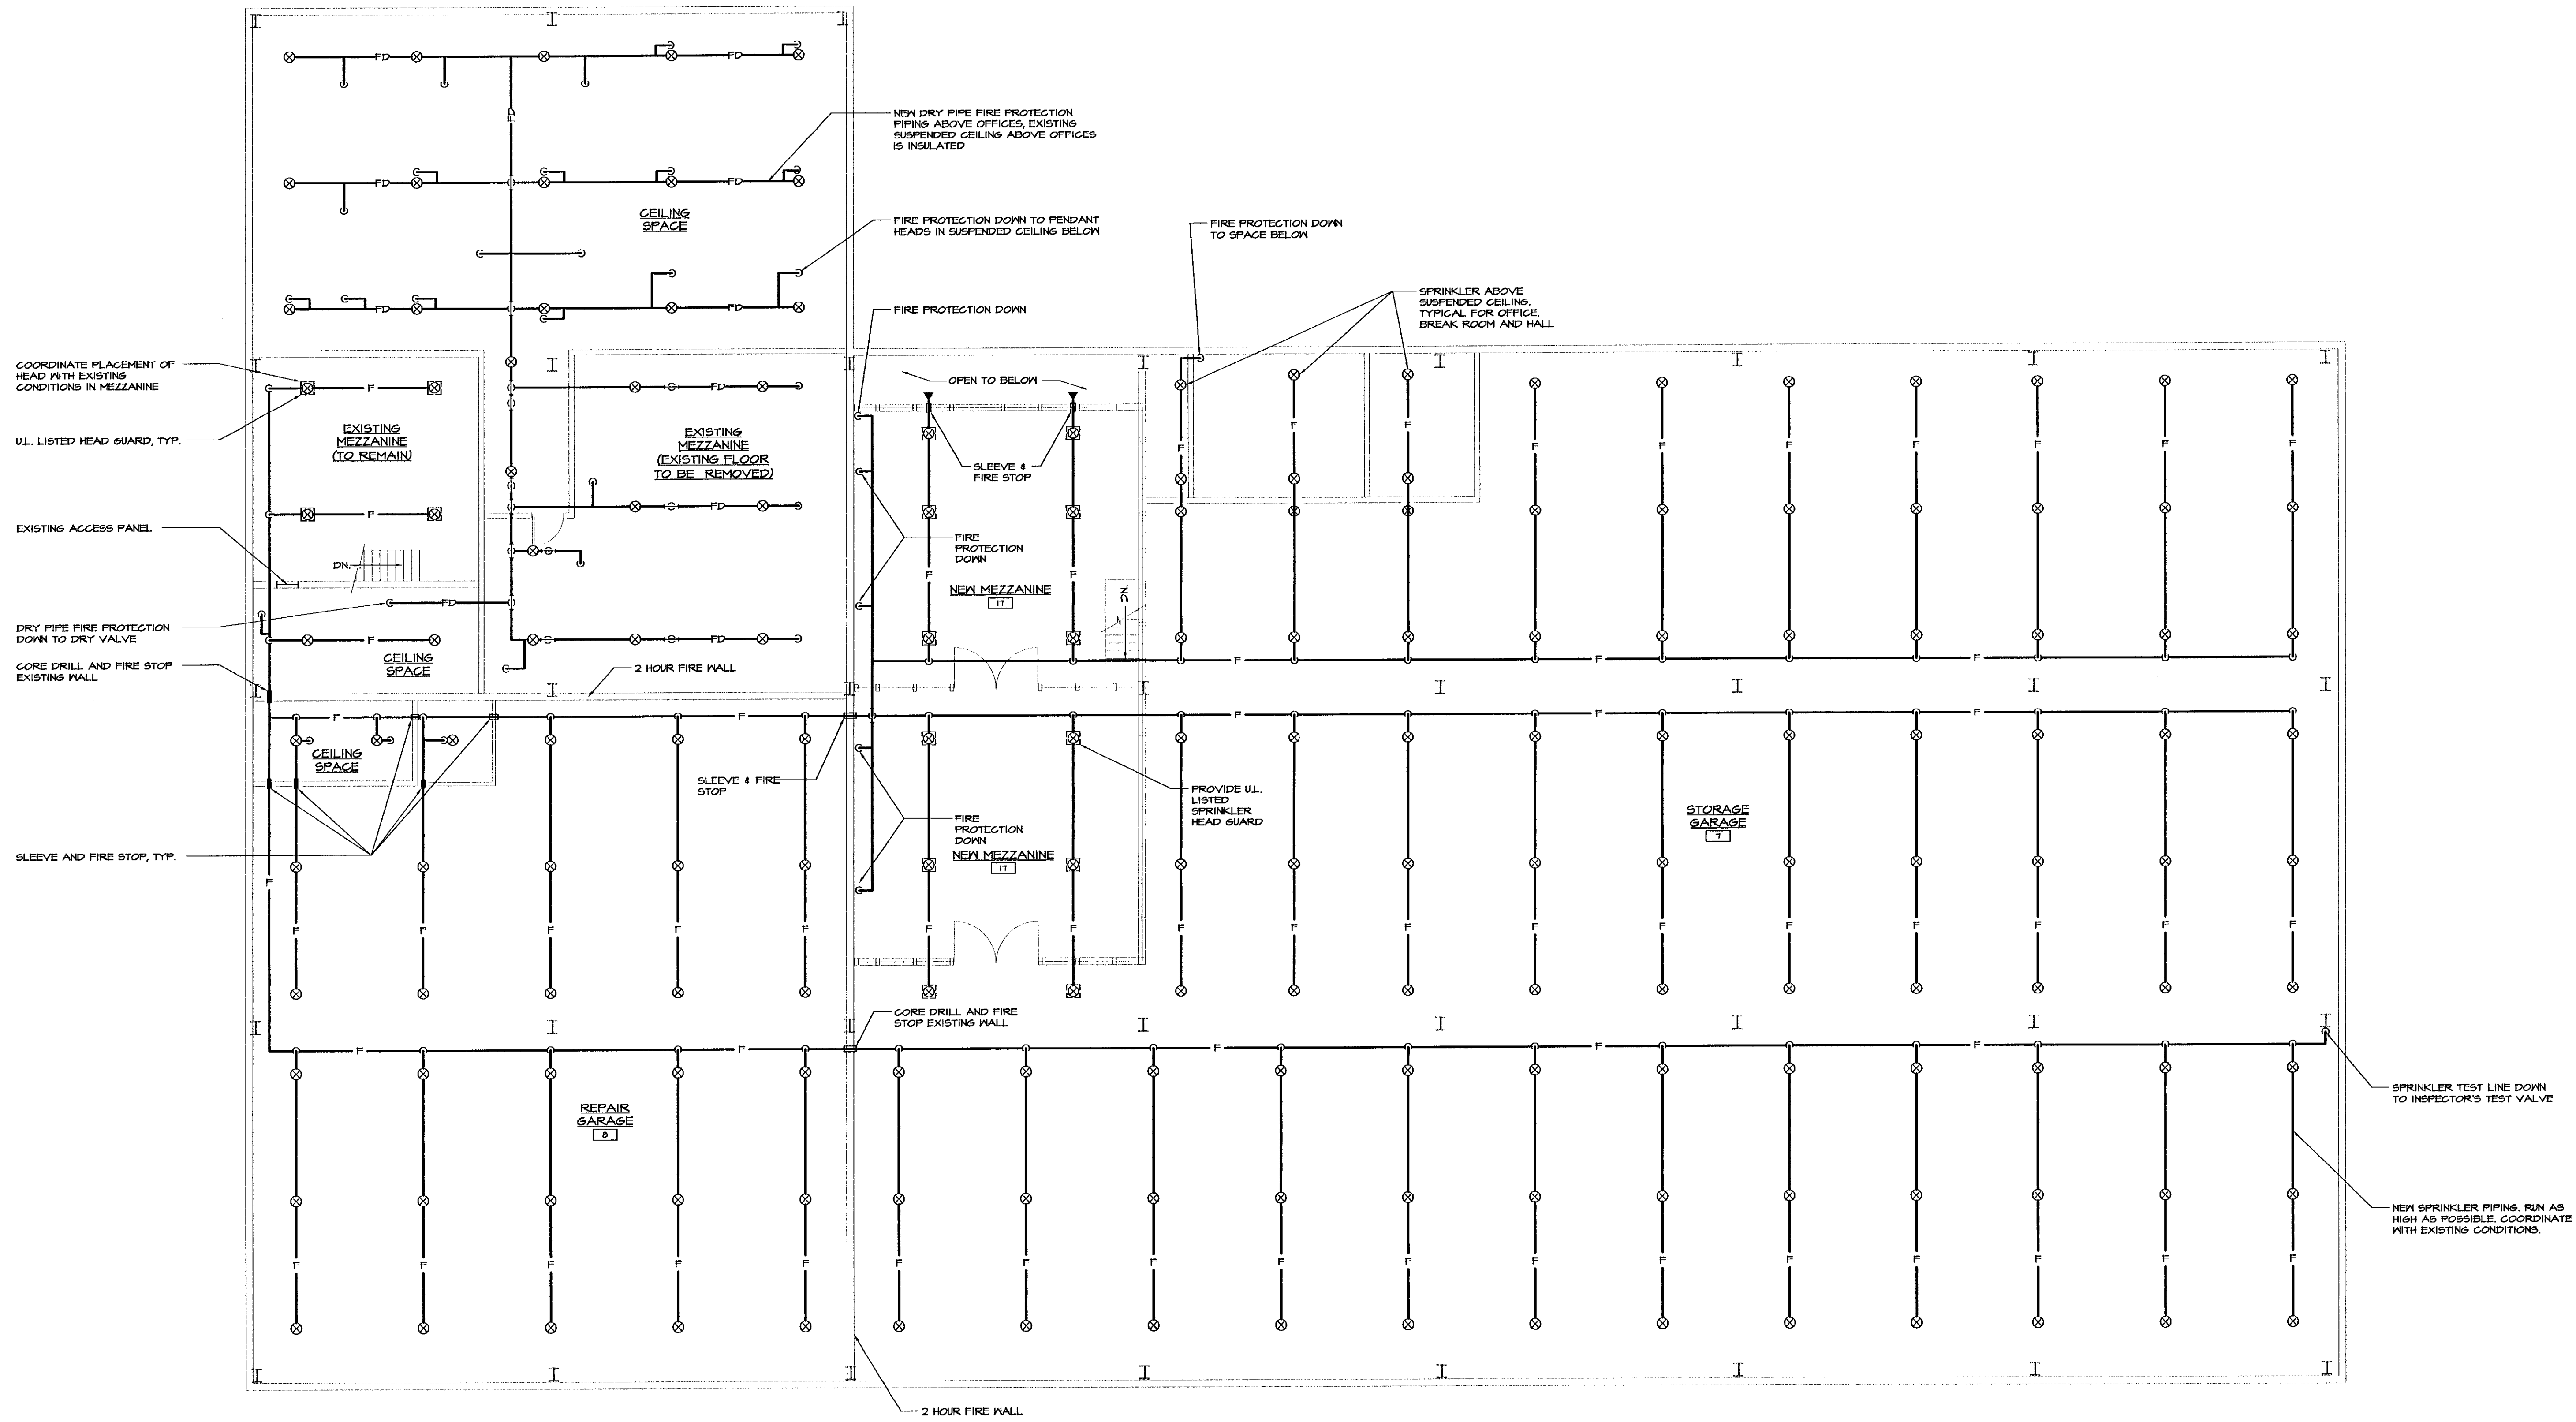

**MEZZANINE FLOOR PLAN - FIRE PROTECTION**  
SCALE: 1/8"=1'-0"

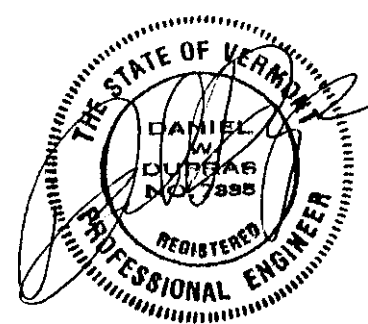

NO.	ISSUED FOR	DATE
1	BIDDING	1/19/2004



HEATING, VENTILATION, & AIR CONDITIONING,  
PLUMBING, FIRE PROTECTION, & ELECTRICAL

CHARLES F. LANE, P.E.  
DANIEL W. DUPRAS, P.E.

51 KILLINGTON AVENUE,  
RUTLAND, VERMONT 05701  
TELEPHONE: (802)747-3346  
FAX/MODEM: (802)747-3356

MEZZANINE FLOOR PLAN FIRE PROTECTION				
BENNINGTON AOT GARAGE INTERIOR RENOVATIONS				
APPR.	DWD	DRAWN:	DWD/KFC	SCALE: AS NOTED
PRJ. NO.				0312-01

**FP2**