 


FLOOR PLAN - LIGHTING PLAN
SCALE: 1/8" = 1'-0"




LIGHTING FIXTURE SCHEDULE				
TYPE	MANUFACTURER & MODEL	MOUNTING	LAMPS	REMARKS
FA	COLUMBIA WC4-232-EB8-120	SURFACE	(2)-F032T8 3500 K	
FB	COLUMBIA P424-232G-LD36-S-EB8-120	RECESSED	(2)-F032T8 3500 K	
FC	COLUMBIA P424-332G-LD36-S-EB8-120-MS9	RECESSED	(3)-F032T8 3500 K	MASTER/SLAVE WIRED FOR DUAL-LEVEL LIGHTING
FE	EXISTING FIXTURE TO REMAIN		EXISTING	WASH ALL FIXTURES & LENSES
FF	COLUMBIA KL4-232-ST-EB8-120-KHC-KLWG4	CHAIN-HUNG	(2)-F032T8 3500 K	CHAIN HUNG, WIRE GUARD HANG FLUSH WITH BOTTOM OF FLOOR JOISTS
FG	COLUMBIA KL8-232-ST-EB8-120-KHC-KLWG4	CHAIN-HUNG	(4)-F032T8 3500 K	CHAIN HUNG, WIRE GUARD HANG FLUSH WITH BOTTOM OF FLOOR JOISTS
FH	PRESCOLITE QBX18-120-T071S	RECESSED	(1)-18W QUAD 2700 K	
FJ	PRESCOLITE 9424-13NPF-120	SURFACE	(1)-13W TT 2700 K	
FK	COLUMBIA J24-232G-FSA12-EB8-120	RECESSED	(2)-F032T8 3500 K	
A	GE VERSAGLOW V2G-25-P-0-A-4-EA-5-LCP120-SFC0-SFC3B	PENDANT	250W MH PULSE START	WITH #LRHB120 HOOK-BOX REFER TO DETAIL
A1	GE VERSAGLOW V2G-25-P-0-A-4-EA-5-Q-LCP120-SFC0-SFC3B	PENDANT	250W MH PULSE START	SAME AS ABOVE WITH 150W QUARTZ RESTRIKE
R	RELOCATED FIXTURES CLEAN AND RELAMP	PENDANT	250W MH PULSE START	REUSE ALL MOUNTING HARDWARE & EQUIPMENT
⊞	DUALITE EZ-2	SURFACE	INCLUDED	
⊗	DUALITE LXURWE	SURFACE	INCLUDED	RED LETTERING

GENERAL NOTES:

- EQUIPMENT AND MATERIALS REMOVED OR DEMOLISHED AND NOT TO BE REINSTALLED BY THE EC SHALL BE CLASSIFIED BY THE OWNER AS SALVAGE OR SCRAP. THOSE CLAIMED BY THE OWNER SHALL BE DELIVERED TO THE OWNER BY THE EC WHERE DIRECTED AT THE SITE. THOSE NOT CLAIMED BY THE OWNER SHALL BECOME PROPERTY OF THE EC AND SHALL BE LEGALLY REMOVED FROM THE SITE AND PREMISES.
- ANY PLACE WHERE THE CONTRACTOR PENETRATES, CUTS AND/OR REMOVES WALLS, CONTRACTOR IS TO REPLACE, PATCH AND PAINT WALLS TO ORIGINAL FINISHES.
- FIELD VERIFY ALL DIMENSIONS BEFORE COMMENCEMENT OF WORK. NOTIFY ENGINEER OF ANY ERRORS. CONTRACTOR IS RESPONSIBLE FOR INSPECTING THE FACILITY PRIOR TO BID DATE. NO ADDITIONAL COMPENSATION SHALL BE PAID TO THE CONTRACTOR FOR FAILURE TO EXAMINE EXISTING CONDITIONS.
- REFER TO THE ARCHITECTURAL PLANS FOR EXTENT OF DEMOLITION WORK TO BE PERFORMED BY THE GENERAL CONTRACTOR. ALL ITEMS THAT NEED TO BE REMOVED BY THE GC SHALL HAVE THE POWER DISCONNECTED BY THE EC.
- NOT ALL DEVICES TO BE REMOVED OR DISCONNECTED ARE SHOWN. ALL EXISTING WIRING, ELECTRICAL DEVICES & EQUIPMENT SHALL BE COMPLETELY REMOVED. REFER TO ARCH. PLANS FOR TOTAL EXTENT OF DEMOLITION WORK.
- BUILDING IS EXISTING. WIRING IN EXTERIOR WALLS SHALL BE FISHED AS NECESSARY. SOME INTERIOR PARTITIONS ARE EXISTING, WIRING IN THESE WALLS MAY NEED TO BE FISHED. REFER TO ARCHITECTURAL PLANS FOR FULL EXTENT OF EXISTING CONDITIONS. NO SURFACE RACEWAY TO BE INSTALLED WITHOUT WRITTEN AUTHORIZATION FROM ARCHITECT.

KEYED NOTES:

- REFER TO LIGHTING WIRING DIAGRAM (TYP. OF ALL Ⓢ.)
- FIXTURES SHALL BE CHAIN-HUNG, WITHIN THE JOIST SPACE, FLUSH WITH THE BOTTOM OF THE JOISTS.
- EXISTING SWITCH, WIRE TO NEW LIGHTS AS SHOWN.
- PROVIDE RED SWITCH PLATE WITH LABEL "EM-LIGHTS".
- CONNECT TO NEAREST RECEPTACLE CIRCUIT.
- PROVIDE UNISTRUT STRUCTURE TO MOUNT NEW LIGHTING CONTACTORS AS REQUIRED.
- RELOCATED FAN SPEED CONTROL.

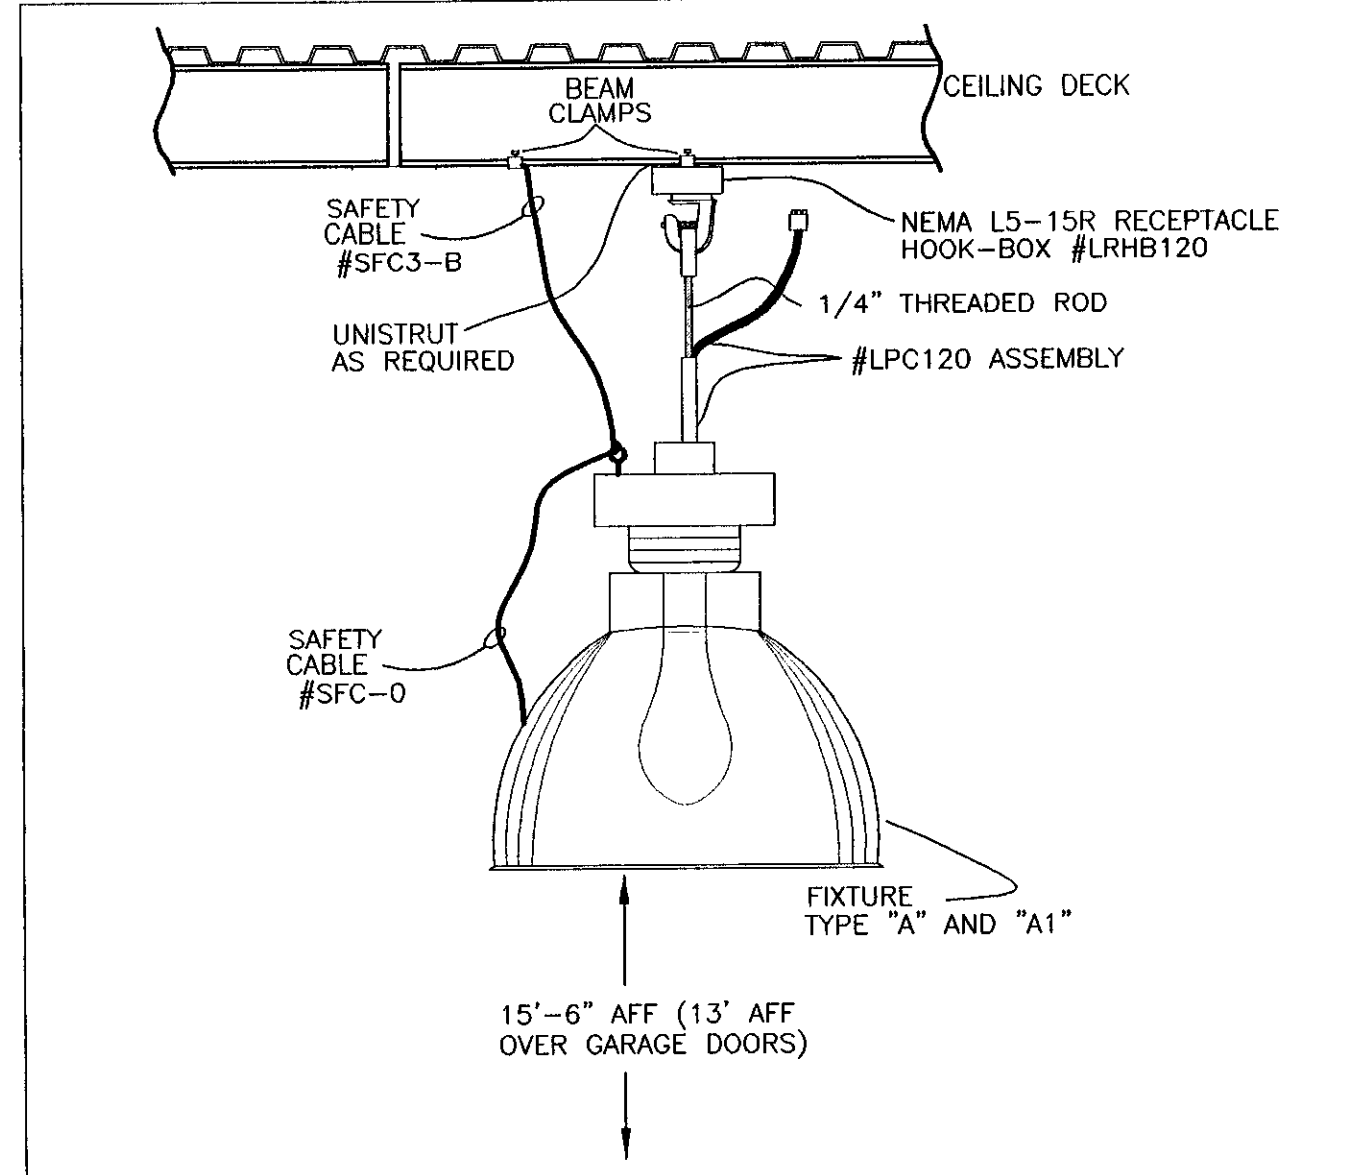

TYPE "A" & "A1" FIXTURE MOUNTING DETAIL
NO SCALE

STATE OF VERMONT
Department of Buildings and General Services
and General Services
Agency of Administration
Montpelier, Vermont

Pearson & Associates
MECHANICAL & ELECTRICAL ENGINEERS
P.O. BOX 610 STONE, VERMONT 05872
TEL. (802) 253-9607 FAX. (802) 253-9290
EMAIL: pearson@stovewy.net

AGENCY OF TRANSPORTATION
BENNINGTON MAINTENANCE GARAGE & OFFICE RENOVATIONS
BENNINGTON VERMONT

REVISIONS

SCALE: AS SHOWN	DATE: JAN. 2004	DRAWN BY: ASG	APPR. BY: EEP
-----------------	-----------------	---------------	---------------

AGENCY OF TRANSPORTATION
GARAGE & OFFICES
LIGHTING PLAN

E-3

3 OF 6