



**MEZZANINE DEMOLITION PLAN**

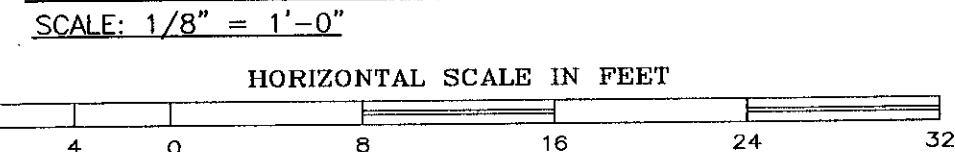


**KEYED NOTES:**

- 1 DOWN TO RECEPTACLES BELOW.
- 2 EXISTING ELECTRICAL ITEMS ON THIS MEZZANINE TO REMAIN.
- 3 EXISTING ELECTRICAL ITEMS ON THIS MEZZANINE TO BE REMOVED.
- 4 EXISTING J-BOXES USED FOR PANEL "CP". EXTEND AND RE-ROUTE CONDUITS TO NEW PANEL LOCATION BELOW.
- 5 EXISTING 12"x12" J-BOXES. REMOVE ALL UNUSED WIRING. LABEL EXISTING WIRES. PROVIDE COVERS AND PROVIDE LABELING FOR J-BOXES.
- 6 CONNECT TO EXISTING RECEPTACLE IN EXISTING MEZZ.
- 7 MOUNT NEW FIXTURES BETWEEN BEAMS ON DECK.
- 8 EXISTING CABLE SERVICE FOR WEATHER COMPUTER IS FED THRU THIS AREA. EXTEND AS REQUIRED TO NEW AREA BELOW.
- 9 COORD EXACT LOCATION & INSTALLATION WITH MC.


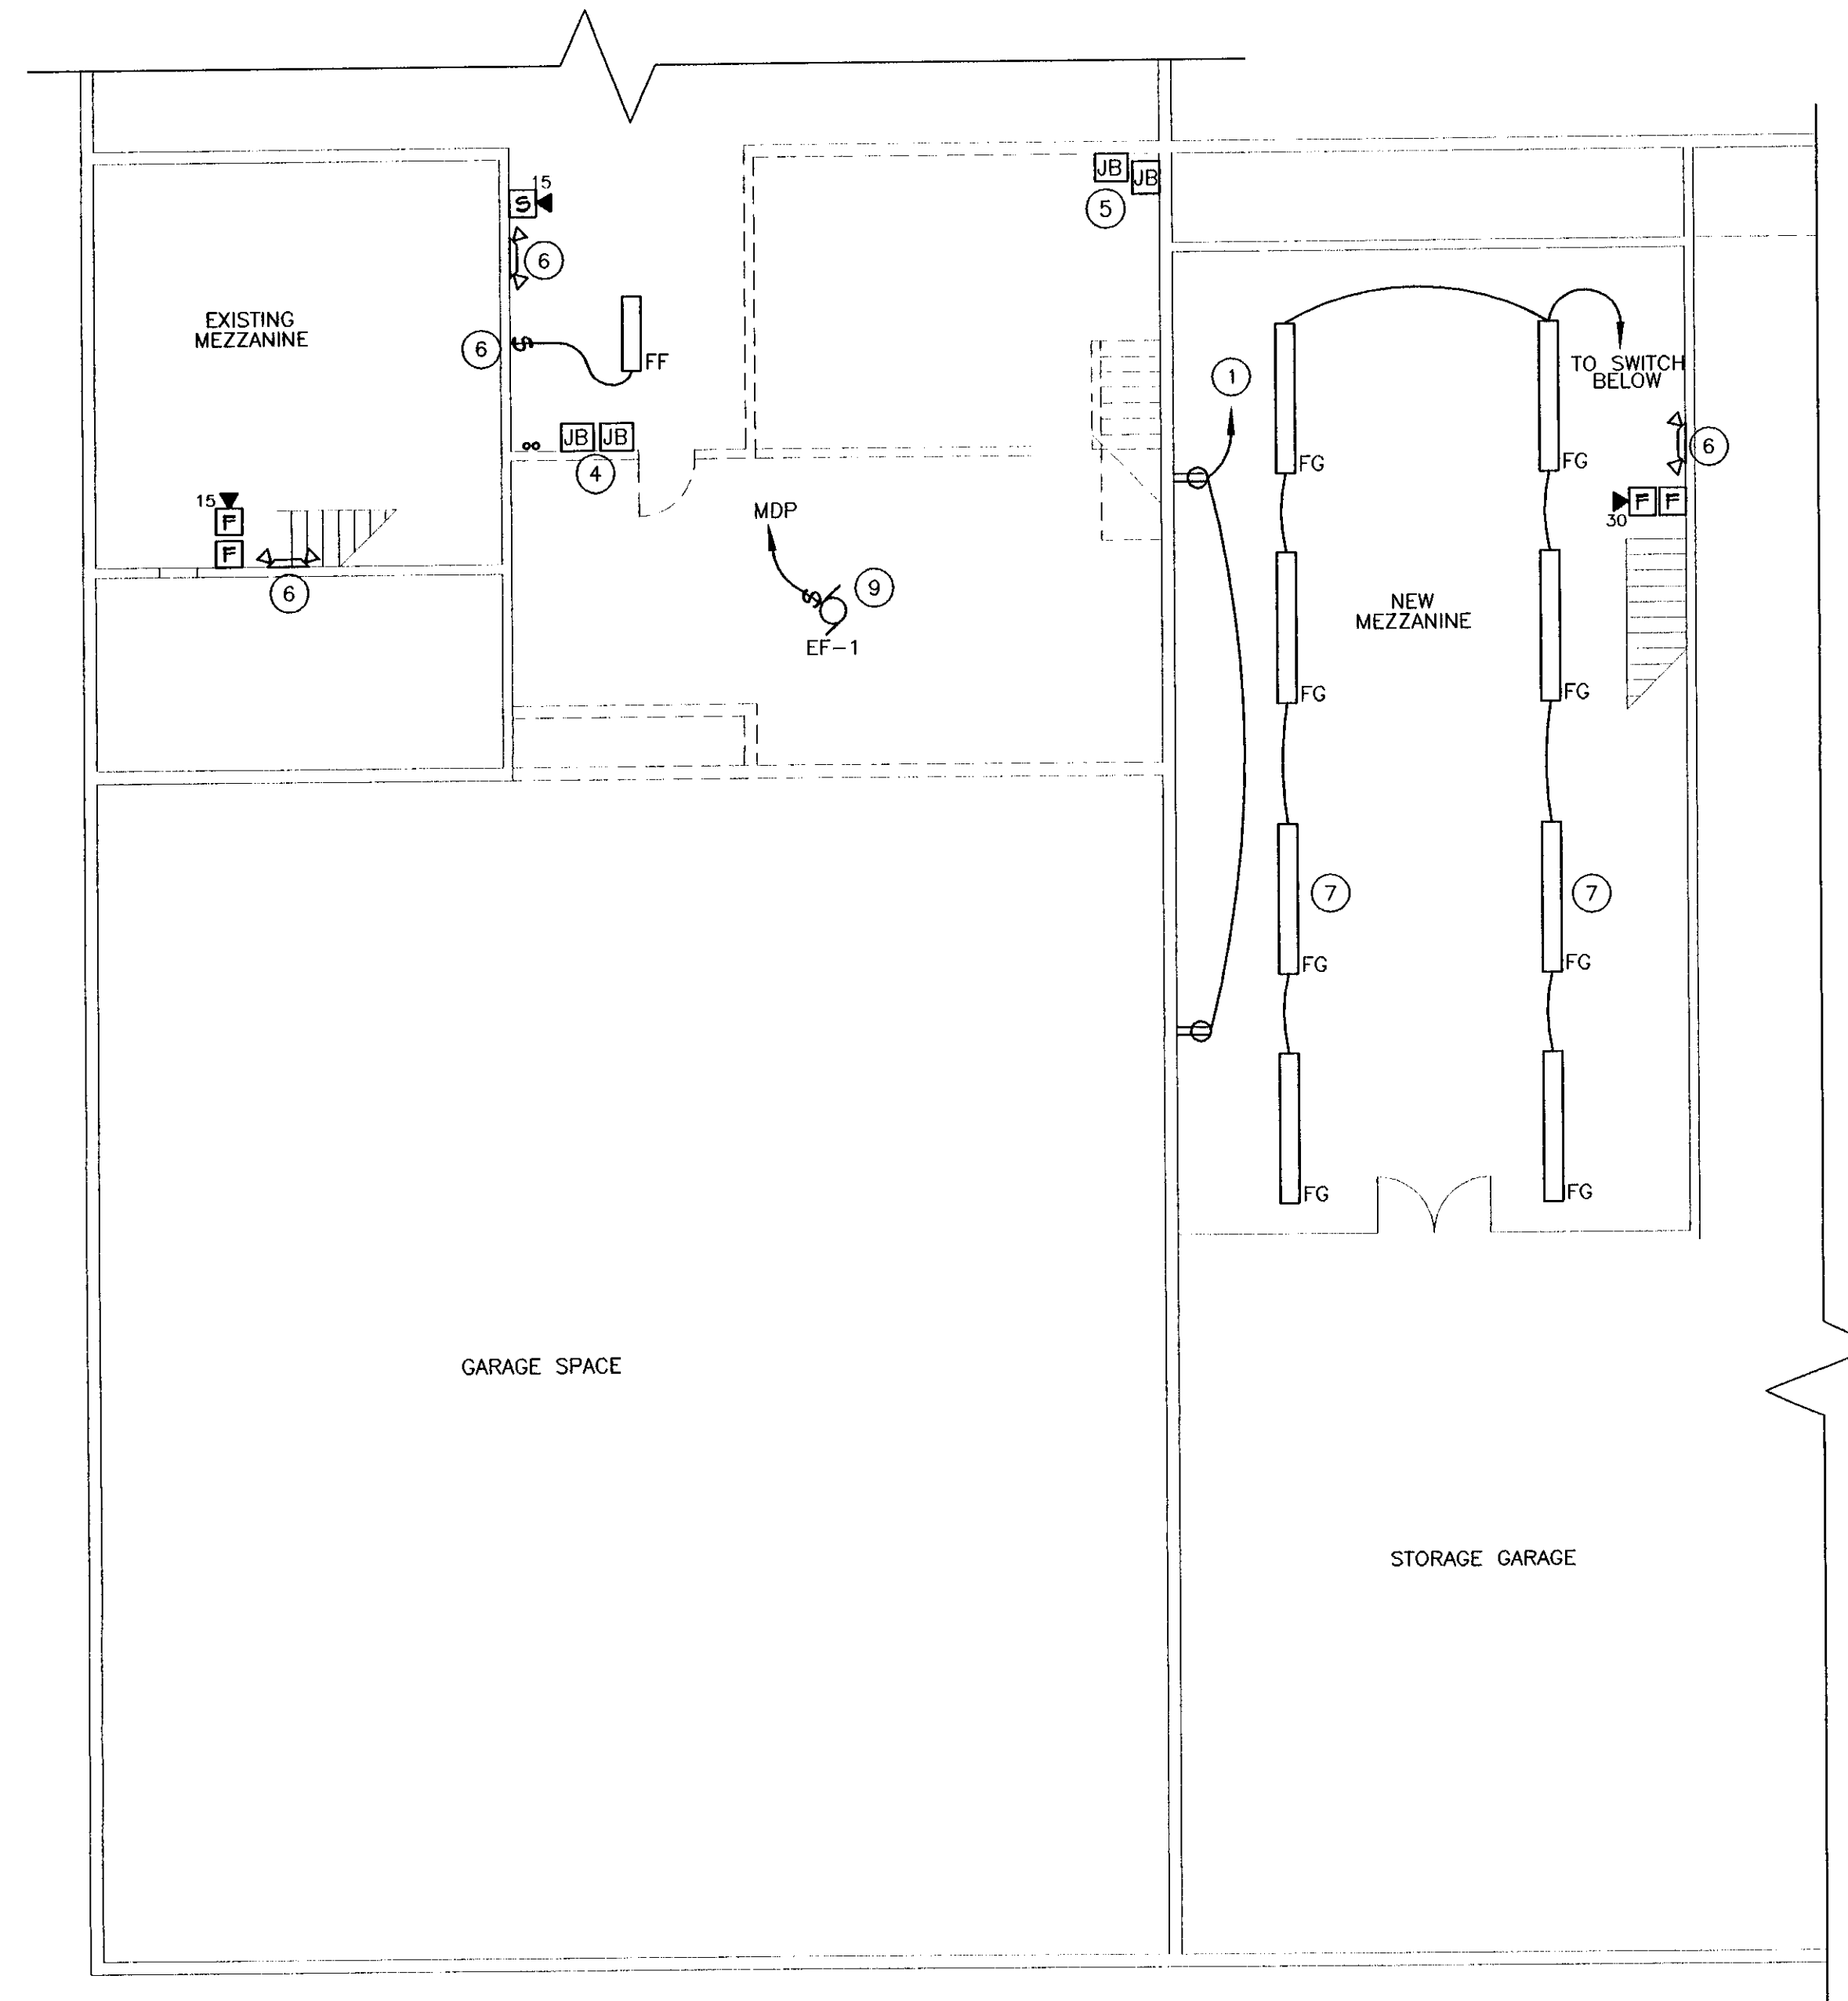


**MEZZANINE ELECTRICAL PLAN**

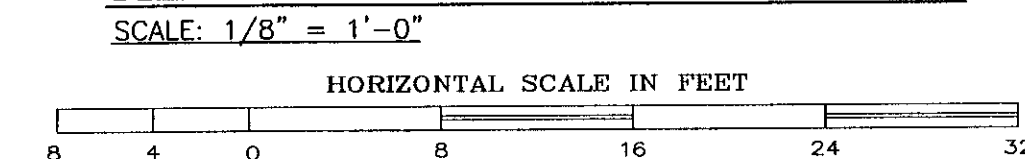


**GENERAL NOTES:** (APPLY TO ALL DRAWINGS)

- A. EQUIPMENT AND MATERIALS REMOVED OR DEMOLISHED AND NOT TO BE REINSTALLED BY THE EC SHALL BE CLASSIFIED BY THE OWNER AS SALVAGE OR SCRAP. THOSE CLAIMED BY THE OWNER SHALL BE DELIVERED TO THE OWNER BY THE EC WHERE DIRECTED AT THE SITE. THOSE NOT CLAIMED BY THE OWNER SHALL BECOME PROPERTY OF THE EC AND SHALL BE LEGALLY REMOVED FROM THE SITE AND PREMISES.
- B. ANY PLACE WHERE THE CONTRACTOR PENETRATES, CUTS AND/OR REMOVES WALLS, CONTRACTOR IS TO REPLACE, PATCH AND PAINT WALLS TO ORIGINAL FINISHES.
- C. FIELD VERIFY ALL DIMENSIONS BEFORE COMMENCEMENT OF WORK. NOTIFY ENGINEER OF ANY ERRORS. CONTRACTOR IS RESPONSIBLE FOR INSPECTING THE FACILITY PRIOR TO BID DATE. NO ADDITIONAL COMPENSATION SHALL BE PAID TO THE CONTRACTOR FOR FAILURE TO EXAMINE EXISTING CONDITIONS.
- D. REFER TO THE ARCHITECTURAL PLANS FOR EXTENT OF DEMOLITION WORK TO BE PERFORMED BY THE GENERAL CONTRACTOR. ALL ITEMS THAT NEED TO BE REMOVED BY THE GC SHALL HAVE THE POWER DISCONNECTED BY THE EC.
- E. NOT ALL DEVICES TO BE REMOVED OR DISCONNECTED ARE SHOWN. ALL EXISTING WIRING, ELECTRICAL DEVICES & EQUIPMENT SHALL BE COMPLETELY REMOVED. REFER TO ARCH. PLANS FOR TOTAL EXTENT OF DEMOLITION WORK.
- F. BUILDING IS EXISTING. WIRING IN EXTERIOR WALLS SHALL BE FISHED AS NECESSARY. SOME INTERIOR PARTITIONS ARE EXISTING. WIRING IN THESE WALLS MAY NEED TO BE FISHED. REFER TO ARCHITECTURAL PLANS FOR FULL EXTENT OF EXISTING CONDITIONS. NO SURFACE RACEWAY TO BE INSTALLED WITHOUT WRITTEN AUTHORIZATION FROM ARCHITECT.

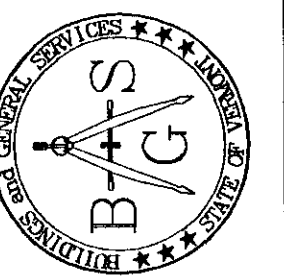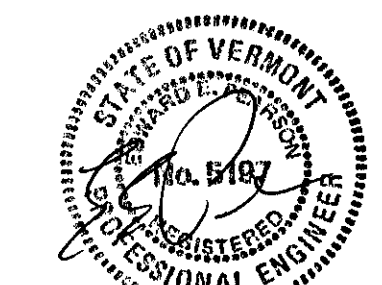

STATE OF VERMONT  
Department of Buildings  
and General Services  
Agency of Administration  
Montpelier, Vermont

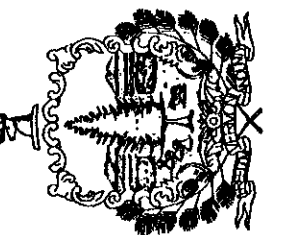

**Pearson & Associates**  
MECHANICAL & ELECTRICAL ENGINEERS  
P.O. BOX 610 STOWE, VERMONT 05672  
TEL (802) 253-9807 FAX (802) 253-9290  
EMAIL: pearson@stowvvt.net

AGENCY OF TRANSPORTATION  
BENNINGTON MAINTENANCE  
GARAGE & OFFICE RENOVATIONS  
BENNINGTON VERMONT

REVISIONS

SCALE: AS SHOWN  
DATE: JAN. 2004  
DRAWN BY: ASG  
APPR. BY: EEP

AGENCY OF TRANSPORTATION  
GARAGE & OFFICES  
MEZZANINE  
PLAN