



WATER 1/2" SANITARY PIPING PLAN
SCALE 1/8" = 1'-0"


PLUMBING SYMBOLS FOR PIPING, VALVES, & FITTINGS	
	COLD WATER PIPING
	HOT WATER PIPING
	WASTE PIPING
	VENT PIPING
	FLOW DIRECTION
	GATE VALVE
	CHECK VALVE
	BACKFLOW PREVENTER
	PRESSURE & TEMP. RELIEF VALVE
	WATER HAMMER ARRESTOR
	UNION
	HOSE BIBB
	P-TRAP
	FLOOR DRAIN w/ P-TRAP
	TOILET FLANGE
	FLOOD CLEANOUT (WALL)
	CLEANOUT (FLOOR)

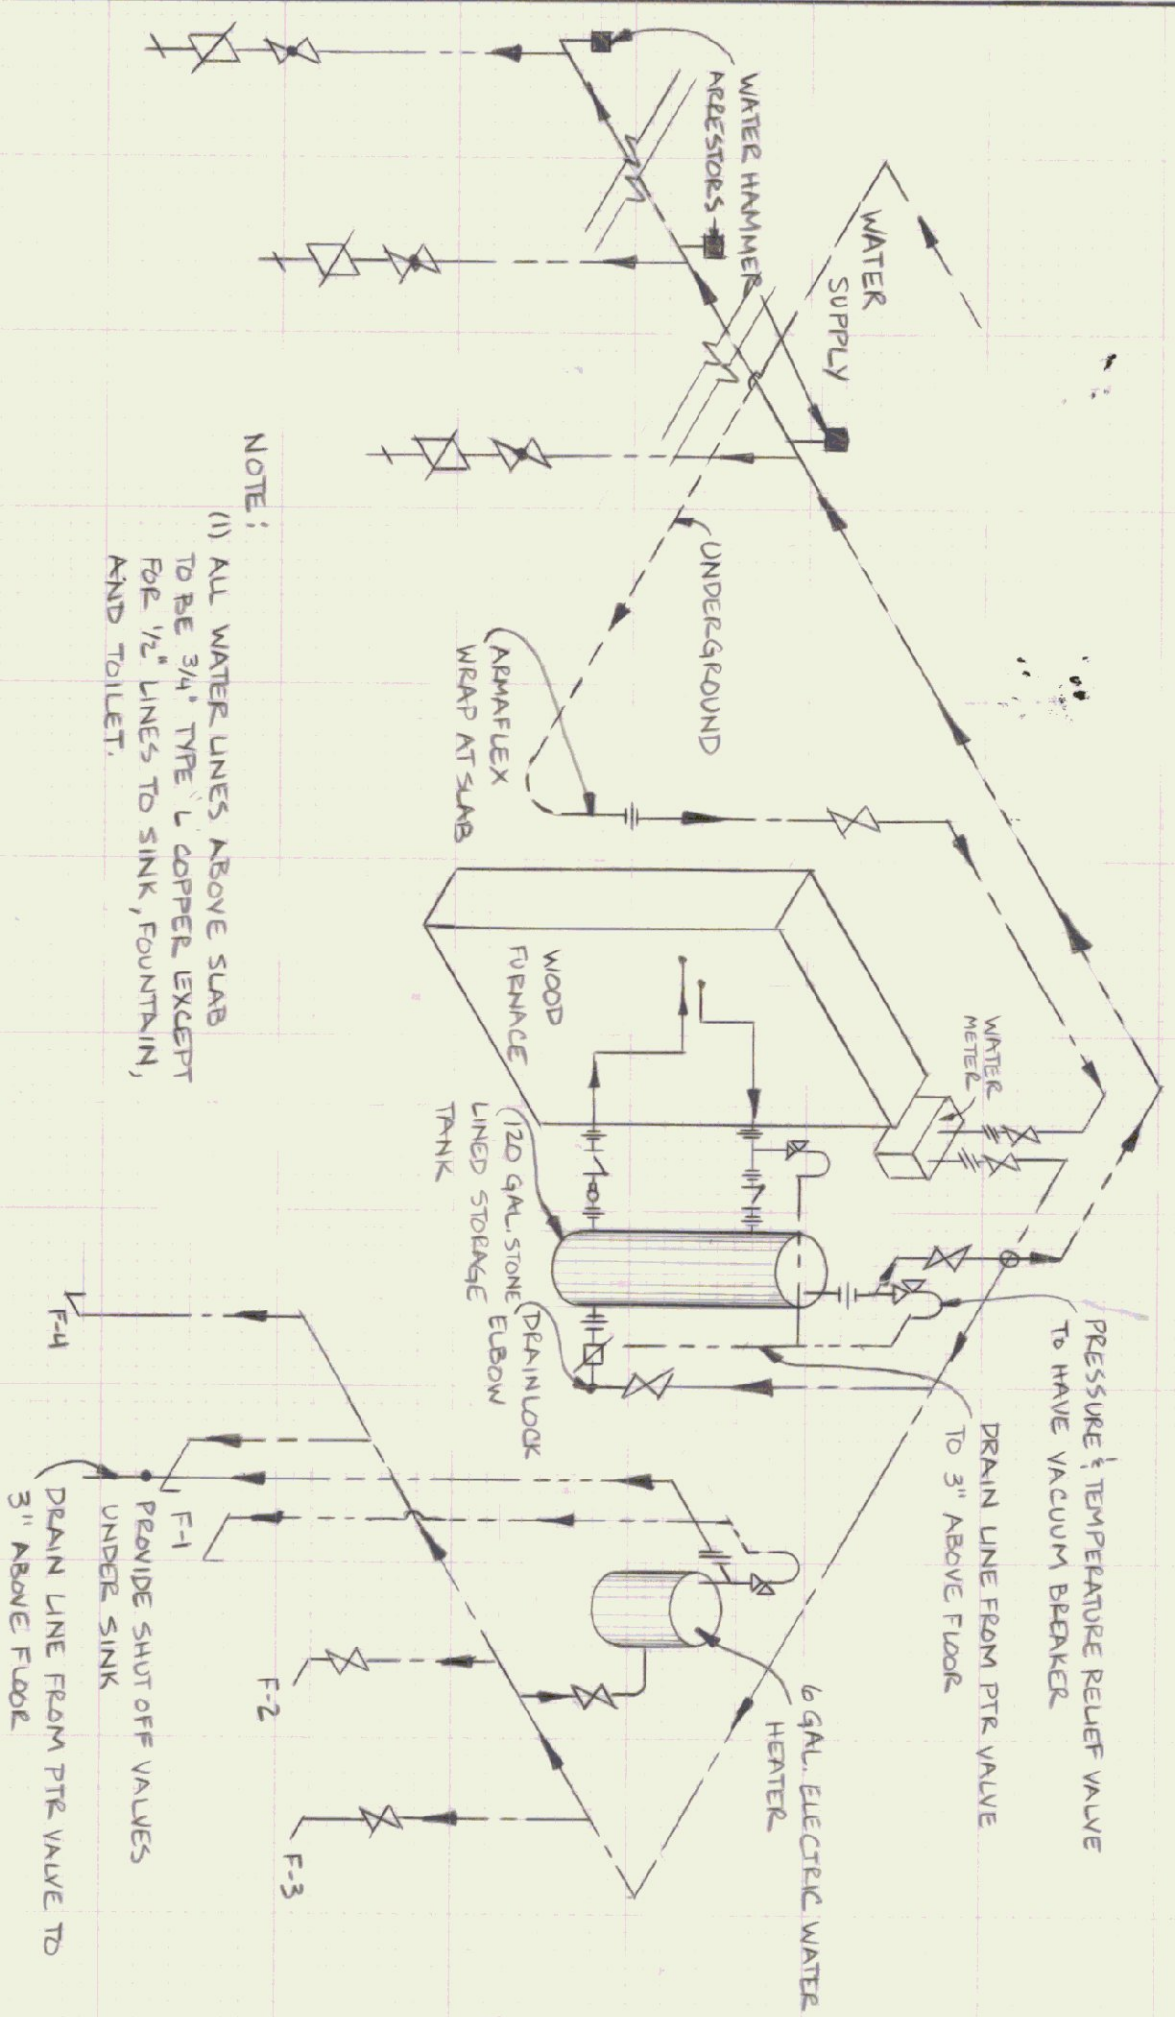

HOT 1/2" COLD WATER PIPING RISER DIAGRAM
NOT TO SCALE

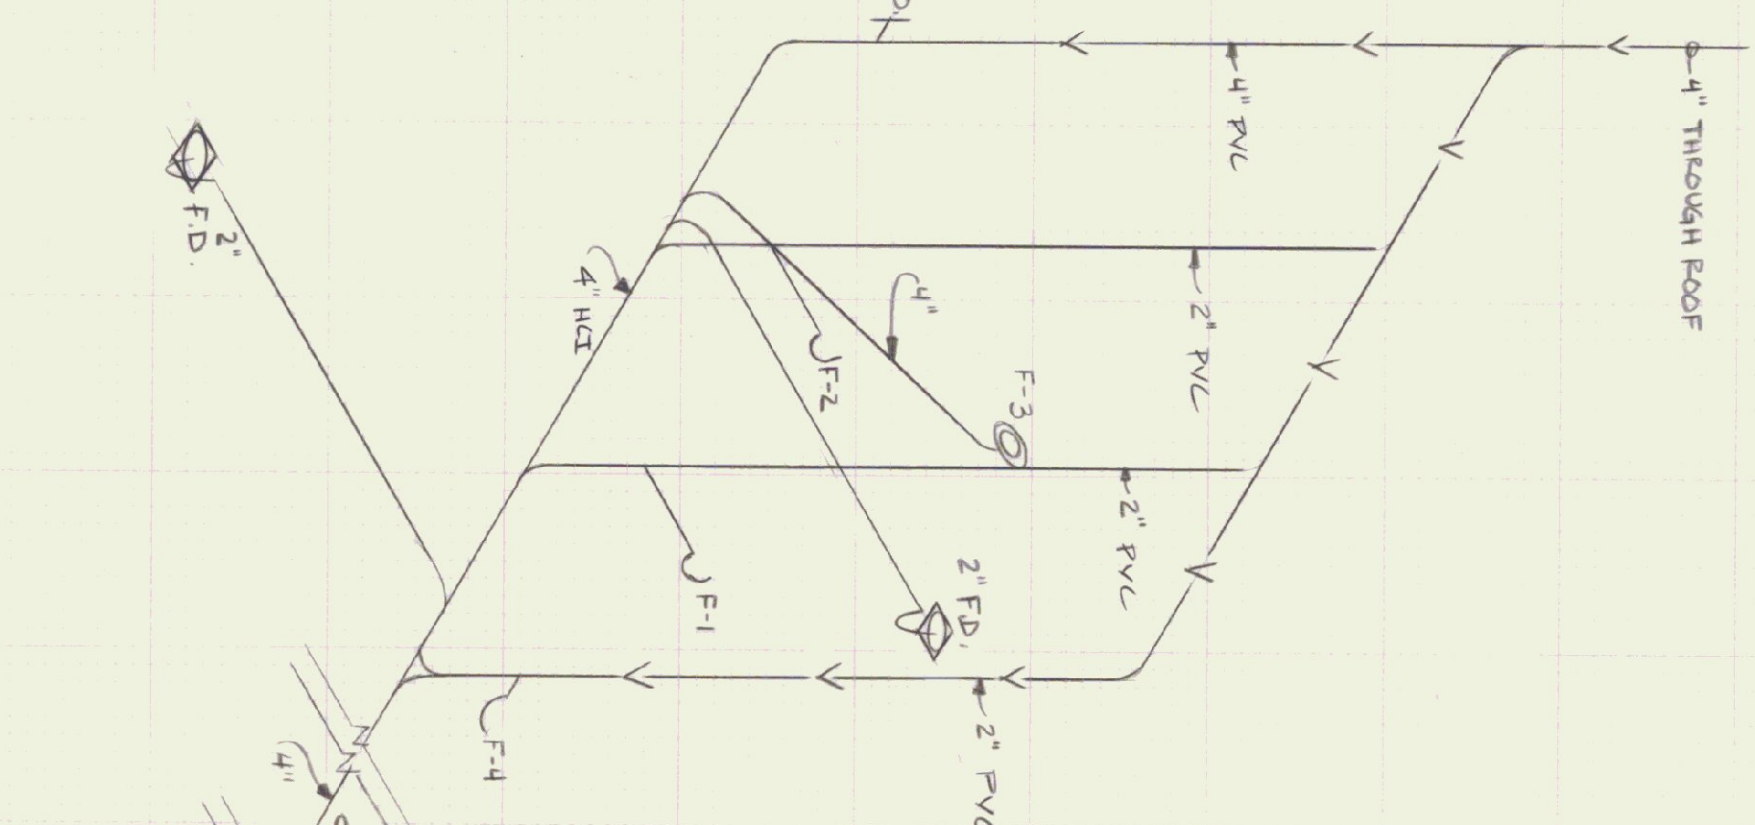

SANITARY WASTE 1/2" VENT PIPE RISER DIAGRAM
NOT TO SCALE

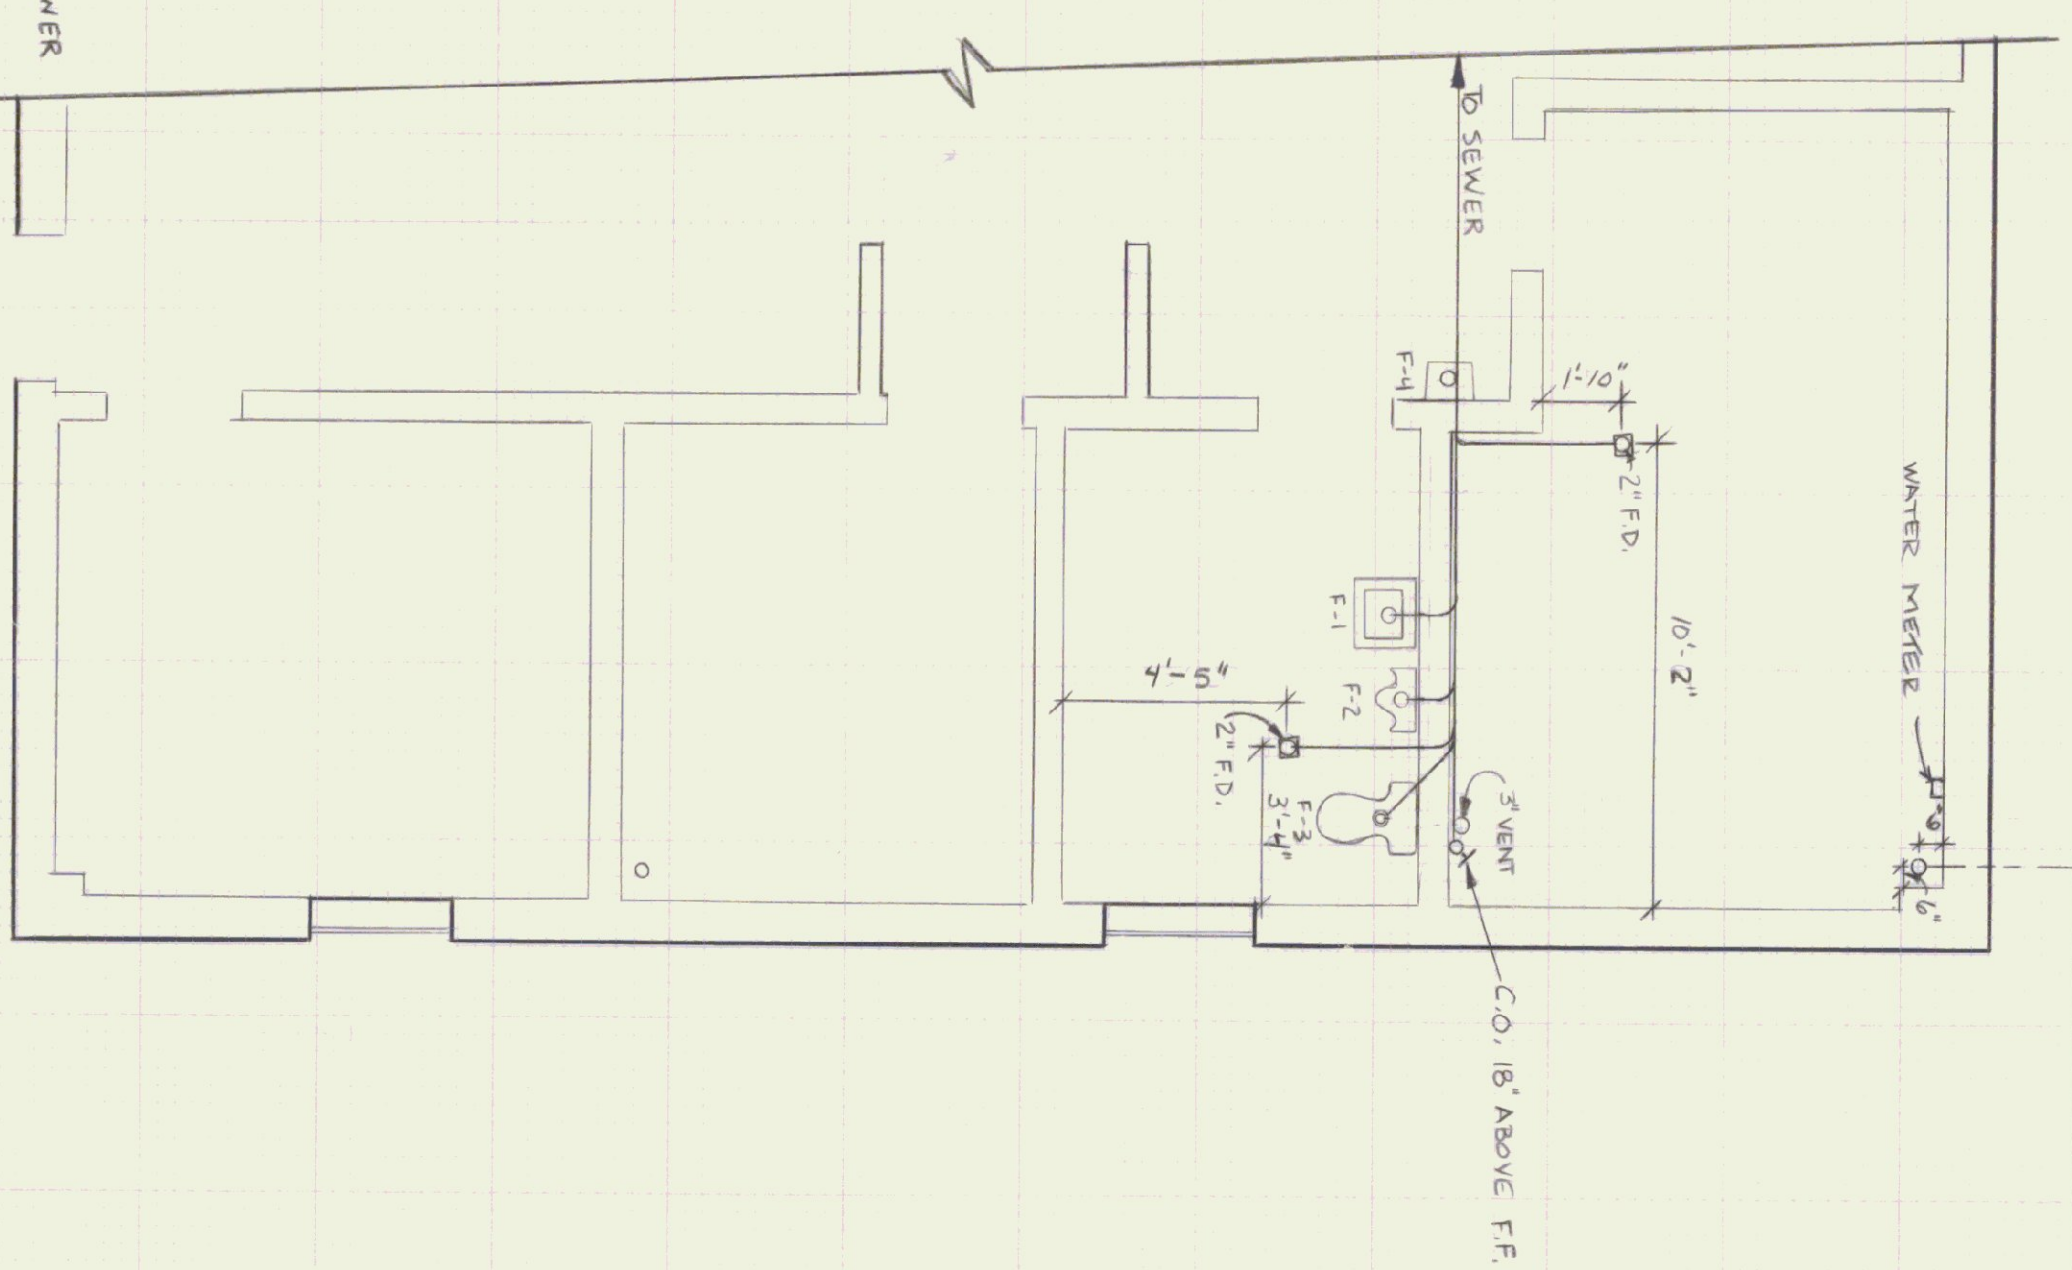

SANITARY WASTE 1/2" VENT PLAN
SCALE 1/4" = 1'-0"

- FIGURE SCHEDULE**
- F-1 WALL MOUNTED CERAMIC LAVATORY.
 - F-2 WALL MOUNTED URINAL WITH VACUUM BREAKER OR FLUSH VALVE.
 - F-3 FLOOR MOUNTED CERAMIC TOILET FIXTURE WITH ELONGATED FRONT (18" HIGH)
 - F-4 WALL MOUNTED DRINKING FOUNTAIN

STATE OF VERMONT			
DEPARTMENT OF STATE BUILDINGS			
AGENCY OF ADMINISTRATION			
MONTPELIER, VERMONT			
PLUMBING PLAN			
6 BAY MAINTENANCE GARAGE			
EAST DORSSET			
DATE:	SCALE:	REVISIONS:	DWG. NO.:
15 APRIL, 1990	A-S NOTED		P-1
DRAWN BY:	APPROVED BY:		
T. McCune	T. Hall		
			19 OF 22