


MECHANICAL PLAN
SCALE 1/4" = 1'-0"

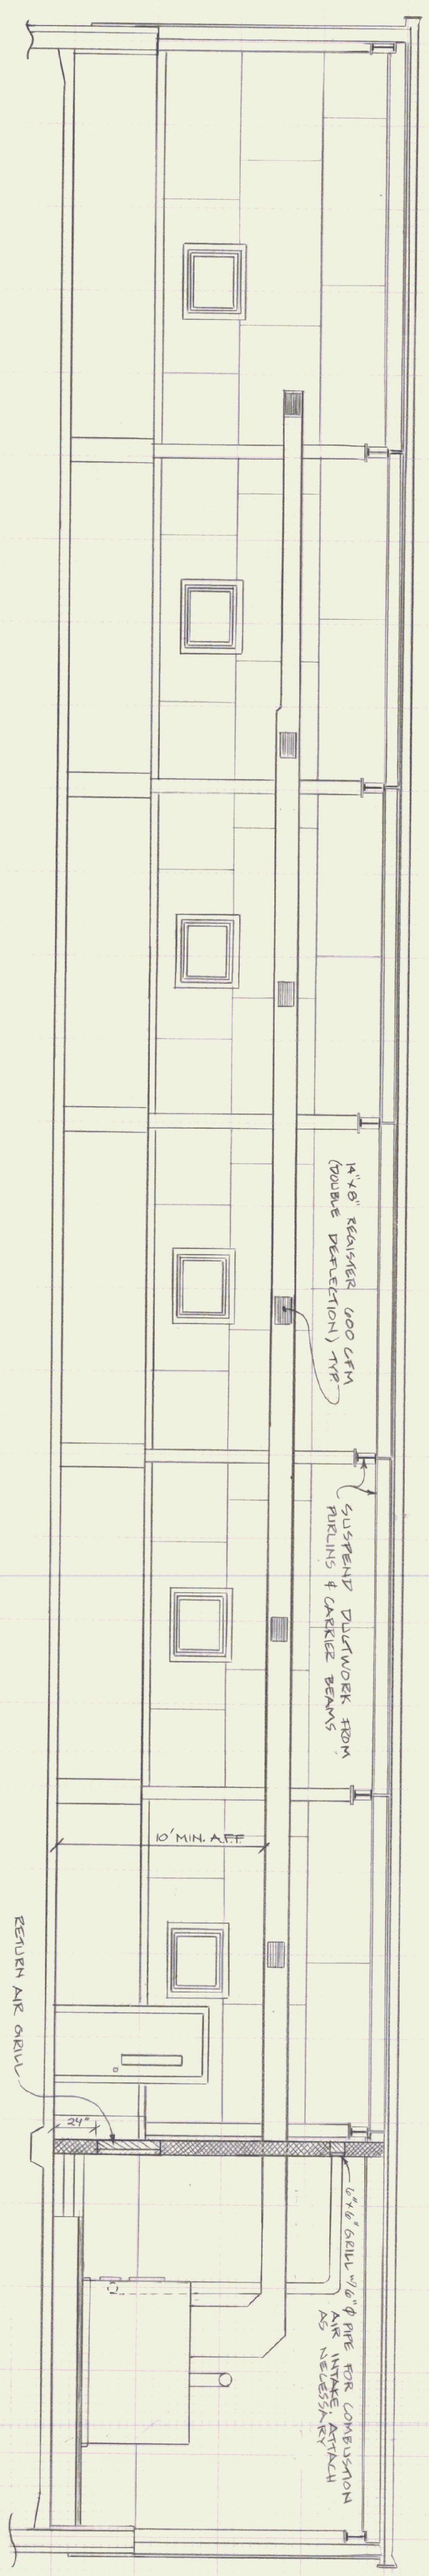

FURNACE & DUCTWORK ELEVATION
SCALE 1/4" = 1'-0"

- NOTES:
- 1) FURNACE BLOWER MODEL 15 HP 115/230 V
 - 2) STORAGE TANK FOR HOT WATER FROM FURNACE SHALL HAVE BRONZE CIRCULATING PUMP-WORK LOOP FROM TANK TO FURNACE.
 - 3) ALL JOINTS IN FUEL OIL LINE TO BE FLARED ALL SOLDERED JOINTS TO BE SWEATED WITH SILVER SOLDER.

STATE OF VERMONT
DEPARTMENT OF STATE BUILDINGS
AGENCY OF ADMINISTRATION
MONTPELIER, VERMONT

HEATING PLAN
AGENCY OF TRANSPORTATION
6 BAY MAINTENANCE GARAGE
EAST IDERSET
VERMONT

DATE	SCALE	REVISIONS	DWG NO
15 APRIL, 1990	AS NOTED		H-1
DRAWN BY	APPROVED BY		
F. PRATT			20 OF 22