


MECHANICAL LEGEND & ABBREVIATIONS


- ⊕ BALL VALVE
- PIPE RISER
- PIPE DROP
- PIPE CAP
- FOS FUEL OIL SUPPLY, E = EXISTING
- FOR FUEL OIL RETURN E = EXISTING
- LP GAS PIPING
- ⊕ LP GAS REGULATOR
- ⊕ THERMOSTAT
- ⊕ EXISTING THERMOSTAT TO BE REMOVED
- St SWITCH, SUBSCRIPT: T = TIMER
- NEW DUCTWORK
- - - EXISTING DUCTWORK TO BE REMOVED
- ⊗ SUPPLY DUCT DOWN
- ⊗ SUPPLY DUCT UP
- FLEXIBLE DUCT CONNECTOR
- AIR FLOW INDICATOR
- VOLUME DAMPER
- M.D. MOTORIZED DAMPER
- FD FIRE DAMPER
- E.C. ELECTRICAL CONTRACTOR
- G.C. GENERAL CONTRACTOR
- G.U.H. GAS FIRED UNIT HEATER
- ⊕ CONNECT TO EXISTING
- ① DRAWING NOTE TAG
- ⊕ DEMOLITION NOTE TAG
- ⊕ LOUVER
- ⊕ SUPPLY DIFFUSER
- ⊕ GAS FIRED UNIT HEATER
- ⊕ EQUIPMENT TYPE E=EXISTING
- ⊕ SECTION NUMBER
- ⊕ DWG. NUMBER

DEMOLITION NOTES: (APPLY TO THIS DRAWING ONLY)


- 1] OWNER TO REMOVE EXISTING DUCTWORK AND DUCT HANGERS.
- 2] OWNER TO REMOVE EXISTING WOOD FIRED FURNACE AND FLUE. CONTRACTOR TO CAP AND SEAL FLUE CONNECTOR AT CHIMNEY.
- 3] OWNER TO REMOVE EXISTING OIL FIRED FURNACE AND FLUE. OWNER TO PATCH ROOF.
- 4] CONTRACTOR TO REMOVE EXISTING FUEL OIL SUPPLY AND RETURN LINES AND TRANSFER PUMP. CONTRACTOR TO CAP FUEL OIL SUPPLY AND RETURN LINES FROM OIL TANK. UNDERGROUND FOS AND FOR LINES TO TANK TO BE ABANDONED IN PLACE.
- 5] OWNER TO REMOVE EXISTING THERMOSTAT FOR WOOD FIRED FURNACE, INCLUDING ASSOCIATED WIRING.
- 6] OWNER TO REMOVE EXISTING THERMOSTAT FOR OIL FIRED FURNACE, INCLUDING ASSOCIATED WIRING.
- 7] CONTRACTOR TO REMOVE EXISTING DOMESTIC HOT WATER HEATER. SALVAGE AND RETURN TO OWNER.
- 8] CONTRACTOR TO REMOVE EXISTING DOMESTIC HOT WATER PIPING, PUMP, VALVES AND ASSOCIATED SPECIALTIES.
- 9] OWNER TO REMOVE EXISTING LOUVER.
- 10] OWNER TO REMOVE EXISTING WALL AS REQUIRED TO REMOVE WOOD FIRED FURNACE. SALVAGE DOOR AND FRAME FOR INSTALLATION IN NEW WALL.
- 11] CONTRACTOR TO REMOVE ELECTRIC HEATER, THERMOSTAT AND ASSOCIATED WIRING AND CONDUIT BACK TO JUNCTION BOX.

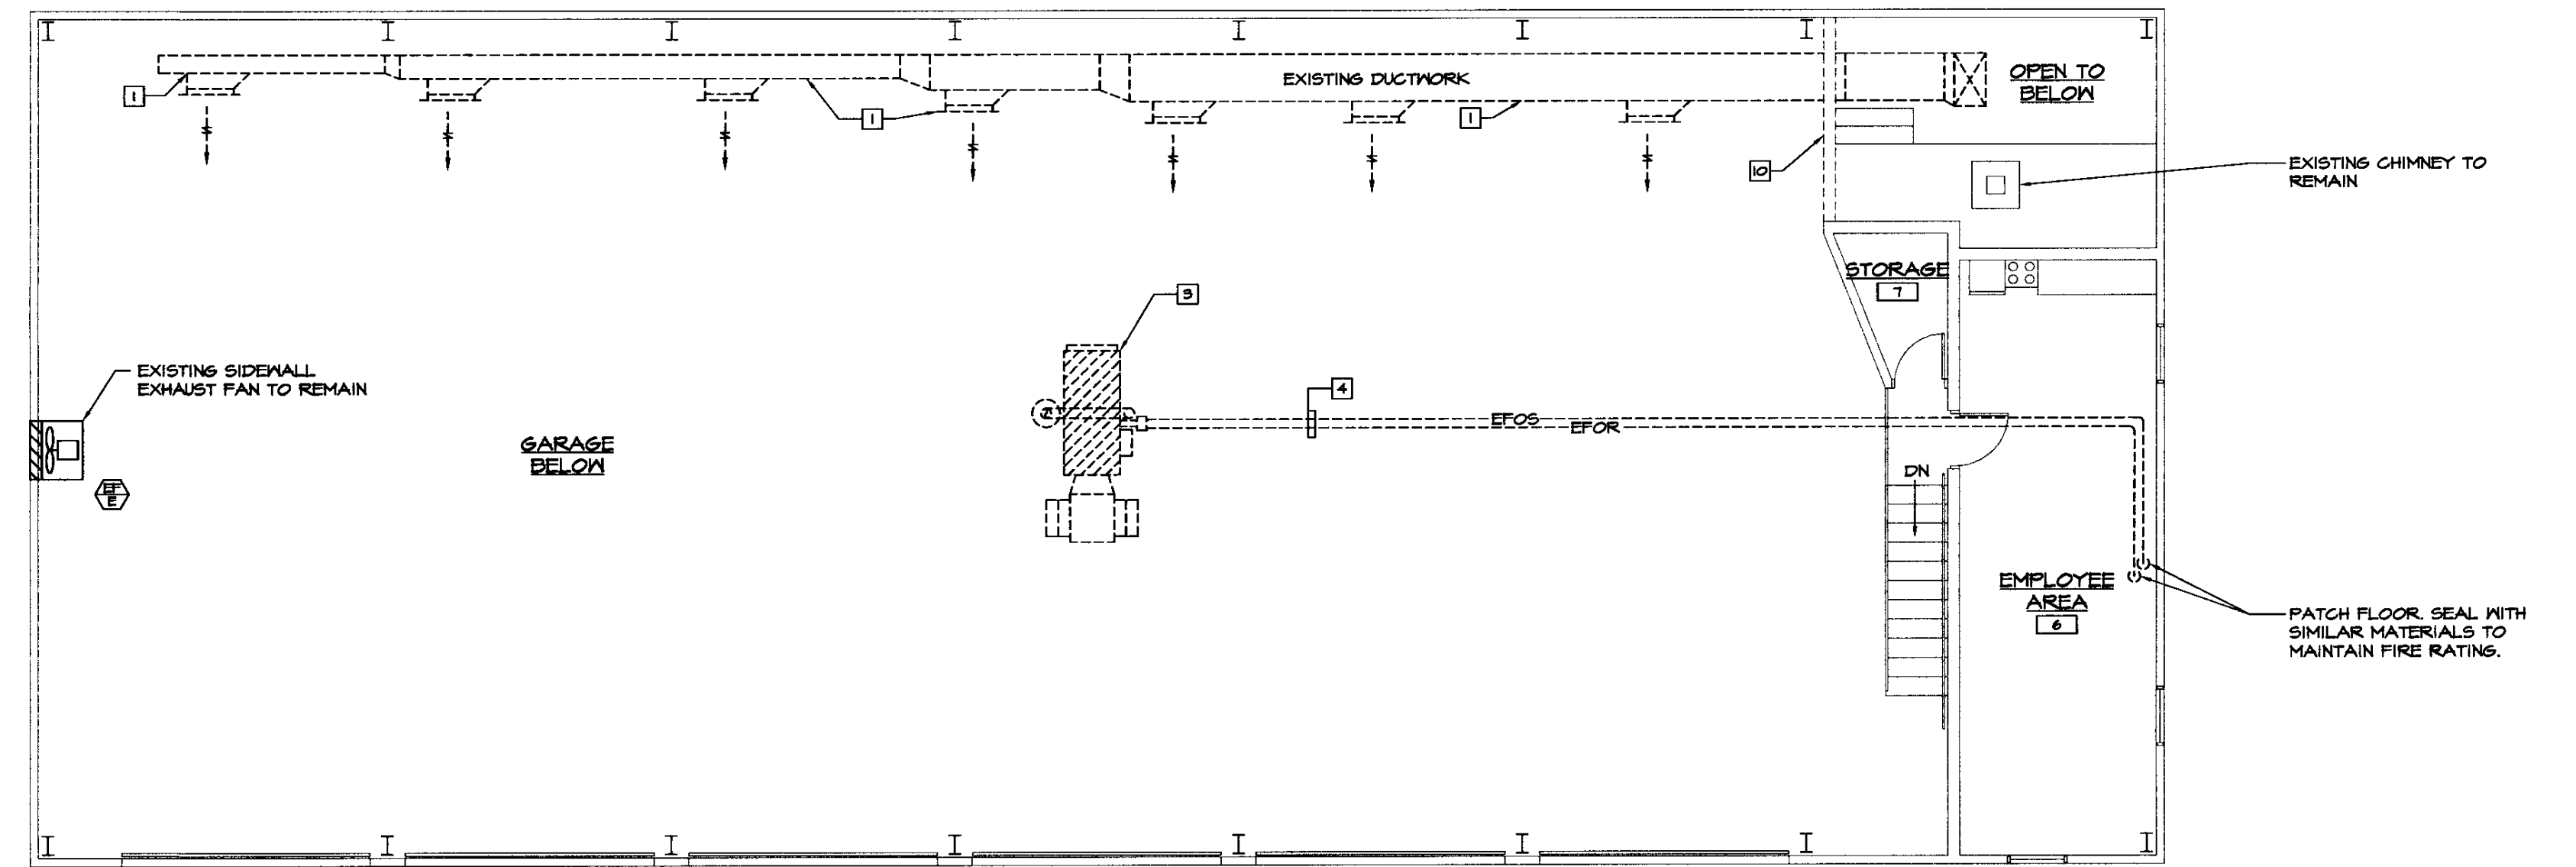

MEZZANINE FLOOR PLAN - MECHANICAL DEMOLITION
SCALE: 1/8"=1'-0"

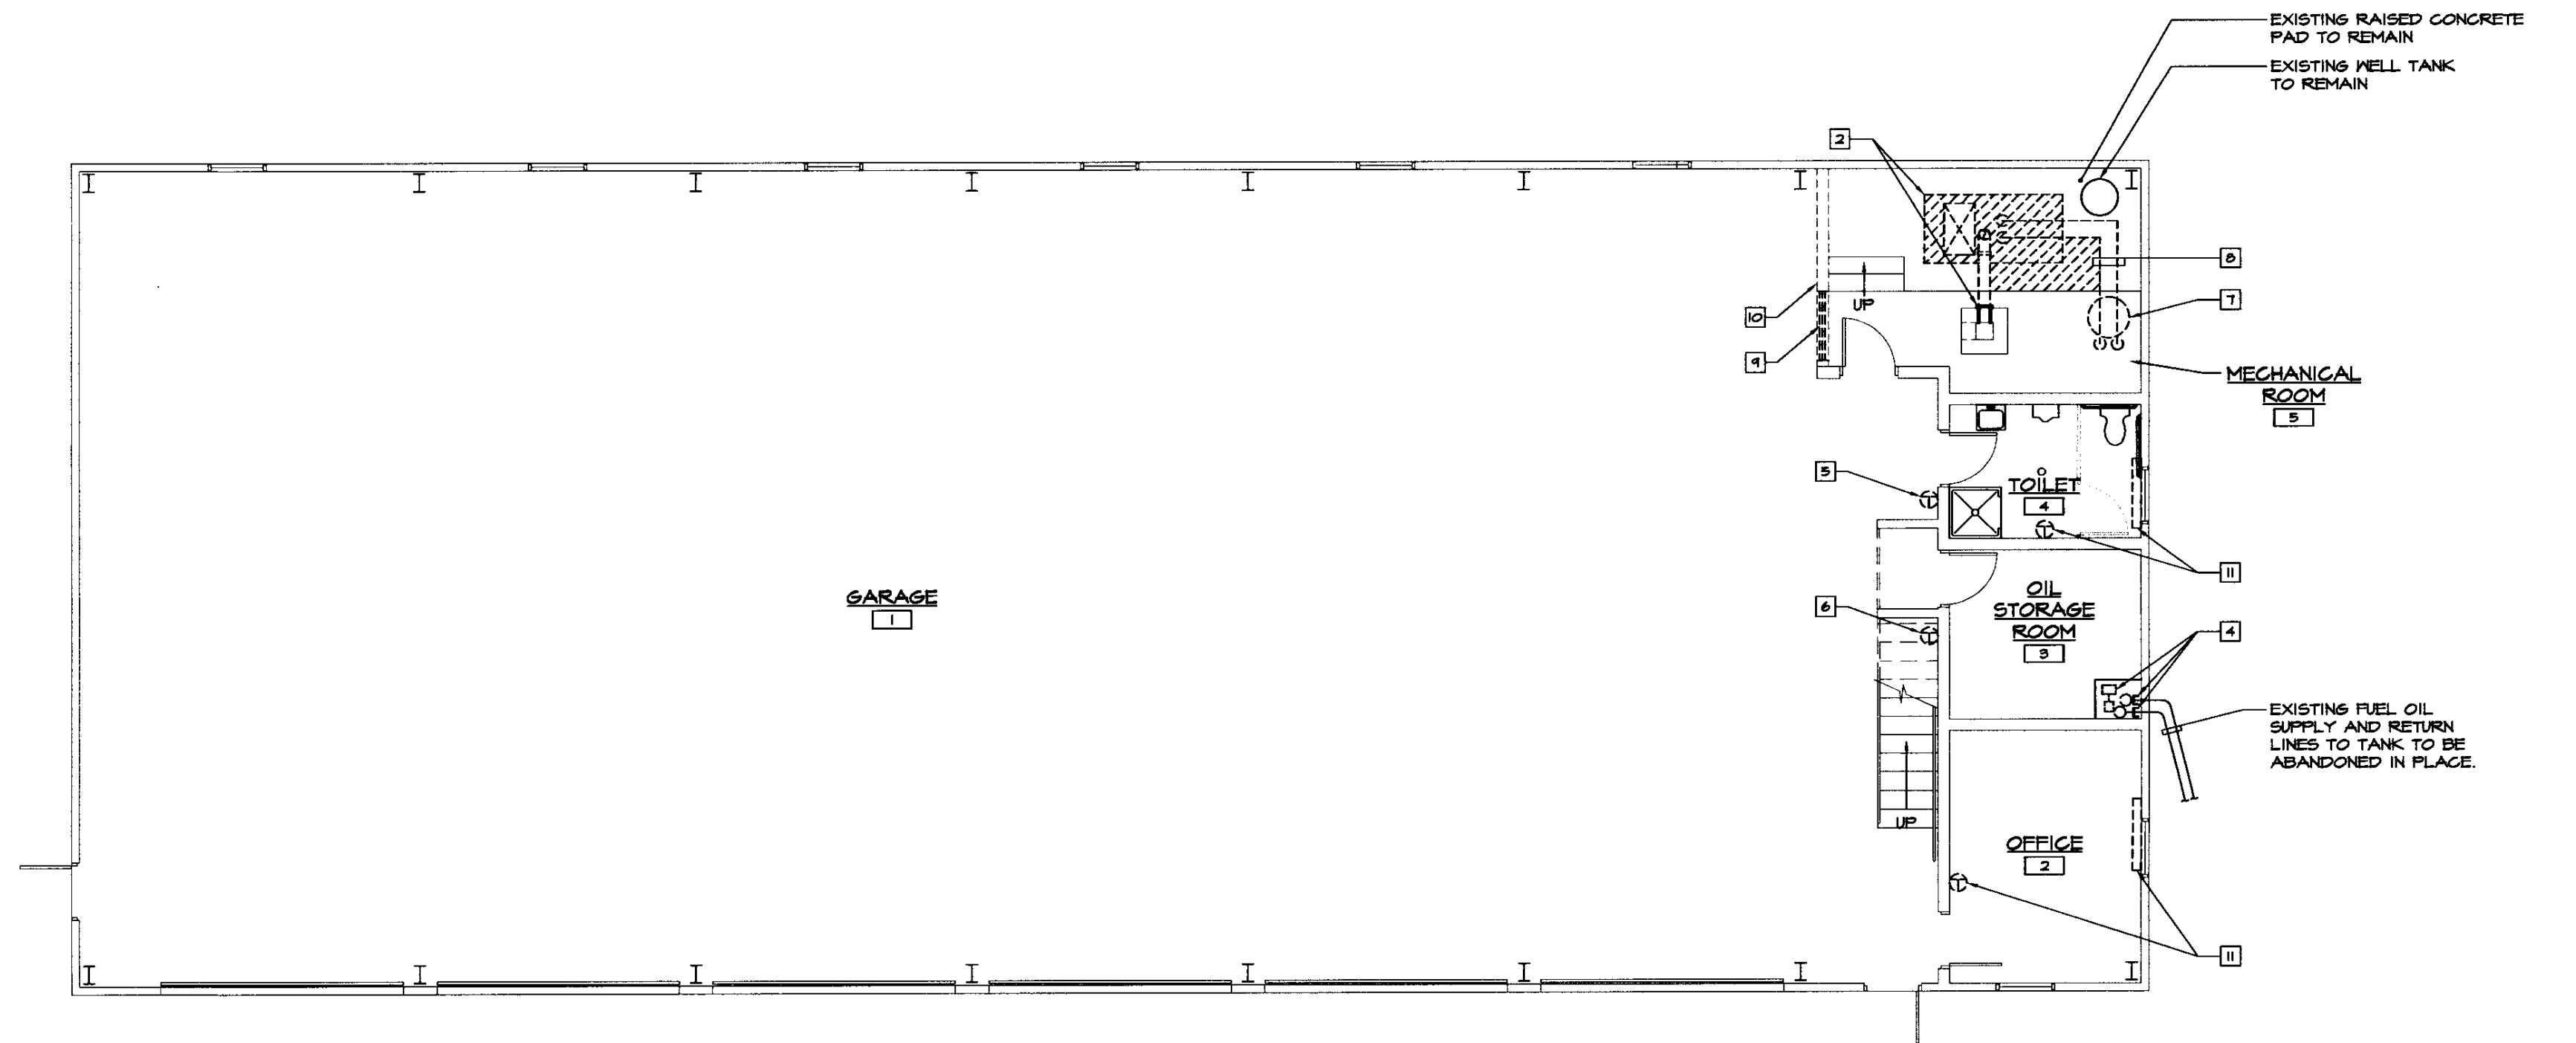

MAIN FLOOR PLAN - MECHANICAL DEMOLITION
SCALE: 1/8"=1'-0"

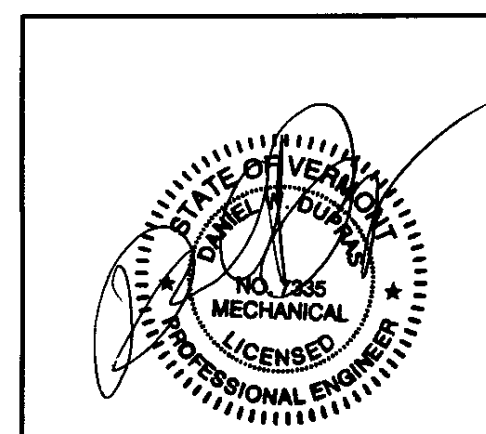

NO.	ISSUED FOR	DATE
1	BIDDING AND CONSTRUCTION	07/2005



HEATING, VENTILATION, & AIR CONDITIONING,
PLUMBING, FIRE PROTECTION, & ELECTRICAL

DANIEL W. DUPRAS, P.E.
DANIEL W. DUPRAS, P.E.

51 KILLINGTON AVENUE,
RUTLAND, VERMONT 05701
TELEPHONE: (802)747-3346
FAX/MODEM: (802)747-3356

FLOOR PLANS - MECHANICAL DEMOLITION			
EAST DORSET AOT GARAGE VERMONT AGENCY OF TRANSPORTATION EAST DORSET, VERMONT			
APPR.	DWD	DRAWN:	TDL/KPC
SCALE:		AS NOTED	
PROJ. NO.		0312-17	

M
1