


2 INTERIOR ELEVATION/SECTION (LOOKING TOWARDS #1 COLUMN LINE)

1/4\"/>

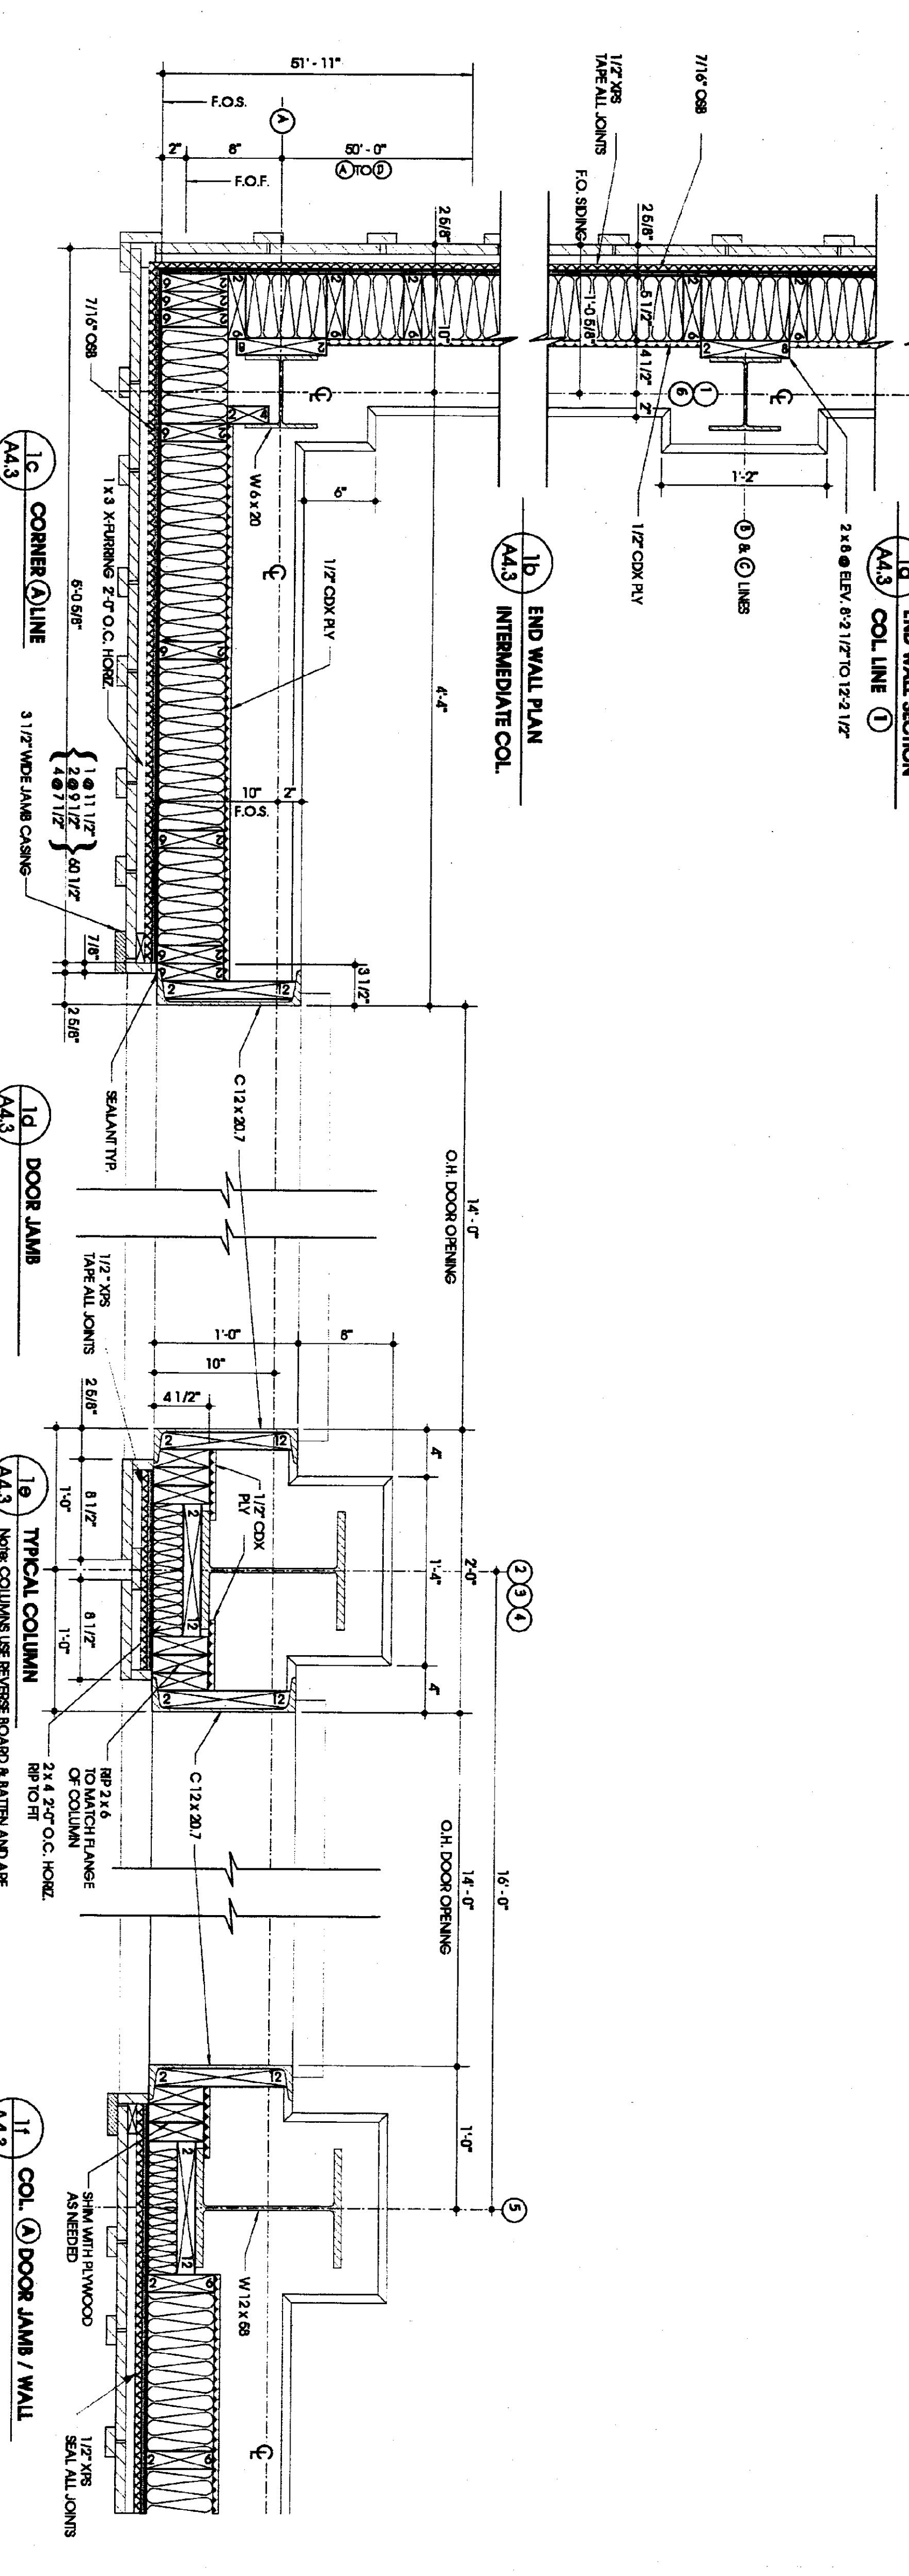

1 WALL SECTION/PLAN SECTION

1/4\"/>

The Design Studio of  
**LineSync Architecture**  
 14 Corbin Hill Washington Vermont 05485 9745 USA  
 V.802.444.2526 / F.2.028  
 www.linesync.com

- STATE HIGHWAY GARAGE GENERAL NOTES**
- PROJECT TO CONFORM TO LOCALITIES WITH THE NATIONAL FIRE MARSHAL SERVICE AND THE NATIONAL ELECTRICAL CODE AND THE REQUIREMENTS OF THE STATE OF VERMONT. THE JURISDICTION SHALL APPLY TO THE PROJECT OWNER BUSINESS (SIMILAR TO FIRE STATION).
  - THE CONTRACTOR SHALL VERIFY CONDITIONS AND DIMENSIONS IN FIELD PRIOR TO SUBSTITUTION.
  - ALL BRACING IN CONTACT WITH CONCRETE AND MASONRY TO BE PROTECTED WITH 1/2\"/>
- PROJECT DRAWING LIST**
- CIVIL BY DERRINGER, BERRY
  - CF1 SITE PLAN
  - CF2 LAYOUT PLAN
  - CF3 ROAD PROFILES
  - CF4.5.6.7 ROAD CROSS SECTIONS
  - CF8.9 SITE DETAILS
  - CF10.11.12 SITE DETAILS
- GARAGE & OFFICE BY LINENSYNCH ARCHITECTURE**
- GA1 SITE PLAN LOCATION MAP & PERMITS
  - GA2 ELEVATIONS
  - GA3 1ST FLOOR PLAN
  - GA4 2ND FLOOR PLAN
  - GA5 INTERIOR ELEVATIONS & SECTIONS
  - GA6 WALL SECTIONS & DETAILS
  - GA7 WINDOW & FAIR DETAILS
- GARAGE STRUCTURAL BY BALMAIN ASSOCIATES**
- BS1 GEN STRUCT NOTES & STANDARD DETAILS
  - BS2 FOUNDATION PLAN
  - BS3 ROOF PLAN
  - BS12 STRUCTURAL SECTIONS & DETAILS
  - BS13 STANDARD STRUCTURAL DETAILS
- ELECTRICAL BY DERRINGER, BERRY**
- BE1 ELECTRICAL SITE PLAN
  - BE2 FIRST FLOOR PLAN (INCLUDES MEZ.)
- GARAGE MECHANICAL BY DERRINGER, BERRY**
- ME1 MECHANICAL NOTES
  - ME2 GARAGE MECHANICAL SCHEDULES
  - ME3 A.O.T. 24\"/>
- MECHANICAL BY DERRINGER, BERRY**
- P-1 VENTILATION SYSTEM PLANS & DETAILS

**ATNSF**  
 AGENCY OF TRANSPORTATION  
 STORAGE FACILITY PROJECT

RENDERBOARD, VERMONT

**INTERIOR ELEVATIONS & WALL SECTION**

DATE: 07 FEB 02  
 DRAWING NUMBER: 0113  
 PROJECT NUMBER: 17 JUNE 2001

17 JUNE 2001