


ESTIMATE OF SEWAGE FLOW		PERCOLATION TEST RESULTS			
Run	Hole #1	Hole #2	Hole #3	Hole #4	Percolation Rate: Minutes for Leaching
1	3 MIN.	4 MIN.	2 MIN.		
2	3 MIN.	4 MIN.	3 MIN.		
3	3 MIN.	4 MIN.	3 MIN.		
4	3 MIN.	4 MIN.	3 MIN.		
5	3:20	9:20	9:30		
6	9:55	9:55	10:00		

NOTE: PERCOLATION TESTS BY G.W. AYERS, P.E., 1102 DIST. ENGR., BENNINGTON

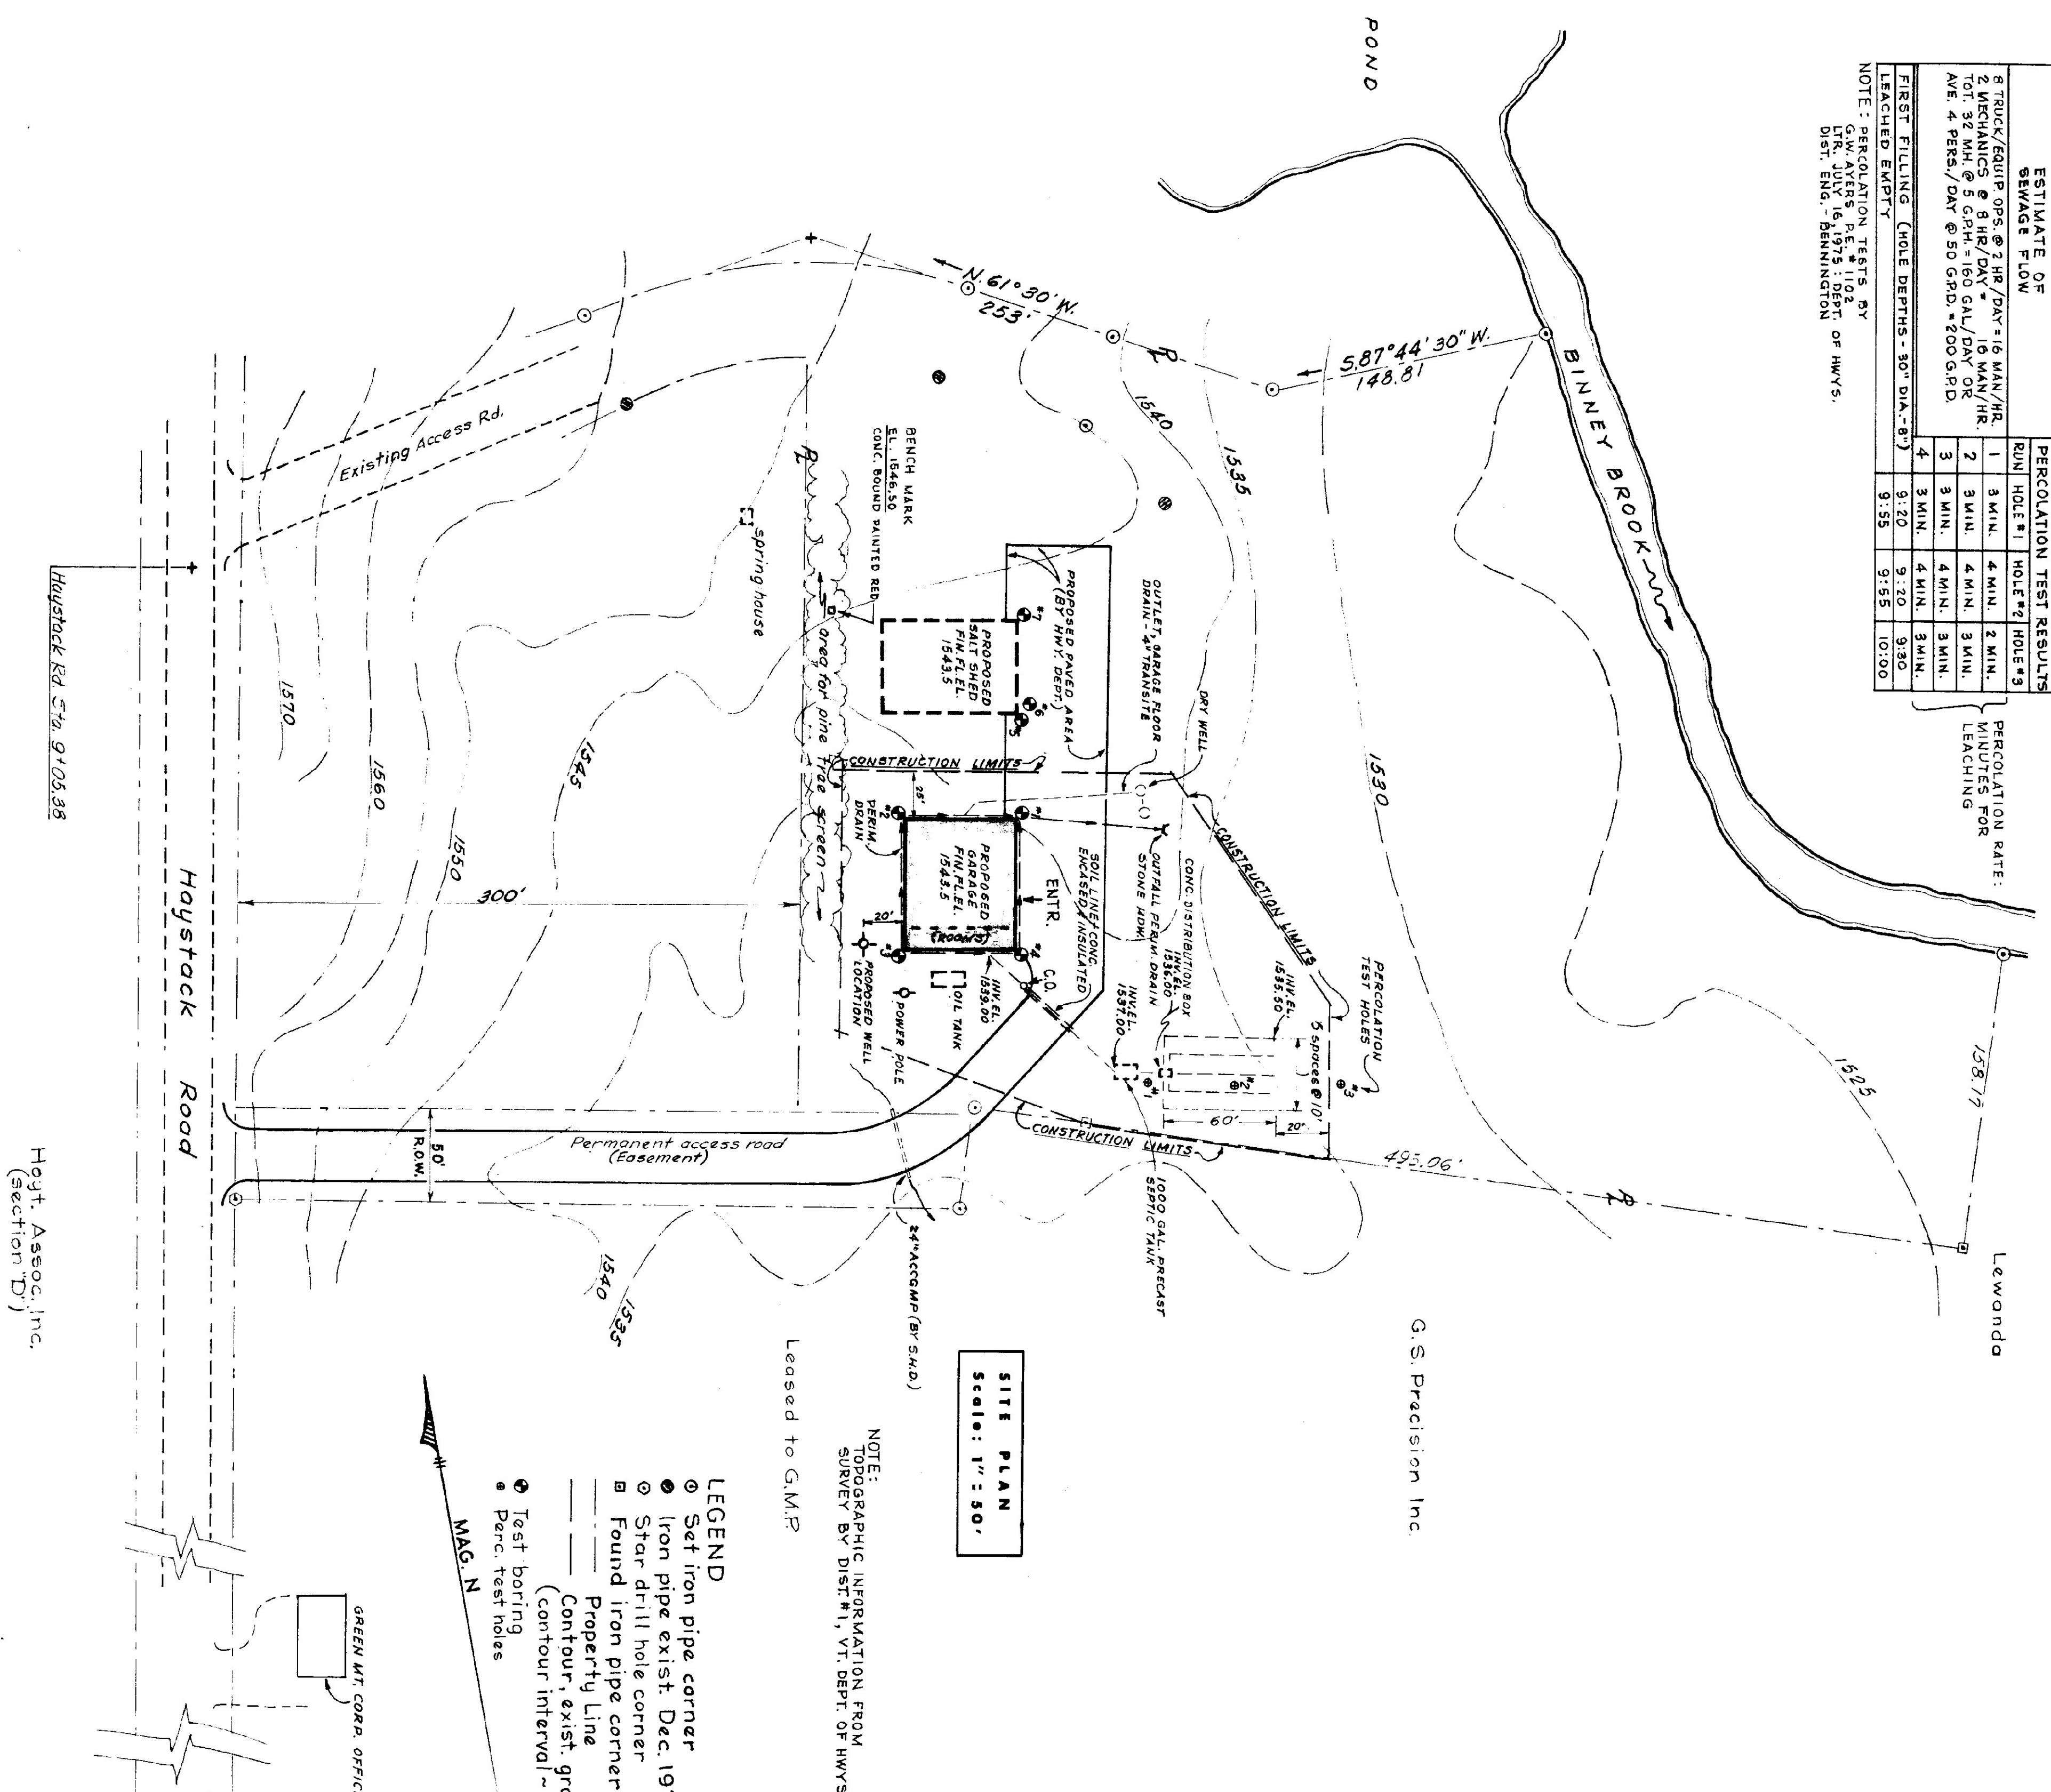


STATE OF VERMONT

PROPOSED STATE HIGHWAY MAINTENANCE

GARAGE BUILDING

LOCATED IN WILMINGTON, VT.

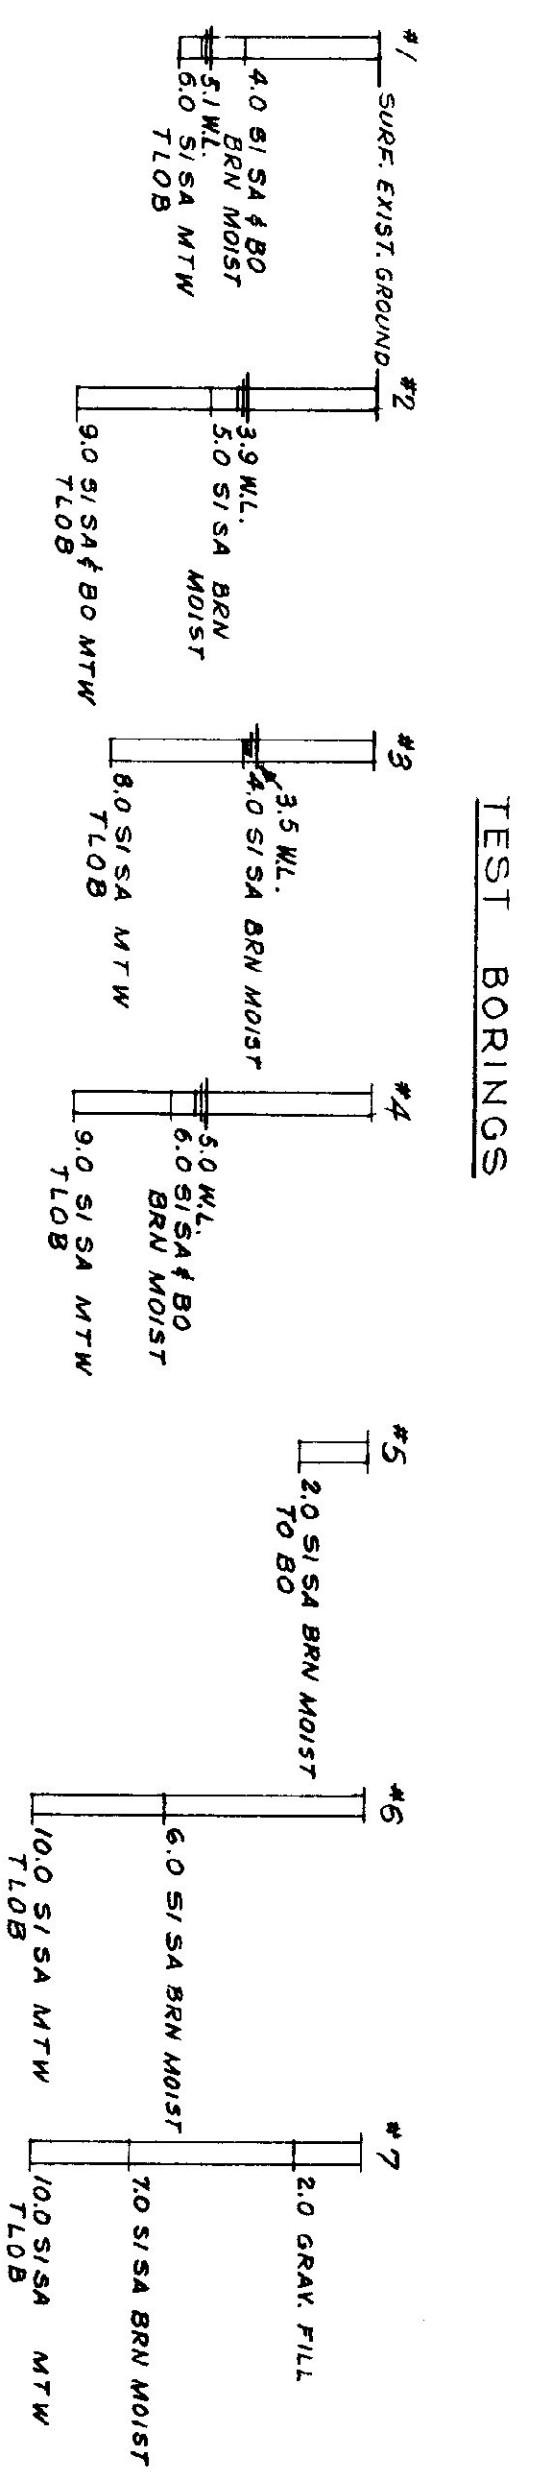

INDEX OF DRAWINGS

- S-1 Title Sheet, Site Plan and Borings
- A-1 Floor Plan and Foundation Details
- A-2 Elevations
- A-3 Wall Sections and Selected Details
- A-4 Det. of Mezz. & Boiler Rim Slabs & Conc. Stairs
- A-5 Precast Conc. Double Tee Roof Struct. & Det.
- H-1 Heating and Plumbing Layout
- H-2 Boiler Room Plan and Selected Details
- E-1 Electrical Plan

APPROVED: *John A. Dunfee* 8-28-75
John A. Dunfee, Maintenance Management Engineer

INITIALS	DATE	REVISION

STATE OF VERMONT
DIVISION OF STATE BUILDINGS
AGENCY OF ADMINISTRATION
MONTPELIER, VERMONT

STANDARD
3 BAY HIGHWAY GARAGE BUILDING
TITLE, SITE PLAN AND BORINGS

DATE	DESIGNED BY	DWG. NO.
AUG. 4, '75	T. J. S.	5-1

5/4 Miller