

ESTIMATE OF SEWAGE FLOW		PERCOLATION TEST RESULTS			
RUN	HOLE #1	HOLE #2	HOLE #3	HOLE #4	HOLE #5
1	3 MIN.	4 MIN.	2 MIN.		
2	3 MIN.	4 MIN.	3 MIN.		
3	3 MIN.	4 MIN.	3 MIN.		
4	3 MIN.	4 MIN.	3 MIN.		
FIRST FILLING (HOLE DEPTHS - 30" DIA. - 8')		9:20	9:20	9:30	
LEACHED EMPTY		9:55	9:55	10:00	


NOTE: PERCOLATION TESTS BY G.M.P. DIST. ENG. - BENNINGTON

PERCOLATION RATE: MINUTES FOR LEACHING

Lewonda

STATE OF VERMONT PROPOSED STATE HIGHWAY MAINTENANCE GARAGE BUILDING LOCATED IN WILMINGTON, VT.

TEST BORINGS

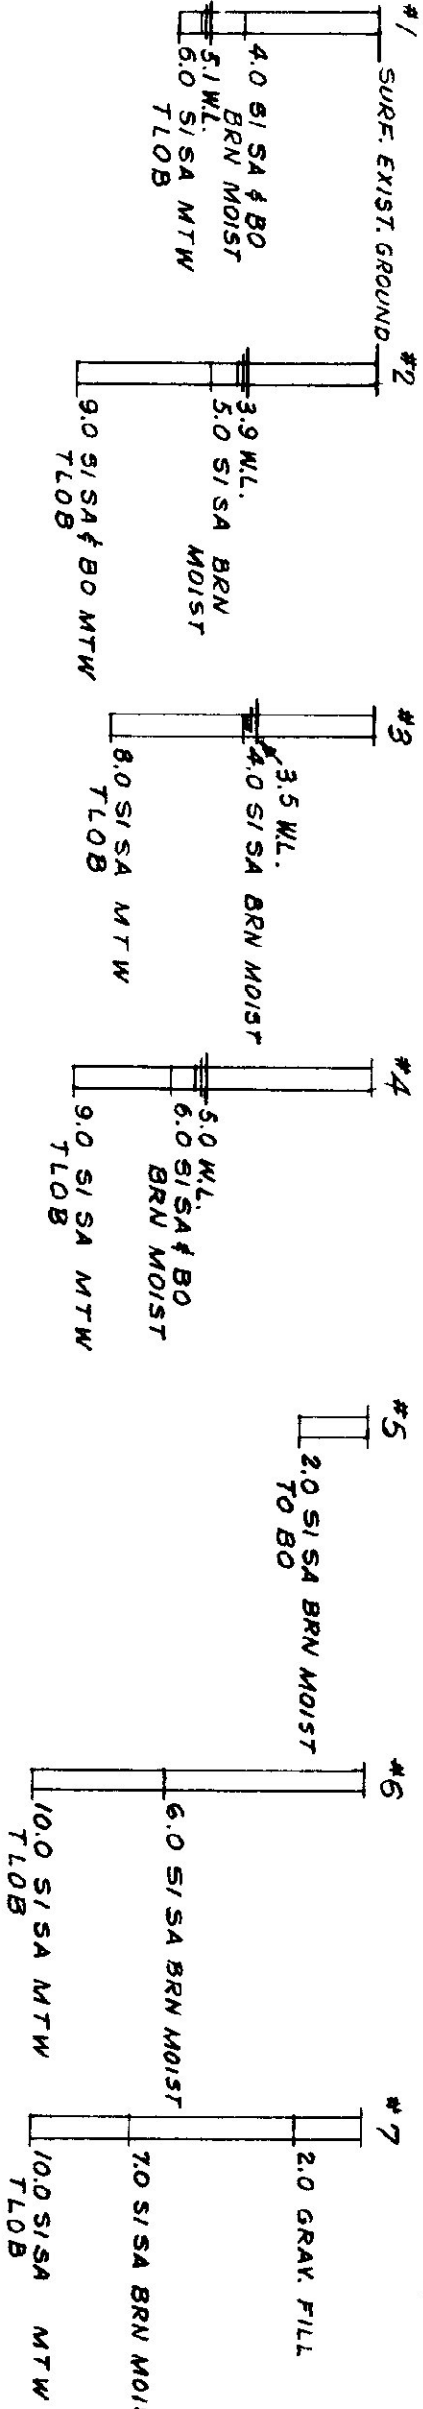

LEGEND FOR BORINGS
SI/SA - SILTY SAND
BO - BOULDER
TLOB - TO LODGE OR BOULDER
BRN - BROWN
MTW - MOIST TO WET
WL - WATER LEVEL

INDEX OF DRAWINGS

- S-1 Title Sheet, Site Plan and Borings
- A-1 Floor Plan and Foundation Details
- A-2 Elevations
- A-3 Wall Sections and Selected Details
- A-4 Det. of Mezz. & Boiler Rim Slabs & Conc. Stairs
- A-5 Precast Conc. Double Tee Roof Struct. & Det.
- H-1 Heating and Plumbing Layout
- H-2 Boiler Room Plan and Selected Details
- E-1 Electrical Plan


APPROVED: *John A. Durfee* P-28-75
John A. Durfee, Maintenance Management Engineer

INITIALS	DATE	REVISION

STATE OF VERMONT
DIVISION OF STATE BUILDINGS
AGENCY OF ADMINISTRATION
MONTPELIER, VERMONT

STANDARD
3 BAY HIGHWAY GARAGE BUILDING
TITLE, SITE PLAN AND BORINGS

DATE: AUG. 4, '75	DESIGNED BY: T. J. S.	DWG. NO. S-1
DRAWN BY: S.H. Miller	APPROVED BY: <i>Signature</i>	1 of 1

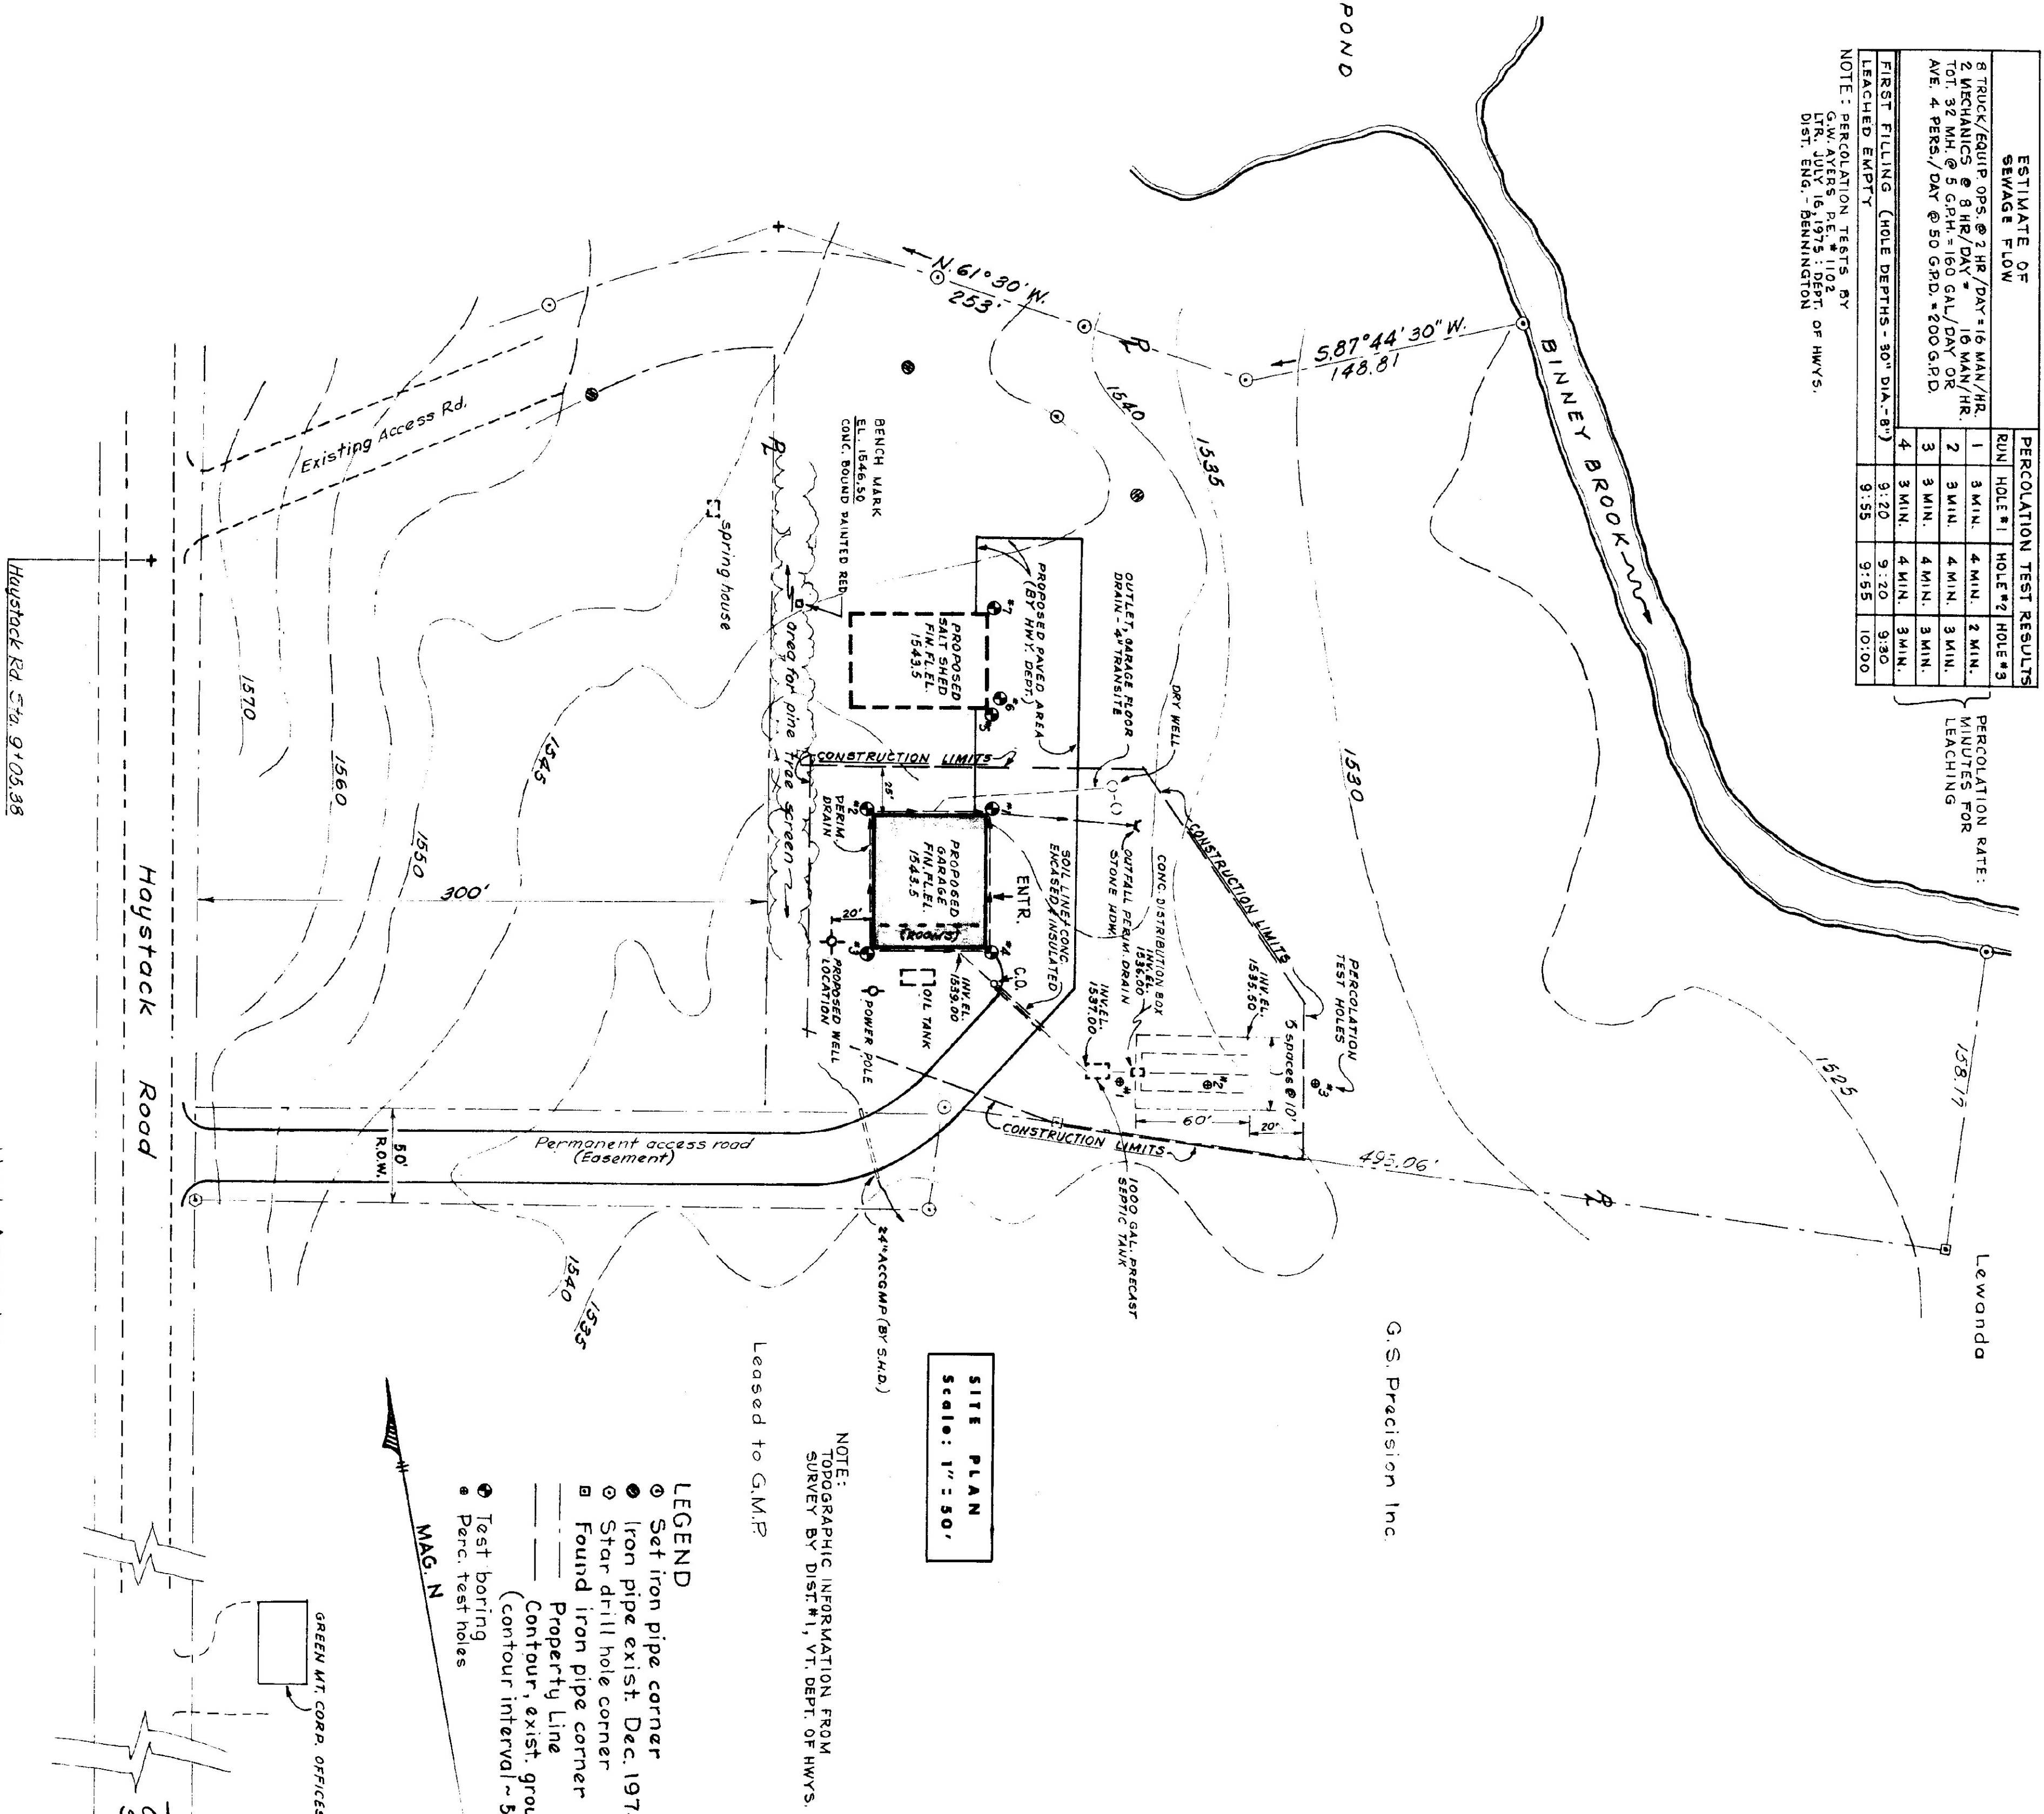

SITE PLAN
Scale: 1" = 50'

NOTE: TOPOGRAPHIC INFORMATION FROM SURVEY BY DIST. M., VT. DEPT. OF HWYS.

Leased to G.M.P.

LEGEND

- Set iron pipe corner
- Iron pipe exist, Dec. 1974
- Star drill hole corner
- Found iron pipe corner
- Property Line
- Contour, exist. ground (contour interval - 5')
- Test boring
- Perc. test holes

MAG. N

GREEN MT. CORP. OFFICES

0.25 mi. to access rd.
St. Hwy. Dept. yard

Vt. Rte. 9
(1.1 mi. to Vt. Rte. 100)
TO BENNINGTON
TO WILMINGTON
Rte. 9 Sta. 936+00
Haystack Rd. 0+00

Hoyt, Assoc. Inc.
(Section D)

Haystack Rd. Sta. 9+05.38