
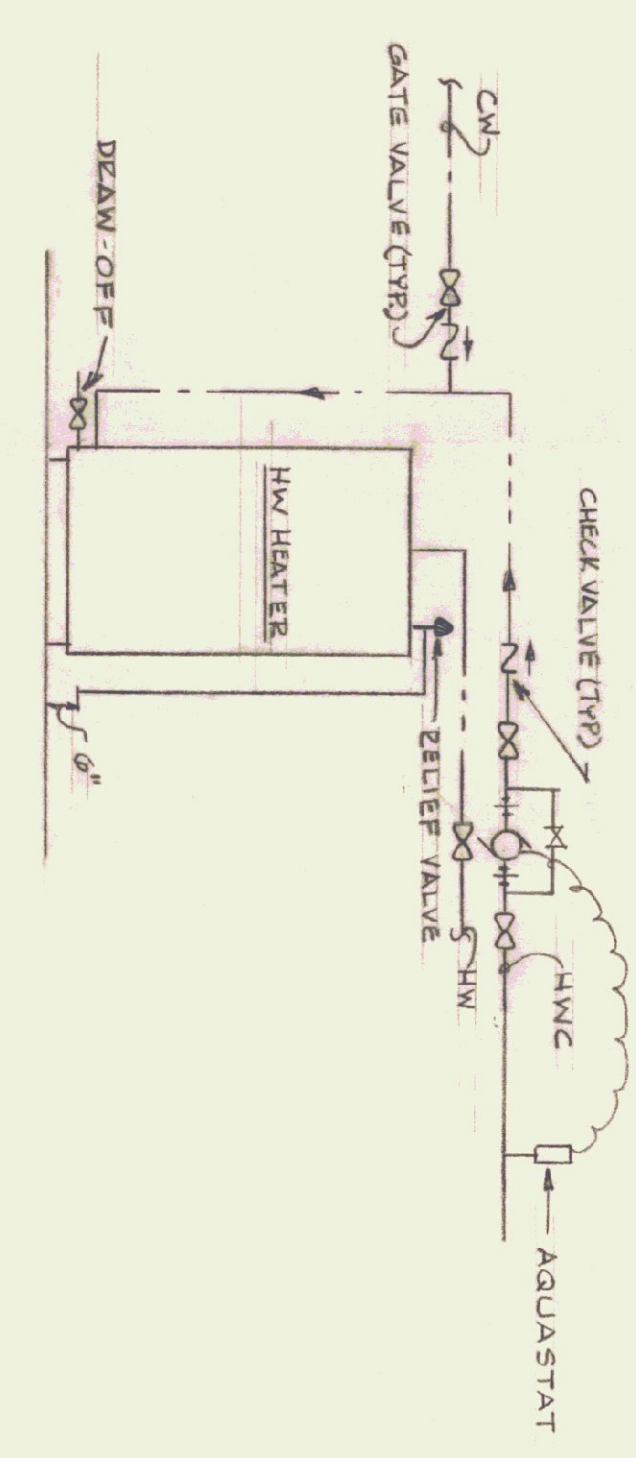



FIXTURE NO. AM.SID.	NO.	FIXTURE	SOIL	WASTE VENT	WASTE	VENT	NOTES
No. 3108.408	P-1A	WATER CLOSET	4"	2"	2"	1/2"	CHURCH OPEN PRT SEAT.
No. 6501.010	P-2	URINAL	2"	2"	3/4"	18" HT. - HANGDOWN	
No. 4867.024	P-3	LAVATORY	1 1/2"	1 1/2"	1/2"	2" CLEAR AT RIM - FINISH WITH POP-UP DRAIN.	
No. 2248.185		LAV. FITTING					
No. 310.112	P-6	DRINKING FOUNTAIN	1/2"	1/4"	1/2"	VIT. CHINA. HANDLE HT. 36"	
	P-7	HOSE FAUCET			1/2"		
No. 7692.049	P-8	SERVICE SINK	2"	2"	3/4"	2 1/2" CURB 8379.018	

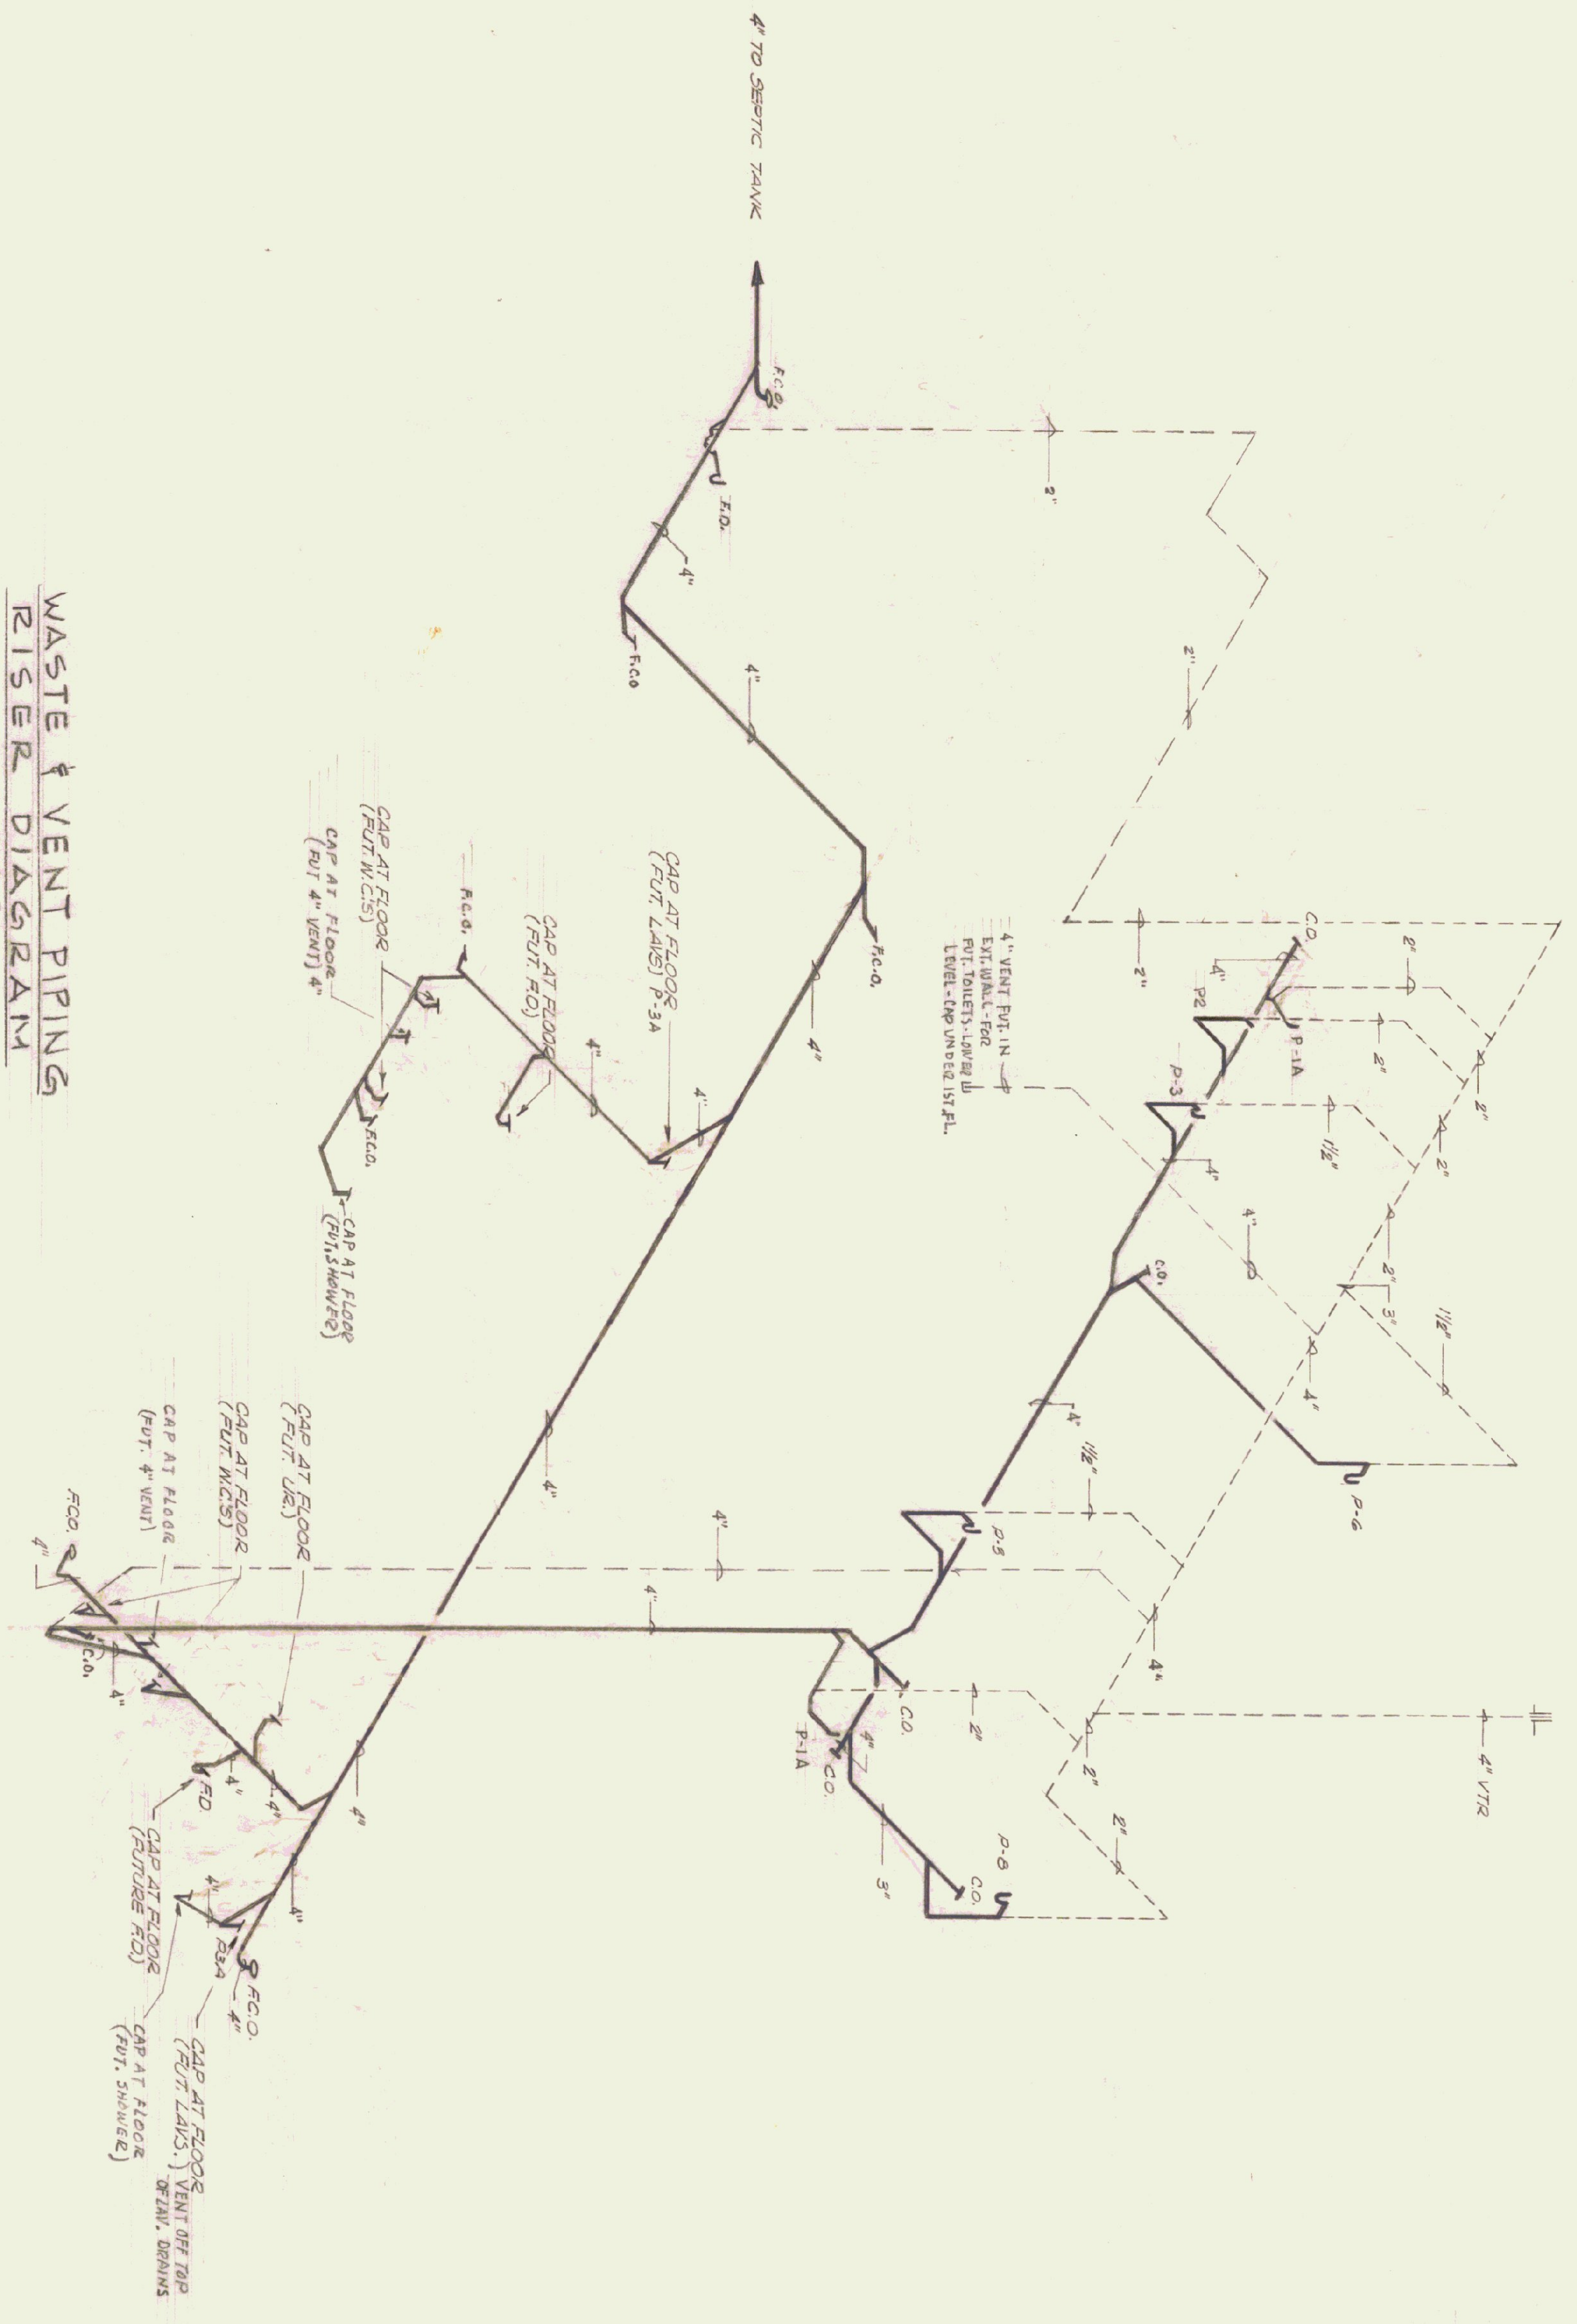

SCHEMATIC HW HEATER
NO SCALE

WASTE & VENT PIPING RISER DIAGRAM
NO SCALE

PART SITE PLAN
SCALE: 1/8" = 1'-0"

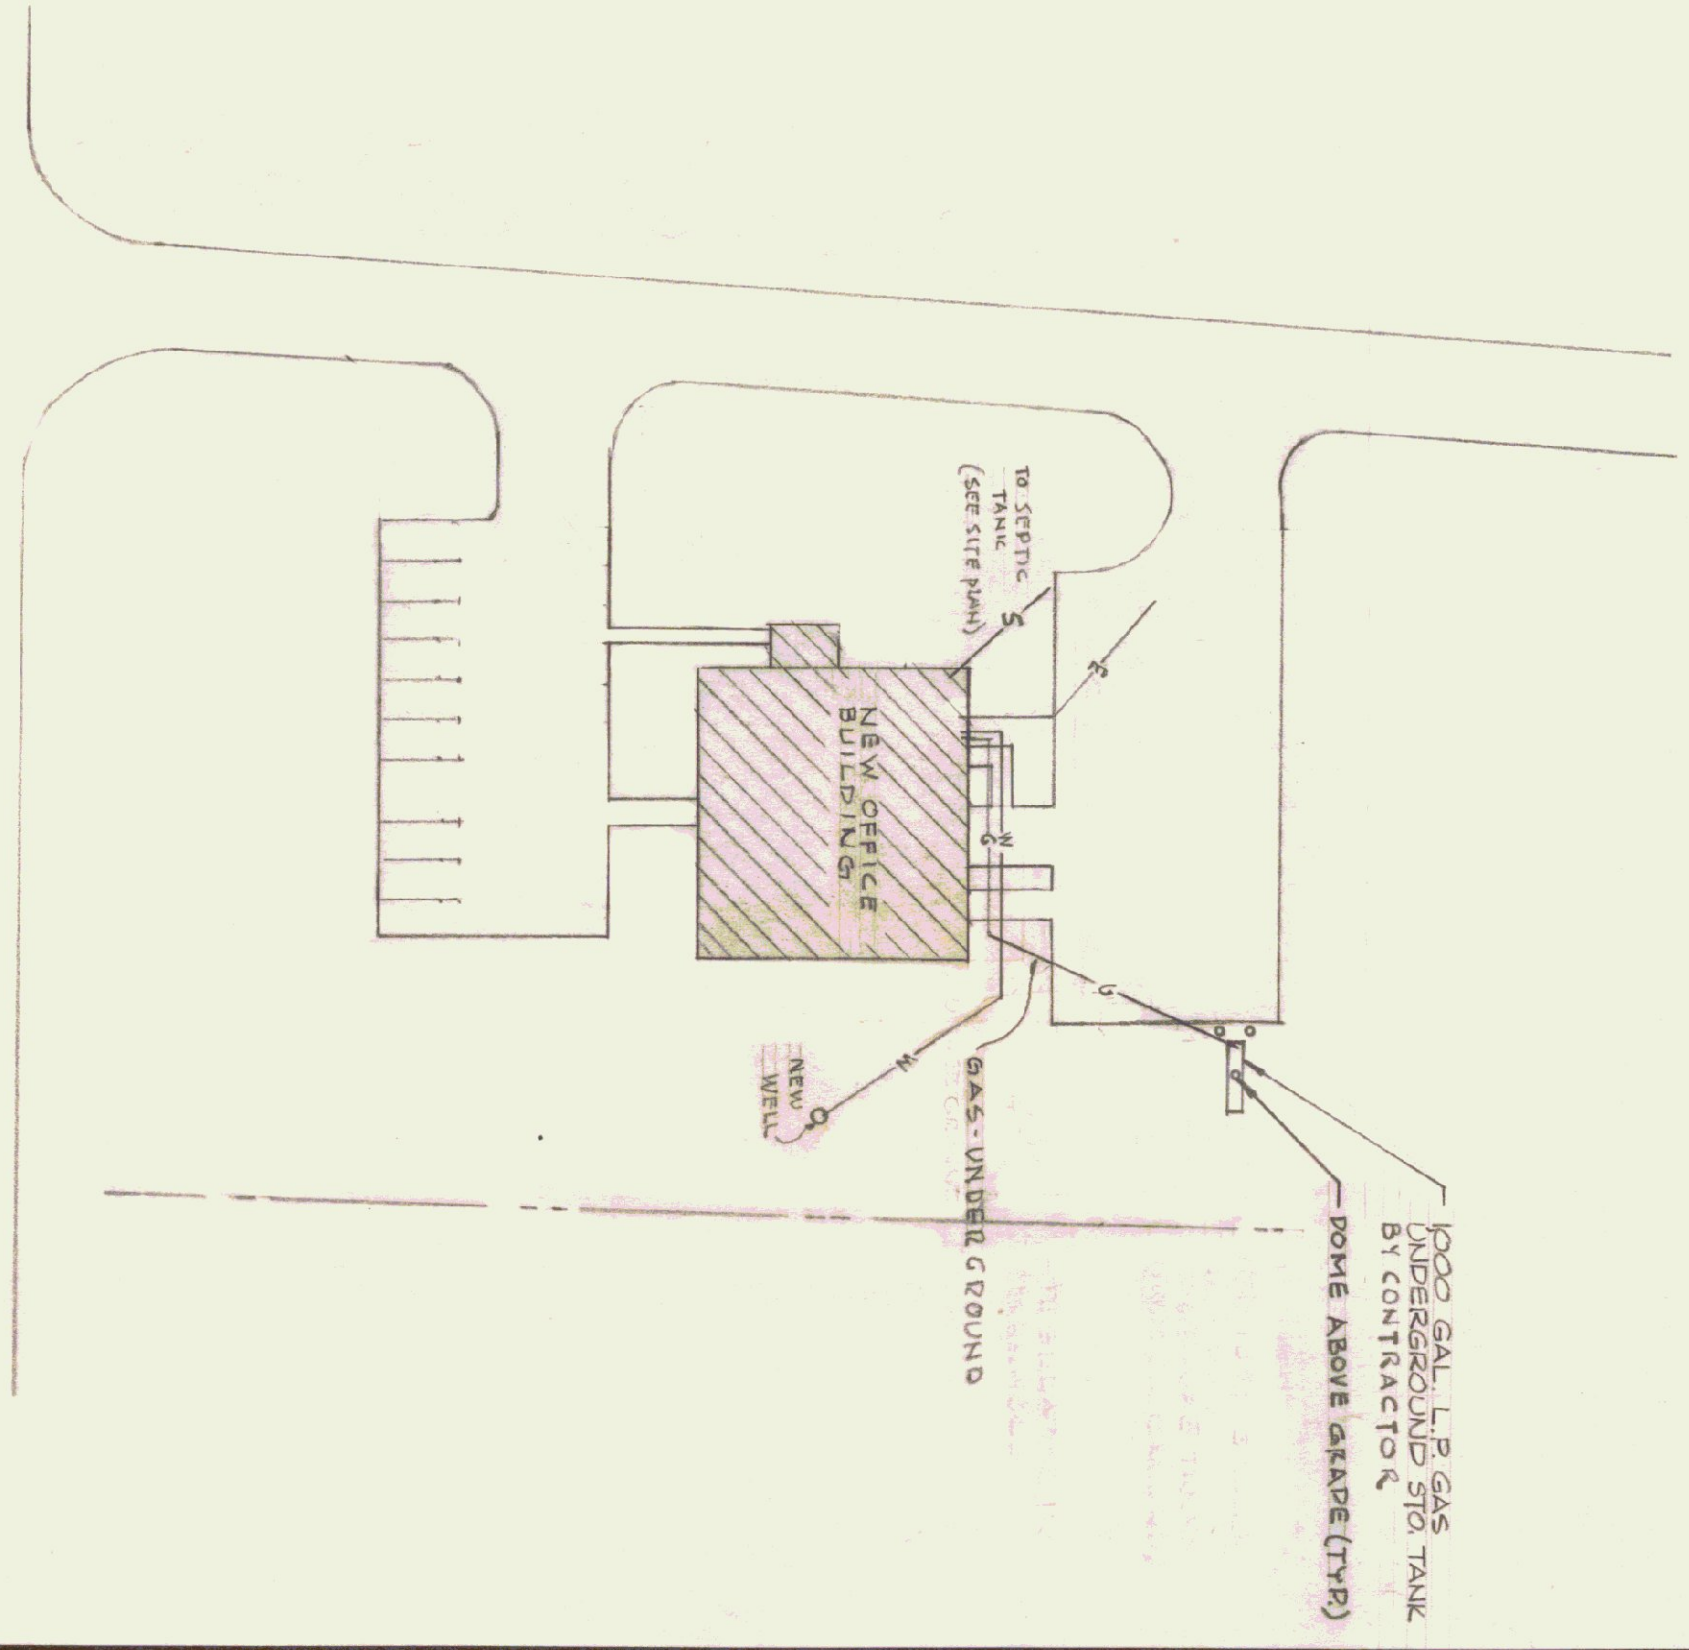

REVISIONS	BY
8-9-85	
10-25-85	
2-18-86	
3-19-86	
5-16-86	

AGENCY OF TRANSPORTATION — NEW OFFICE
 STATE OF VERMONT-DEPT. OF STATE BUILDINGS
 DUMMERSTON, VERMONT
 GORDON G. WOODS ASSOC., ARCHITECTS, BURLINGTON, VERMONT

DRAWN: JCS
 CHECKED: GFS
 DATE: JULY 24, 1985
 SCALE: NONE
 JOB NO.: 8420
 SHEET: 32 OF 36

P 3

RICHARD D. KIMBALL CO., INC.
 READING, MASSACHUSETTS 01867
 (617) 942-0130