
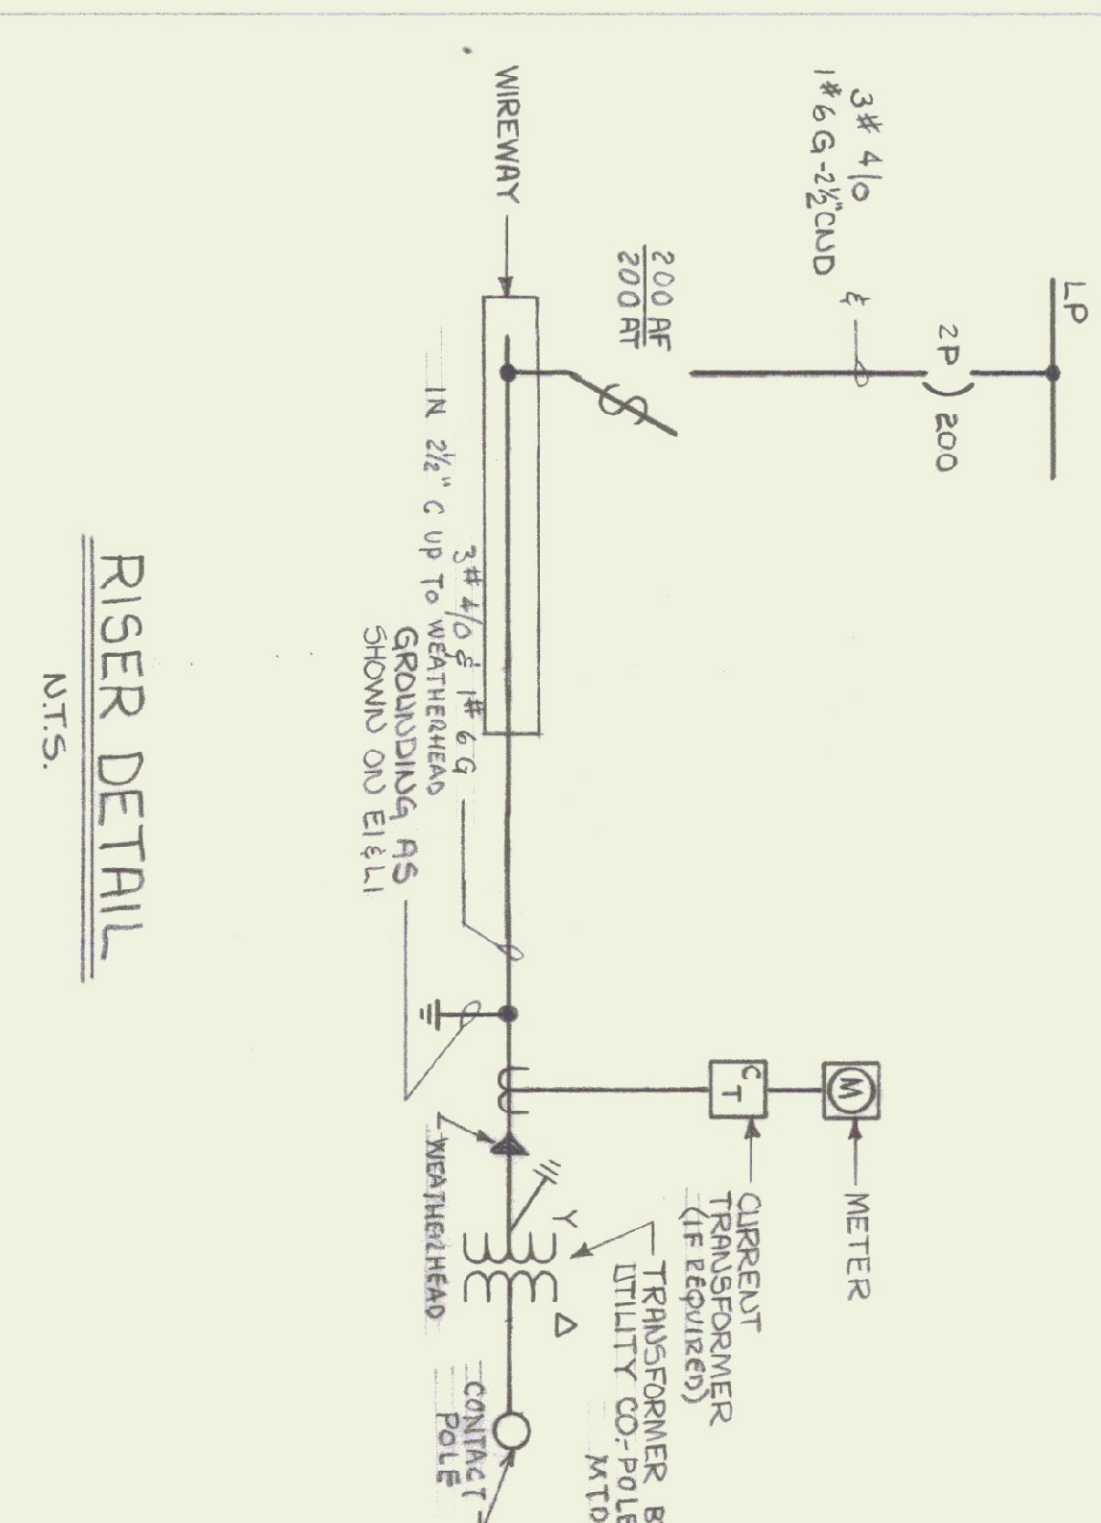


LOWER LEVEL ELECTRICAL AND LIGHTING PLAN
SCALE: 1/4" = 1'-0"

NOTE 5:
ALL DIMENSIONS TO BE VERIFIED AT THE SITE BY THE CONTRACTOR. ANY ERROR OR POINTS IN QUESTION MUST BE REFERRED TO THE ARCHITECT FOR A DECISION BEFORE PROCEEDING WITH THE WORK.

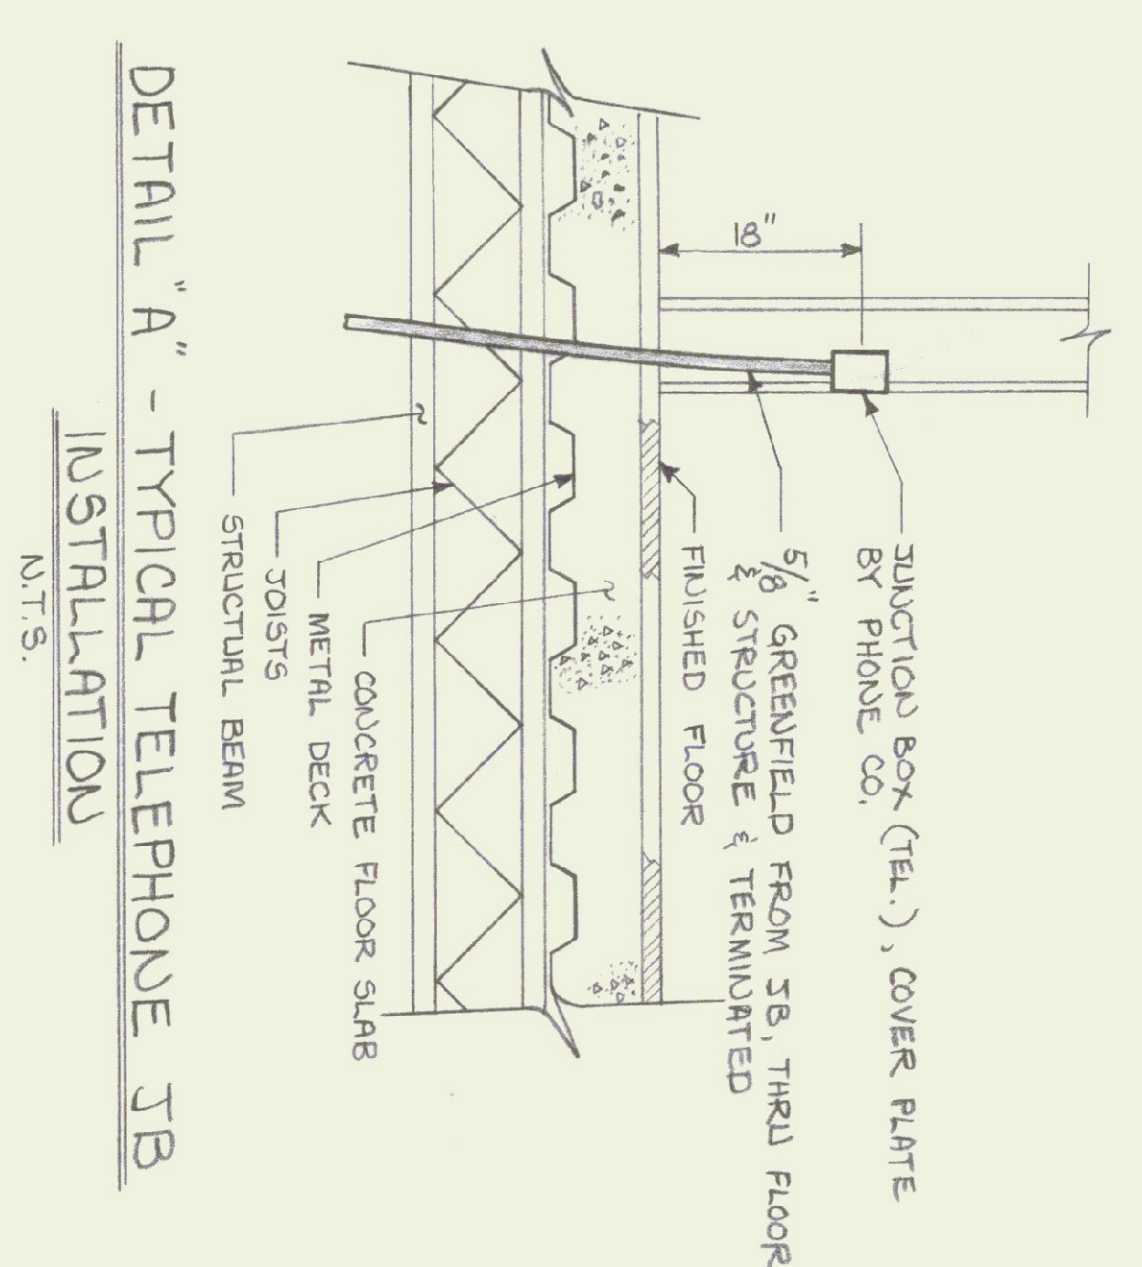

RICHARD D. KIMBALL CO. INC.
580 Main St.
Reading, Massachusetts 01867
(617) 342-0150

AGENCY OF TRANSPORTATION — NEW OFFICE
STATE OF VERMONT DEPT. OF STATE BUILDINGS
DUMMERSTON, VERMONT
GORDON G. WOODS ASSOC. ARCHITECTS, BURLINGTON, VERMONT

REVISIONS	BY
8-9-85	
LABOR DIMENSIONS BY LETTER 8-28-85	
10-25-85	
5-16-86	

ELL
30 OF 32 SHEETS

DRAWN: 5W / 5W
CHECKED:
DATE: JUN 29, 1985
SCALE: 1/4 INCH = 1 FOOT
JOB NO.: 8420
SHEET: