


66'-0"



NOTES:
 ALL DIMENSIONS TO BE VERIFIED AT THE SITE BY THE CONTRACTOR. ANY ERROR ON POINTS IN QUESTION MUST BE REFERRED TO THE ARCHITECT FOR A DECISION BEFORE PROCEEDING WITH THE WORK.

TYPE	MANUFACTURER	CAT. NO.	LAMPS	VOLTS	WTG.	REMARKS
A	LPI CORP	TR2458TR240	3F40W	120	R	
B	LPI CORP	TR2458TR240	2F40U	120	R	
C	LPI CORP	98HR2-40	2F40W	120	S	
D	LPI CORP	TRH45TR240	2F40W	120	R	
E	MARKSTONE	FL 1532	32 W	120	S	
F	AH/H	111	150 W	120	S	
G	MARKSTONE	945	2-40W	120	S	
H	McPHILLIBEN	43-40VT	1-100W	120	S	
J	LITHONIA	LB240A	2F40W	120	S	

ZONES:
 ZONE 1 - BOILER ROOM / MECHANICAL ROOM
 ZONE 2 - SPARE
 ZONE 3 - LOWER LEVEL
 ZONE 4 - FIRST FLOOR
 ZONE 5 - SPARE
 ZONE 6 - SPARE

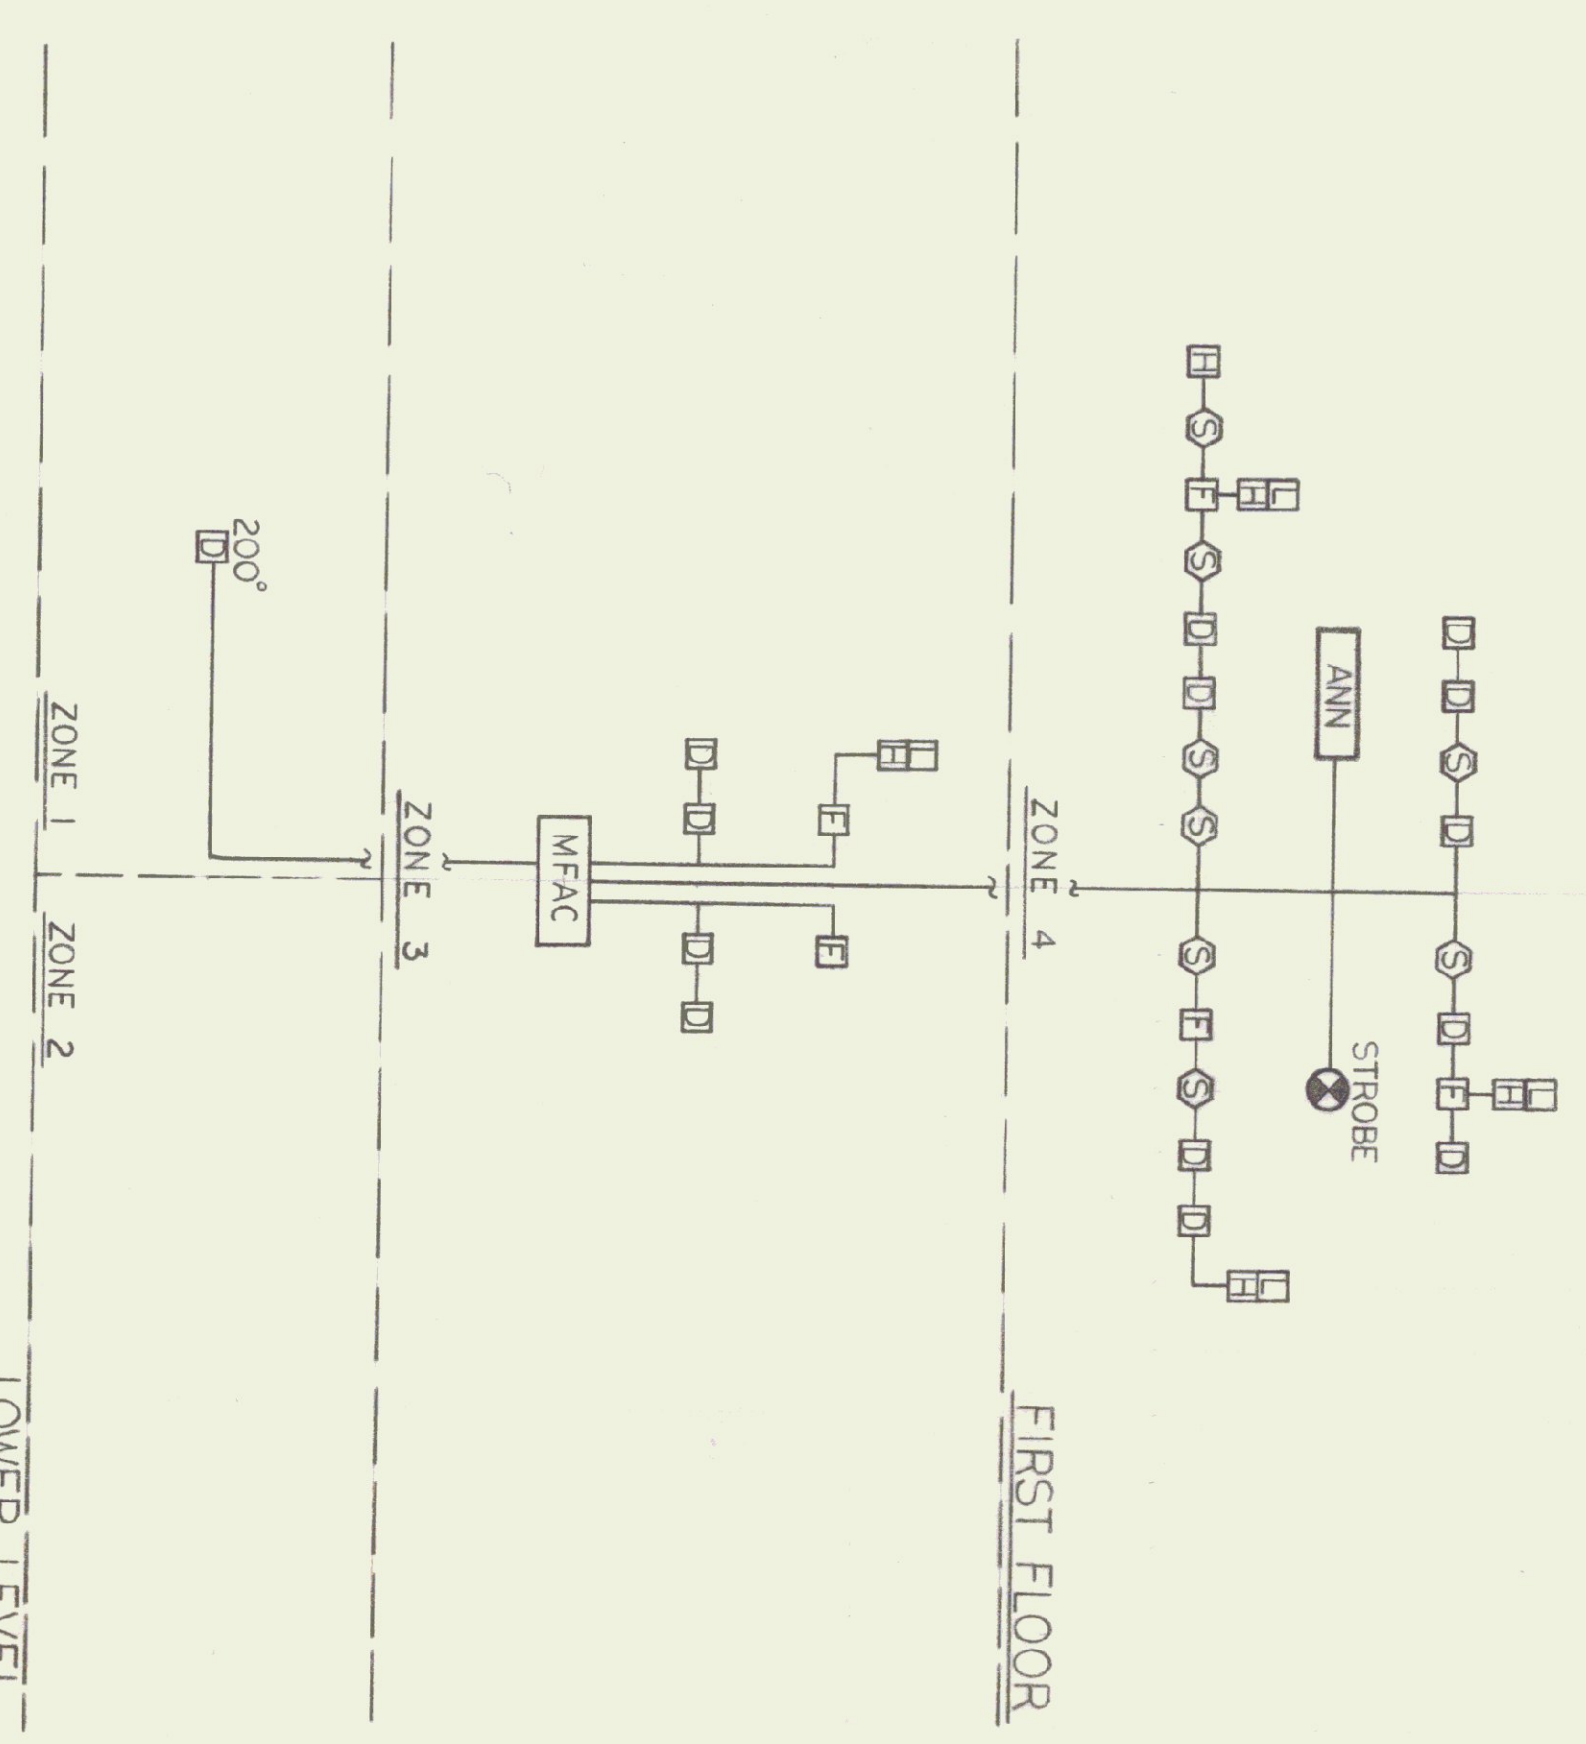

FIRE ALARM RISER DIAGRAM

1/8" SCALE

NOTE: ALL EQUIPMENT BEING USED IN THIS SYSTEM SHALL BE LISTED, LABELED AND COMPATIBLE AND THAT THIS SYSTEM BE INSTALLED IN COMPLIANCE WITH THE APPLICABLE NFPA STANDARDS.



RICHARD D. KIMBALL CO., INC.
 380 Main Street
 Reading, Vermont 05677
 (817) 942-0130

LOWER LEVEL

AGENCY OF TRANSPORTATION - NEW OFFICE
 STATE OF VERMONT DEPT OF STATE BUILDINGS
 DUMMERSTON VERMONT
 GORDON G. WOODS ASSOC. ARCHITECTS, BURLINGTON, VERMONT

REVISIONS	BY
8-9-85	
LABOR & INQUIRY BUREAU LETTER 8-26-85	
10-25-85	
2-18-86	
5-16-86	

32 OF 32 SHEETS

L2

DRAWN: JKL/ew
 CHECKED:
 DATE: July 24, 1985
 SCALE: 1/4" = 1'-0"
 JOB NO.: 8420
 SHEET