

FIRST FLOOR LIGHTING PLAN
SCALE: 1/4" = 1'-0"


TYPE	MANUFACTURER & MODEL	MOUNTING	LAMPS	REMARKS
A	RIIUD MAC2410-D, WM-3	SURFACE	(1)-100W MH	
B	RIIUD E44090	SURFACE	(1)-50W MH	
C	GE VZC-29P0A-4E45	PENDANT	(1)-250W MH COATED	MOUNT AT 15'-6" AFF.
C1	GE VZC-29P0A-4E450	PENDANT	(1)-250W MH COATED	SAME AS ABOVE
D	RIIUD MAC2410-1P, WM-3	SURFACE	(1)-100W MH	PHOTOCELL
F	DAYTON 40863 W/4G929 CONTROL	SURFACE		MOUNT AT 14' AFF.
FA	METALUX W3332A-120-EBB1	SURFACE	(3)-FO3278 3500 K	
FB	METALUX DIM-232-120-EBB1	CHAIN	(2)-FO3278 3500 K	
FC	THE ROBERT GROUP J0-2/3-120	SURFACE	(2)-P13W 3500 K	
FD	METALUX Z6C-232A-120-EBB1	RECESSED	(2)-FO3278 3500 K	
FV	STONCO K01L-28-NR1-1	SURFACE	(1)-GX324-3	
MA	LEATON MOTION DETECTOR #05120	SURFACE		DETECTOR ONLY
MB	LEATON MOTION DETECTOR #05120	SURFACE	(2)-PAR38 150 W FLOO	WEATHERPROOF WITH 2 STONCO LAMP HOLDERS
MC	SURBELITE CC-4-WI-NICAD	SURFACE		CEILING OR WALL MOUNT
MD	SURBELITE CCX-227G-RWH120	SURFACE		RED LETTERING

GENERAL NOTES:

- ANY PLACE WHERE THE CONTRACTOR PENETRATES, CUTS AND/OR REMOVES WALLS, CEILINGS, OR WOODWORK, CONTRACTOR IS TO REPLACE, PATCH AND PAINT FINISH SURFACES TO ORIGINAL FINISHES.
- FIELD VERIFY ALL DIMENSIONS BEFORE COMMENCEMENT OF WORK IS TO BEGIN. NOTIFY ENGINEER OF ANY ERRORS.
- REFER TO THE ARCHITECTURAL REFLECTED CEILING PLANS FOR FINAL LOCATIONS OF LIGHT FIXTURES.
- EC TO PROVIDE AND INSTALL ALL DISCONNECT SWITCHES, MG TO PROVIDE ALL MOTOR STARTERS, EC TO INSTALL.


KEYED NOTES:

- THIS FIXTURE IS CONTROLLED BY INTERNAL PHOTOCELL ONLY, NOT SWITCHED.
- THIS FIXTURE IS UN-SWITCHED (ON AT ALL TIMES), CONNECT TO NEAREST LIGHTING CIRCUIT.
- FIXTURES OVER GARAGE DOOR MOUNTED AT 15'-6" AFF. ALL OTHERS AT 14' AFF.

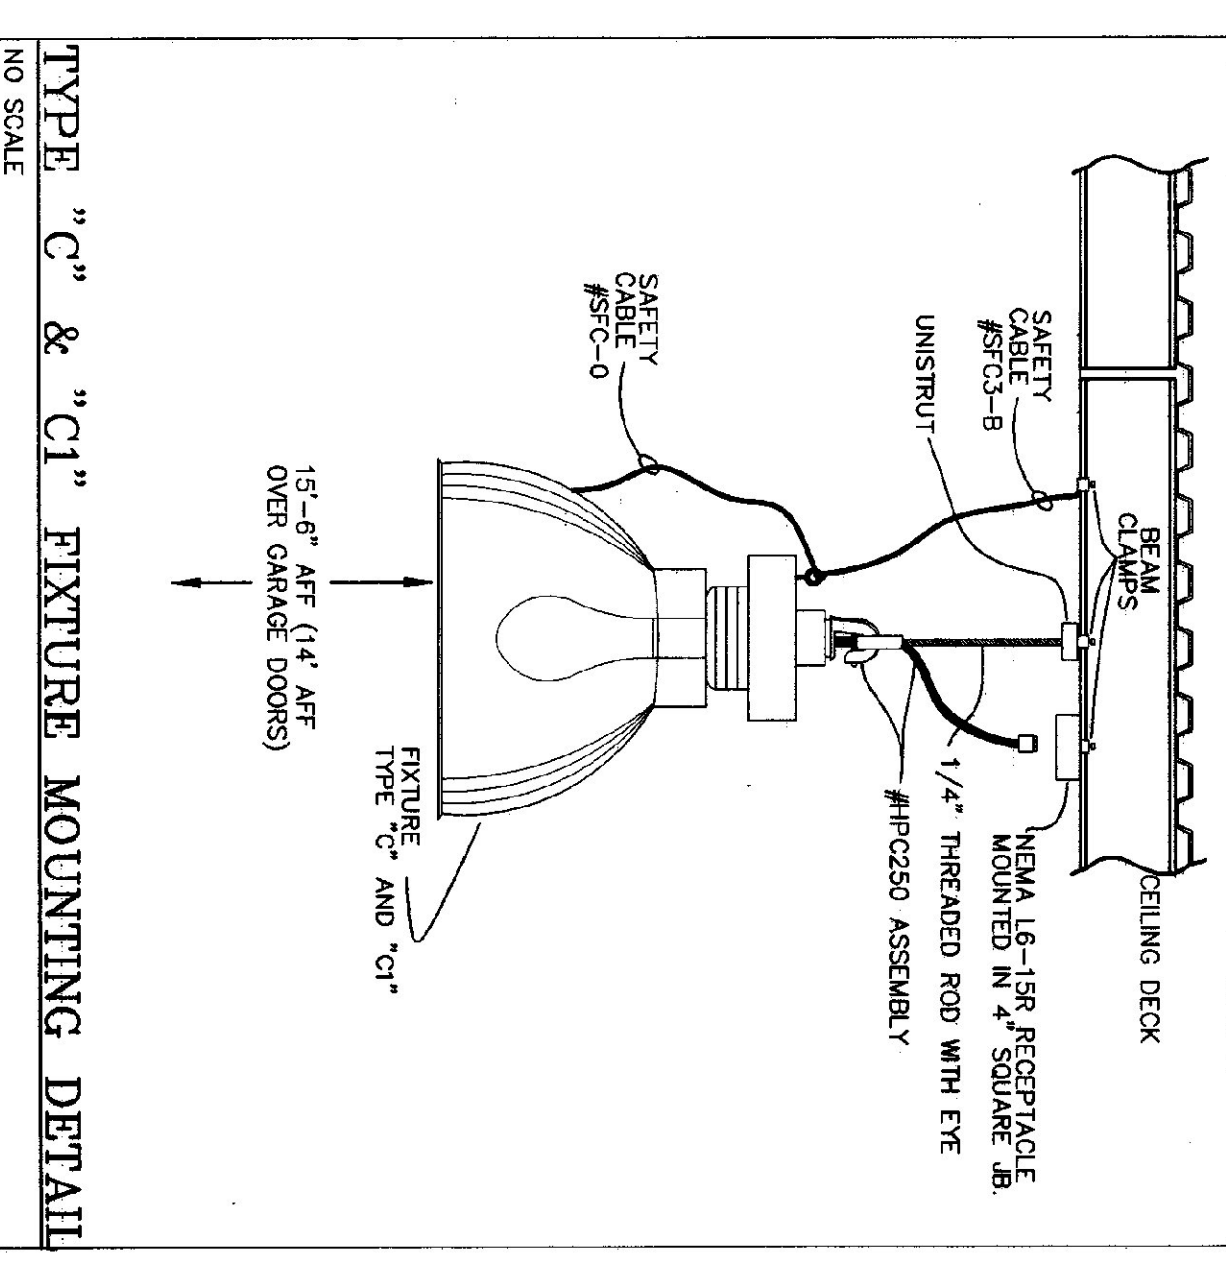

E H Danson Assoc.
Architects
827 Washburn Ave. Ste. 204, P.O. Box 4096
St. Johnsbury, Vermont 05889
Tel (802) 748-8286 Fax (802) 748-1048

Pearson & Associates
MECHANICAL & ELECTRICAL ENGINEERS
P.O. BOX 810, STONE, VERMONT 05672
TEL.(802) 253-9607 FAX.(802) 253-9290

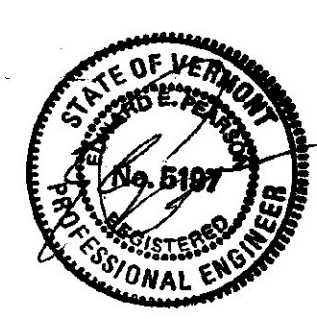

AGENCY of TRANSPORTATION:
FIVE BAY MAINTENANCE FACILITIES
LONDONDERRY, VERMONT

SCALE	AS NOTED
DATE	MAY, 14, 2001
DRAWN BY	ASS

DATE	REVISION

DRAWING NAME
ELECTRICAL
FIRST FLOOR LIGHTING PLAN

E2