




FLOOR PLAN
SCALE: 1/8" = 1'-0"

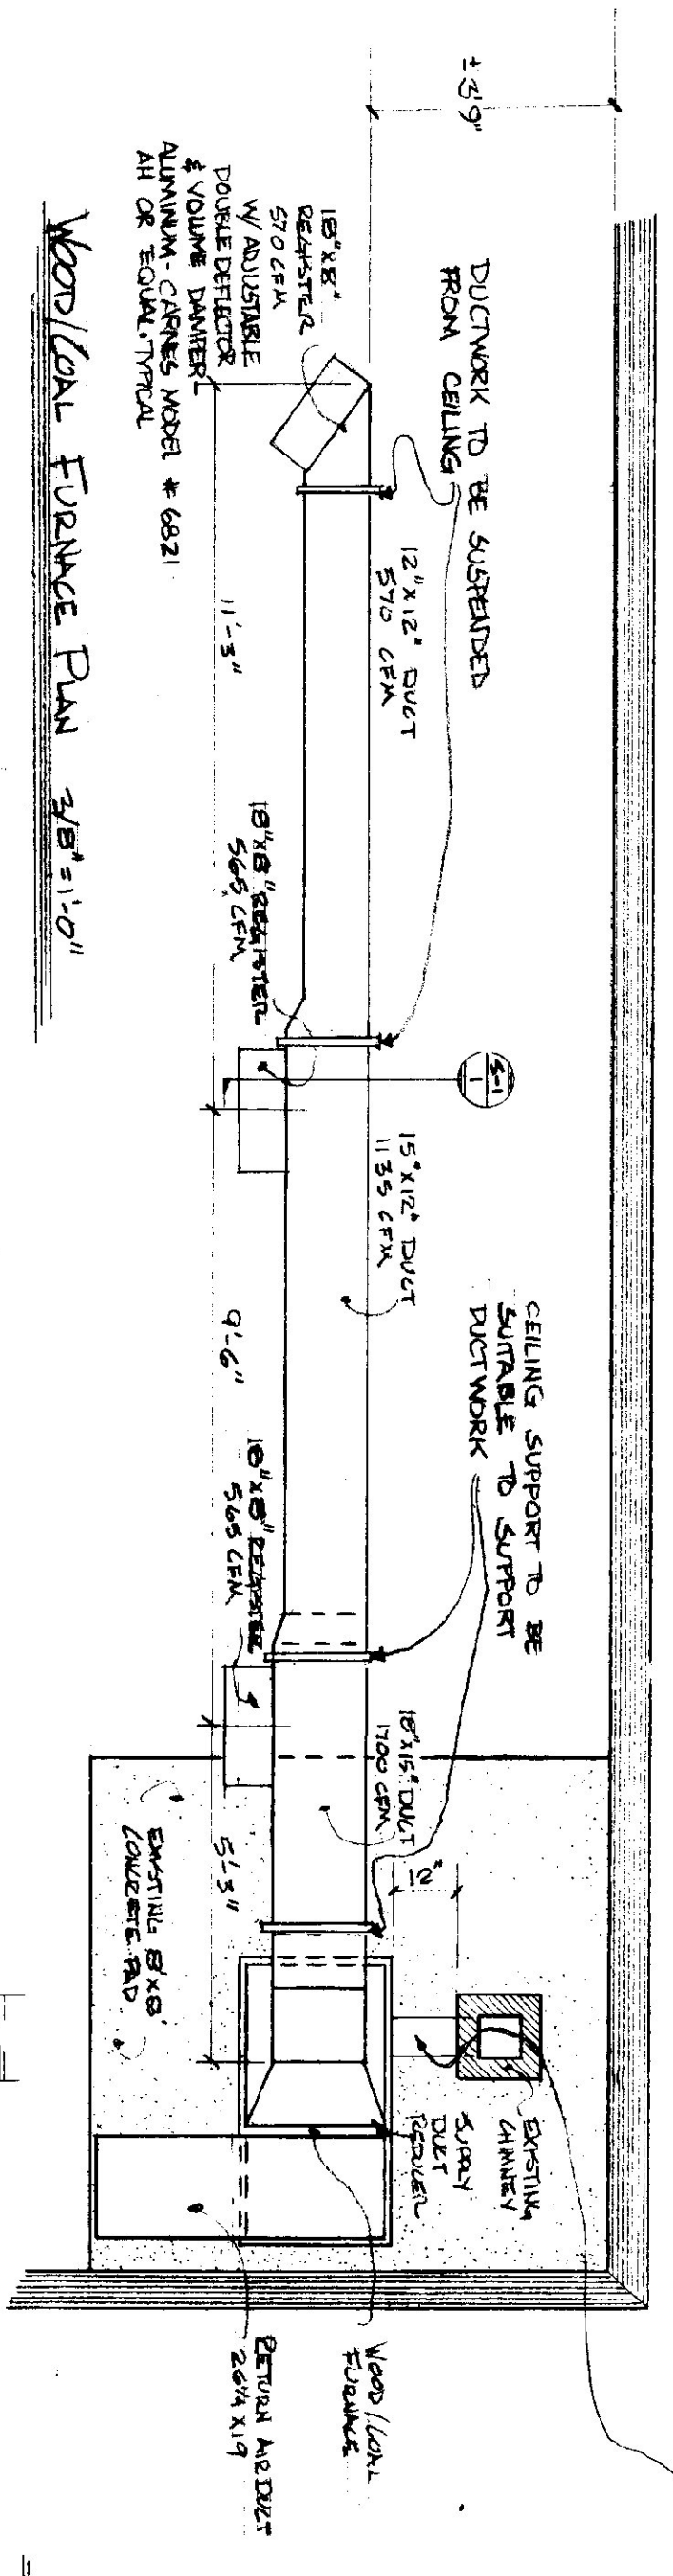

WOOD/COAL FURNACE PLAN 3'-0" x 1'-0"

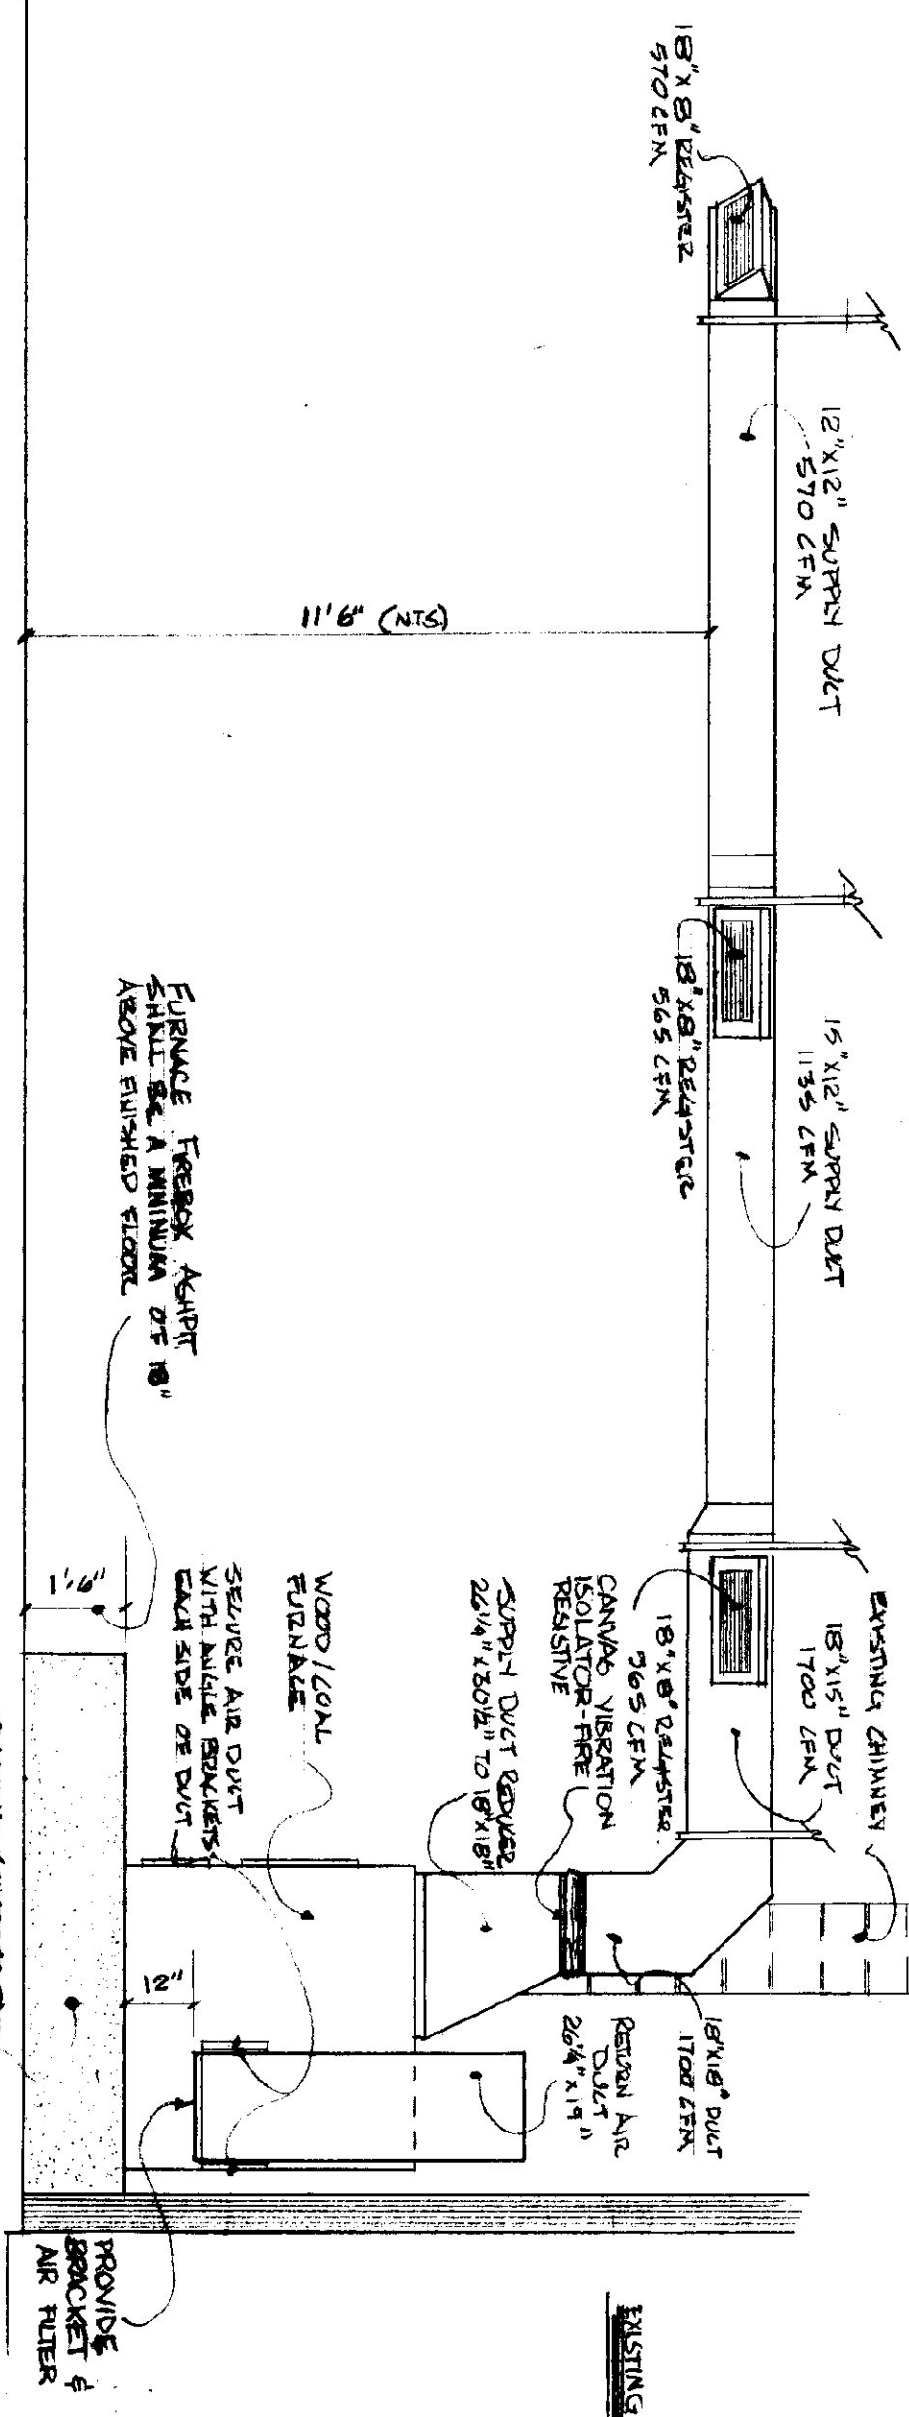

FRONT ELEVATION OF FURNACE 3'-0" x 1'-0"

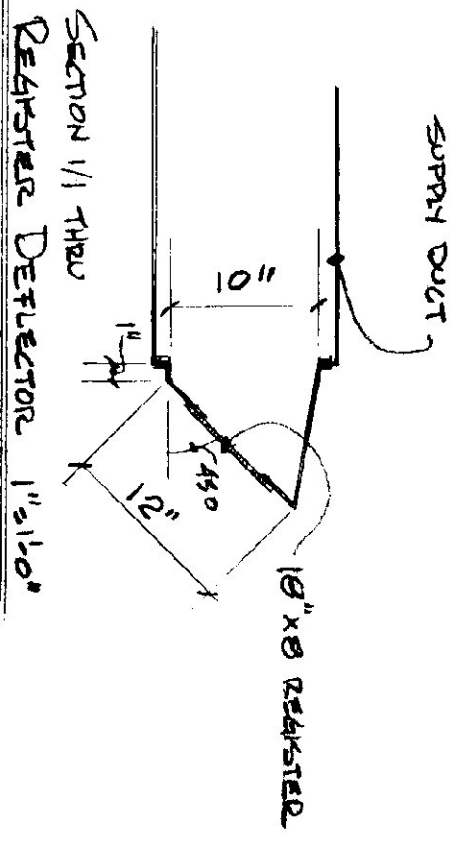

SECTION 1/1 THRU REGISTER DEFLECTOR 1'-0" x 1'-0"

STATE OF VERMONT
DIVISION OF STATE BUILDINGS
AGENCY OF ADMINISTRATION
MONTPELIER, VERMONT

WOOD/COAL FURNACE INSTALLATION
AT THE AGENCY OF TRANSPORTATION GARAGE
MARBORO, VERMONT

| | | | |
|-------------------------|-----------------------------|------------|--------------------|
| DATE: APRIL 17, 1961 | SCALE: AS SHOWN | REVISIONS: | DWG. NO. 1 OF 1 |
| DRAWN BY: HAYSON | APPROVED BY: [Signature] | | |