



FLOOR PLAN
SCALE: 1/4" = 1'-0"


NOTE:
ALL DUCTWORK TO BE HUNG FROM CEILING

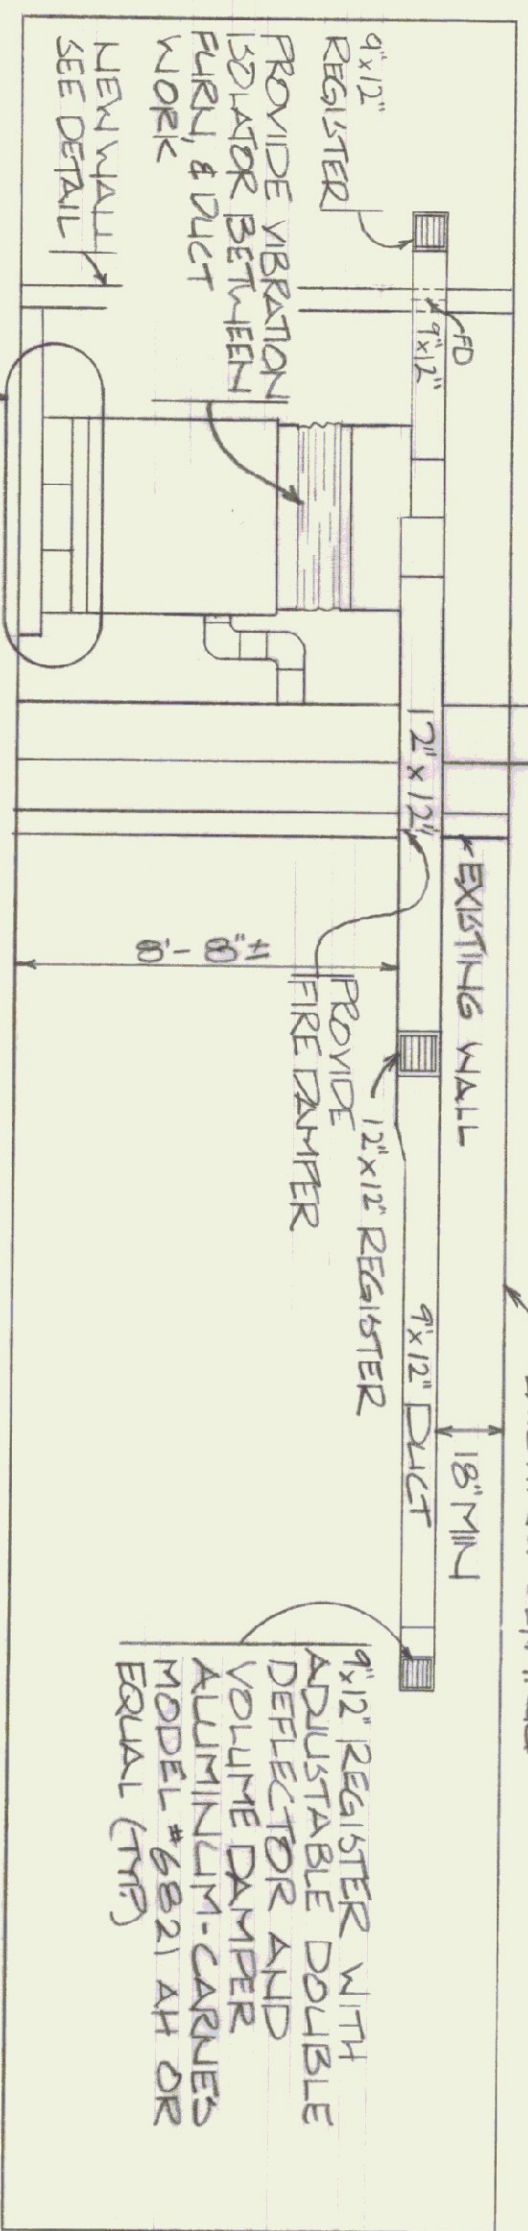

NEWMAC GL-1156
WOOD/COAL/OIL
FURNACE

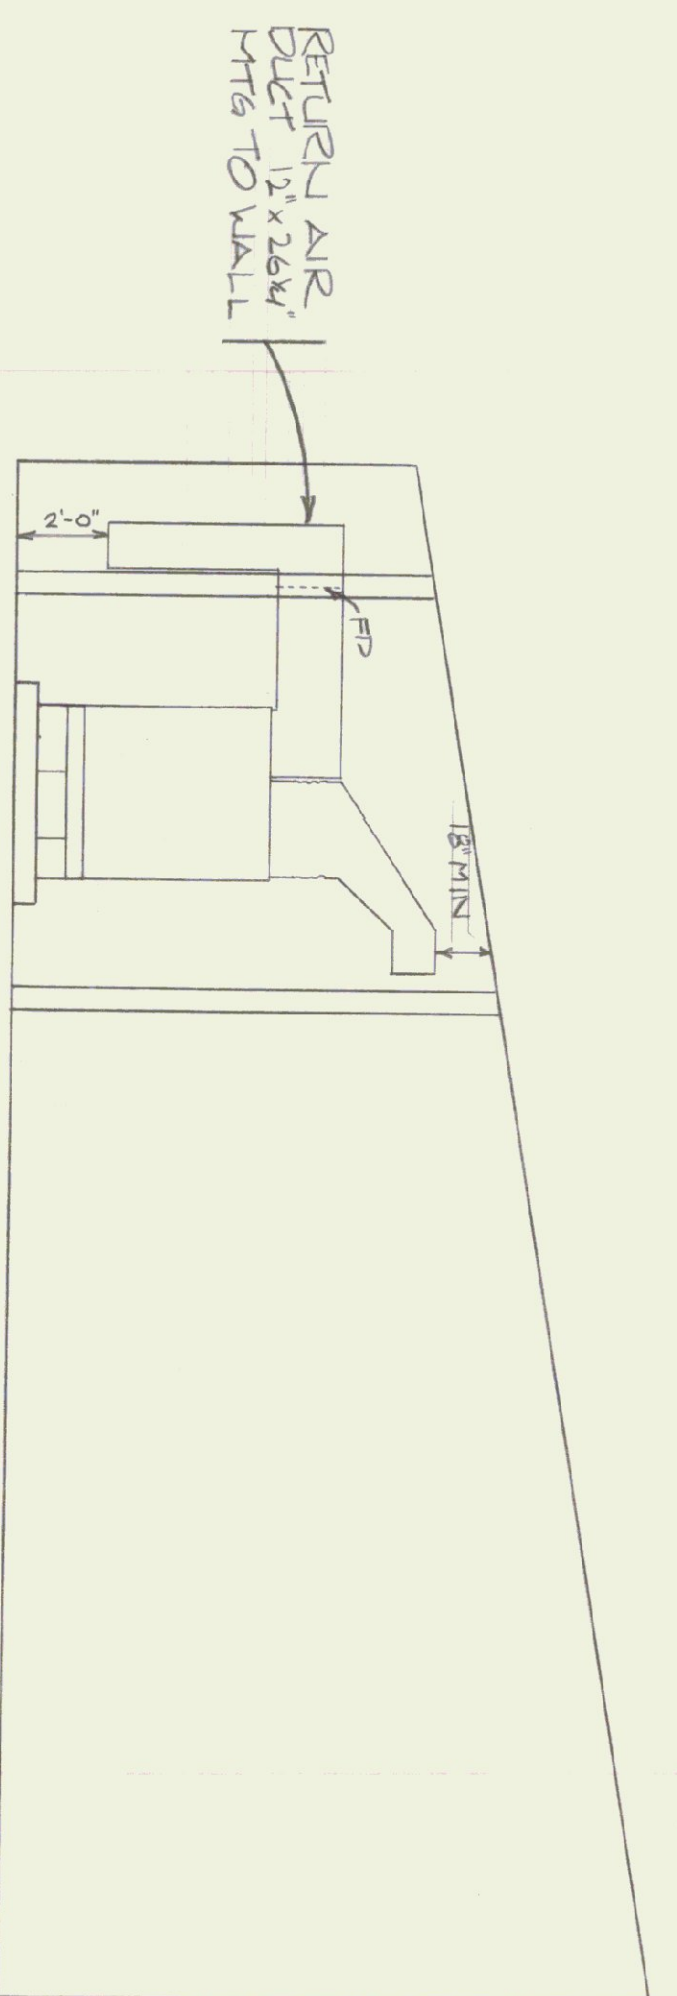

SECTION B-B
SCALE: 1/4" = 1'-0"

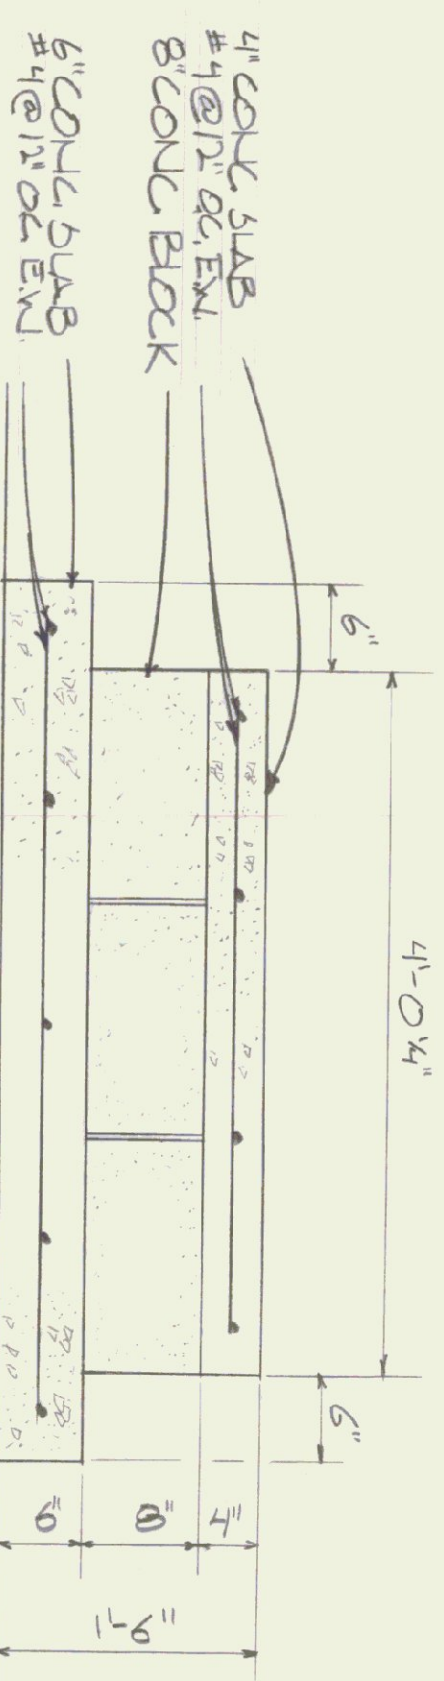

- NOTES:
1. ALL DUCTWORK SHALL BE 24 GA GAVALVANIZED METAL
 2. ALL WIRING TO BE IN EMT MINIMUM 4" ABOVE GRADE
 3. CONCRETE AND CARPENTRY WORK NOT IN CONTRACT
 4. PROVIDE FIRE DAMPERS IN SUPPLY AND RETURN DUCTS THROUGH PARTITIONS

NOTE: GYP BOARD LOCATED ON INSIDE WALL OF FURNACE RM

