



**HOT & COLD WATER PIPING PLAN**  
SCALE: 1/8" = 1'-0" AND 1/4" = 1'-0"

**PLUMBING SYMBOLS FOR PIPING, VALVES & FITTINGS**

	COLD WATER PIPE		HOT WATER PIPE
	P-TRAP		FLOOR DRAIN W/P TRAP
	TOILET FLANSIE		FLOOR CLEANOUT
	UNION		HOSE BIB
	WATER HAMMER ARRESTER		PRESSURE & TEMP RELIEF VALVE
	CHECK VALVE		GATE OR BALL VALVE
	DRAINAGE VALVE		BACKFLOW PREVENTER
	PRESSURE & TEMP RELIEF VALVE		WATER HAMMER ARRESTER

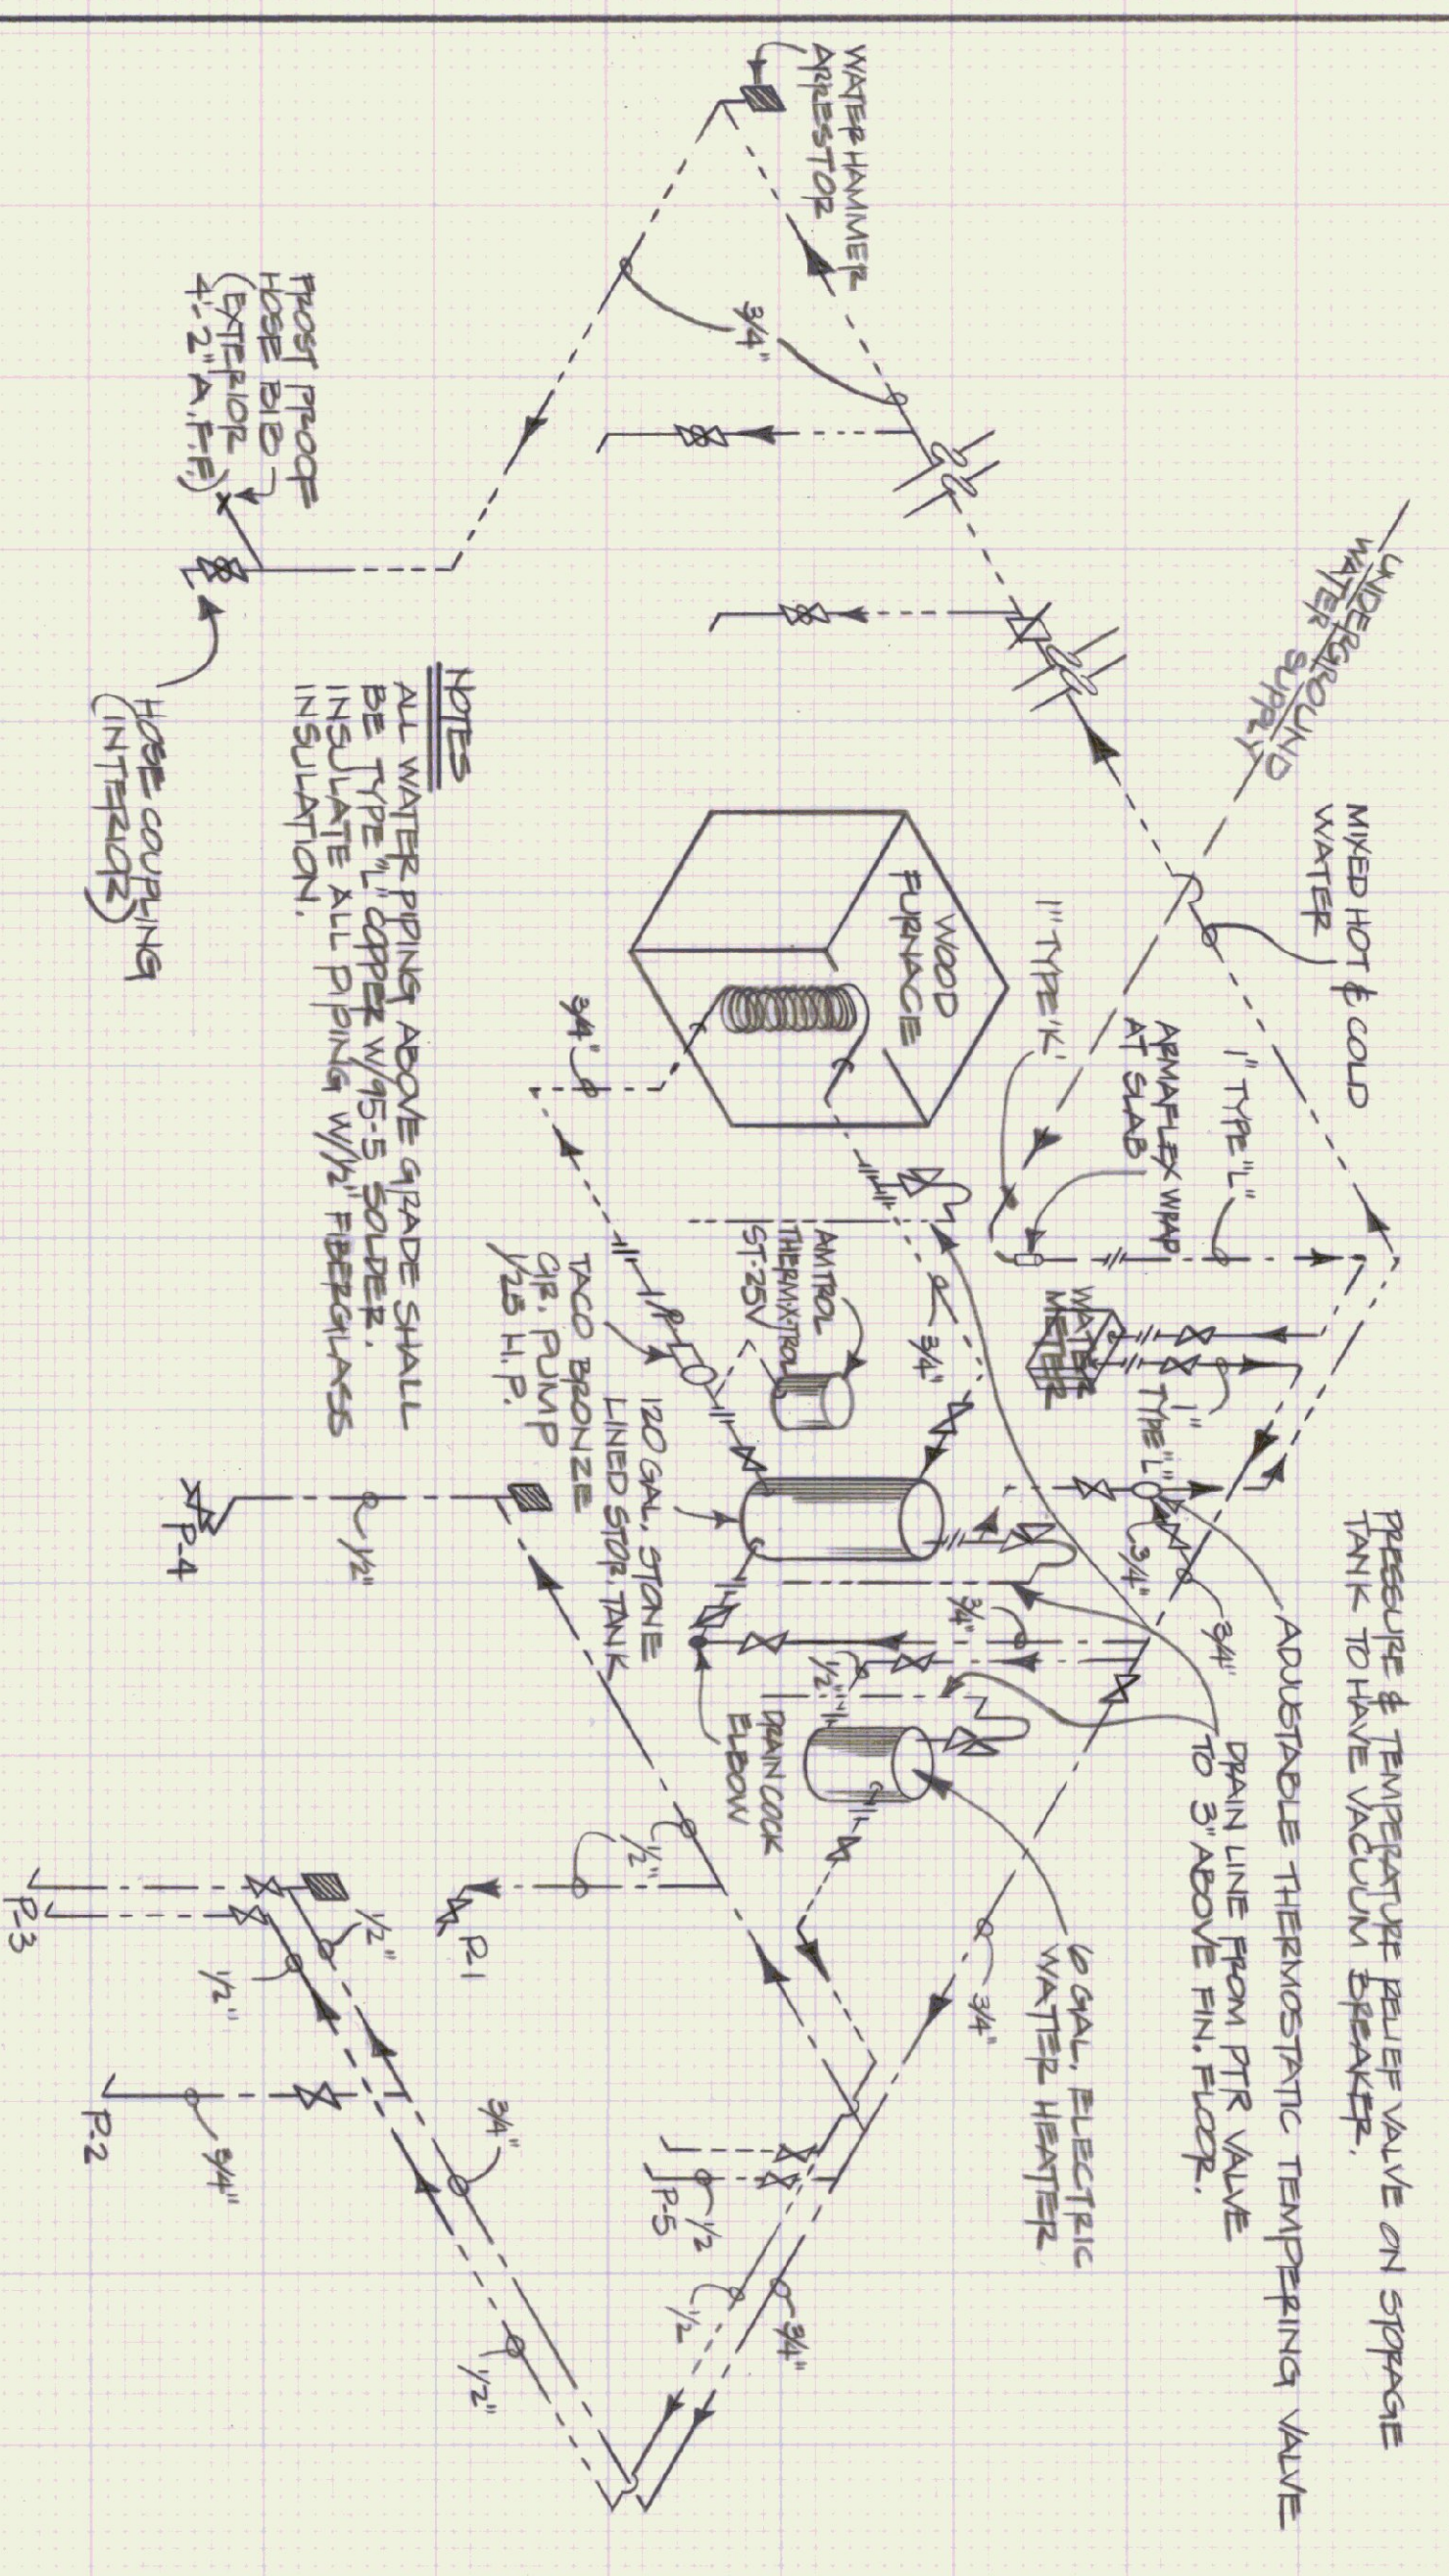


**HOT & COLD WATER PIPING RISER DIAGRAM**  
NOT TO SCALE

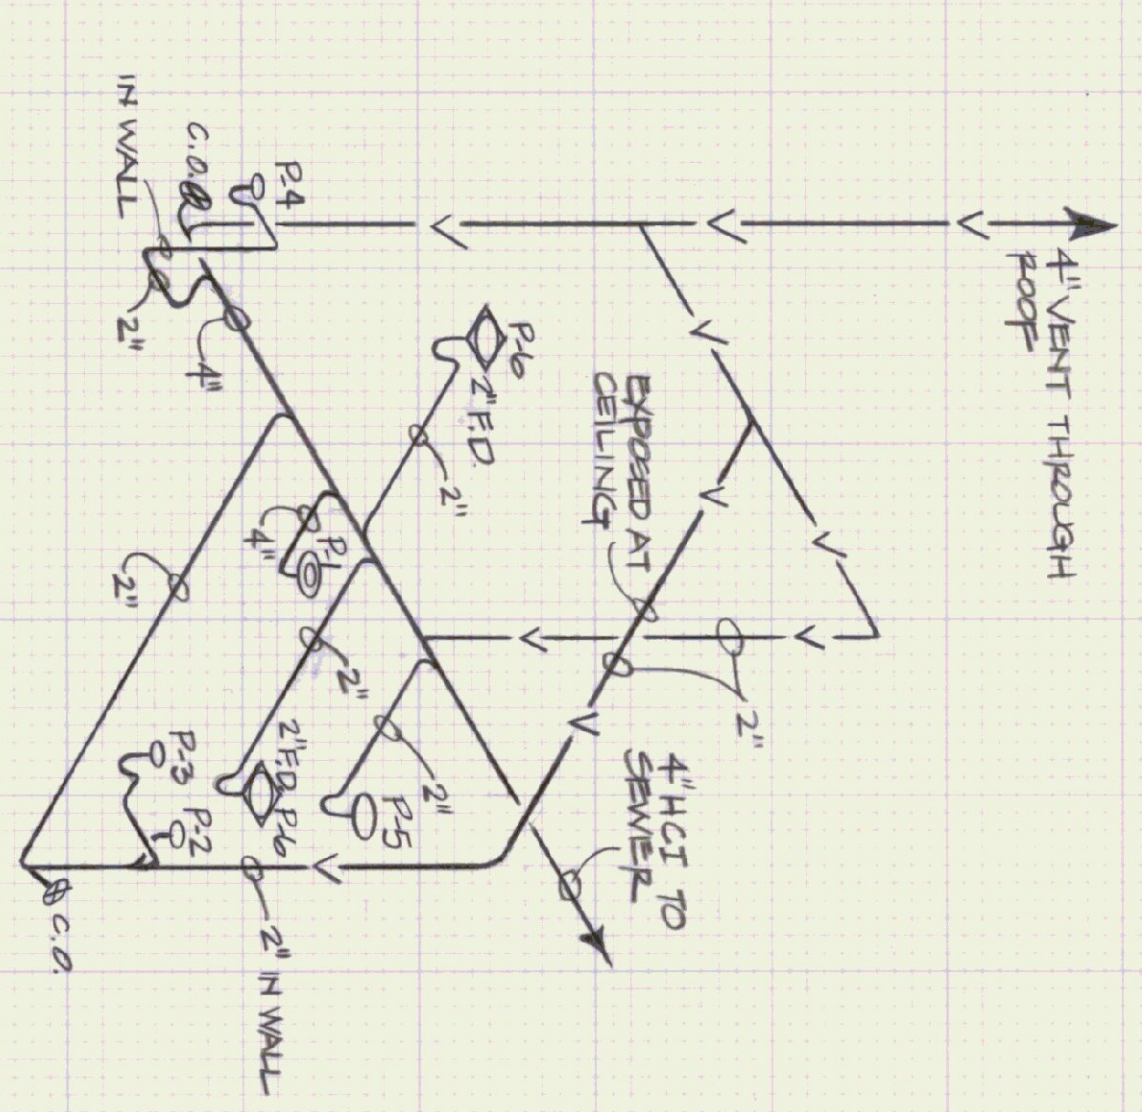

**SANITARY WASTE & VENT PIPE RISER DIAGRAM**  
NOT TO SCALE

**FIGURE SCHEDULE**

APP.	FIXTURE	DESCRIPTION	NOTES	DRAIN	VENT	COLD	HOT
P-1	TOILET	AMERICAN STANDARD "EAGLE" # 2005-500 WHITE VITREOUS CHINA, HANDICAP, FLOOR MOUNT, TANK TYPE ELONGATED, WATER SAVING, SIFON JET ACTION, COSE COUPLED WITH AQUA-GARD LINES, 16" HIGH, SEAT TO BE ELONGATED, OPEN FRONT WITH FOOT CAPS, PROVIDE SUPPLY STOP.		4"	2"	1/2"	-
P-2	URINAL	AMERICAN STANDARD "WASHBROOK" # 6501, 010, 3/4" TOP SPUD, WHITE VITREOUS CHINA, WALL HUNG, WASH OUT URINAL, WITH SWAN PAVIL 180 FLUSH VALVE & COMPATIBLE CARRIER.		2"	2"	3/4"	-
P-3	W/ATTRY	AMERICAN STANDARD "LUCERNE" # 0055-012, 20" X 18" WALL HUNG, WHITE VITREOUS CHINA, FRONT OPERATION, 41 CENTER PRUSET HOLES, & PROVIDED W/ WAND CONTROL ARM CARRIER. FITTINGS SHALL BE CHROME SINGLE LEVER CONTROL W/ P-TRAP & P-TRAP AMERICAN STANDARD "CERAMIX" MODEL 2000-101.		2"	2"	1/2"	1/2"
P-4	DRINKING FOUNTAIN	AMERICAN STANDARD # 8910-112 WHITE VITREOUS CHINA, SELF CLOSING VALVE. PROVIDE W/P-TRAP.		4"	4"	1/2"	-
P-5	SHOWER STALL	FIBERGLASS, 36" X 54", DURASTAL MODEL 144, WHITE. FITTINGS: CHROME SINGLE LEVER CONTROL, RESURGE BALANCED WITH OVERFLOW STOP. AMERICAN STANDARD "CEPANMAX" MODEL # 2000-501. PROVIDE A CHROME STRAINER AND P-TRAP.		2"	2"	1/2"	1/2"
P-6	FLOOR DRAINS	SCOTTED ROUND CENR. DRAIN SHALL DISCHARGE THROUGH A P-TRAP. OUTLET OF P-TRAP SHALL HAVE A TWO INCH CLEANOUT.		PROVIDE W/ TRAP PRIMER FROM COLD WATER W/ ATTRY.	2"	-	-
P-7	HOT WATER HEATER	6 GAL. ENERGY SAVING WITH P-67 FOAM INSULATION) 7 GPH RECOVERY, AT 90° TEMP. RISE. BRADPOD WHITE MODEL "MIDRESS OR APPROVED EQUAL".	AS INDICATED OR REQUIRED BY CODE. CLEANOUTS SAME SIZE AS P-TRAP. FLOOR CLEANOUTS TO BE SET FLUSH W/ FLOOR. WALL C.O.'S SHALL BE ZUPIN MODEL Z 1400-2 OR APPROVED EQUAL. WALL C.O.'S SHALL BE ZUPIN MODEL Z 1400-1 OR APPROVED EQUAL.		1/2"	1/2"	-

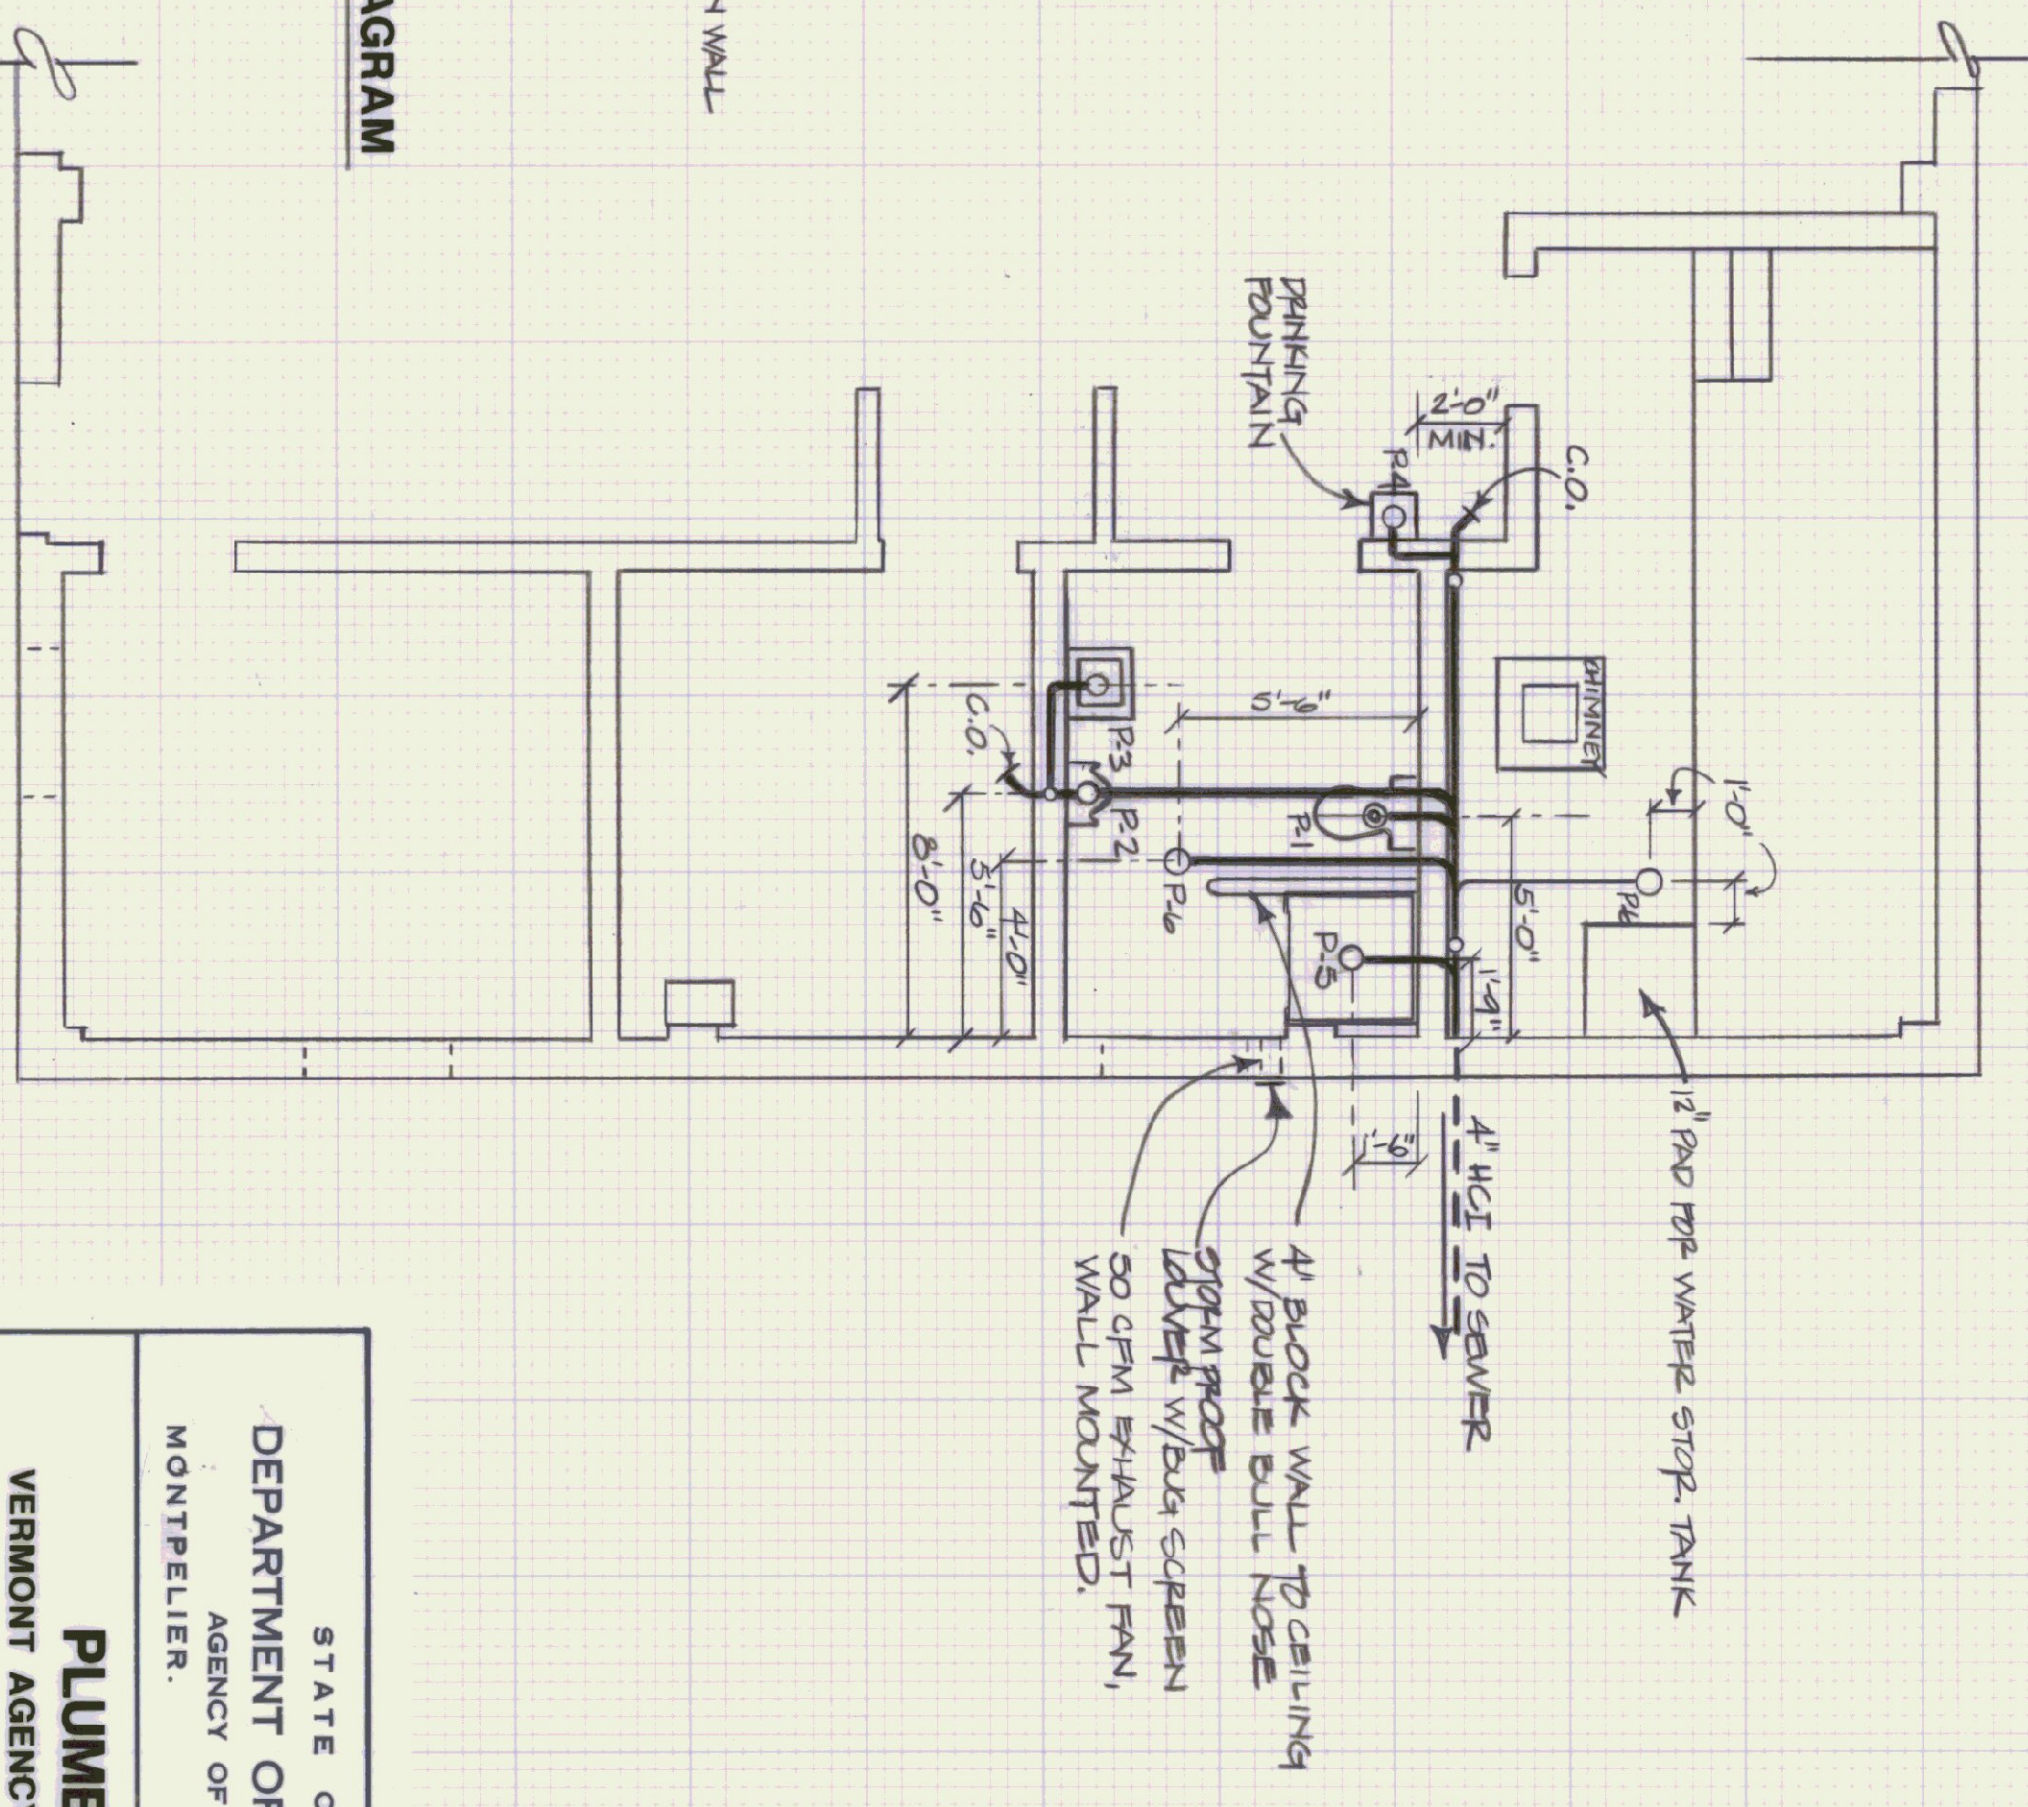

**SANITARY WASTE & VENT PLAN**  
SCALE: 1/4" = 1'-0"

STATE OF VERMONT  
DEPARTMENT OF STATE BUILDINGS  
AGENCY OF ADMINISTRATION  
MONTPELIER, VERMONT

**PLUMBING PLAN**  
VERMONT AGENCY OF TRANSPORTATION  
6 BAY MAINTENANCE GARAGE  
VERMONT  
CLARENDON

DATE: APRIL 19, 1993  
DRAWN BY: A. FOULIN  
APPROVED BY: F. TRANT

SCALE: AS NOTED  
REVISIONS:

DWG. NO. P-1  
16 OF 23