


NOTES:  
 1) SITE WORK WILL BE PREPARED BY  
 MONT PELIER TO SCHEDULE WORK.  
 2) SEE NOTE ON SHEET A-1 FOR EROUND  
 & BASTEN FOUND.

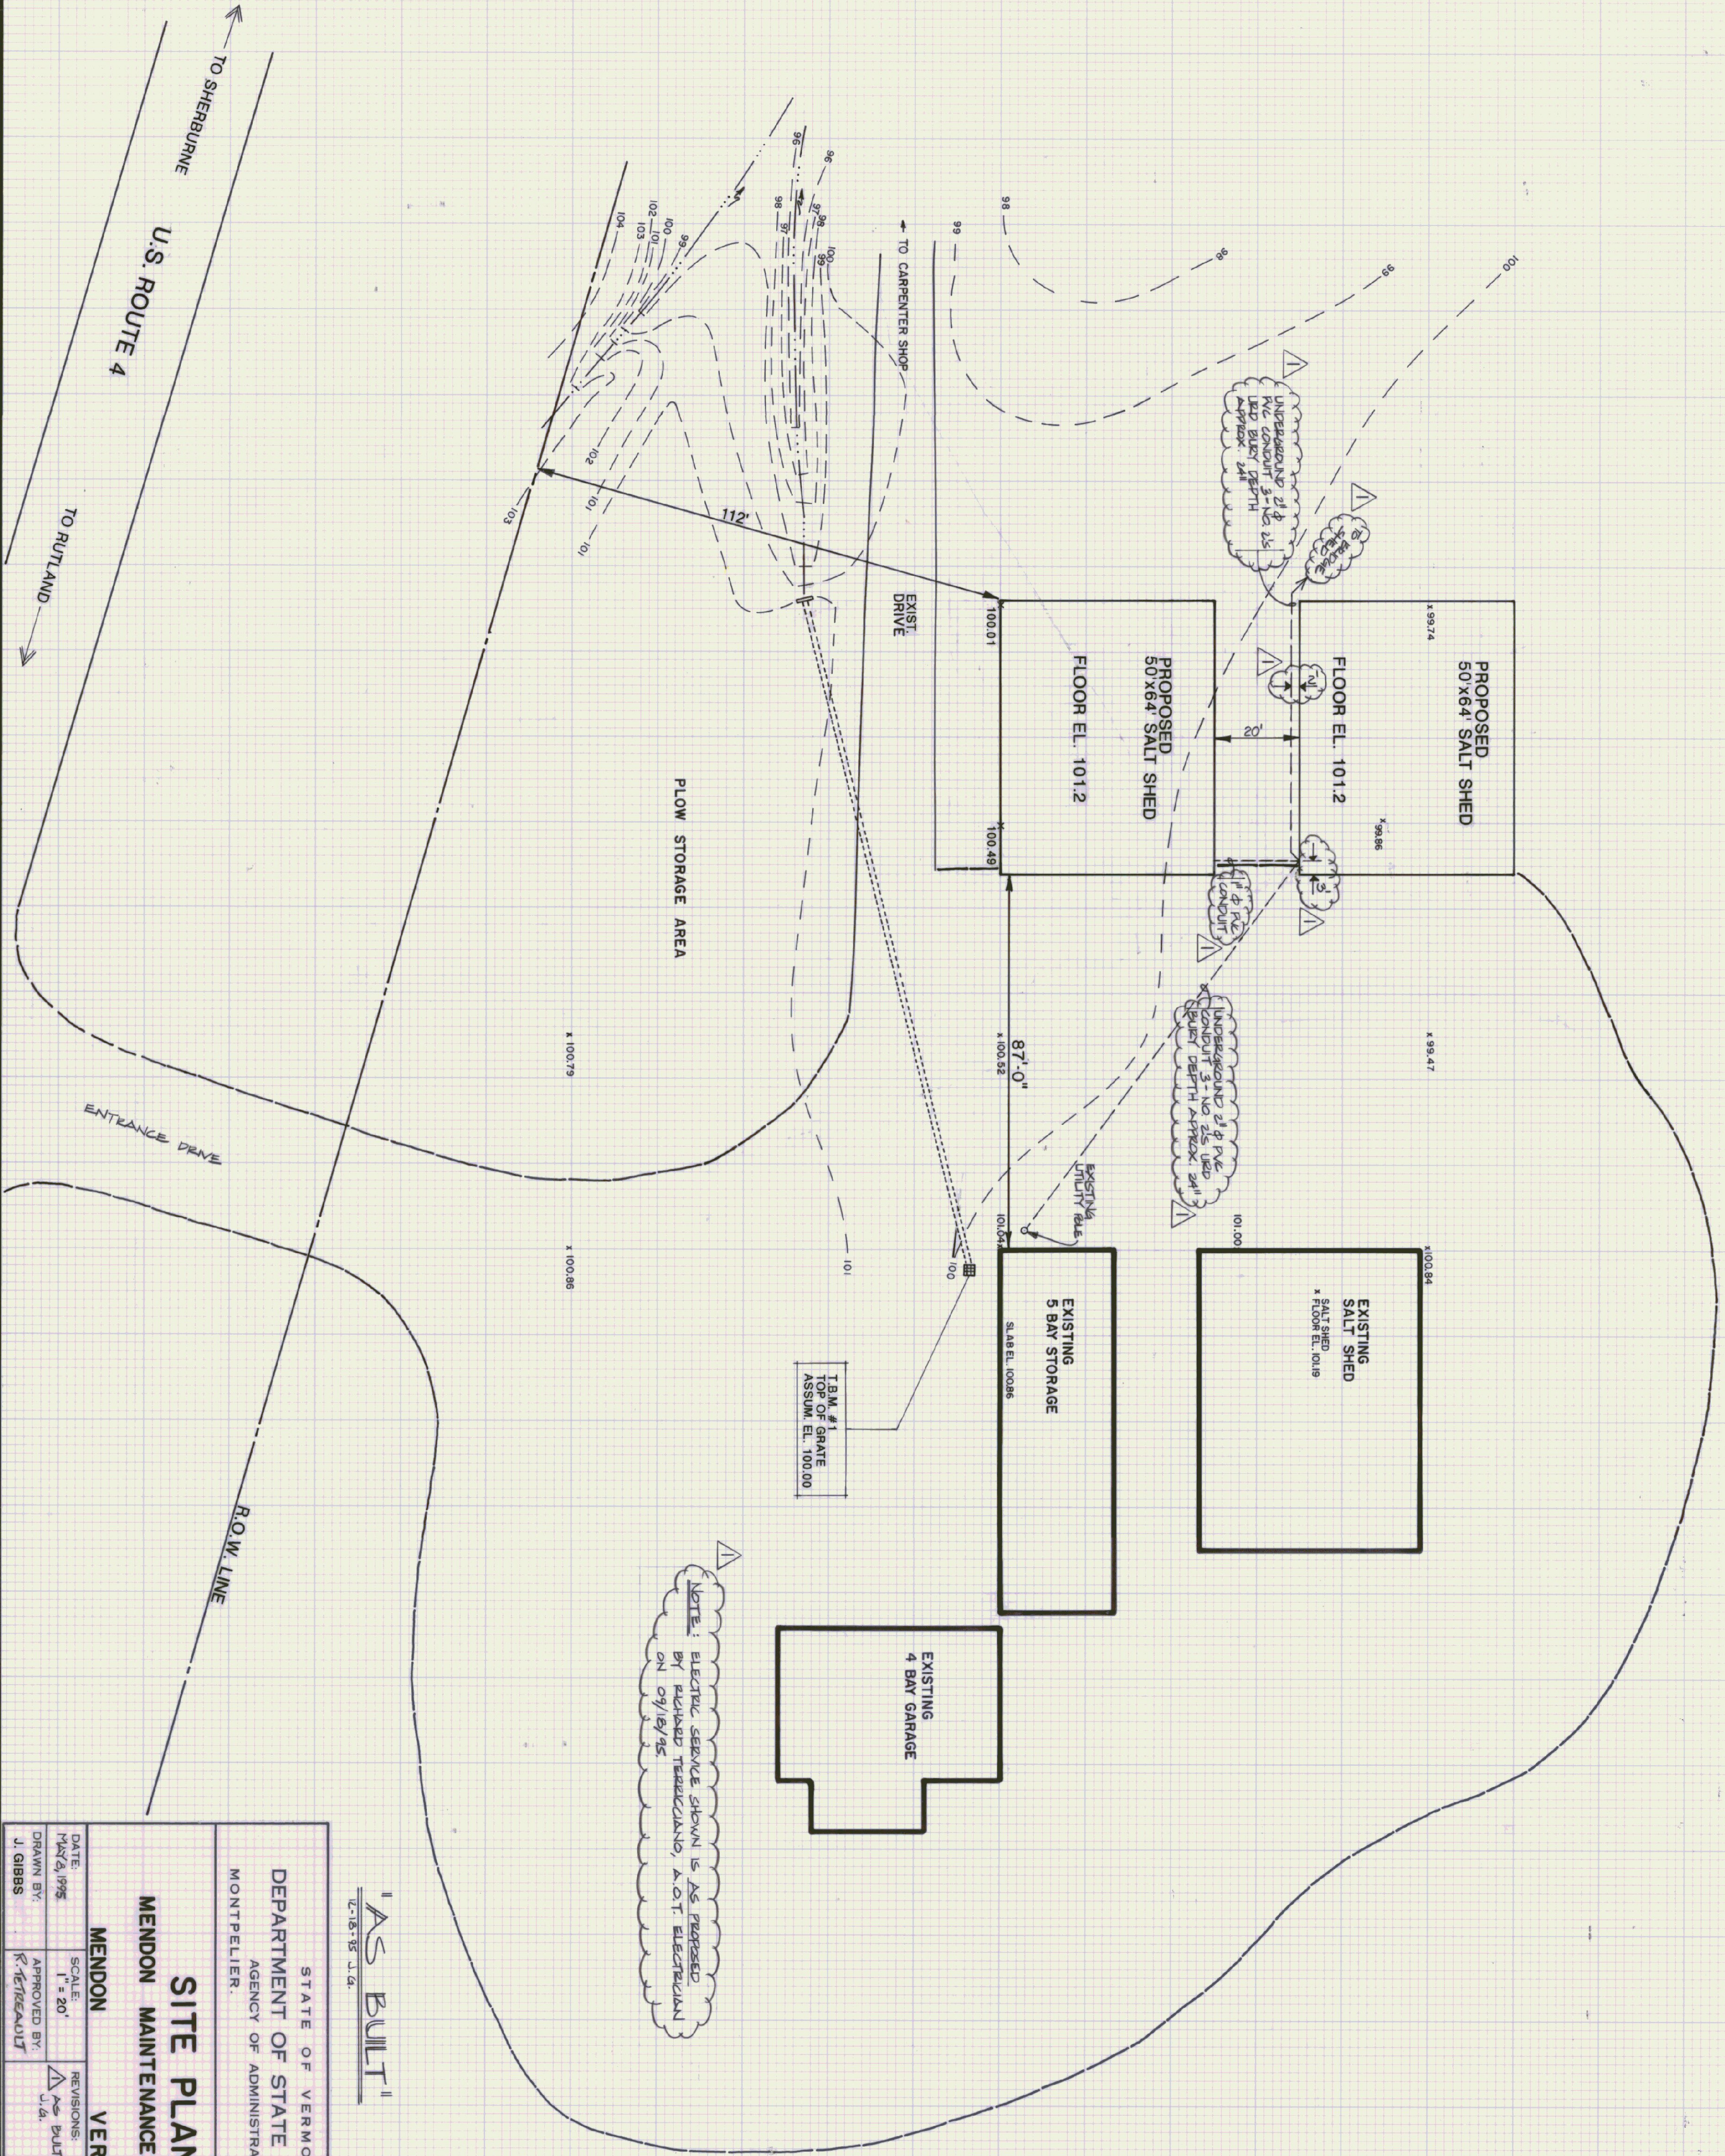

NOTE: ELECTRICAL SERVICE SHOWN IS AS PROPOSED BY RICHARD TERRELLANO, A.O.T. ELECTRICIAN ON 09/16/75

"AS BUILT"

STATE OF VERMONT  
 DEPARTMENT OF STATE BUILDINGS  
 AGENCY OF ADMINISTRATION  
 MONTPELIER, VERMONT

**SITE PLAN**  
 MENDON MAINTENANCE FACILITY

DATE May 2, 1975	SCALE 1" = 20'	REVISIONS AS BUILT	DWG. NO. S-1
DRAWN BY J. GIBBS	APPROVED BY K. TERRELLANO		1 OF 2