


FLOOR PLAN
SCALE: 1/8" = 1'-0"

NOTE: 181 THERMOSTAT FOR WOOD FURNACE TO BE MOUNTED 5'-0" FROM FLOOR. RELOCATE EXIST. THERMOSTAT

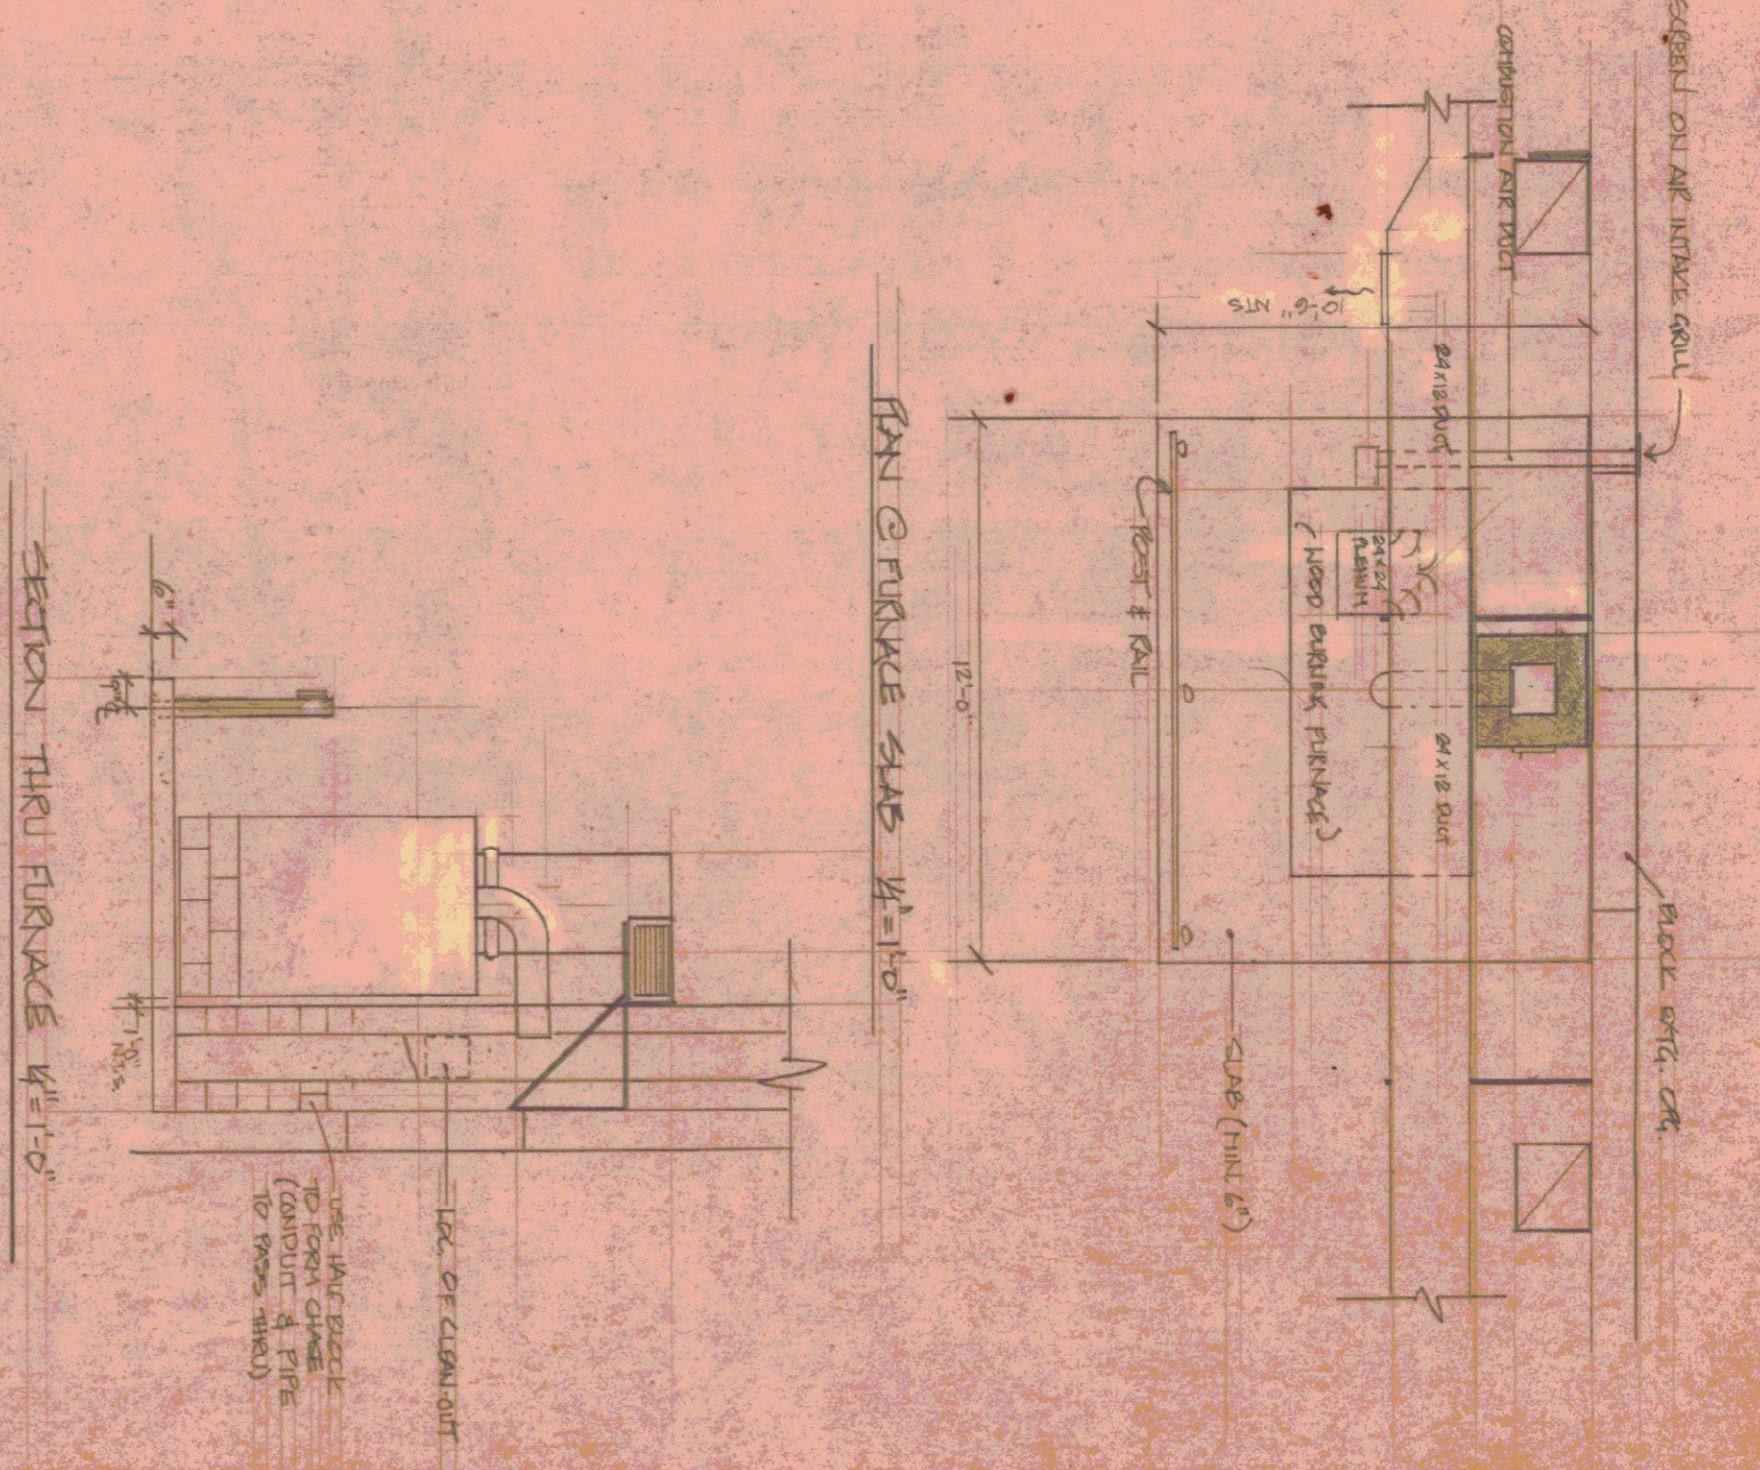

SECTION THRU FURNACE 1/4" = 1'-0"

NOTE: THESE DETAILS ARE SCHEDULED IN INTENT OF DETAILS ON SHEET 2 AND INTERIOR

STATE OF VERMONT
DIVISION OF STATE BUILDINGS
AGENCY OF ADMINISTRATION
MONTPELIER, VERMONT

WOODBURNING FURNACE INSTALLATION
@ AGENCY OF TRANSPORTATION GARAGE
RUTLAND, VERMONT

DATE: 7-24-80	SCALE: AS NOTED	REVISIONS: 10-17-80 KH	DWG. NO. 1 OF 3
DRAWN BY: KH/KH		APPROVED BY: <i>[Signature]</i>	