

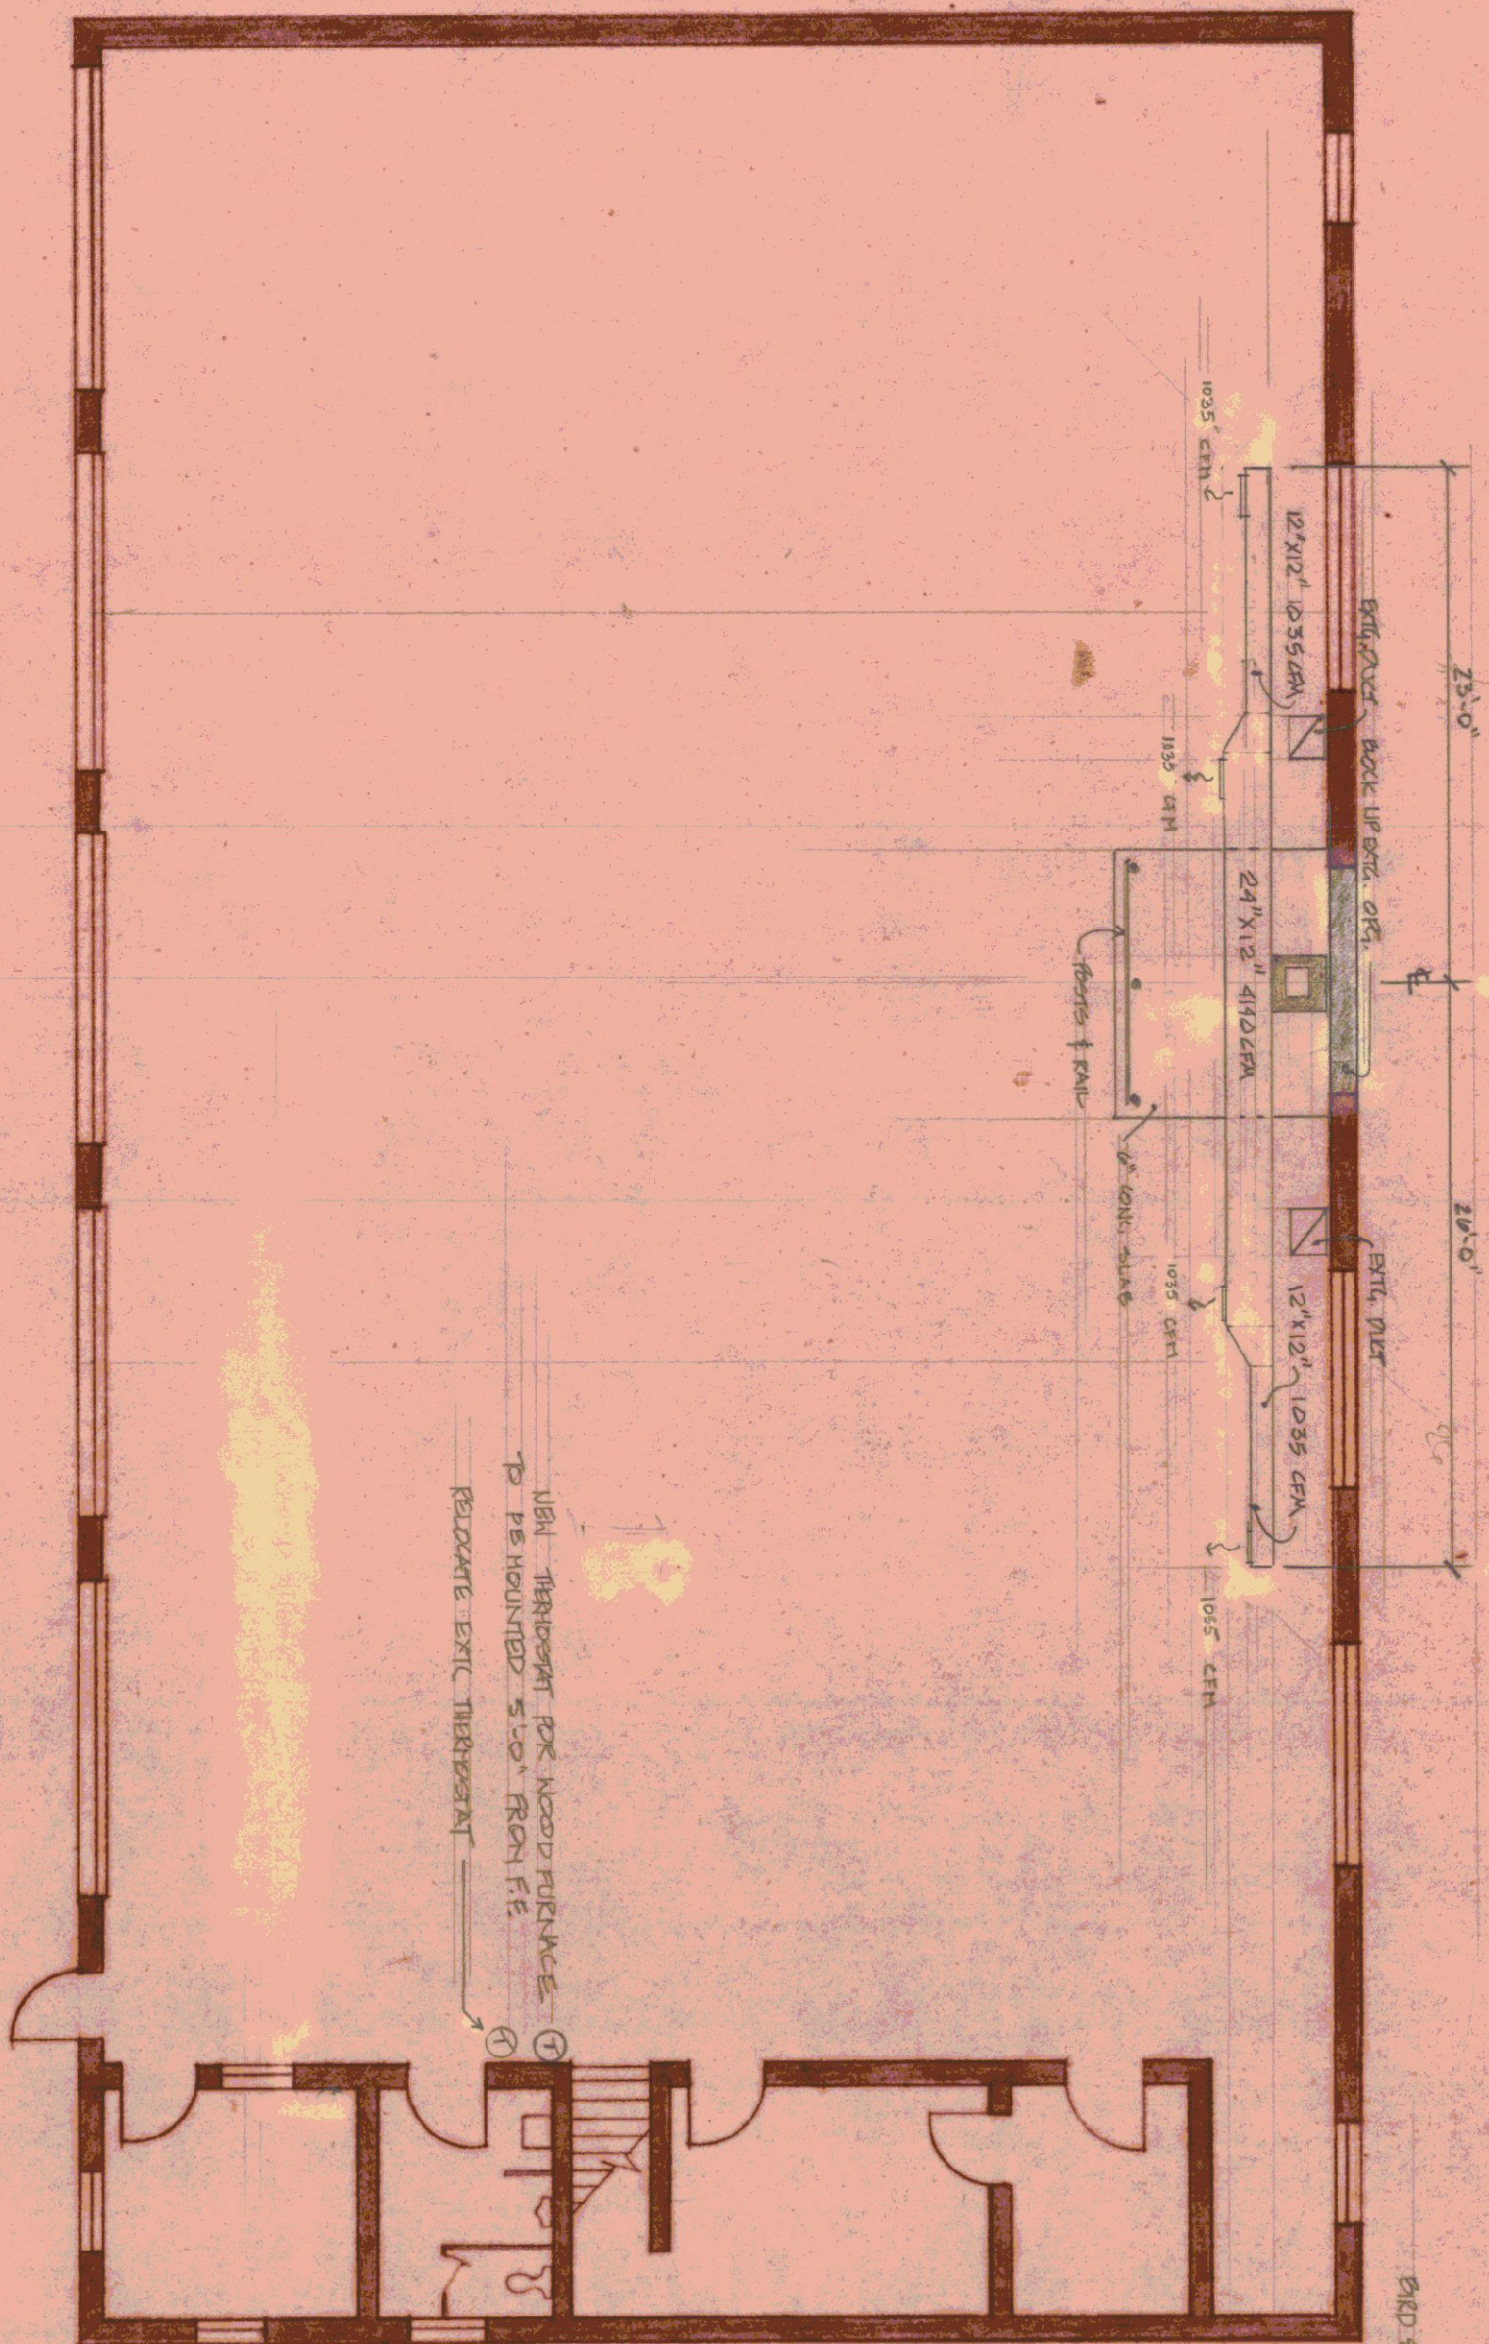


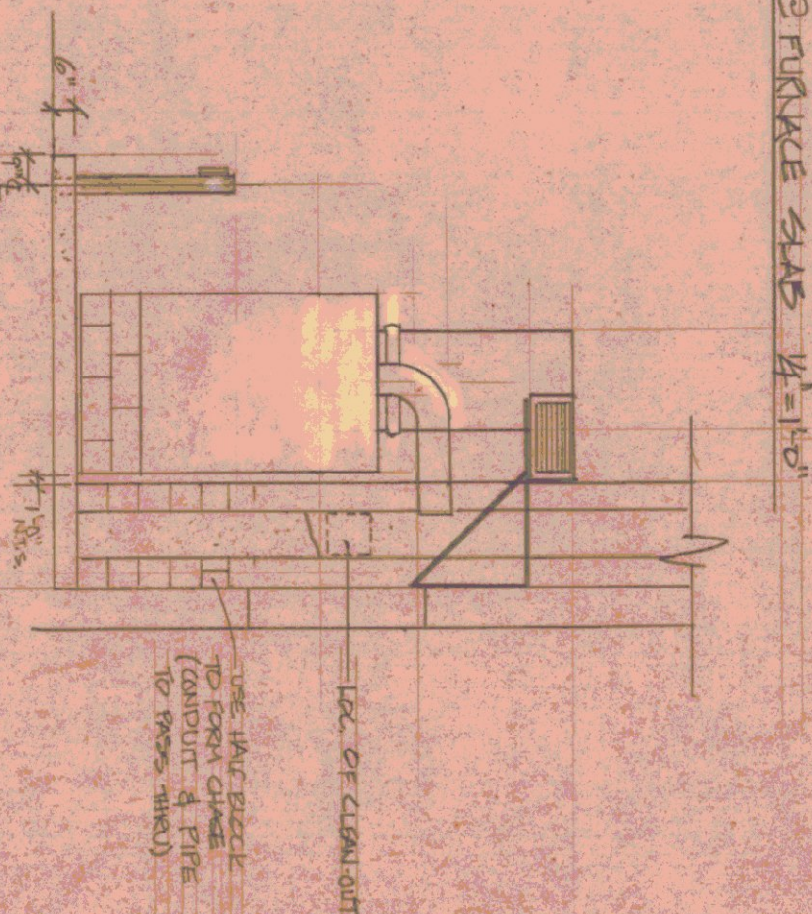

FLOOR PLAN
SCALE: 1/8" = 1'-0"

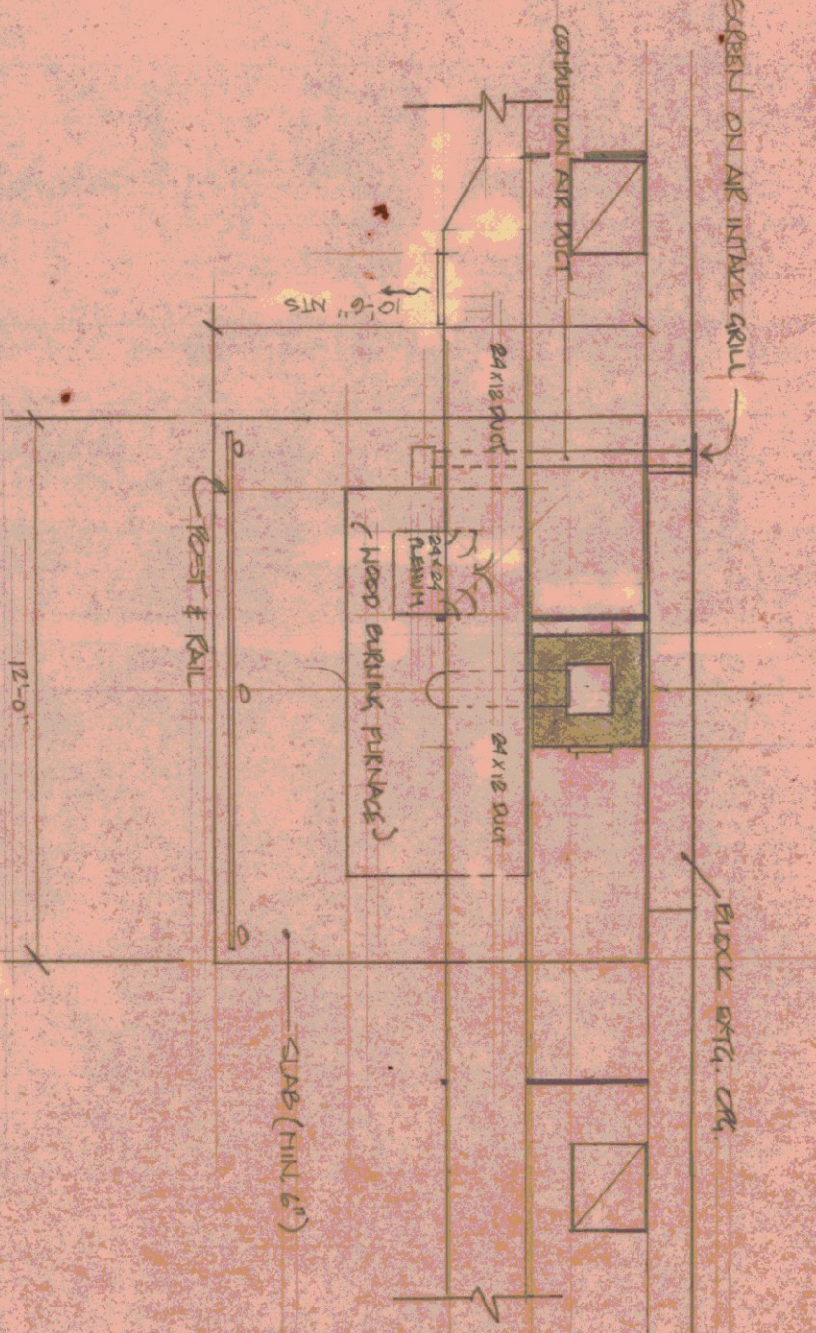

NOTE:
THREE REPAIRS ARE SCHEDULED - INTENT OF
REPAIRS ON SHIT 2 ARE INTEREST

STATE OF VERMONT			
DIVISION OF STATE BUILDINGS			
AGENCY OF ADMINISTRATION			
MONTPELIER, VERMONT			
WOODBURNING FURNACE INSTALLATION			
C AGENCY OF TRANSPORTATION GARAGE			
RUTLAND, VERMONT			
DATE: 7-24-80	SCALE: AS NOTED	REVISIONS: 10-17-80 KH	DWG. NO. 1 OF 3
DRAWN BY: KH/KH	APPROVED BY: G. M. M. M.		