



X:\031204-mech\Drawings\Mech\031204M02.dwg, M2, 06/15/2004 09:57:06 AM, © LANE ASSOCIATES CONSULTING ENGINEERS P.C., 2004

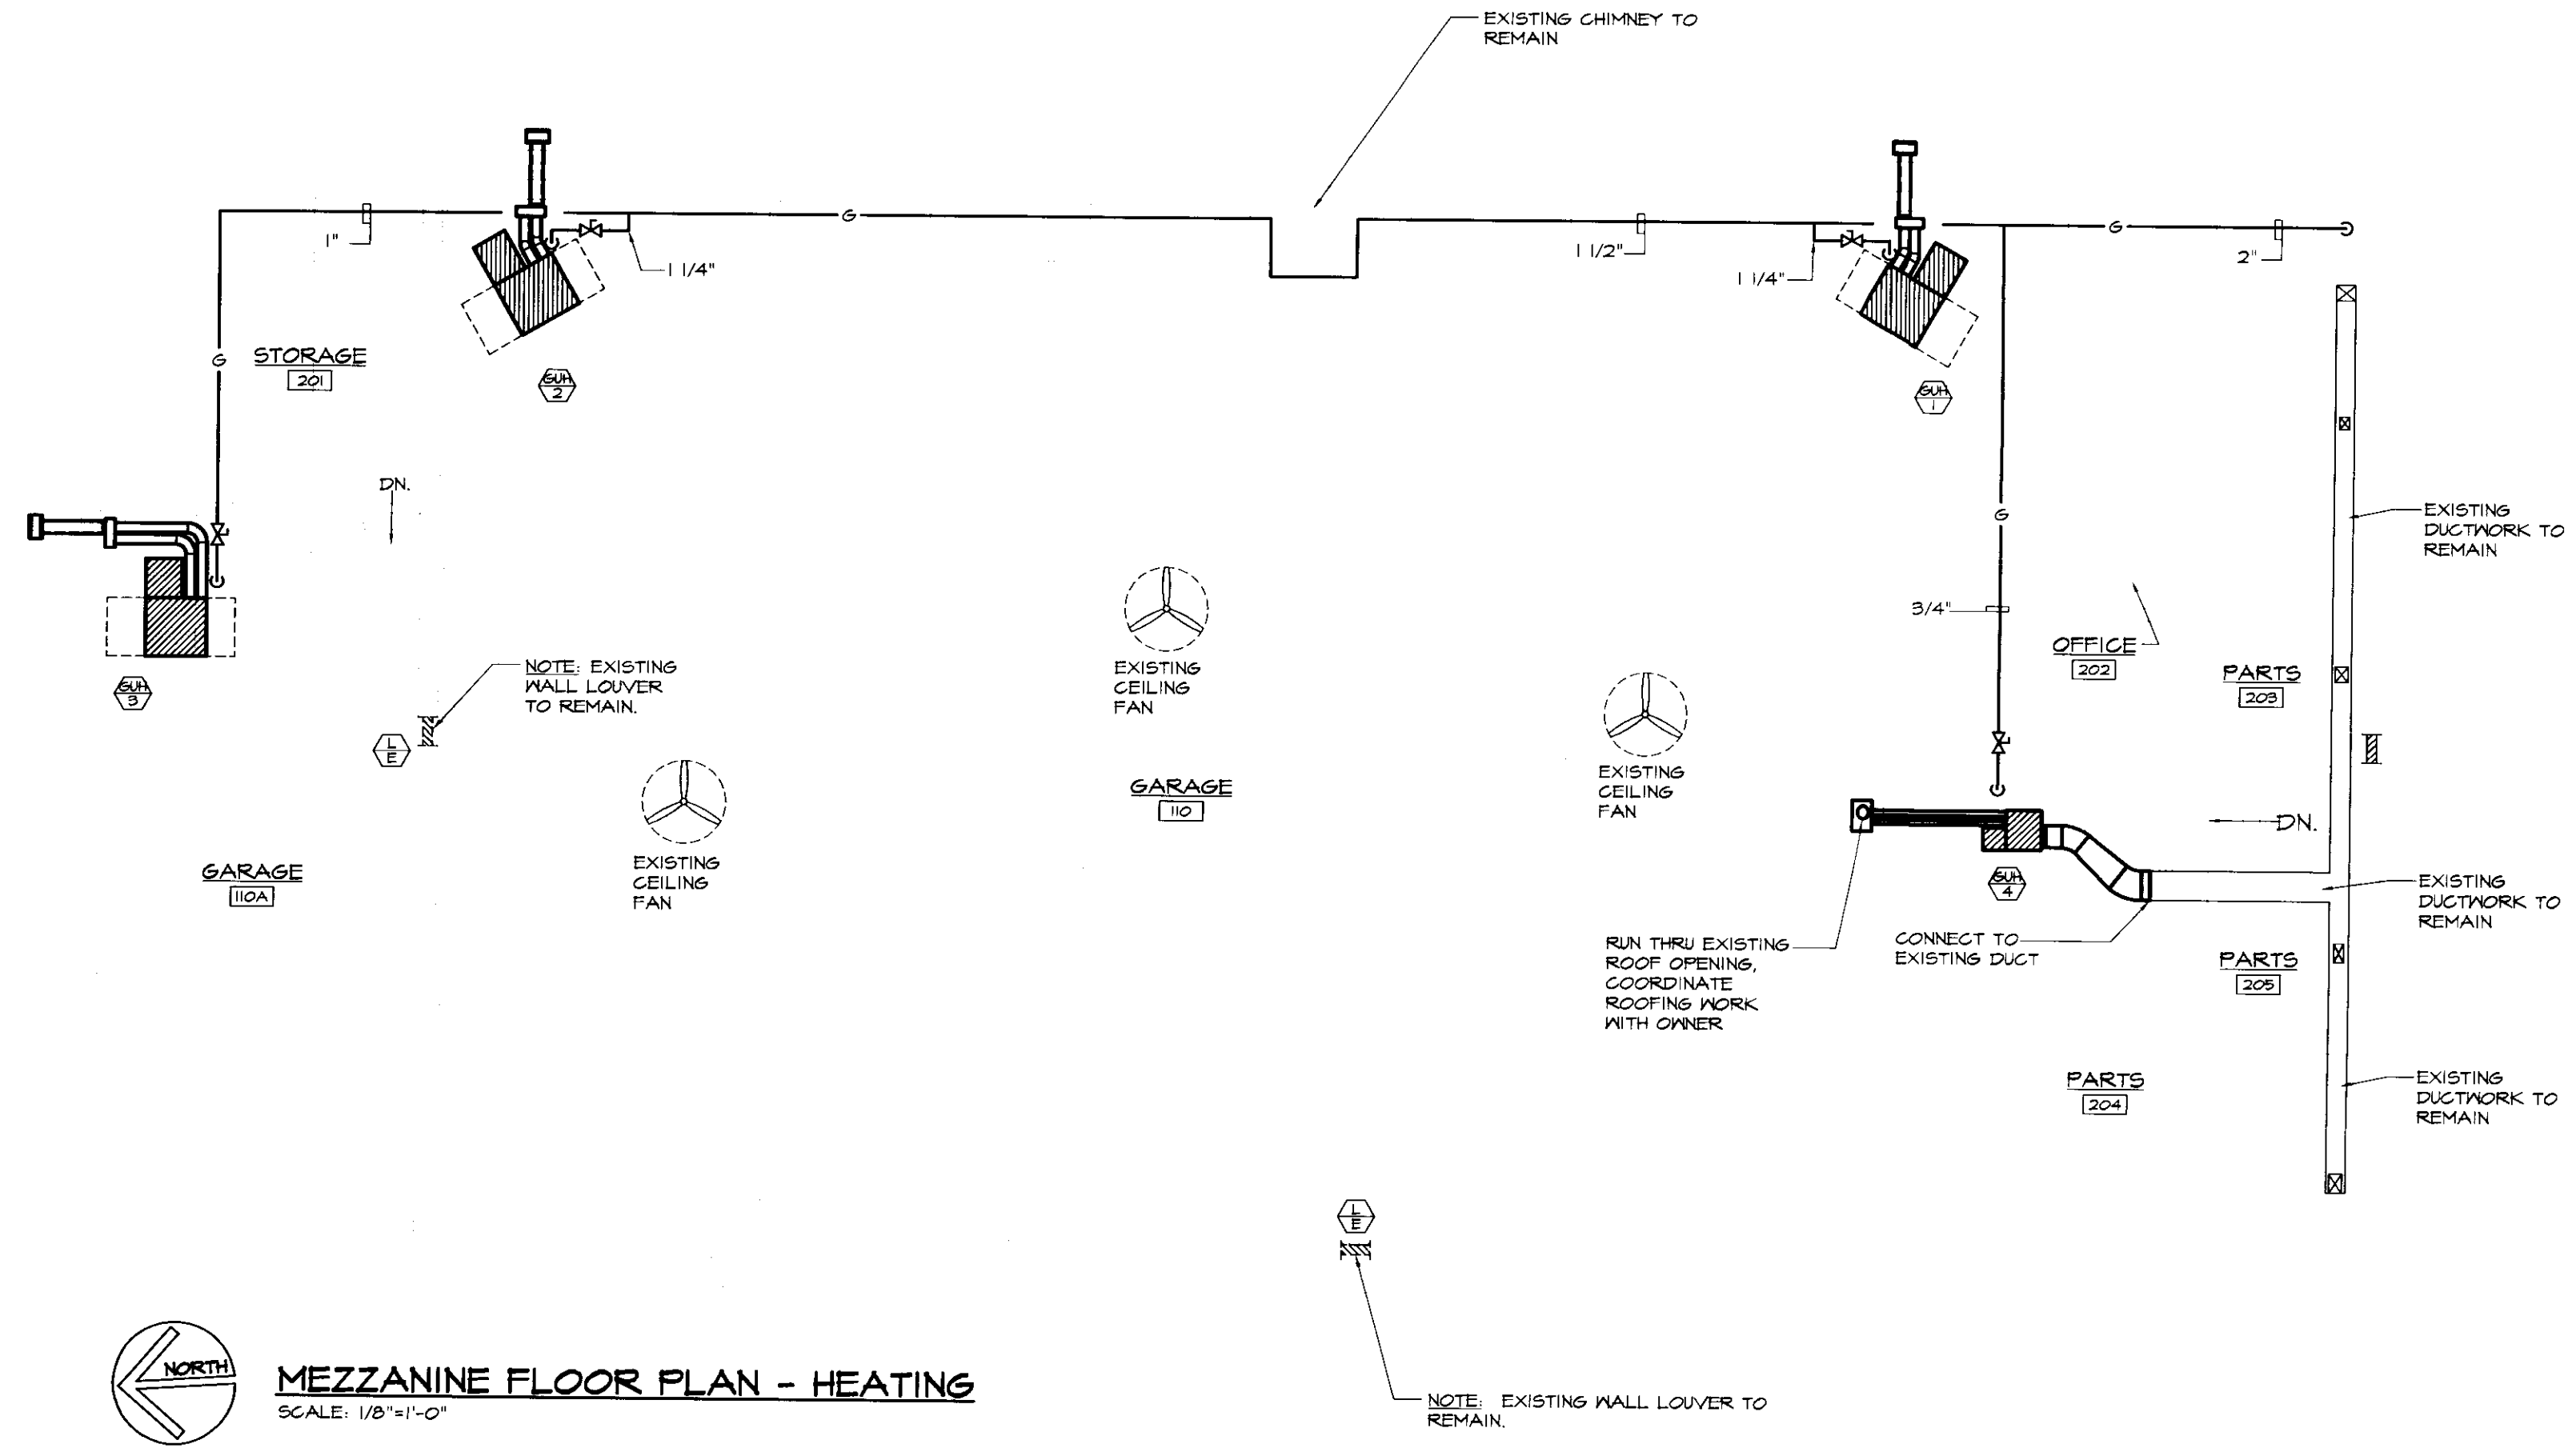

MEZZANINE FLOOR PLAN - HEATING
SCALE: 1/8"=1'-0"

EXTERIOR WASTE OIL STORAGE TANK AREA [101]

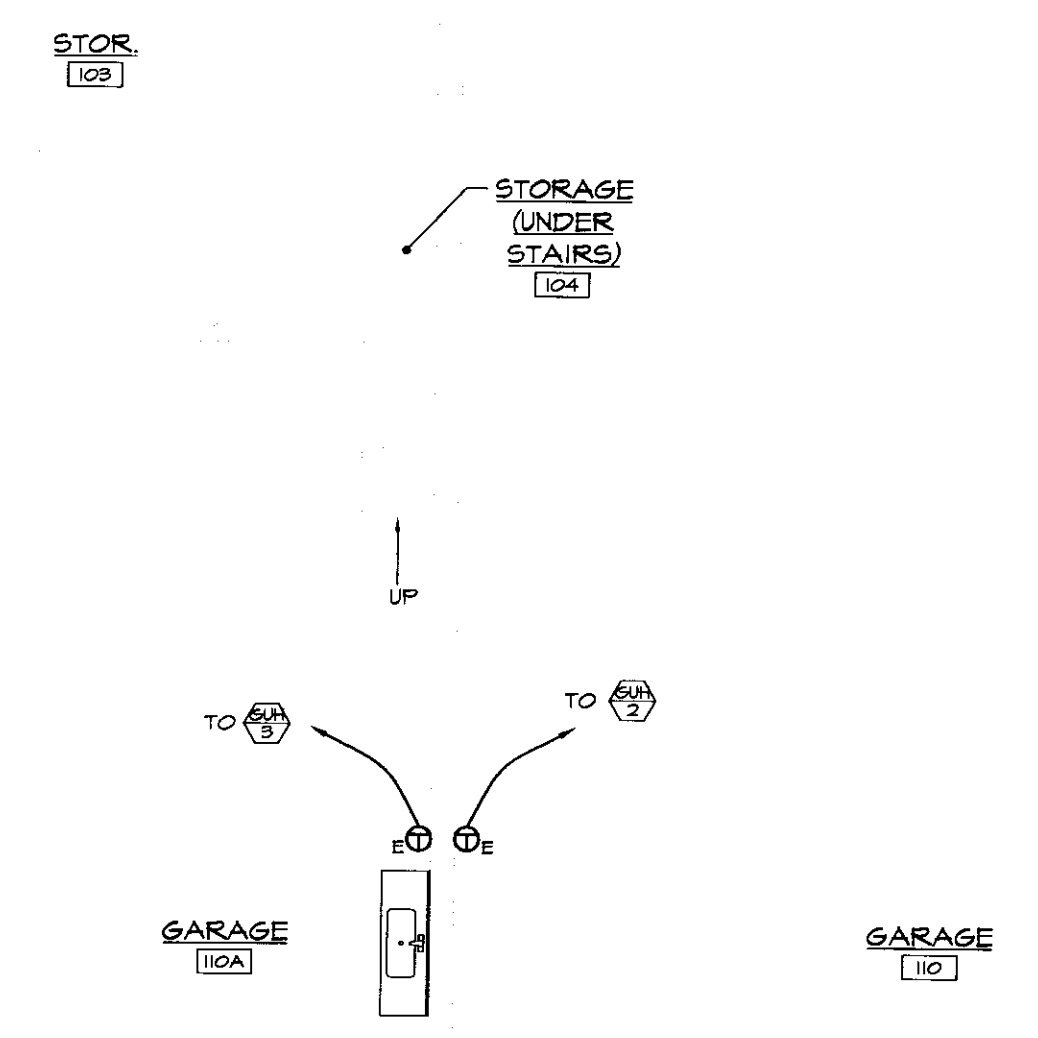

FIRST FLOOR PLAN - HEATING
SCALE: 1/8"=1'-0"

PROGRESS PRINTS NOT FOR CONSTRUCTION	NO.	ISSUED FOR	DATE
	3	REVISED FOR REFRIGING	JUNE 2004
	2	BIDDING AND CONSTRUCTION	JAN. 2004
	1	OWNERS REVIEW	JAN. 2004



HEATING, VENTILATION, & AIR CONDITIONING,
PLUMBING, FIRE PROTECTION, & ELECTRICAL

CHARLES F. LANE, P.E.
DANIEL W. DUPRAS, P.E.

51 KILLINGTON AVENUE,
RUTLAND, VERMONT 05701
TELEPHONE: (802)747-3346
FAX/MODEM: (802)747-3356

FIRST AND MEZZANINE FLOOR PLANS BASE BID HEATING SYSTEM			
RUTLAND AOT GARAGE DISTRICT 3 RUTLAND, VT 05701 NEW HEATING SYSTEM			
APPR:	DWD	DRAWN:	KPC
SCALE:	AS NOTED		PROJ. NO. 0312-04

M
2