

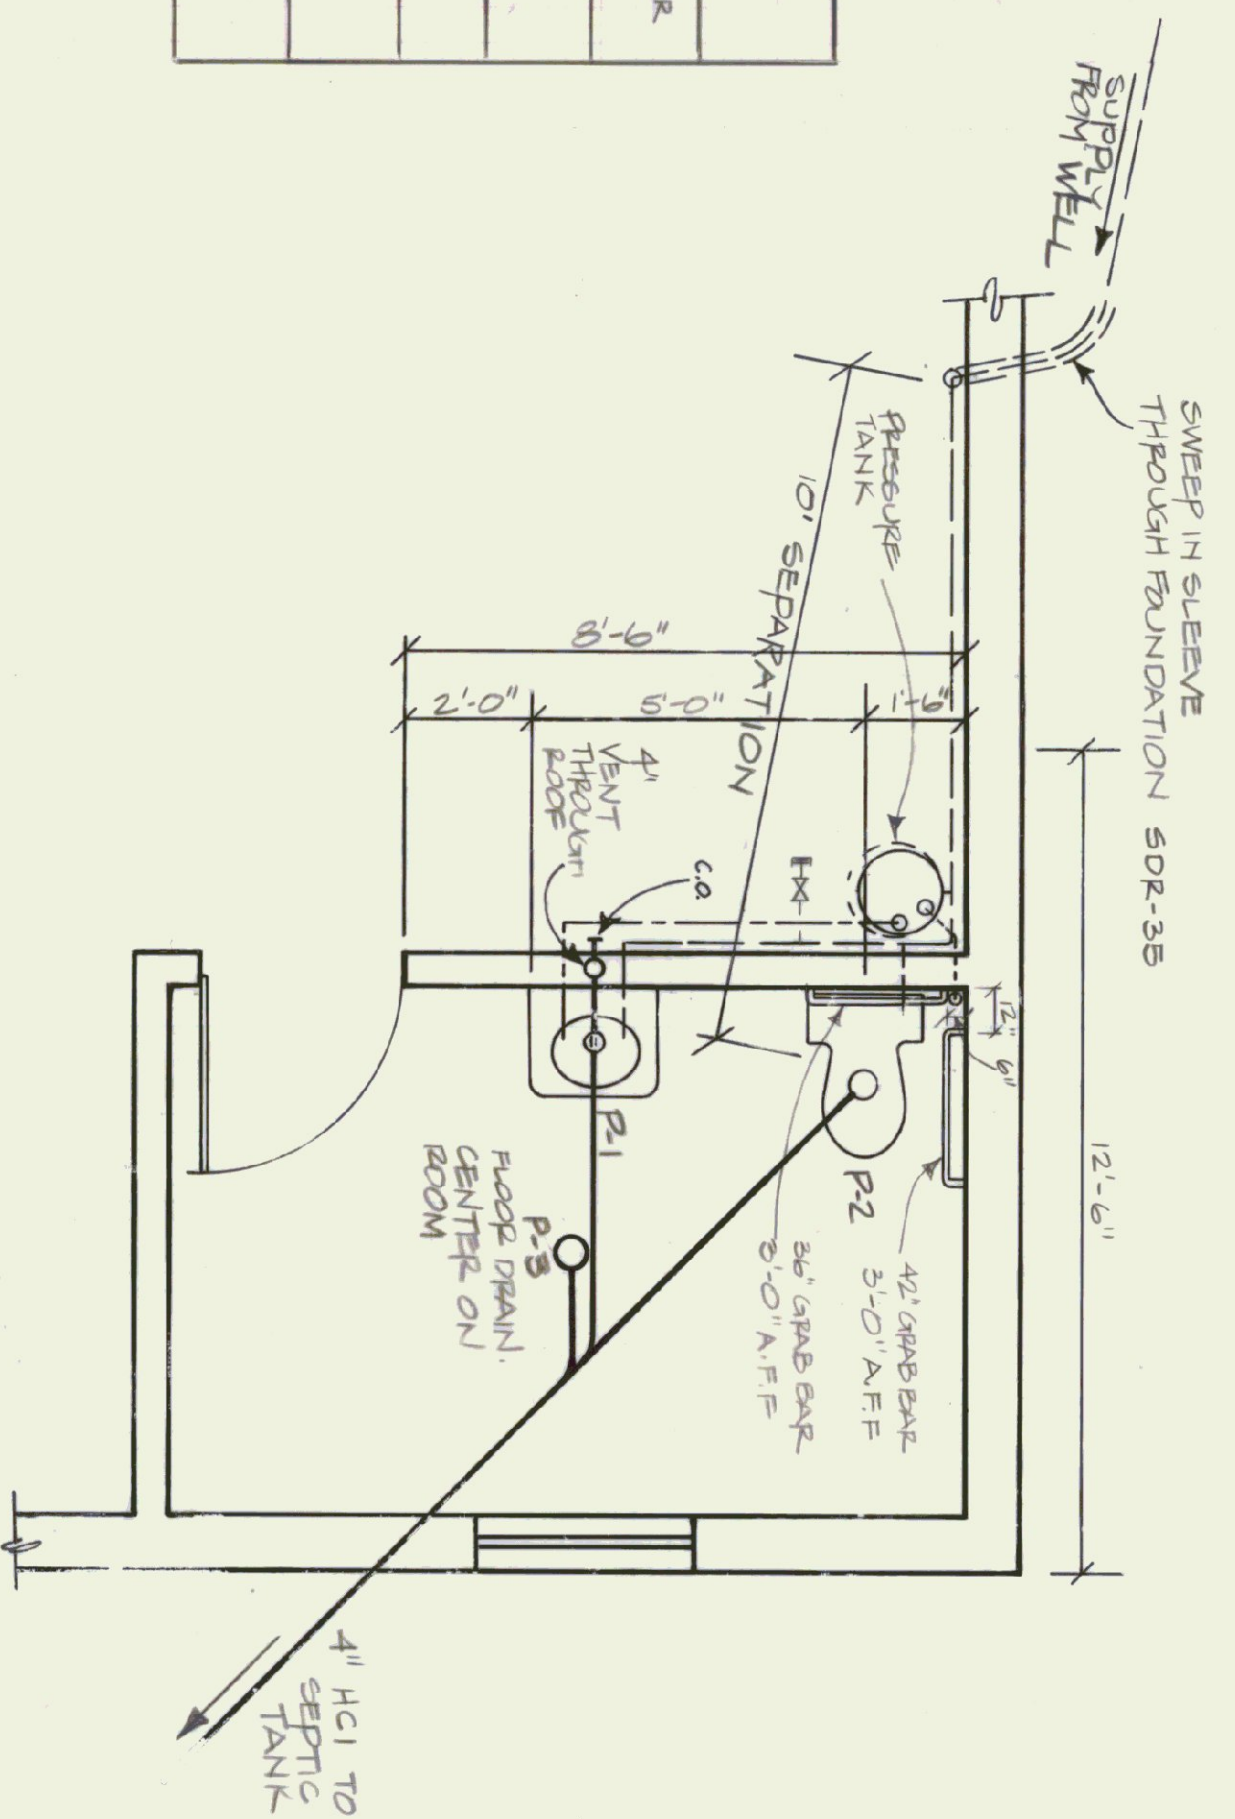


ITEM	FIXTURE	MAKE/MODEL	ROUGH-IN			REMARKS	
			HOT	COLD	WASTE		VENT
P-1	LAVATORY	AMERICAN STANDARD 0555.012	1/2"	1/2"	4"	4"	PROVIDE AFS #2385.131 FAUCET AND BRID STRAINER PROVIDE OFFSET DRAIN! WALL HANGER MOUNT RM AT 5' AFF
P-2	TOILET	AMERICAN STANDARD 3043.102	-	1/2"	4"	-	PROVIDE CHURCH #9400 KC SEAT SUON III FLUSH VALVE
P-3	FLOOR DRAIN	-	-	-	4"	-	PROVIDE NICKEL SLOTTED COVER
P-4	WATERHEATER	BRADFORD-WHITE M-1-6USS	3/4"	3/4"	-	-	PROVIDE P4 T RELIEF VALVE PIPED TO 6" A.F.F.
P-5	PRESSURE TANK	-	-	-	-	-	SUPPLIED BY WELL CO.

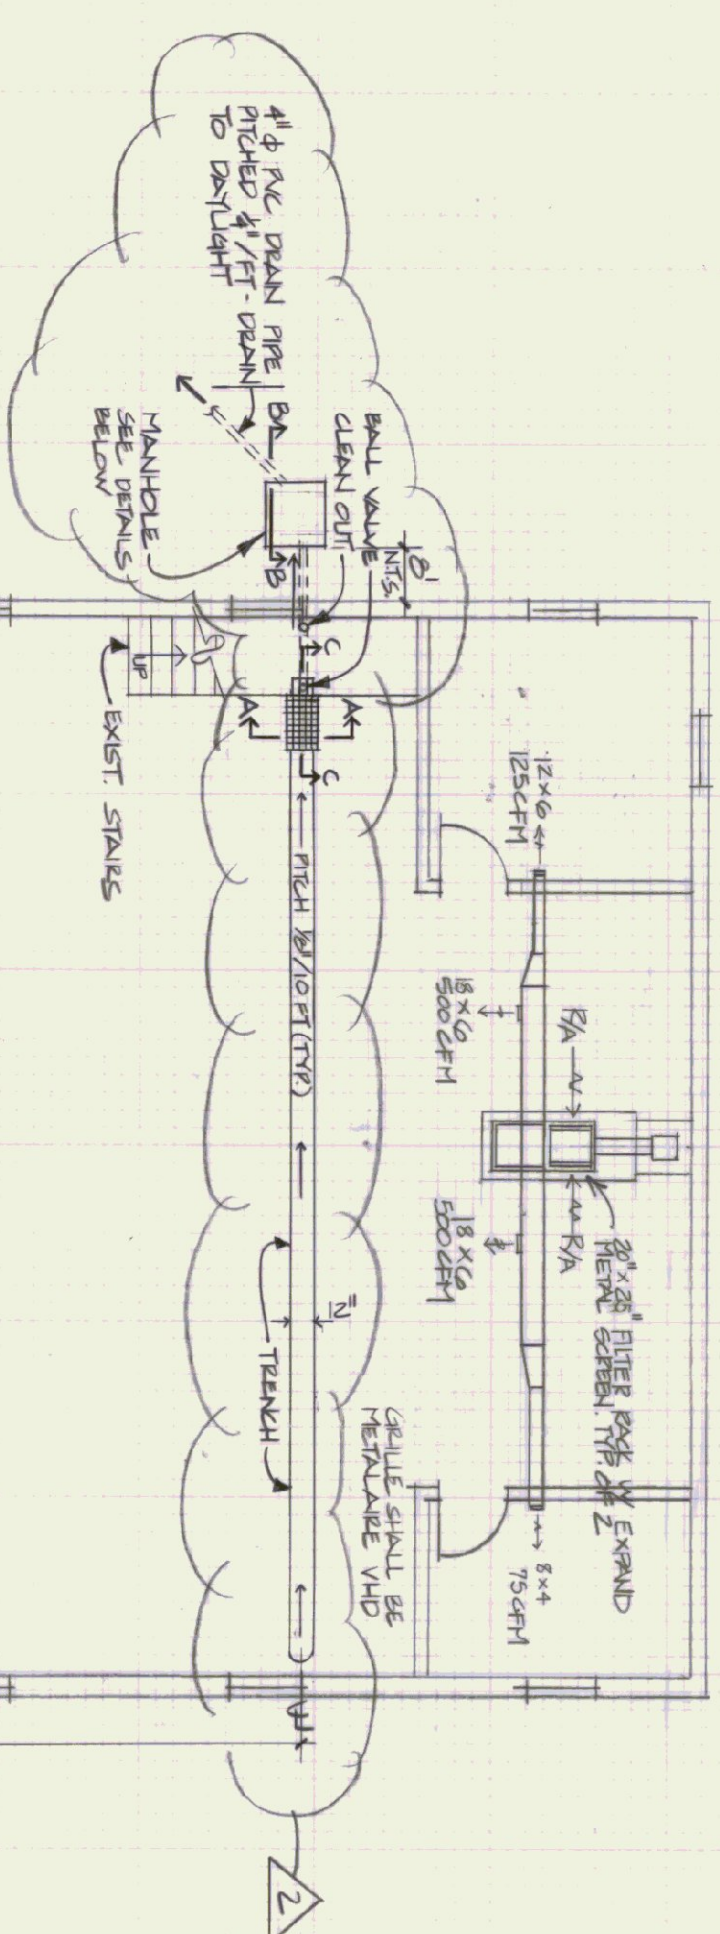






BATHROOM PLUMBING PLAN
SCALE: 3/8" = 1'-0"

HOT & COLD WATER RISER DIAGRAM
NOT TO SCALE

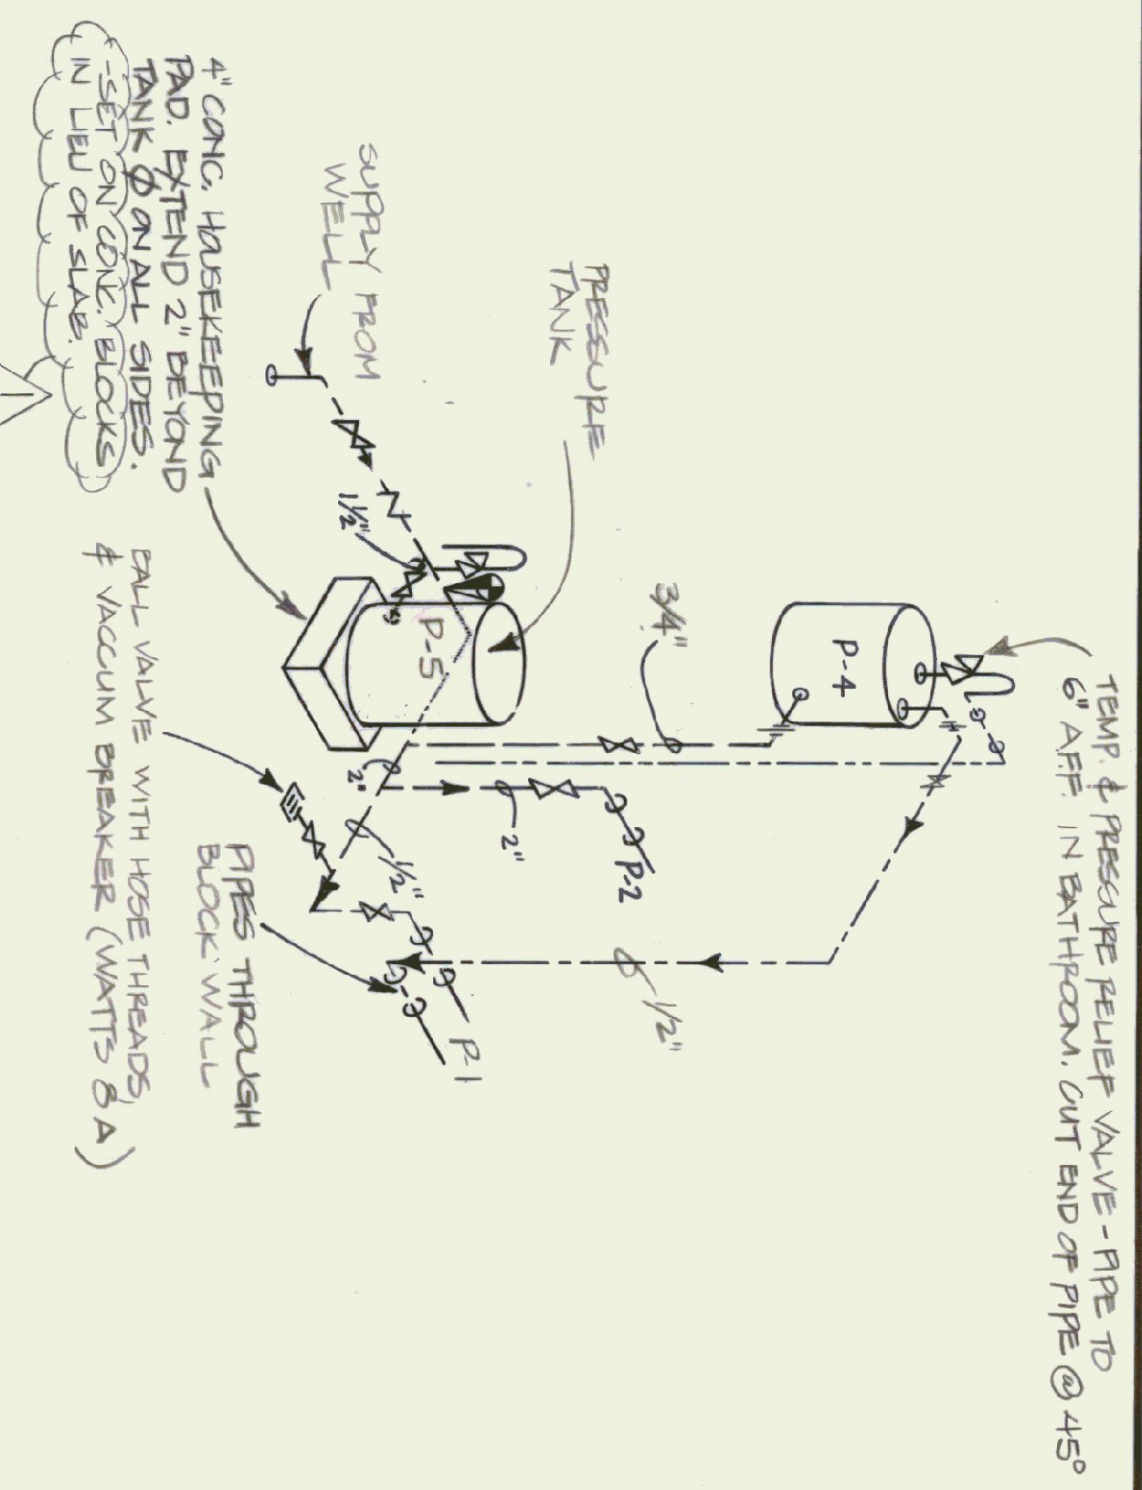

SANITARY WASTE & VENT RISER DIAGRAM
NOT TO SCALE

HEATING DRAWING
SCALE: 1/8" = 1'-0"

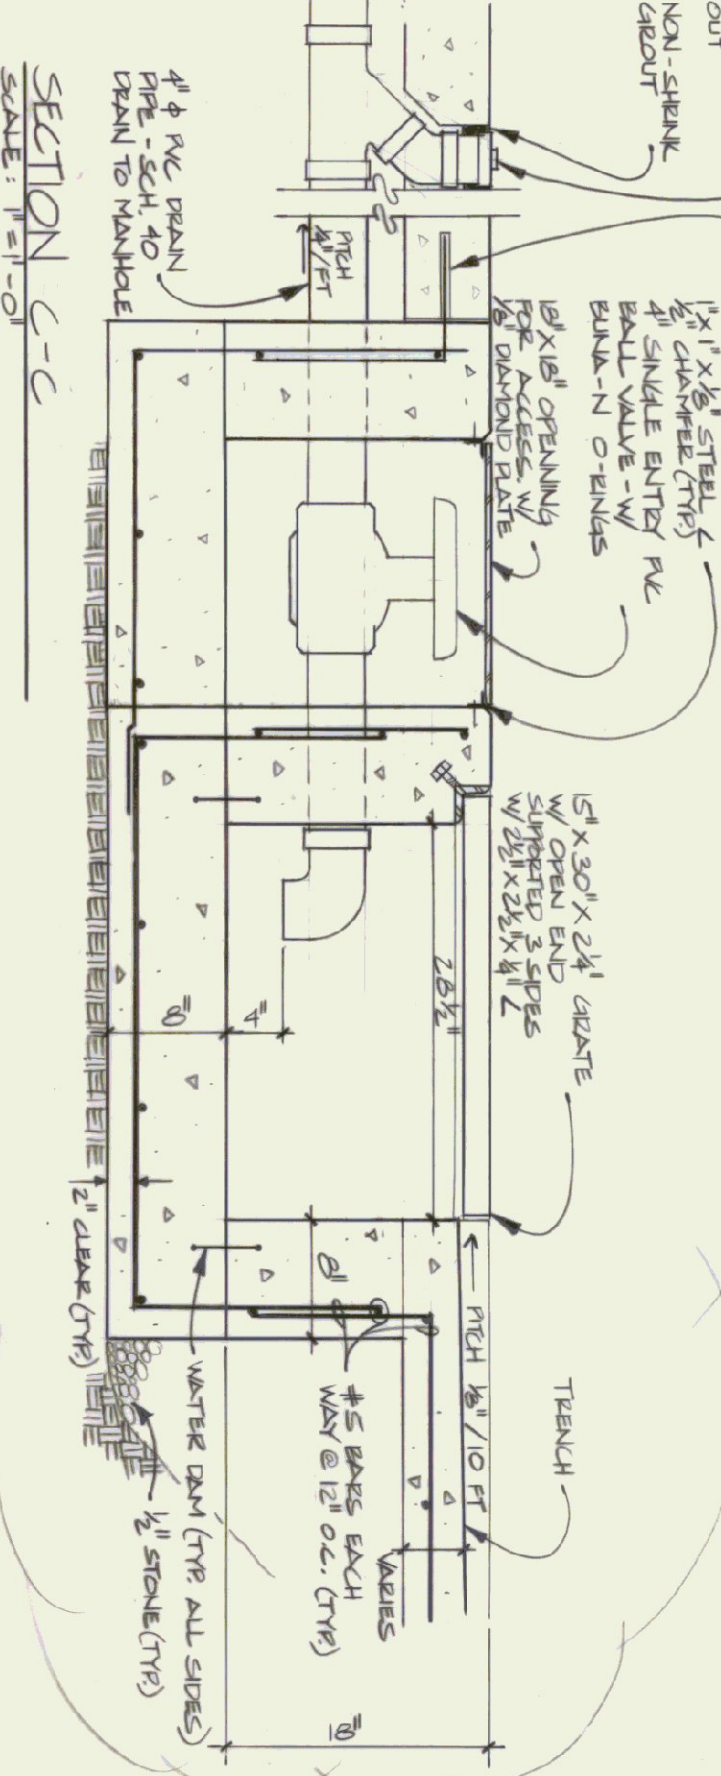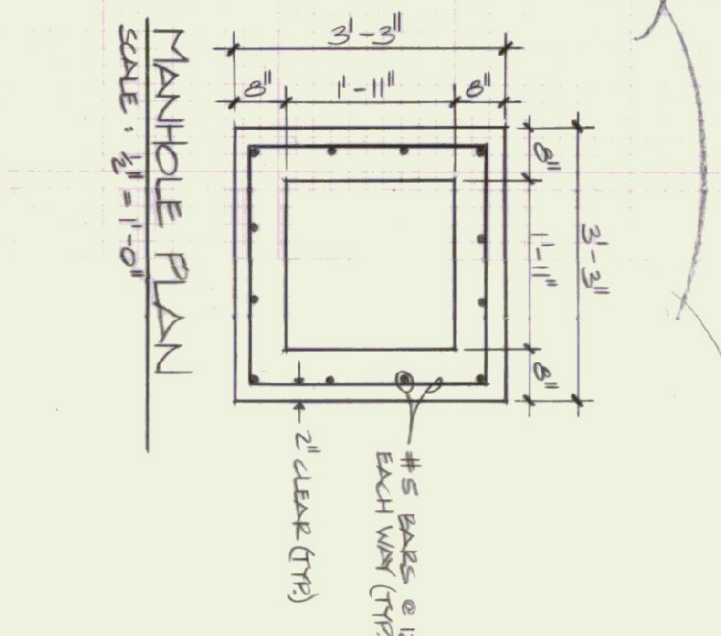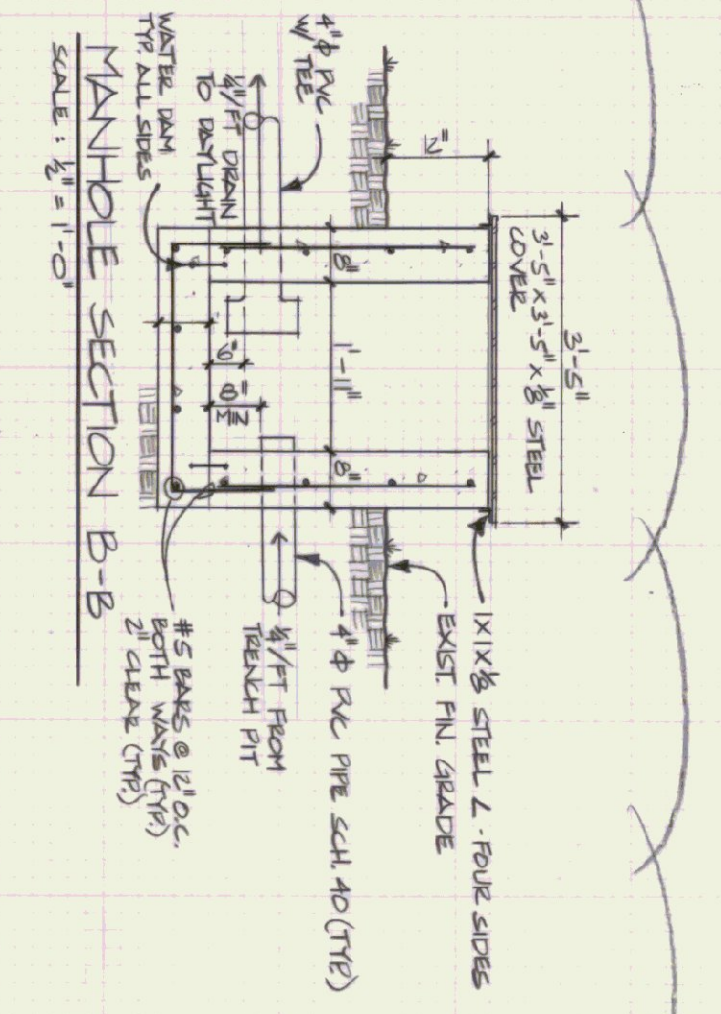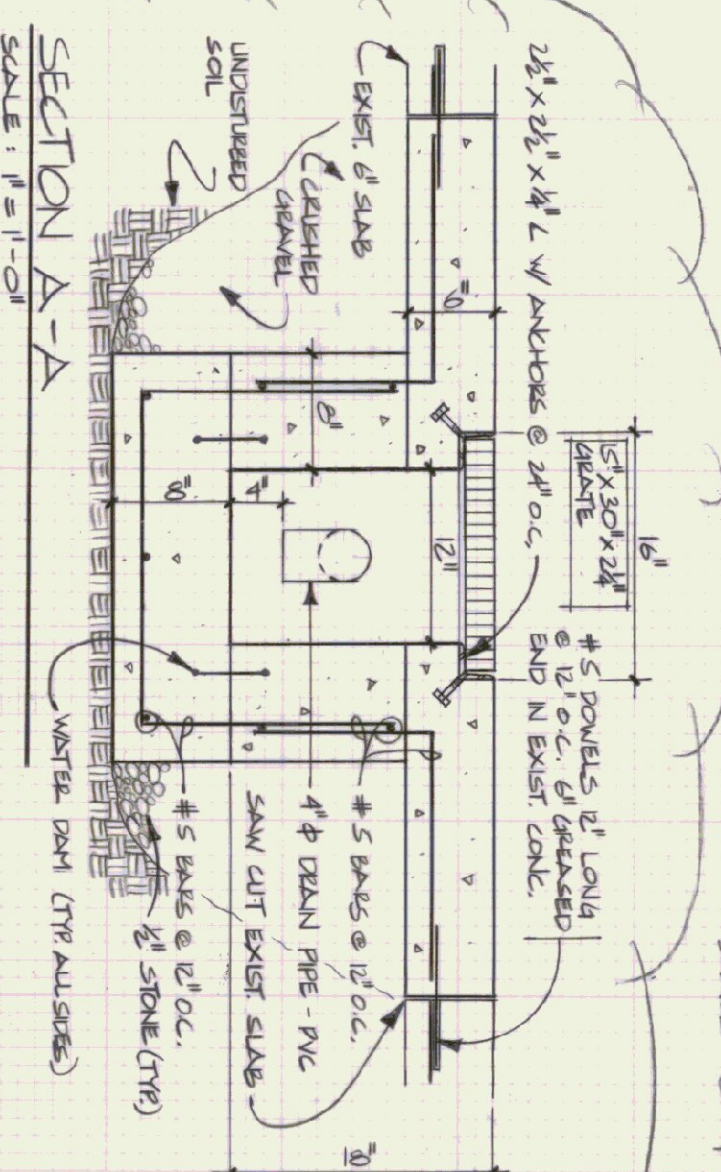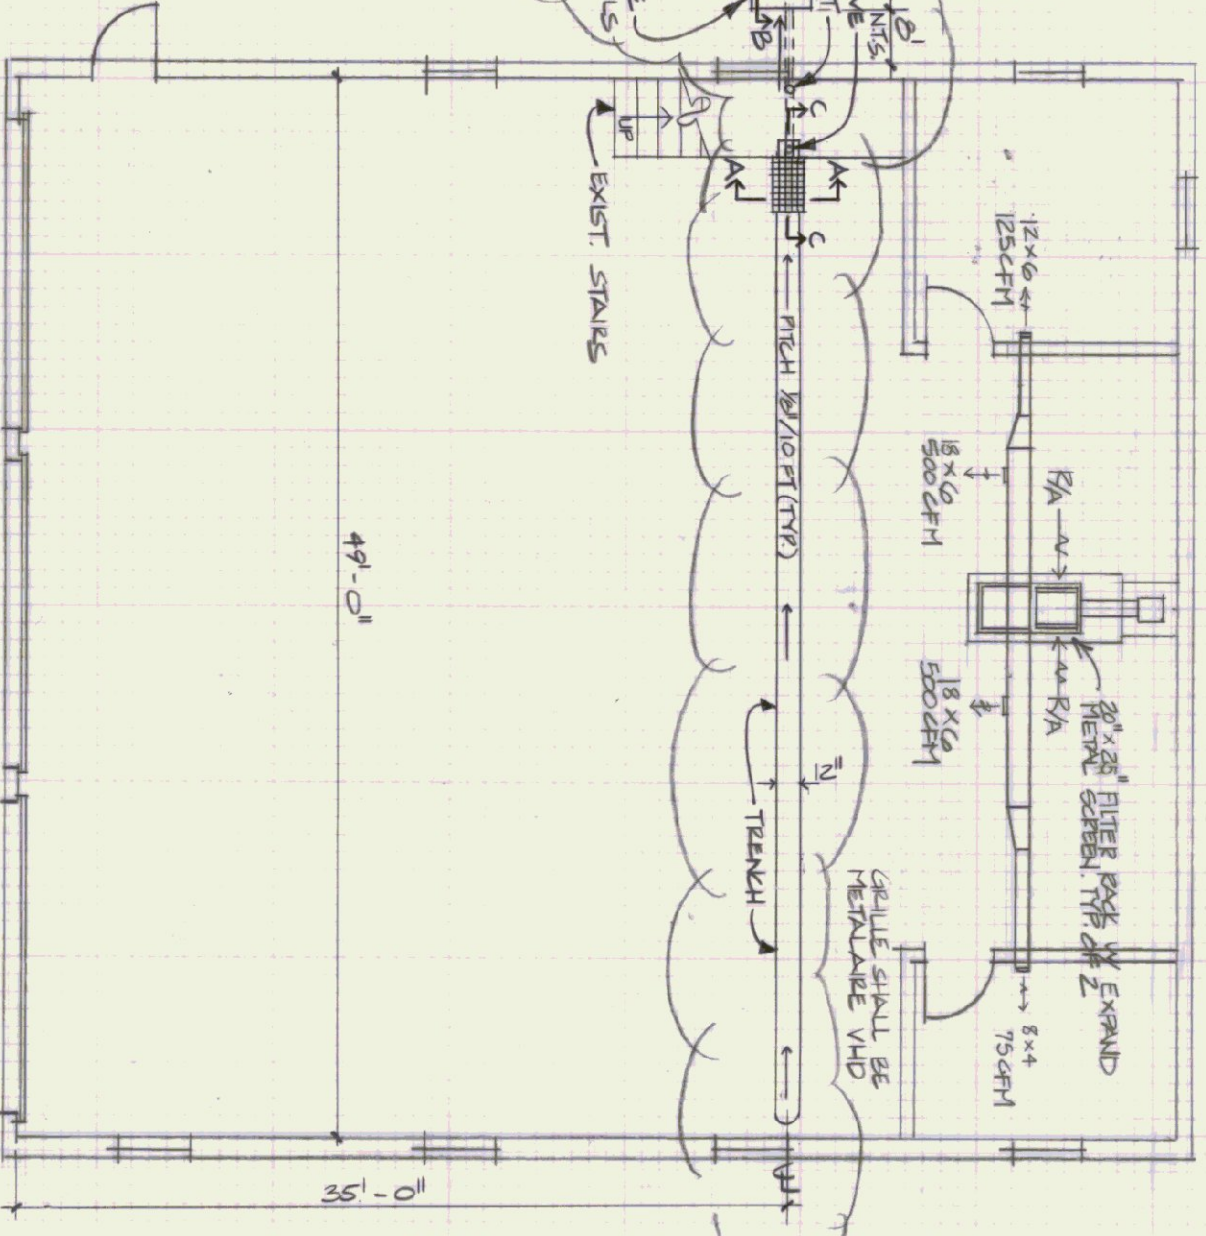

AS BUILT

STATE OF VERMONT
DEPARTMENT OF STATE BUILDINGS
AGENCY OF ADMINISTRATION
VERMONT

AGENCY OF TRANSPORTATION
MECHANICAL PLAN
SUBBURY MAINTENANCE FACILITY
3 BAY GARAGE

DATE: April 21, 1995
DRAWN BY: A. POULIN
SCALE: AS NOTED
APPROVED BY: [Signature]

REVISIONS:
1. [Signature]
2. [Signature]
3. [Signature]
4. [Signature]
5. [Signature]

VERMONT
DWG. NO. M-1
5 OF 8