


FLOOR PLAN
SCALE: 1/8" = 1'-0"

CEILING FAN LAYOUT KEY
 (F) CEILING FAN (SUBSTITUTED MODEL DUE TO 156" DIAMETER SHADE OR EQUIV)
 ALL DIMENSIONS ARE APPROXIMATE ONLY. EXACT LOCATION WILL DEPEND ON FIELD CONDITIONS.

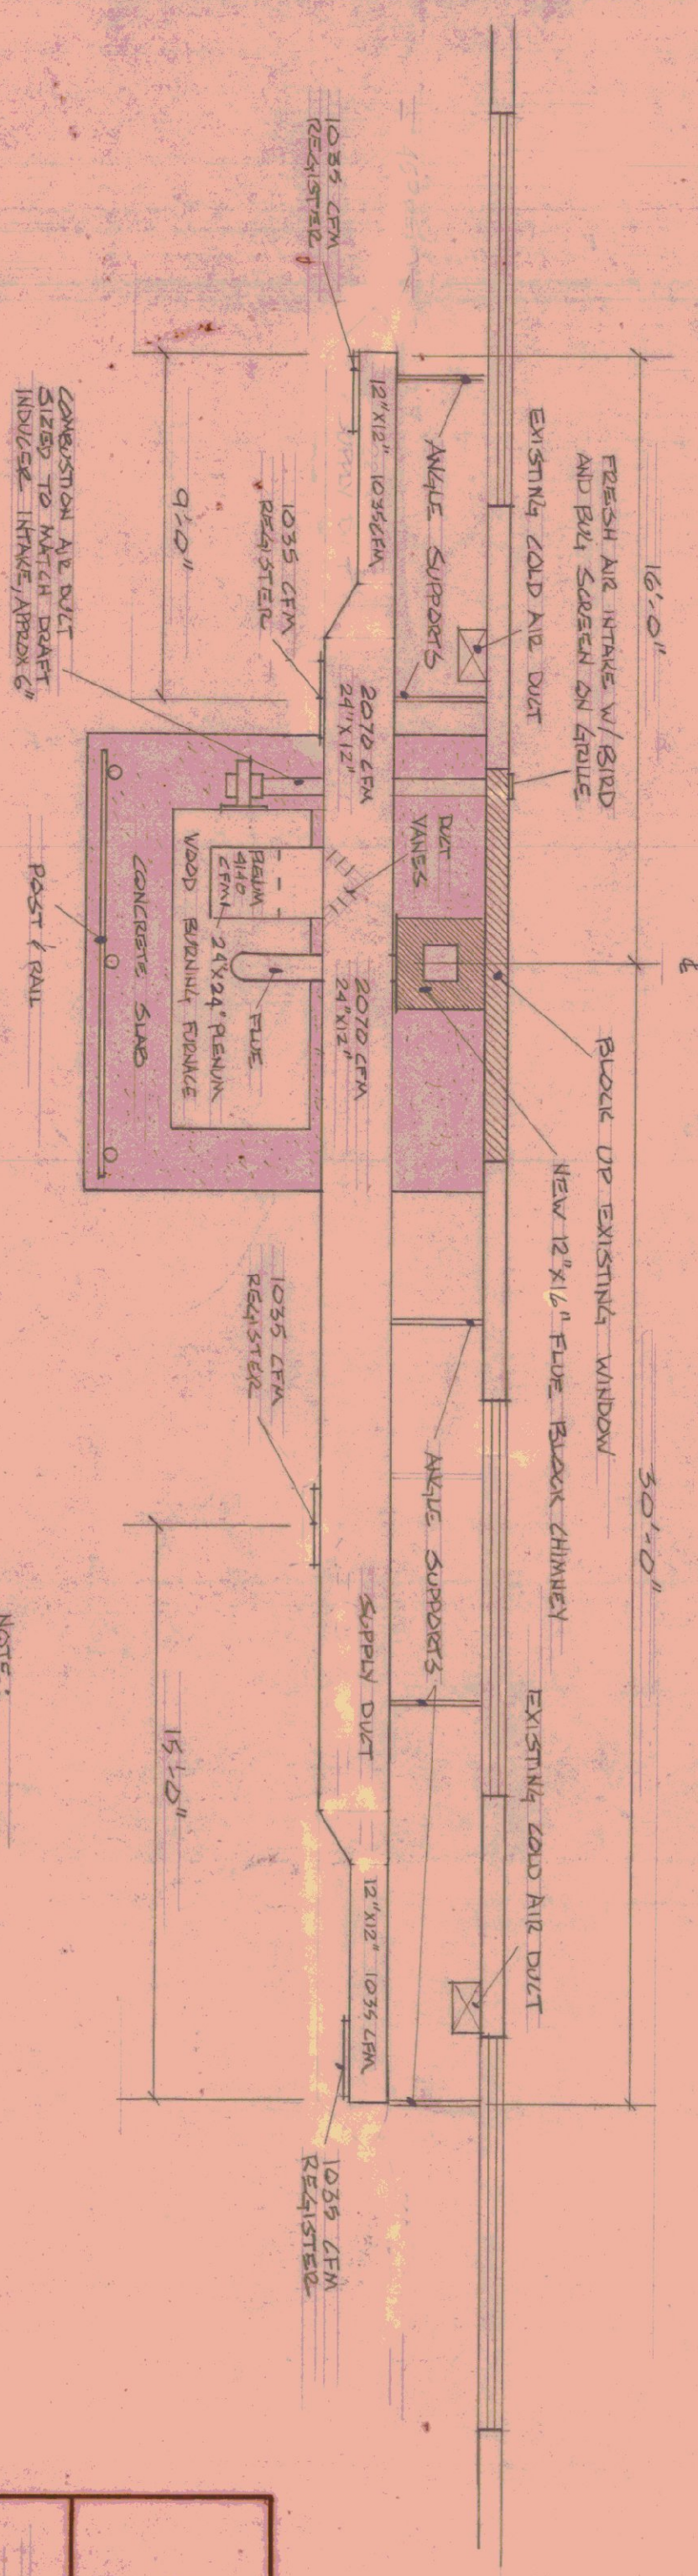

PLAN AT FURNACE SLABS (SCALE 1/4" = 1'-0")

NOTE:
 FOR ADDITIONAL DETAILS SEE
 TYPICAL DETAILS SHEET N-82

STATE OF VERMONT
 DIVISION OF STATE BUILDINGS
 AGENCY OF ADMINISTRATION
 MONTPELIER, VERMONT

WOOD BURNING FURNACE INSTALLATION
 AT THE AGENCY OF TRANSPORTATION GARAGE
 ROYALTON, VERMONT

DATE: 8-11-80	SCALE: AS NOTED	REVISIONS: 10-17-80 KH 1-19-81 - CEILING FAN S/W	DWG. NO. 1 OF 3
DRAWN BY: D.H. HANSON	APPROVED BY: G.M. WOODS		