




FOUNDATION PLAN  
SCALE 1/8" = 1'-0"

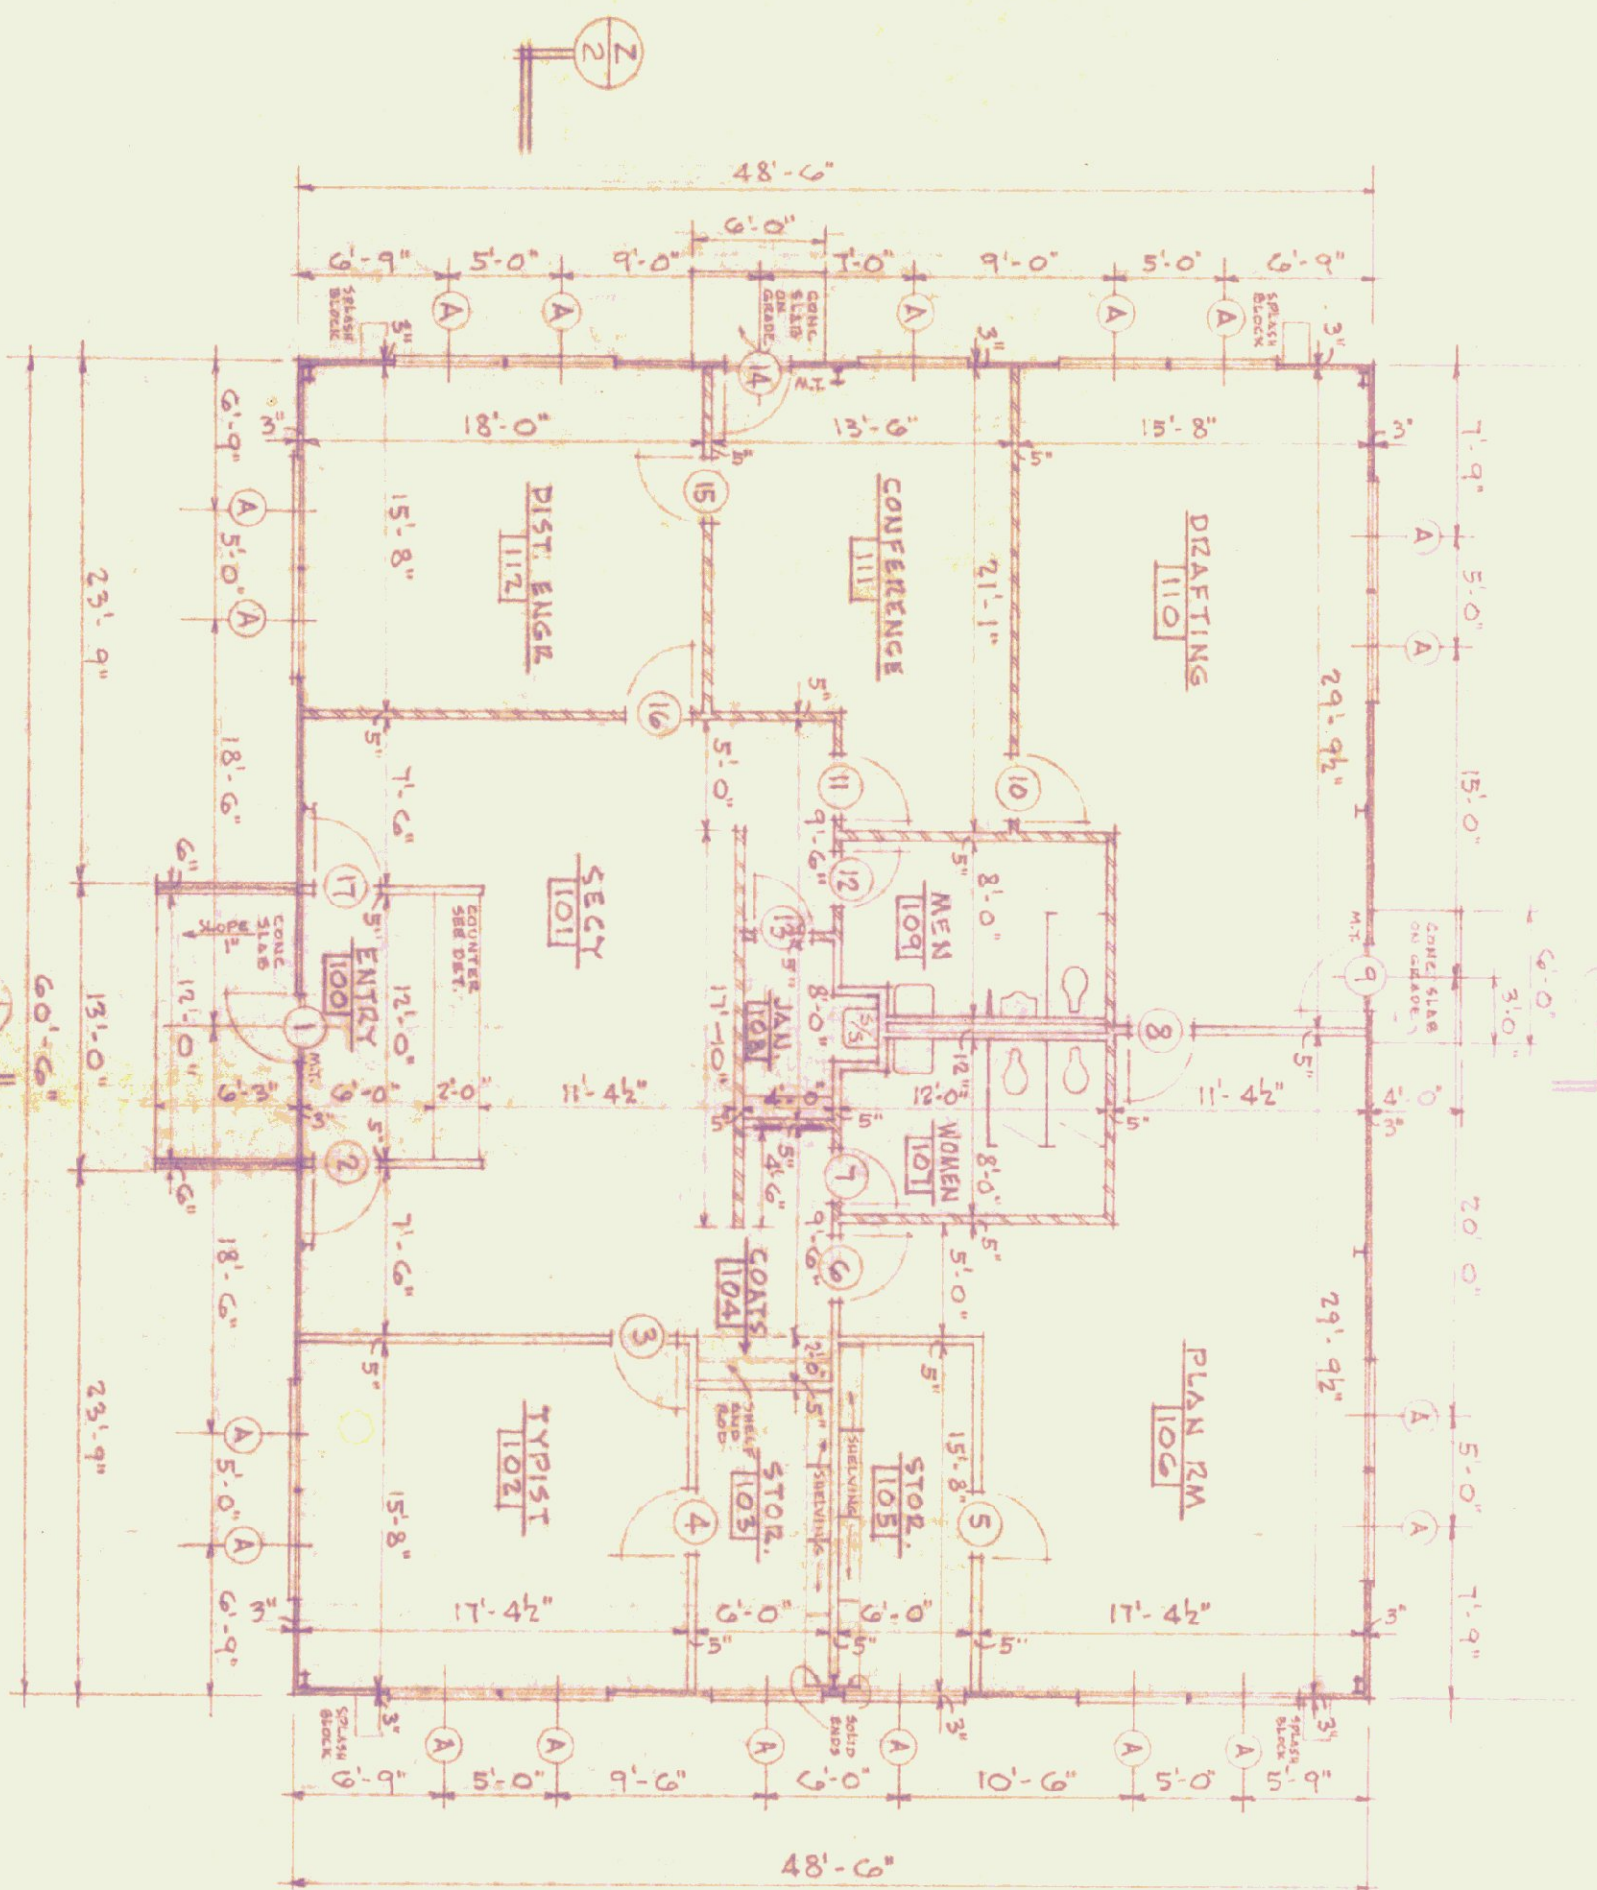


FIRST FLOOR PLAN  
SCALE 1/8" = 1'-0"

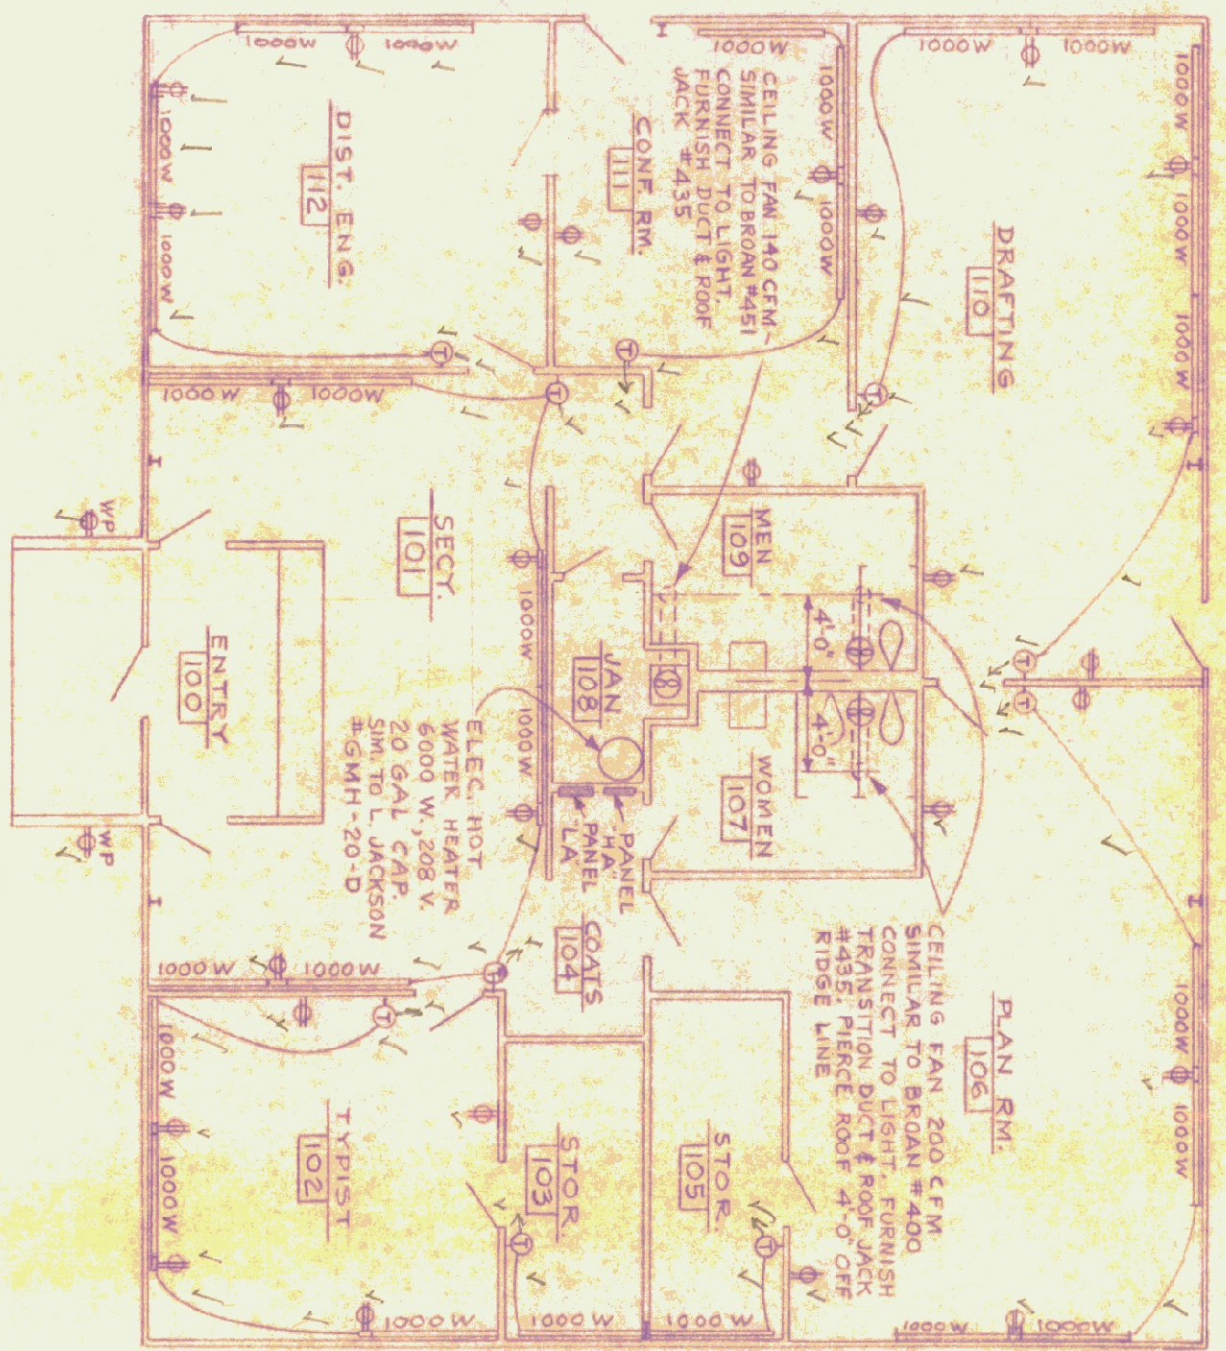



ELEC-HEAT & POWER PLAN  
SCALE 1/8" = 1'-0"

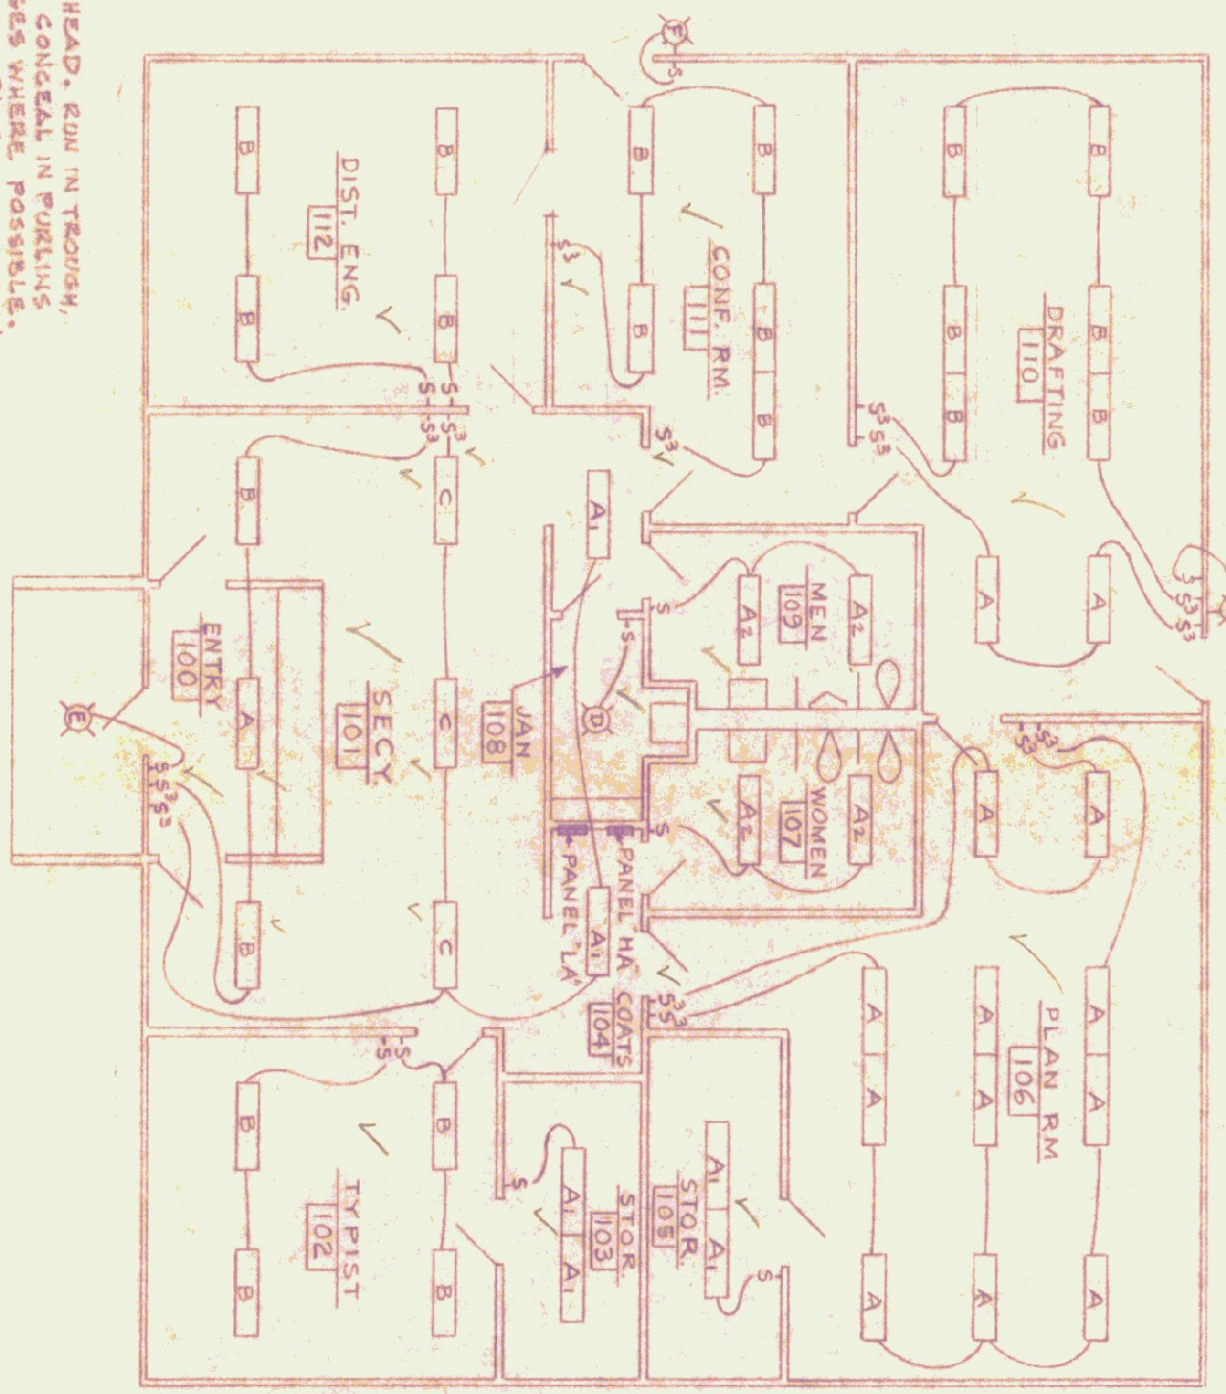

ELEC-LIGHTING PLAN  
SCALE 1/8" = 1'-0"

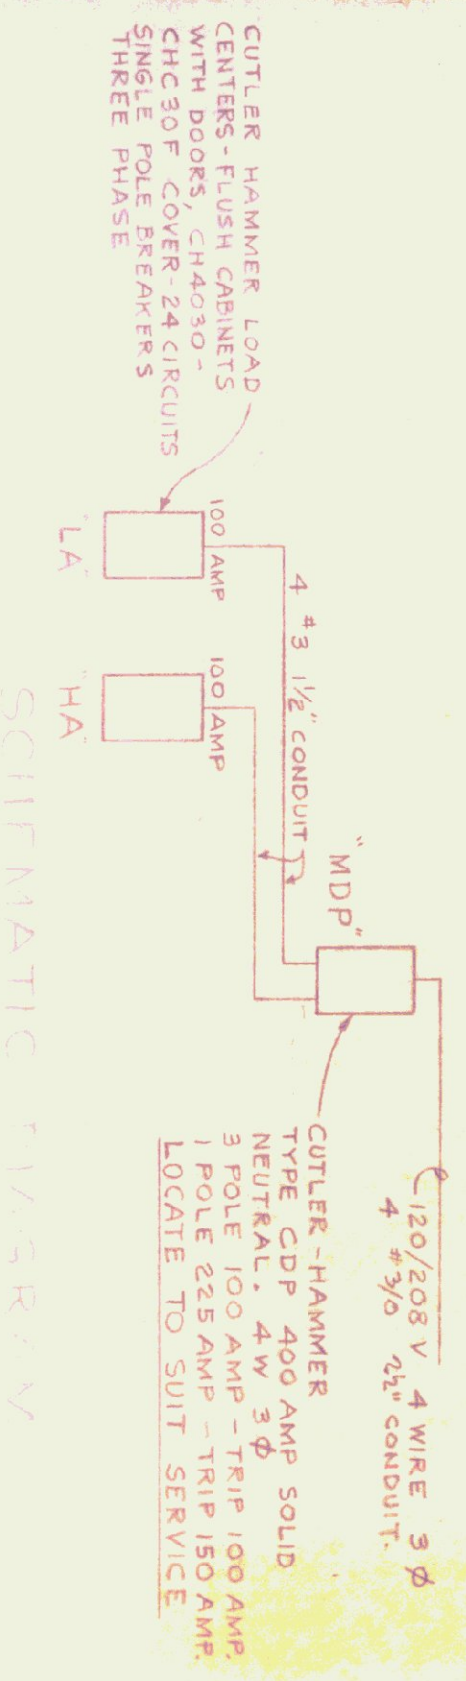


SCHEMATIC WIRING

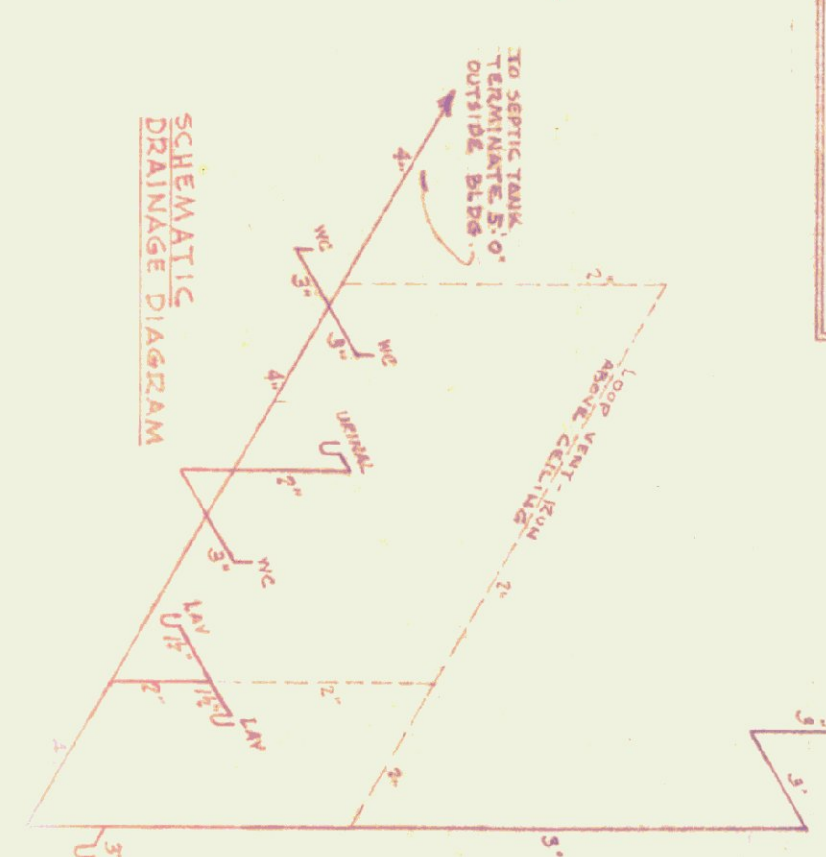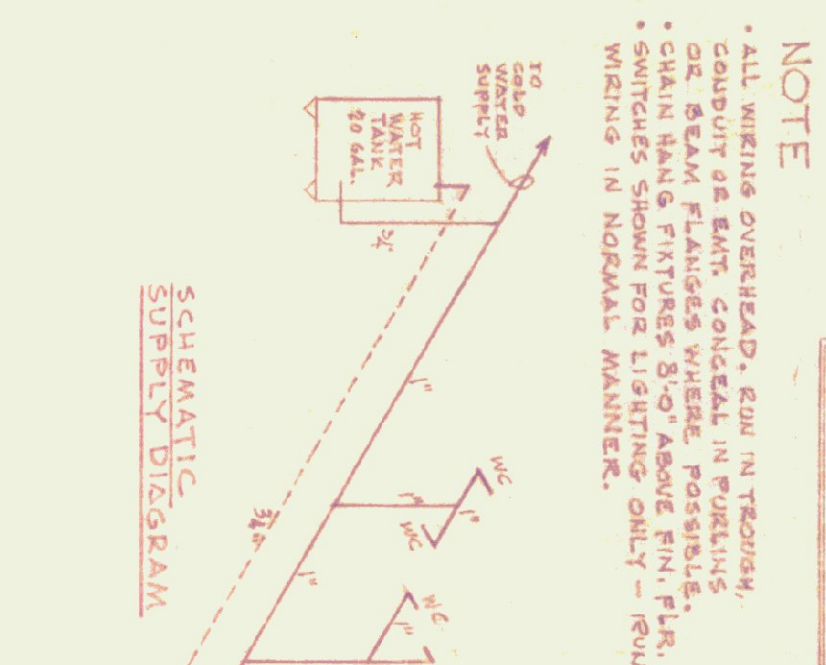


WINDOW SCHEDULE  
4'-11 1/2"  
4'-0"


CONCRETE SPLASH  
BLOCK DETAIL

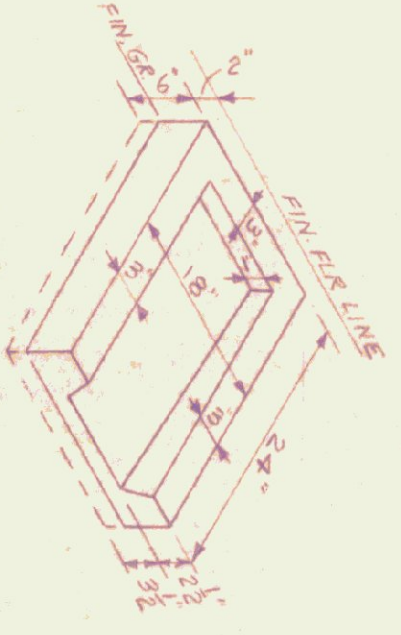

DOOR TYPES

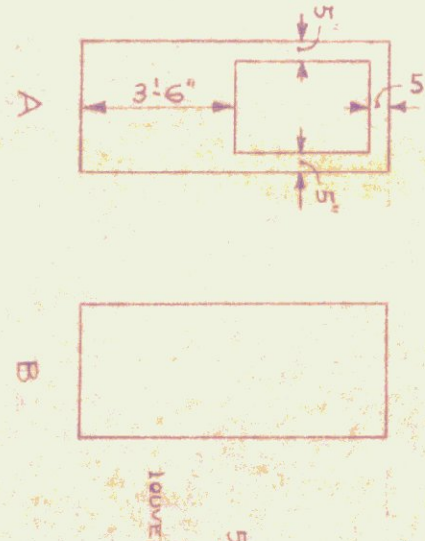

INTERIOR DOOR  
JAMB

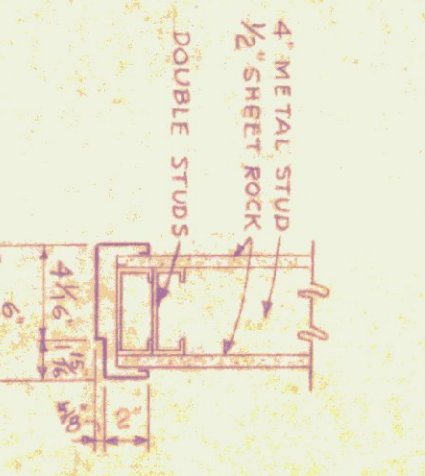

NOTE: ALL DOORS & DOOR FRAMES IN METAL PANEL WALLS ARE TO BE FINISHED BY THE METAL BUILDING MANUFACTURER PER PARTITION DIMENSIONS SHOWN ARE FINISH TO FINISH. PARTITION DIMENSIONS SHOWN ARE FINISH TO FINISH. PARTITION DIMENSIONS SHOWN ARE FINISH TO FINISH. PARTITION DIMENSIONS SHOWN ARE FINISH TO FINISH.

NO.	SIZE	THICK	TYPE	MATERIAL	REMARKS		
1	3'-0" x 7'-0"	1 3/4"	A	H.M.	1	A-5	CLEAR WIRE GLASS
2	3'-0" x 7'-0"	1 3/4"	A	H.C.V.	1	NONE	CLEAR WIRE GLASS
3	3'-0" x 7'-0"	1 3/4"	A	H.C.V.	12	NONE	CLEAR WIRE GLASS
4	3'-0" x 7'-0"	1 3/4"	B	H.C.V.	12	NONE	CLEAR WIRE GLASS
5	3'-0" x 7'-0"	1 3/4"	B	H.C.V.	12	NONE	CLEAR WIRE GLASS
6	3'-0" x 7'-0"	1 3/4"	B	H.C.V.	7	NONE	CLEAR WIRE GLASS
7	2'-6" x 7'-0"	1 3/4"	C	H.C.V.	5	NONE	WOOD LOUVER
8	3'-0" x 7'-0"	1 3/4"	A	H.C.V.	12	NONE	CLEAR WIRE GLASS
9	3'-0" x 7'-0"	1 3/4"	A	H.C.V.	7	A-5	CLEAR WIRE GLASS
10	3'-0" x 7'-0"	1 3/4"	B	H.C.V.	7	A-6	CLEAR WIRE GLASS
11	3'-0" x 7'-0"	1 3/4"	B	H.C.V.	7	A-6	CLEAR WIRE GLASS
12	2'-6" x 7'-0"	1 3/4"	C	H.C.V.	5	NONE	WOOD LOUVER
13	2'-6" x 7'-0"	1 3/4"	C	H.C.V.	9	A-4	WOOD LOUVER
14	3'-0" x 7'-0"	1 3/4"	A	H.C.V.	7	A-5	CLEAR WIRE GLASS
15	3'-0" x 7'-0"	1 3/4"	A	H.C.V.	7	A-6	CLEAR WIRE GLASS
16	3'-0" x 7'-0"	1 3/4"	A	H.C.V.	7	A-6	CLEAR WIRE GLASS
17	3'-0" x 7'-0"	1 3/4"	B	H.C.V.	13	NONE	CLEAR WIRE GLASS

ROOM FINISH SCHEDULE

NO.	AREA	FLOOR	BASE	WALL	CEILING	REMARKS
100	ENTRY	V.A.	VINYL	---	---	SEE ENTRY COUNTER DET. DWG. NO. 3
101	SECRETARY	"	"	---	---	SEE ENTRY COUNTER DET. DWG. NO. 3
102	STORAGE	"	"	---	---	SEE ENTRY COUNTER DET. DWG. NO. 3
103	STORAGE	"	"	---	---	SEE ENTRY COUNTER DET. DWG. NO. 3
104	STAIRS	"	"	---	---	SEE ENTRY COUNTER DET. DWG. NO. 3
105	STORAGE ROOM	"	"	---	---	SEE ENTRY COUNTER DET. DWG. NO. 3
106	WOMEN	"	"	---	---	SEE ENTRY COUNTER DET. DWG. NO. 3
107	JAN	"	"	---	---	SEE ENTRY COUNTER DET. DWG. NO. 3
108	WOMEN	"	"	---	---	SEE ENTRY COUNTER DET. DWG. NO. 3
109	MEN	"	"	---	---	SEE ENTRY COUNTER DET. DWG. NO. 3
110	CONF. ROOM	"	"	---	---	SEE ENTRY COUNTER DET. DWG. NO. 3
111	CONF. ROOM	"	"	---	---	SEE ENTRY COUNTER DET. DWG. NO. 3
112	DIST. ENGINEER	"	"	---	---	SEE ENTRY COUNTER DET. DWG. NO. 3

FIXTURE SCHEDULE

NO.	DESCRIPTION	DATE	REMARKS
A	SIMILAR TO DAYBRITE	OCT-7	CC166-76-4, 1 LAMP RAMP START, COOL. WHITE
B	"	"	CC266-76-4, 2 "
C	"	OCT-12	CO240-24-4, 2 "
D	"	OCT-18	CO440-44-4, 4 "
E	"	"	"
F	"	"	"
G	"	"	"
H	"	"	"
I	"	"	"
J	"	"	"
K	"	"	"
L	"	"	"
M	"	"	"
N	"	"	"
O	"	"	"
P	"	"	"
Q	"	"	"
R	"	"	"
S	"	"	"
T	"	"	"
U	"	"	"
V	"	"	"
W	"	"	"
X	"	"	"
Y	"	"	"
Z	"	"	"



STATE OF VERMONT  
OFFICE BUILDING  
FOR  
STATE HIGHWAY DEPT.  
PLANS & SCHEDULE  
SCALE 1/8" = 1'-0"  
RICHARD B. DIAMOND & ASSOC.  
ARCHITECTS-ENGINEERS  
FERRISBURGH, VERMONT

