
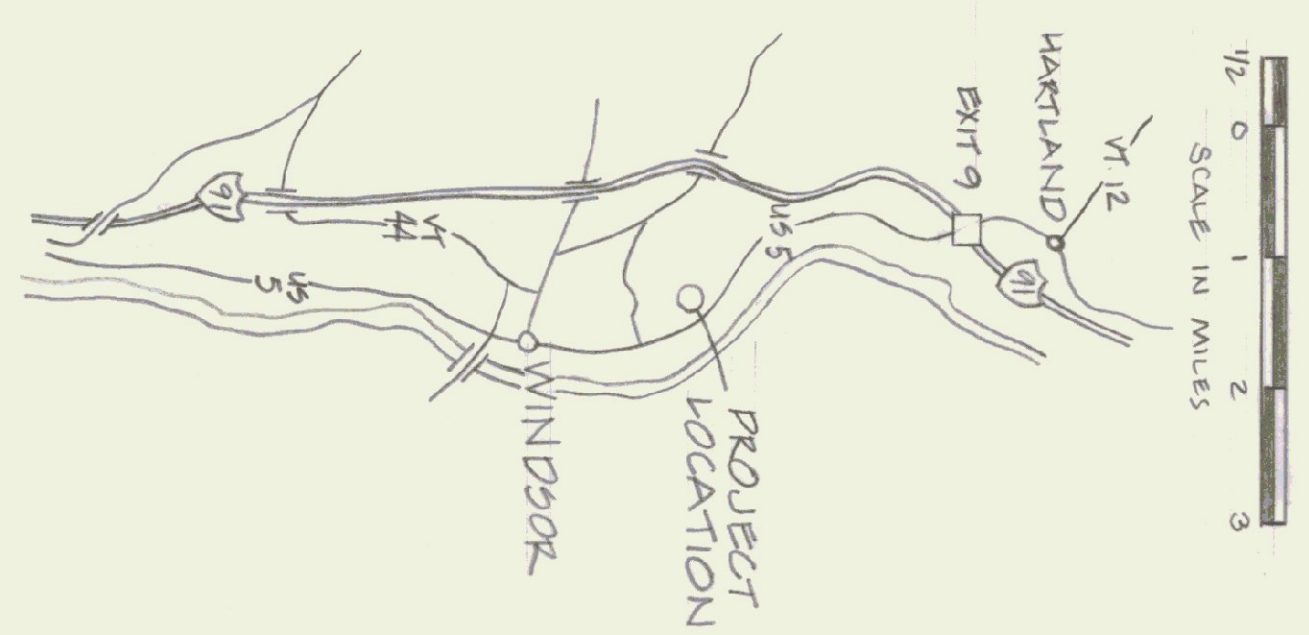
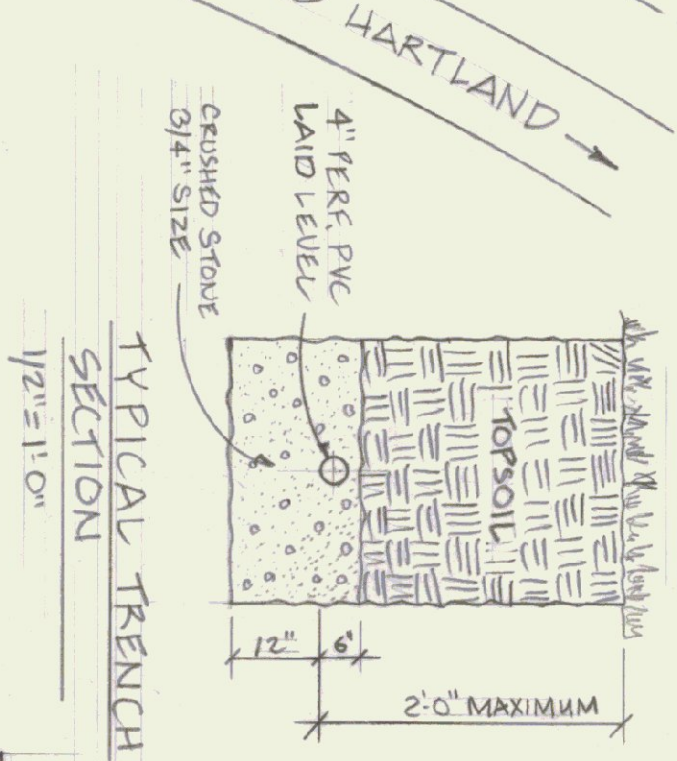


**SEPTIC DESIGN INFORMATION**

- DESIGN FLOW — 150 GPF
- PERCOLATION RATE — 11 MIN / INCH
- APPLICATION RATE — 0.9 GAL / FT<sup>2</sup> / DAY
- FACTOR OF SAFETY — 1.25
- TEST PIT LOCATION
- PERCOLATION TEST

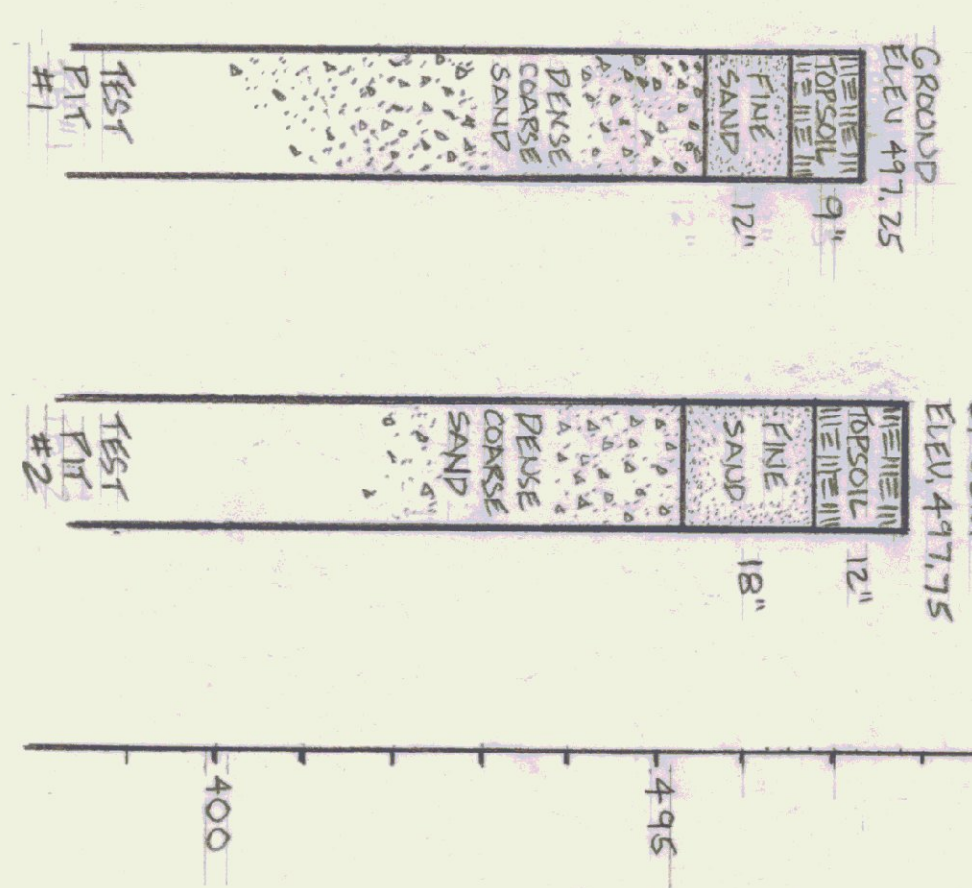

STATE OF VERMONT DIVISION OF STATE BUILDINGS AGENCY OF ADMINISTRATION MONTPELIER, VERMONT	
VERMONT AGENCY OF TRANSPORTATION SITE PLAN 5 BAY GARAGE WINDBOR, VERMONT DISTRICT 4	
DATE: Aug 1, 1983 DRAWN BY: A. Rowan	SCALE: 1" = 50'-0" APPROVED BY: F. TERRY
REVISIONS: 10/25/83 JTD 1/24/88 AV	DWG. NO.: 5-1
	1 OF 12