

FURNISH & INSTALL (2) 1" COMPRESSED AIR CONNECTIONS W/ GLAD HANDS IN MECH. BAY AREA (COLUMN LINE 2) BETWEEN DOORS

FOR REEL NO. LUBRICATION, SEE PLAN BELOW

FOR WORK IN THIS AREA SEE SCALE PLAN BELOW


FOR PLUMBING WORK IN THIS AREA SEE SCALE PLAN BELOW

FOR PLUMBING WORK IN THIS AREA SEE SCALE PLAN BELOW

FOR PLUMBING WORK IN THIS AREA SEE SCALE PLAN BELOW

FOR PLUMBING WORK IN THIS AREA SEE SCALE PLAN BELOW

FOR PLUMBING WORK IN THIS AREA SEE SCALE PLAN BELOW

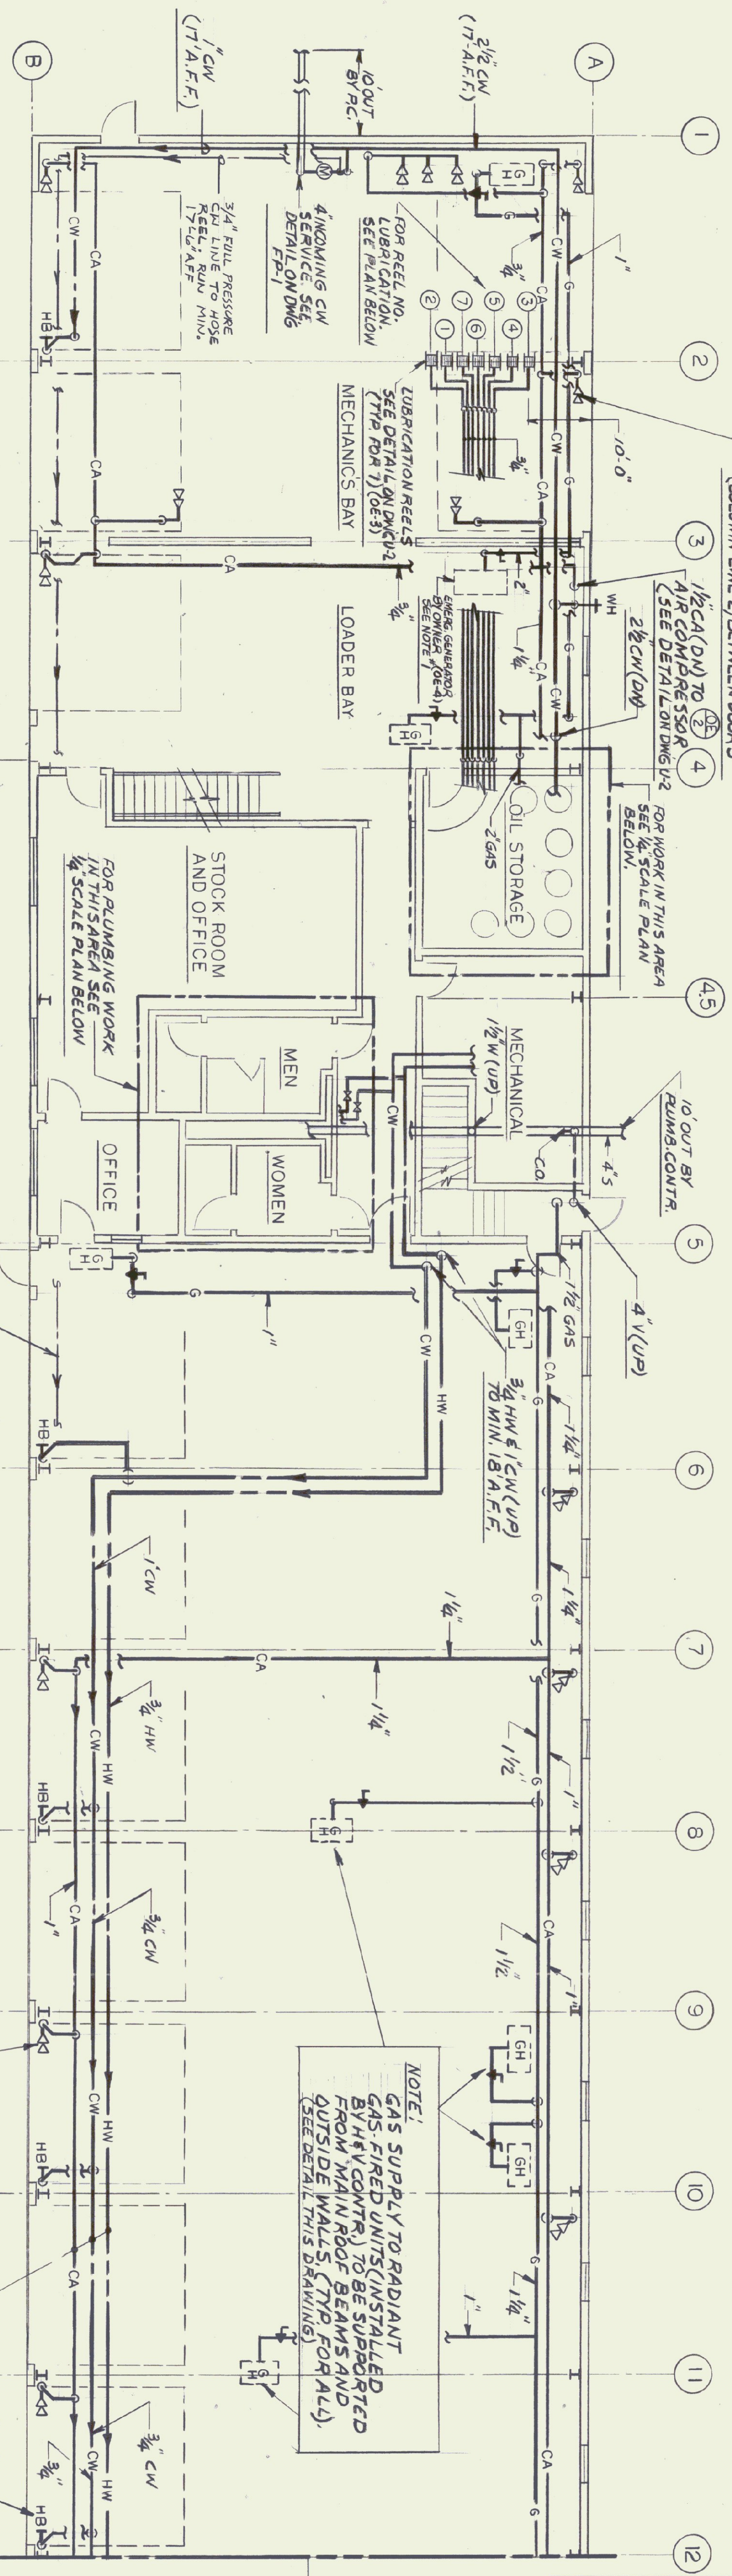

NOTES:
1. EMERGENCY GAS-FIRED GENERATOR BY OWNER, FURNISHED BY OWNER AND INSTALLED BY ELEC. CONTR.
2. PLUMB CONTR. TO FURNISH & INSTALL 2" GAS LINE W/ SHUT-OFF & FULL DIRT SOCKET 3/4" TAKE-OFF TO GENERATOR CONNECTIONS W/ UNION & SHUT-OFFS (COORDINATE ALL WORK W/ ELEC. CONTR.)

PLUMBING-MAIN LEVEL PLAN
SCALE: 1/8"=1'-0"

NOTE:
GAS SUPPLY TO RADIANT GAS-FIRED UNITS (INSTALLED BY HEV CONTR.) TO BE SUPPORTED FROM MAIN ROOF BEAMS AND OUTSIDE WALLS. (TYP. FOR ALL). (SEE DETAIL THIS DRAWING)

ALL PIPING RUNNING BETWEEN COLUMN LINES 5-14 TO BE SUPPORTED OFF OUTSIDE WALL & MAIN 24" DEEP 1" BEAMS. NOT ROOF SUPPORTS (SEE DETAIL)


QUICKDISCONNECT AIR FITTING (TYP) INSTALL TO AVOID DOOR FRAMES (SEE DETAIL)

HOSE BIB (TYP) (SEE DETAIL)


MATCH LINE FOR CONTINUATION SEE PLAN BELOW

MATCH LINE FOR CONTINUATION SEE PLAN ABOVE

MATCH LINE FOR CONTINUATION SEE PLAN ABOVE

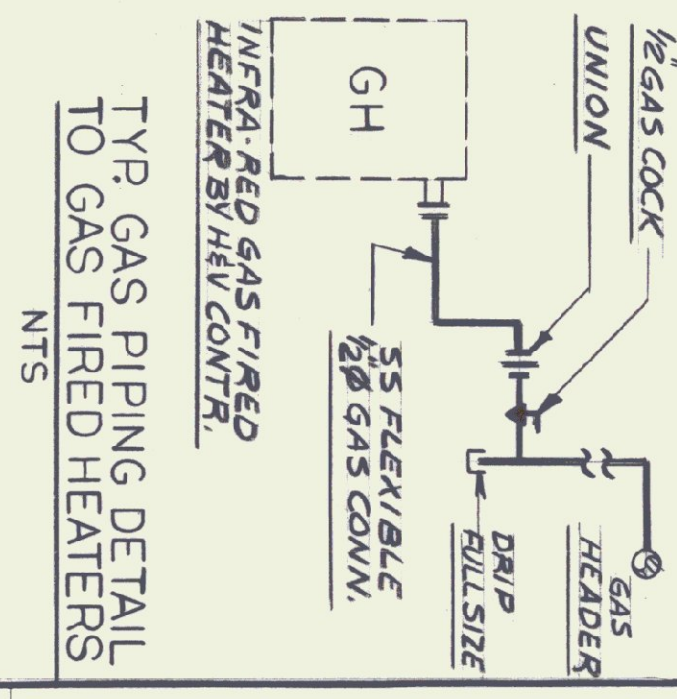


TYP. GAS PIPING DETAIL TO GAS FIRED HEATERS

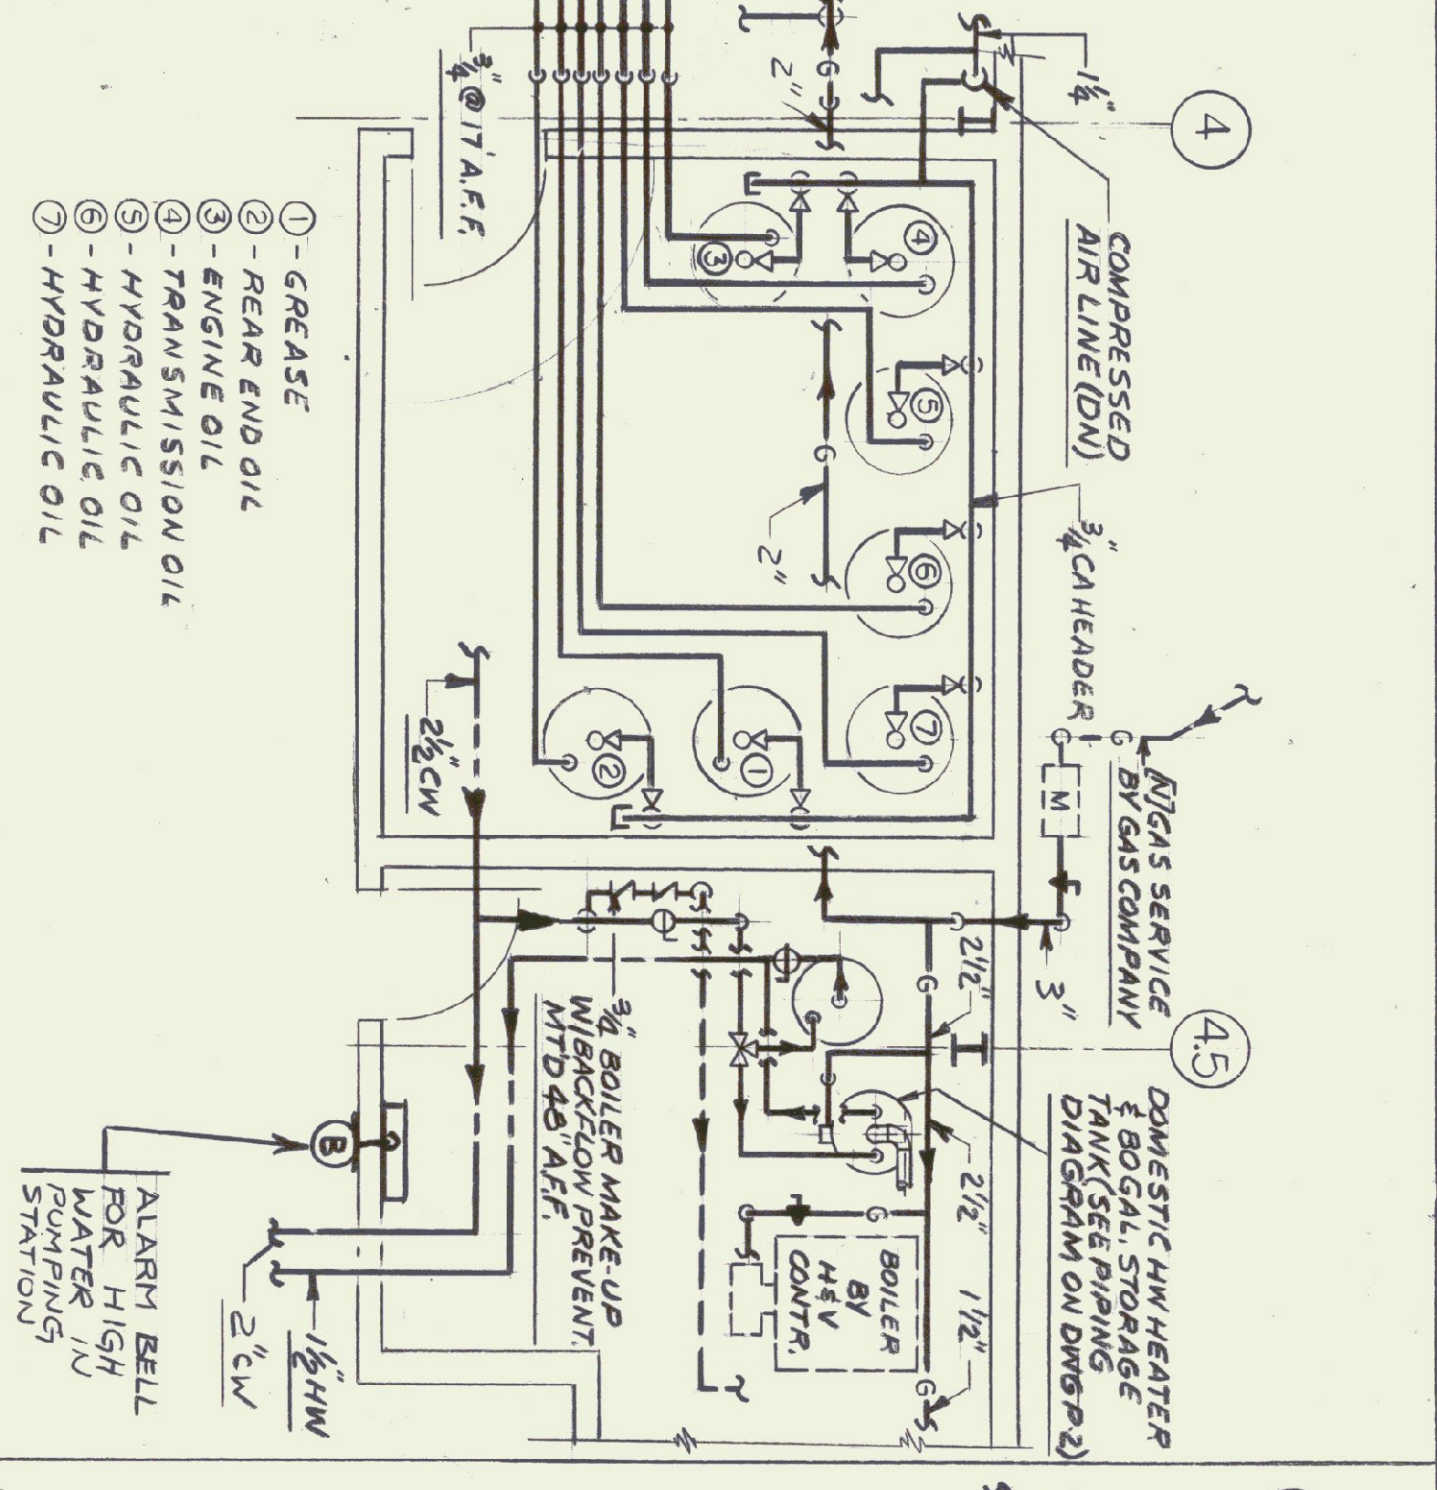


NOTE:
1. SEE GREASE & LUBRICATING OIL SYSTEM PIPING DIAGRAM ON DWG U-2
2. DRAWINGS & ASSOCIATED HOSE REELS BY OWNER (OE-3) & INSTALLED BY H.C. INCLUDING ALL INTERCONNECTING PIPING VALVES ETC.


OIL STORAGE ROOM PLAN
SCALE: 1/4"=1'-0"

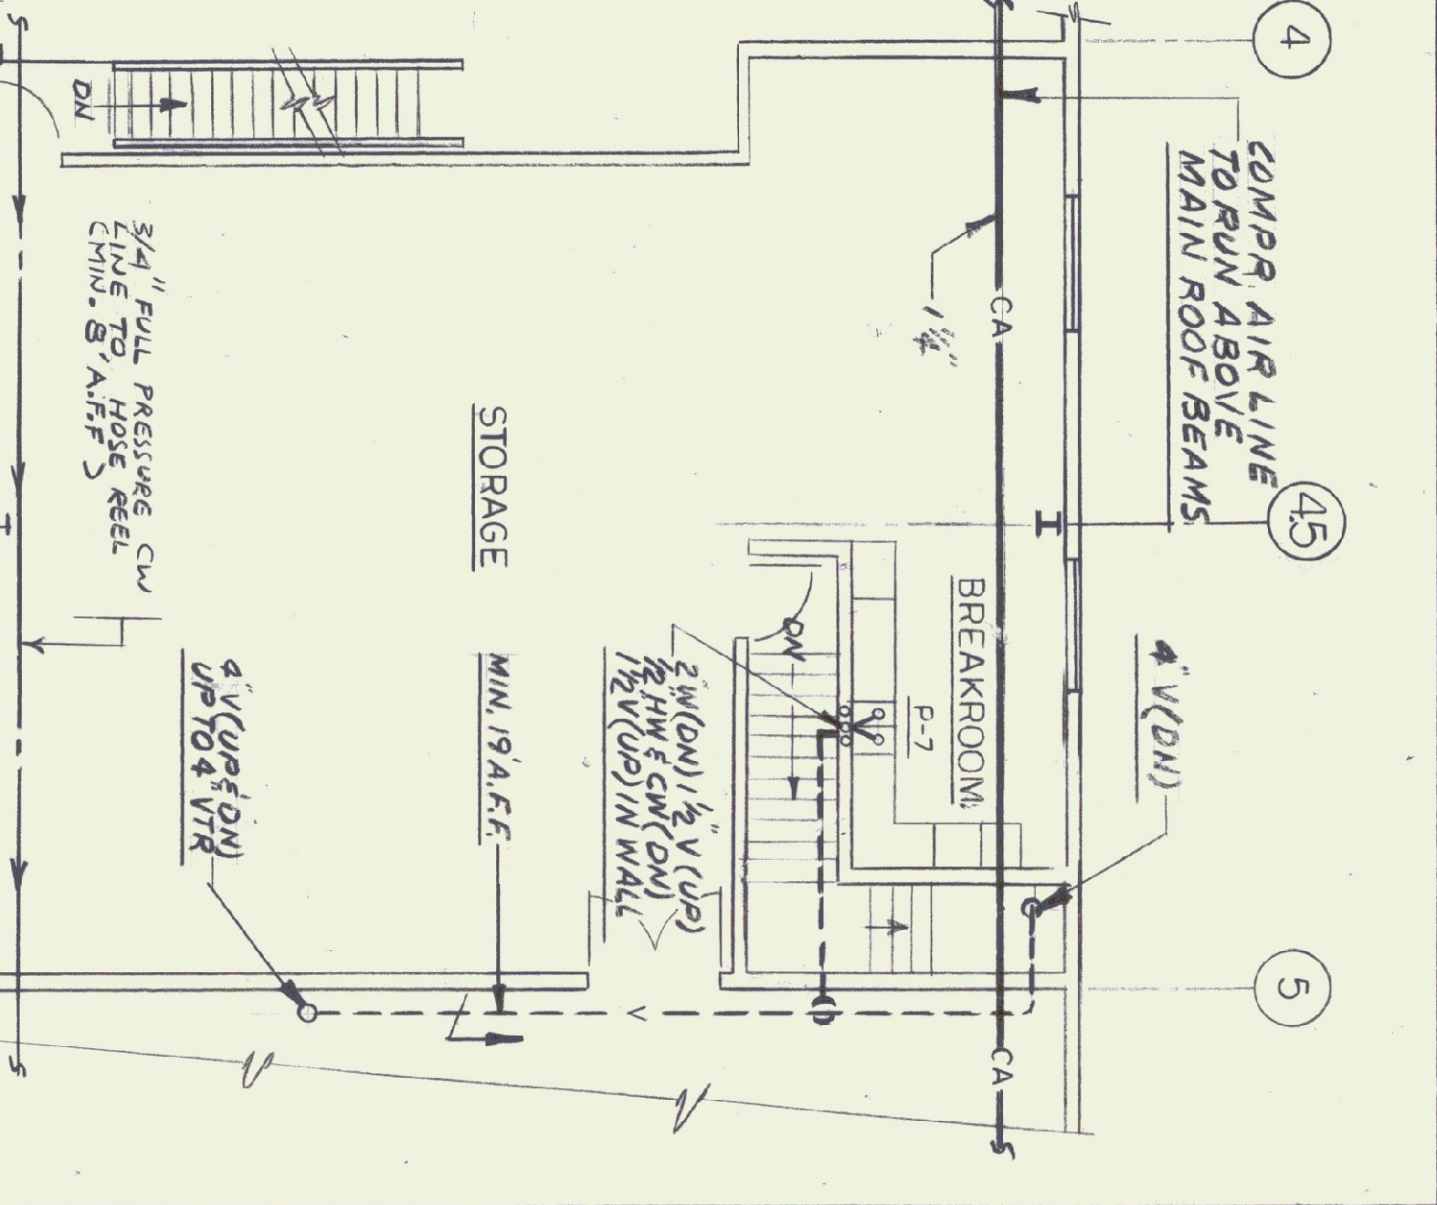


SECOND FLOOR PLAN
SCALE: 1/8"=1'-0"

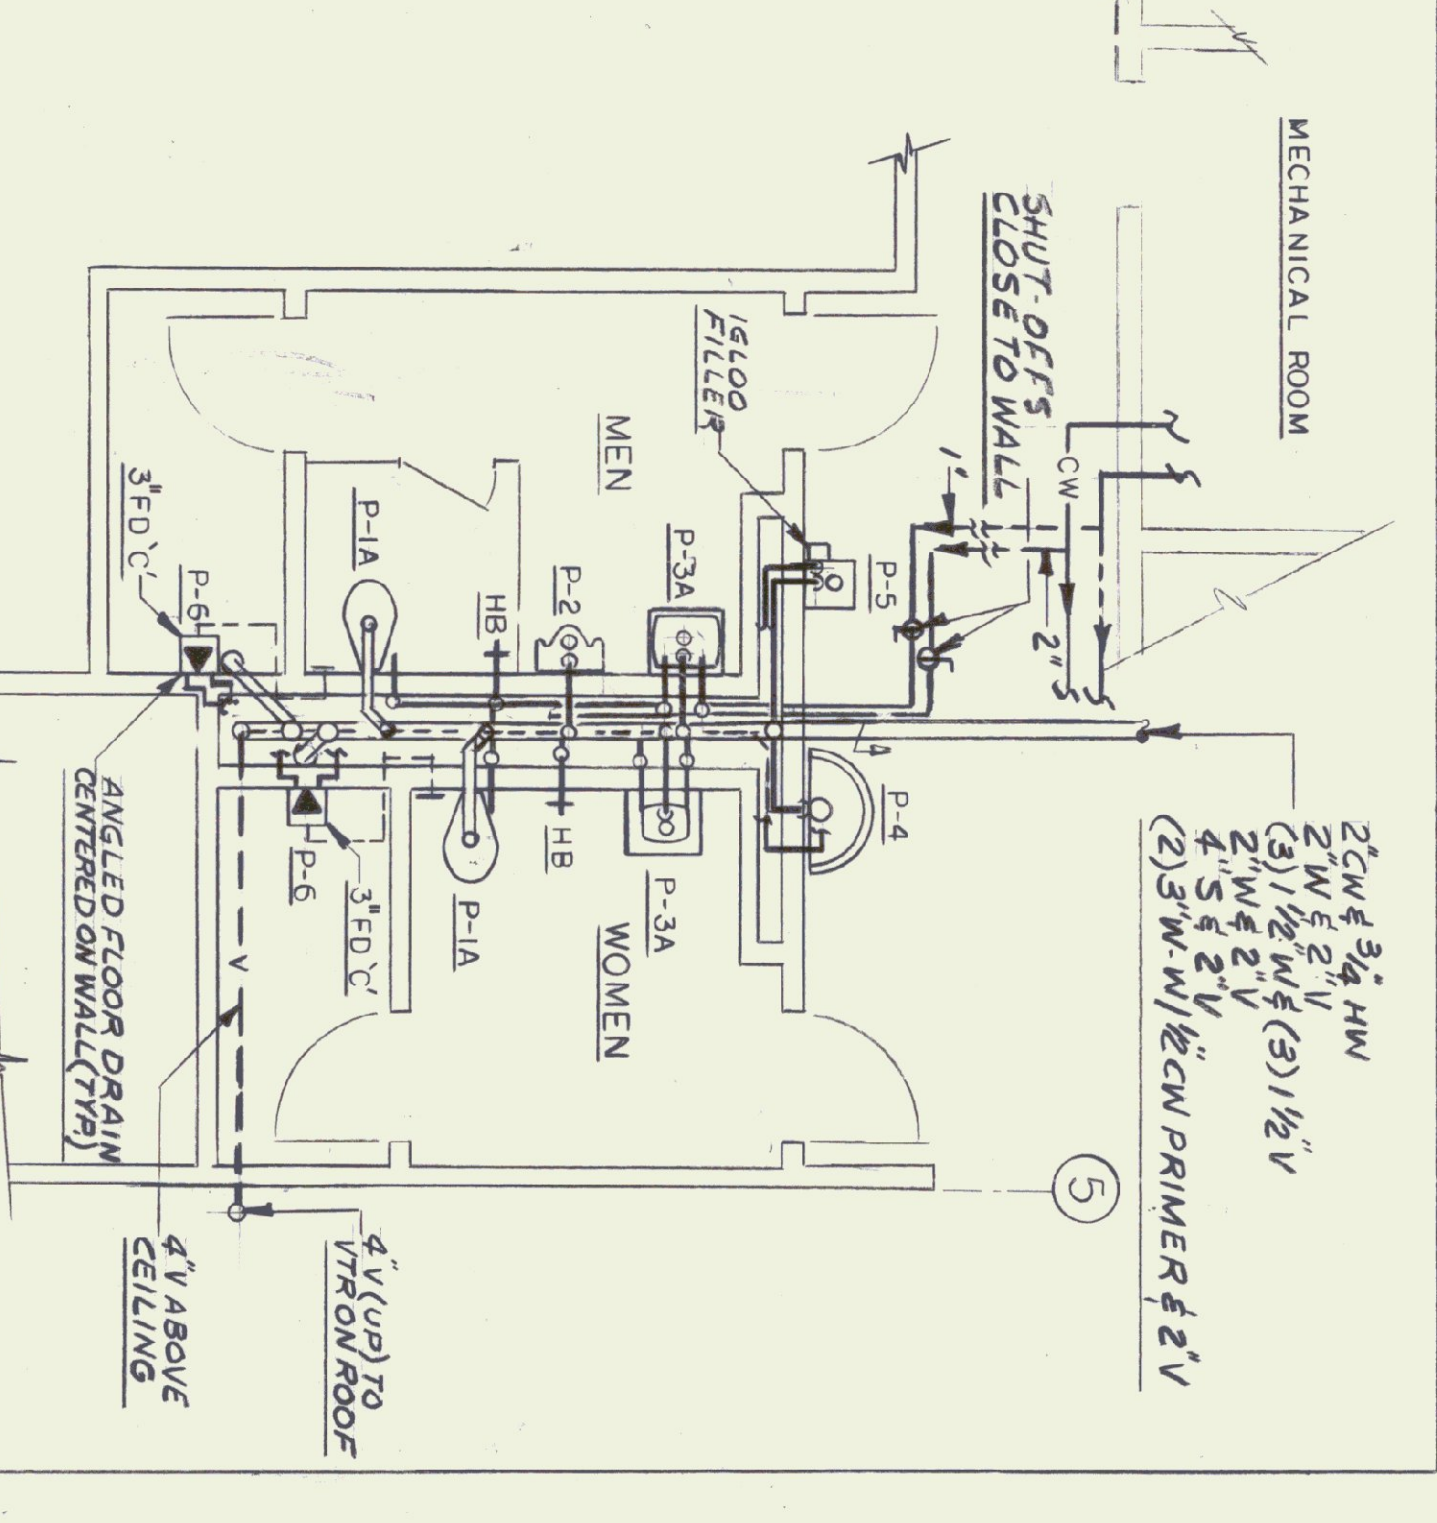

PLUMBING-MEN'S/WOMEN'S AREA-FLOOR PLAN
SCALE: 1/4"=1'-0"

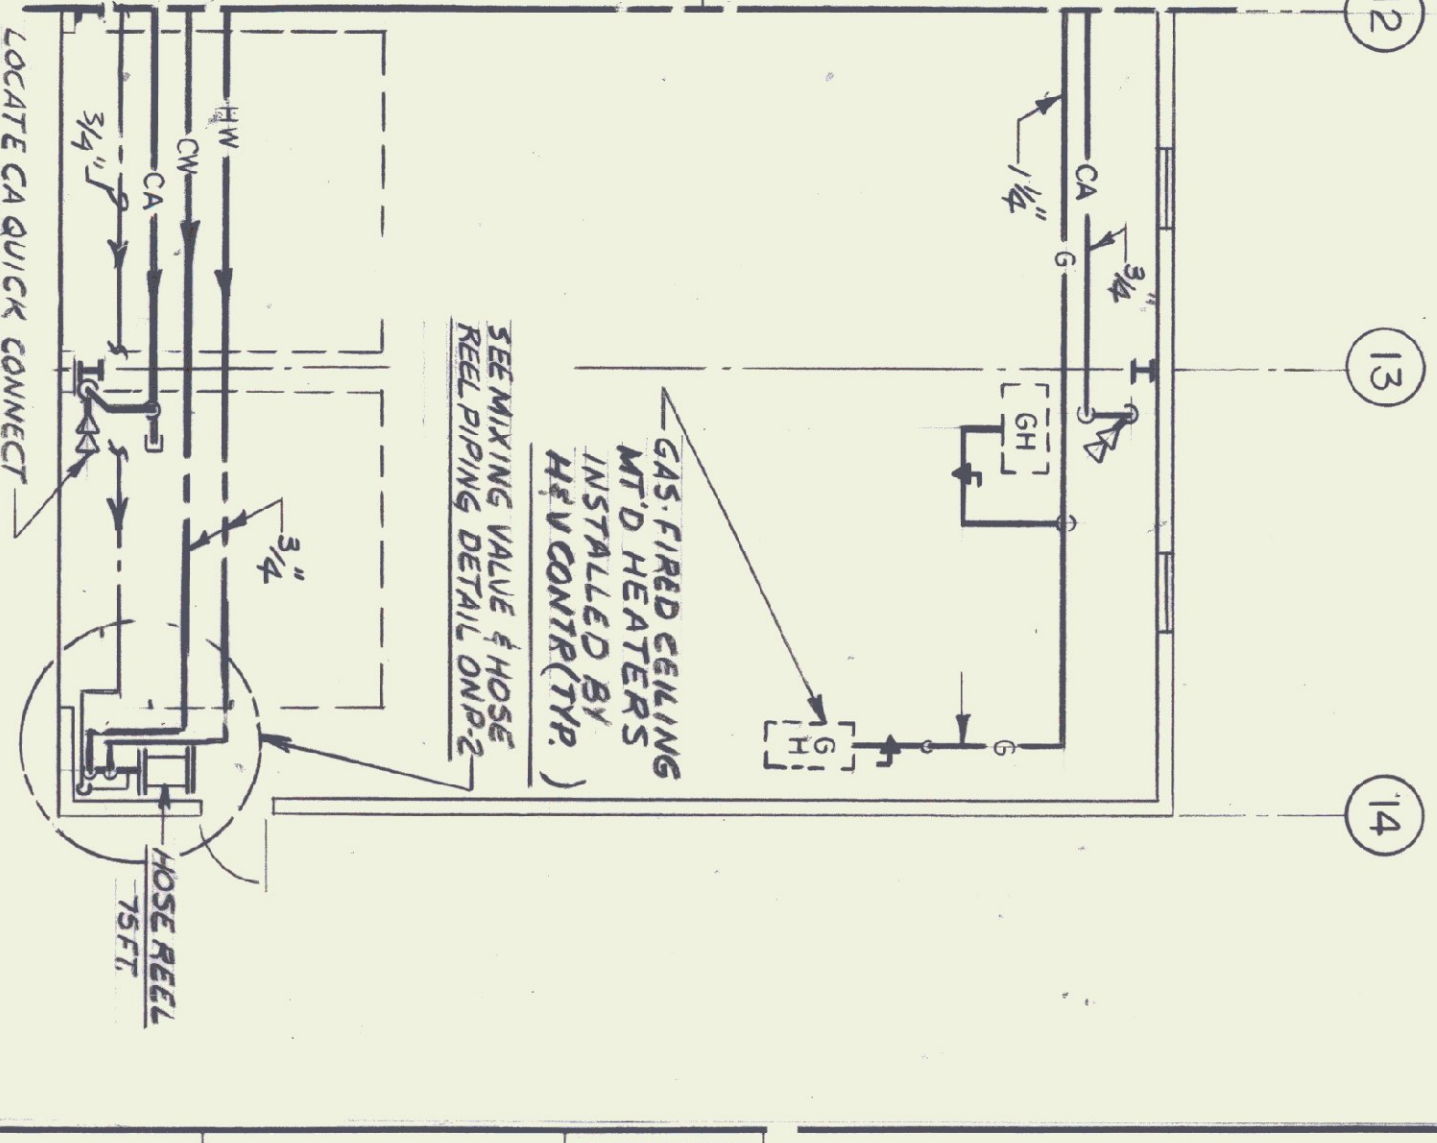

PLUMBING-PARTIAL MAIN LEVEL PLAN
SCALE: 1/8"=1'-0"

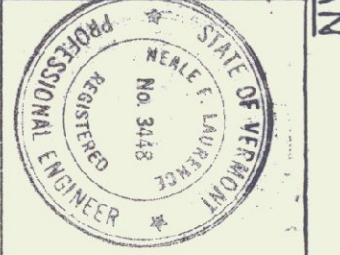

REVISIONS	DATE	BY	APPR.
1	10/15/99	OG	NFL
2	1/10/00		

AGENCY OF TRANSPORTATION
COLCHESTER MAINTENANCE FACILITY
CHIMNEY CORNERS
COLCHESTER, VERMONT

STATE OF VERMONT
DEPARTMENT OF BUILDINGS
AND GENERAL SERVICES
AGENCY OF ADMINISTRATION
MONTPELIER, VERMONT

DORE AND WHITTIER INC.
ARCHITECTS • PROJECT MANAGERS
206 WILSON ROAD, SOUTH BURLINGTON, VERMONT
N.F. LAURENCE and ASSOC. INC.
113 WEST MAIN STREET NORTHBOROUGH, MA.