




ROOF VENT DETAIL  
NOT TO SCALE

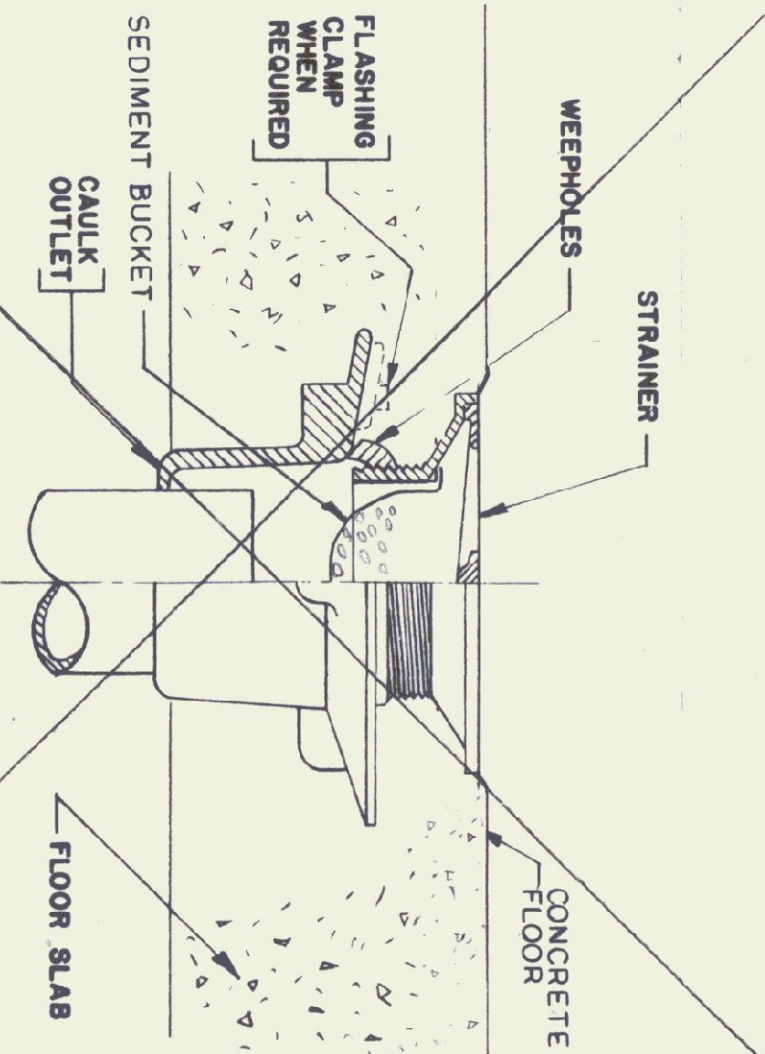


FLOOR DRAIN DETAIL  
NOT TO SCALE  
N.I.C.

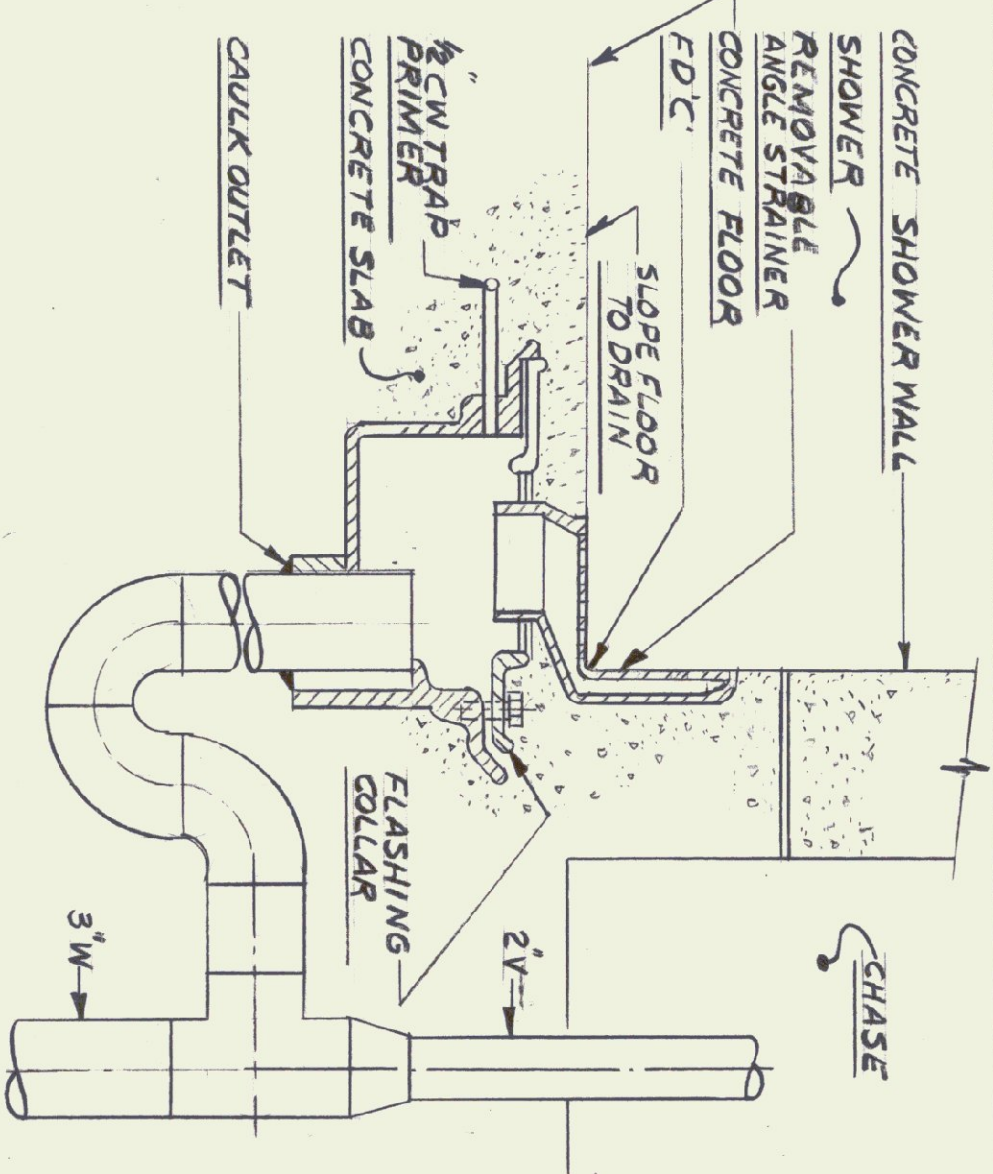

SHOWER -  
TYPE FD'C - ANGLE FLOOR DRAIN DETAIL  
NTS

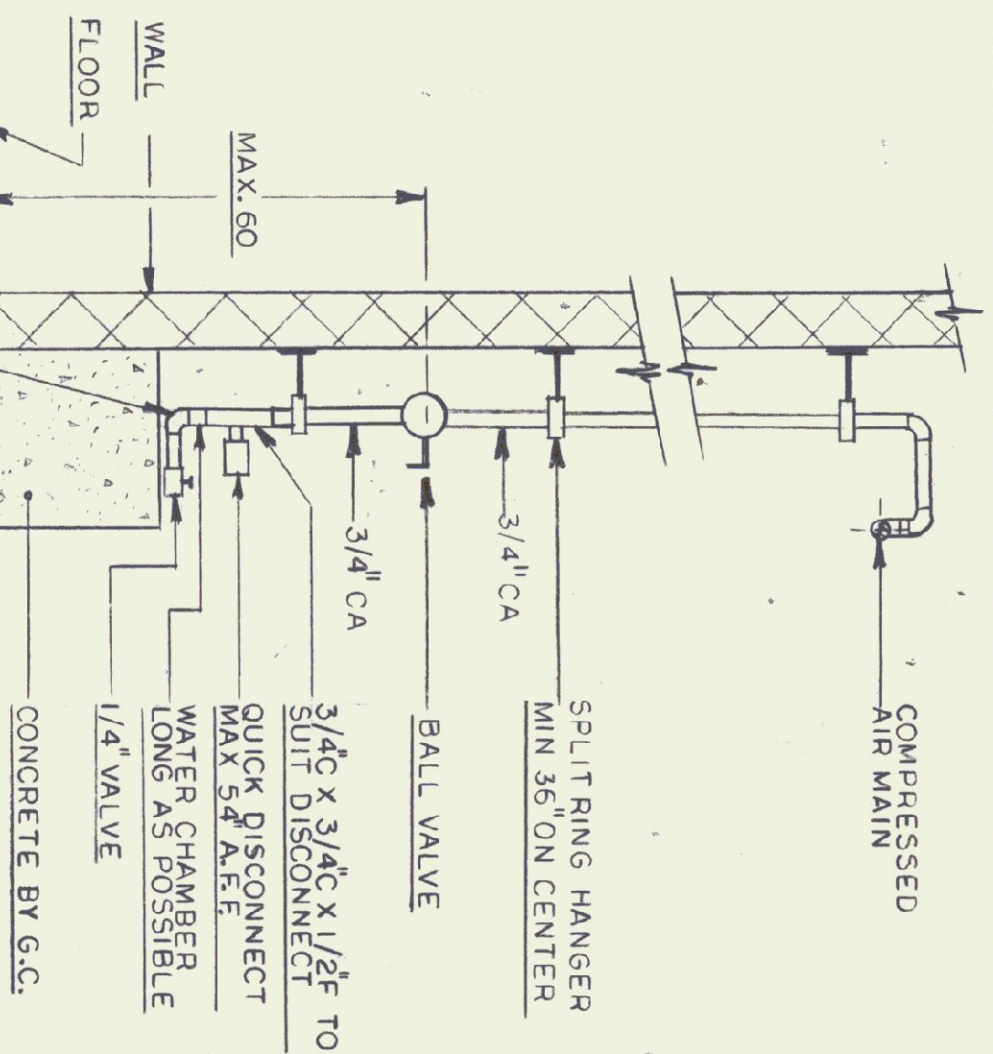

TYPICAL COMPRESSED AIR PNEUMATIC OUTLET DETAIL  
NTS

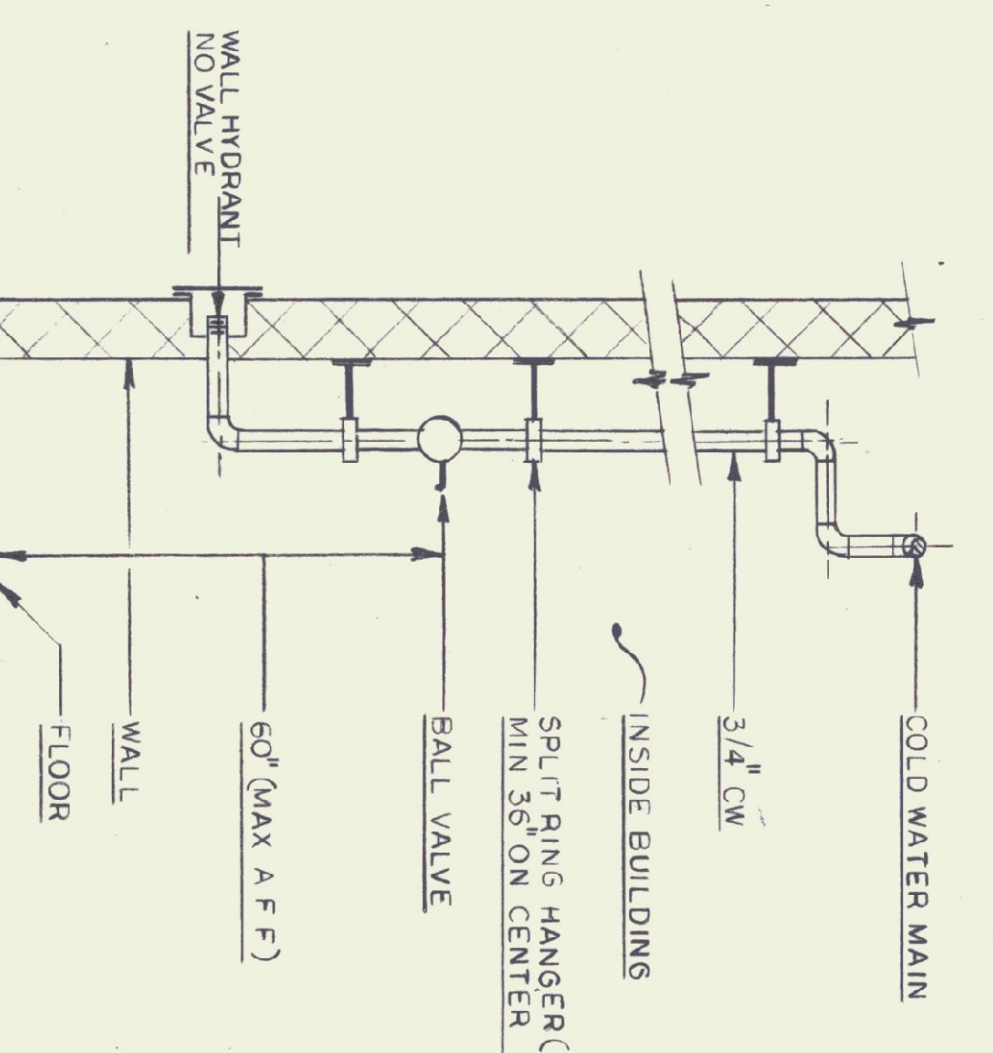


TYPICAL OUTSIDE WALL HYDRANT DETAIL  
NTS


PLUMBING FIXTURE & RUNOUT SCHEDULE						
MARK	FIXTURE	DESCRIPTION	COLD WATER	HOT WATER	WASTE	VENT
P-1A	WATERCLOSET	WALL HUNG, HANDICAPPED USE	1 1/2"	1 1/2"	4"	2"
P-2	URINAL	WALL HUNG	3/4"	---	2"	2"
P-3A	LAVATORY	WALL HUNG, HANDICAPPED USE	1 1/2"	1 1/2"	1 1/2"	1 1/2"
P-4	WASHFOUNTAIN	---	1 1/2"	1 1/2"	2"	2"
P-5	WATER COOLER	WITH 16GAL FILLER	1 1/2"	---	1 1/2"	1 1/2"
P-6	SHOWER	---	1 1/2"	1 1/2"	3"	2"
P-7	KITCHEN SINK	---	1 1/2"	1 1/2"	2"	1 1/2"

OWNER EQUIPMENT SCHEDULE					
MARKING SYMBOL	DESCRIPTION	MANUF. #	MECHANICAL REQUIREMENTS	ELECTRIC REQUIREMENTS	REMARKS
DE	HAND GRANK HOSE REEL FOR WASHING TRUCKS	FEELCRAFT H-19000	3/4" TEMPERED WATER PWS 3/4" FULL PWS 3/4"	N/A	WITH 75 HOSE
DE	AIR COMPRESSED AIR SYSTEM	CHAMPION VR 5-9 80 GAL	INSTALL 1/2" COMPRESS AIR REEL & PURSUING	230V/1 PHASE AIR COMPRESS 70 AMP	80-117446 BT OWNER ONLY
DE	GENERATOR	ALEMITE	COMPRESSED AIR REEL & PURSUING SYSTEM	N/A	---
DE	EMERGENCY GENERATOR	SOUTHWORTH MILTON (NH)	2" GAS SUPPLY	INSTALLED & WIRED	---


PLUMBING LEGEND	
✓	SANITARY OR WASTE LINE (ABOVE GROUND)
✓	SANITARY OR WASTE LINE (BELOW GROUND)
✓	STORM LINE (ABOVE GROUND)
✓	STORM LINE (BELOW GROUND)
✓	GAS LINE
✓	COMPRESSED AIR LINE
✓	FIRE LINE
✓	VENT LINE (ABOVE GROUND)
✓	VENT LINE (BELOW GROUND)
✓	COLD WATER LINE (ABOVE GROUND)
✓	COLD WATER LINE (BELOW GROUND)
✓	HOT WATER RECIRCULATING LINE
✓	CLEAN OUT
✓	FLOOR CLEAN OUT
✓	WALL HYDRANT OR HOSE BIBB
✓	GLOBE VALVE
✓	CHECK VALVE
✓	GATE VALVE
✓	FLOOR DRAIN WITH TRAP
✓	EXISTING
✓	POINT OF NEW PLUMBING CONNECTION TO EXISTING
✓	SANITARY LINE
✓	STORM LINE
✓	VENT LINE
✓	WASTE LINE
✓	TRAP
✓	ROOF DRAIN
✓	ROOF LEADER
✓	COLD WATER LINE
✓	ANGLED FLOOR DRAIN
✓	QUICK DISCONNECT
✓	SHOWER
✓	BALL VALVE
✓	VACUUM BREAKER
✓	NORMALLY CLOSED
✓	NOT IN CONTRACT

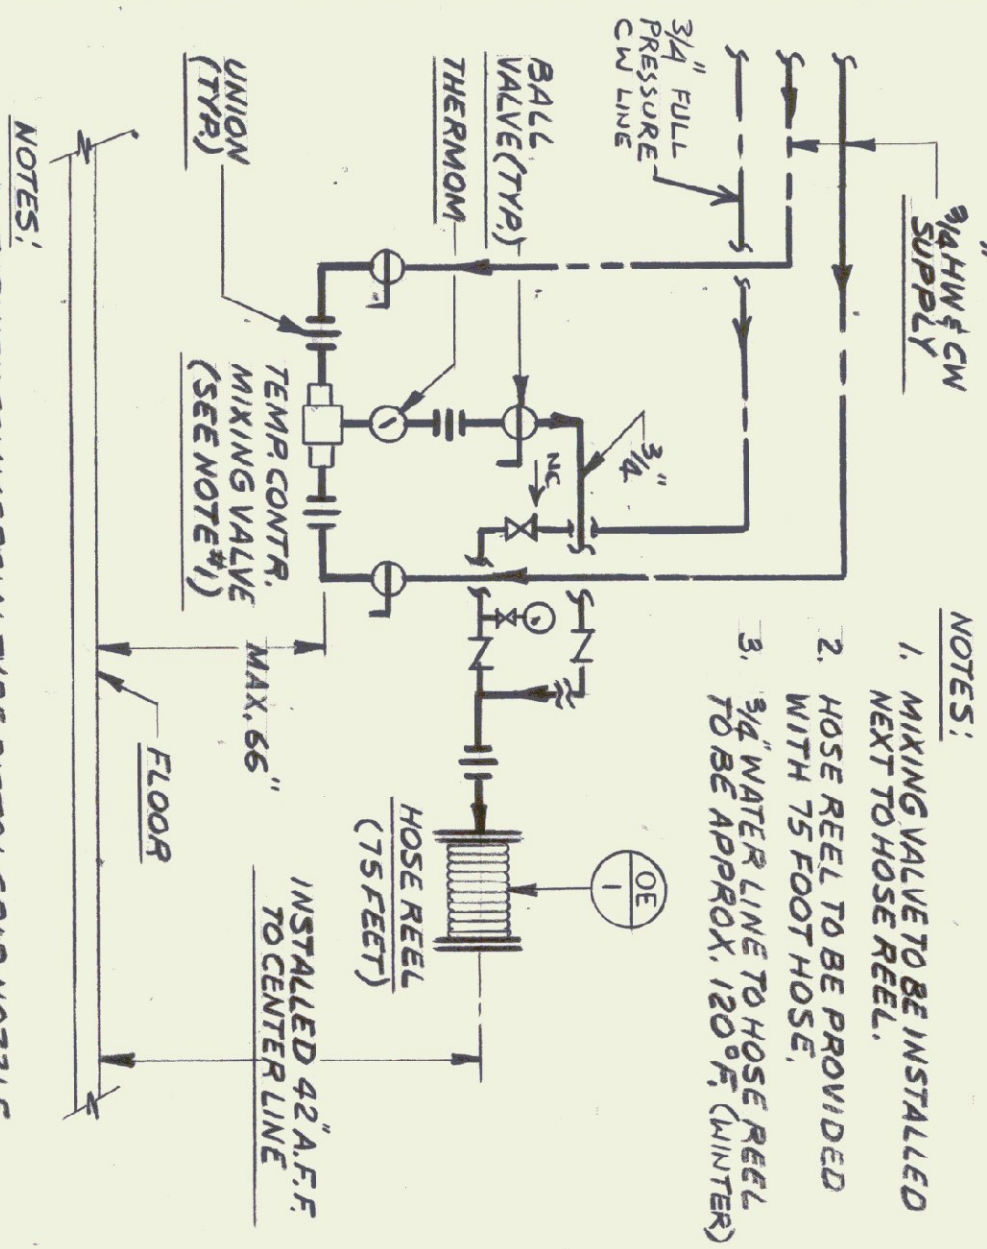




MIXING VALVE / HOSE REEL - PIPING DETAIL  
NTS

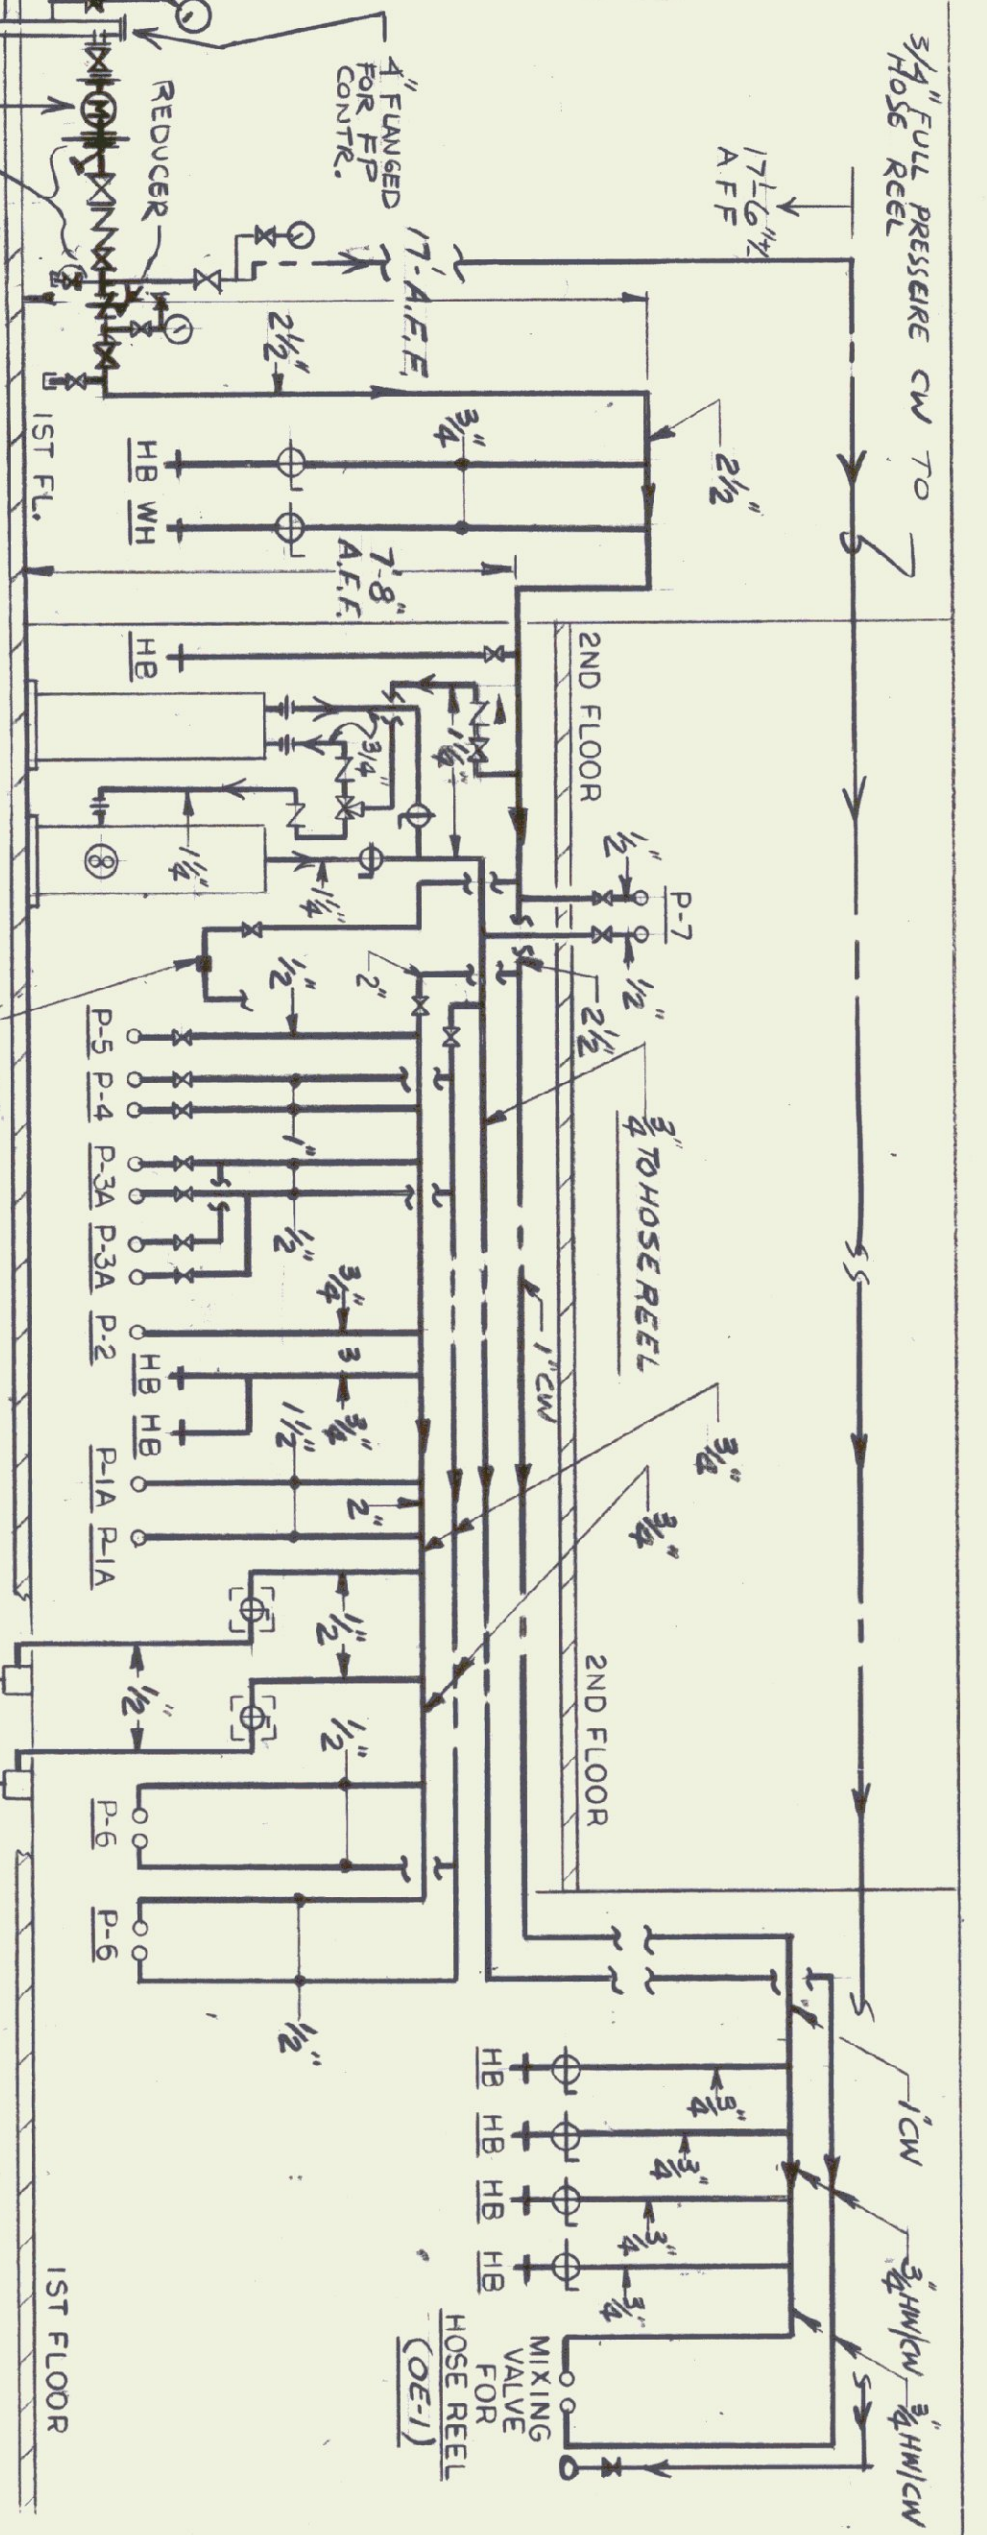

HOT & COLD WATER RISER DIAGRAM  
NTS

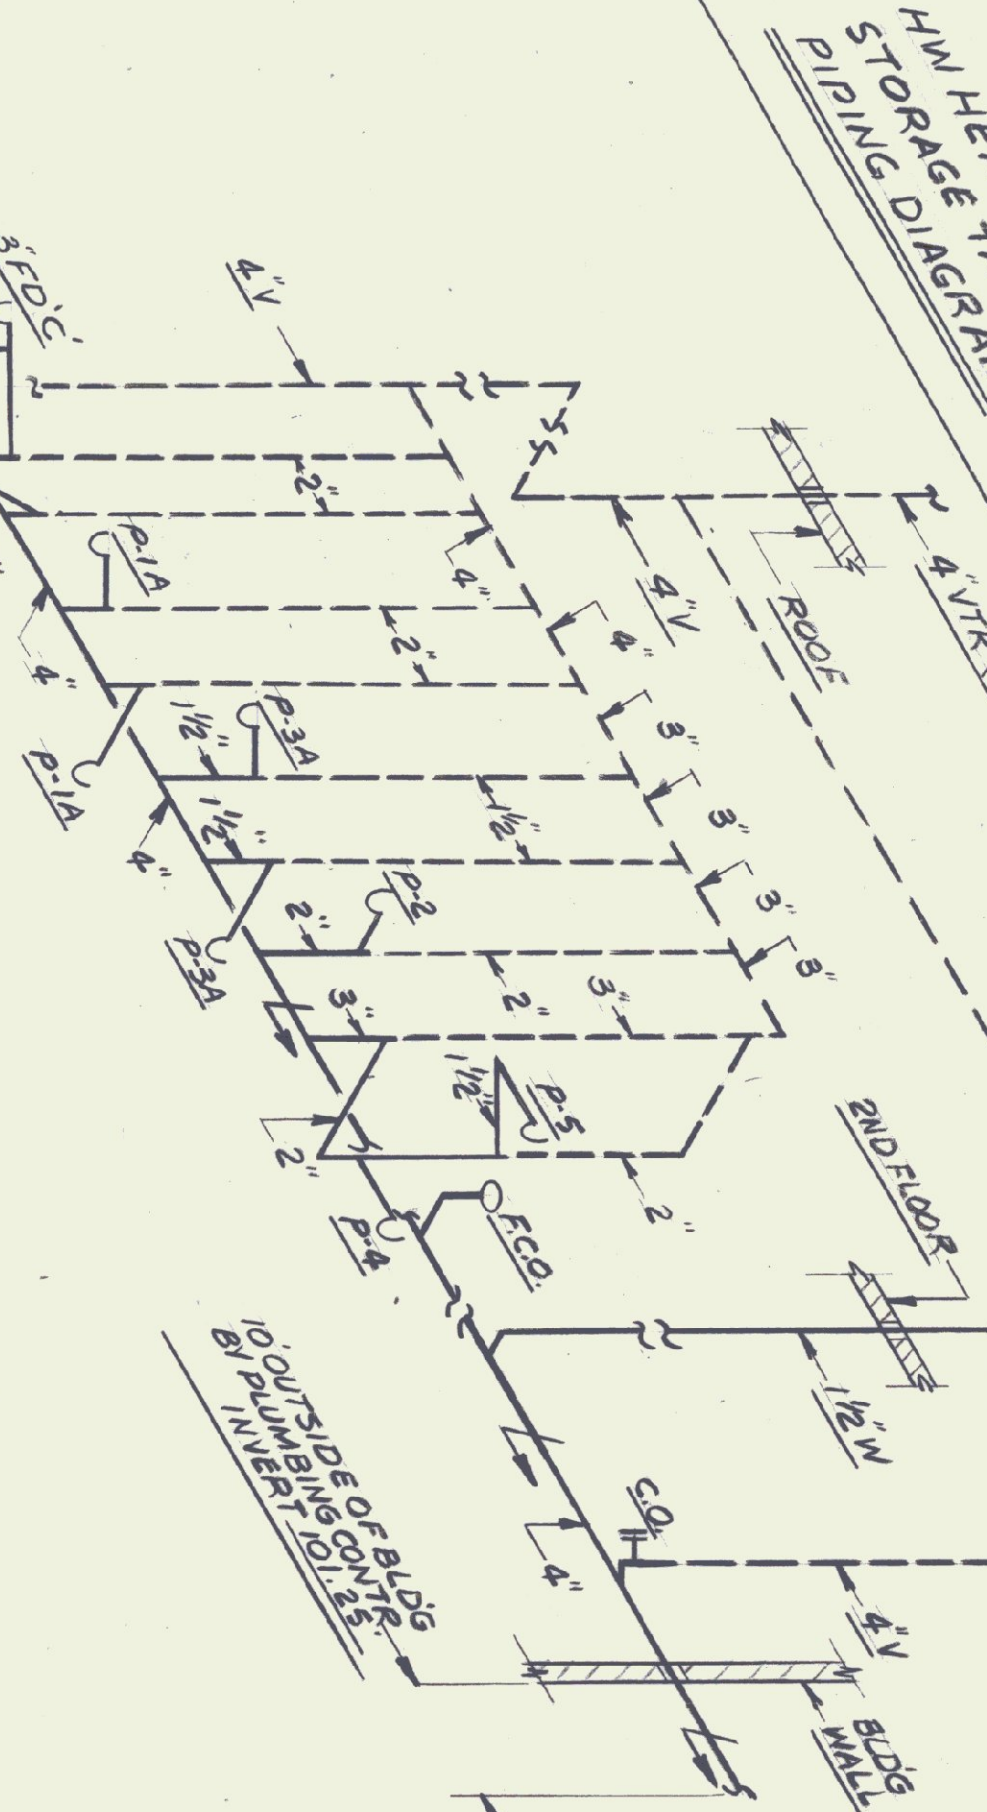

PLUMBING SANITARY & VENT ISOMETRIC DIAGRAM  
NTS

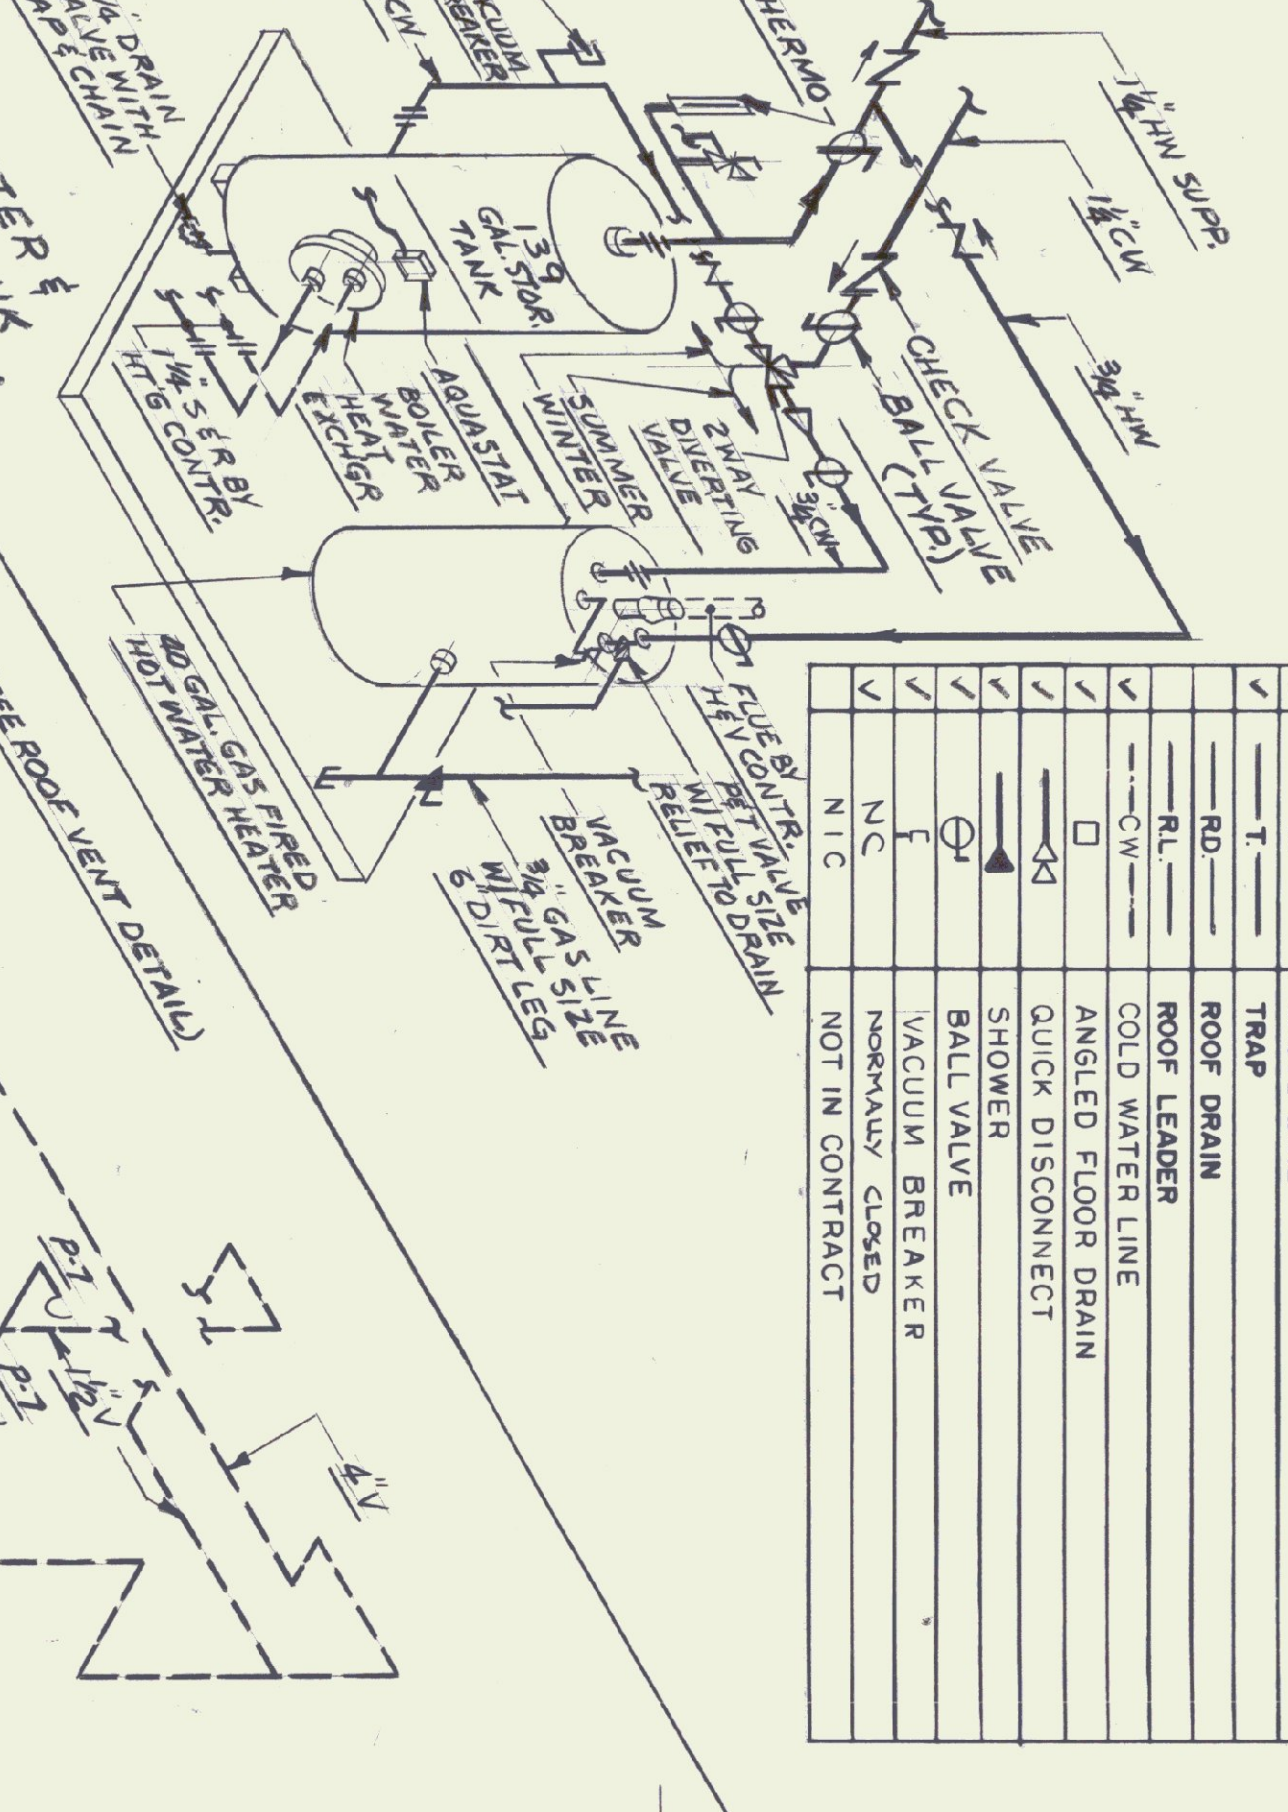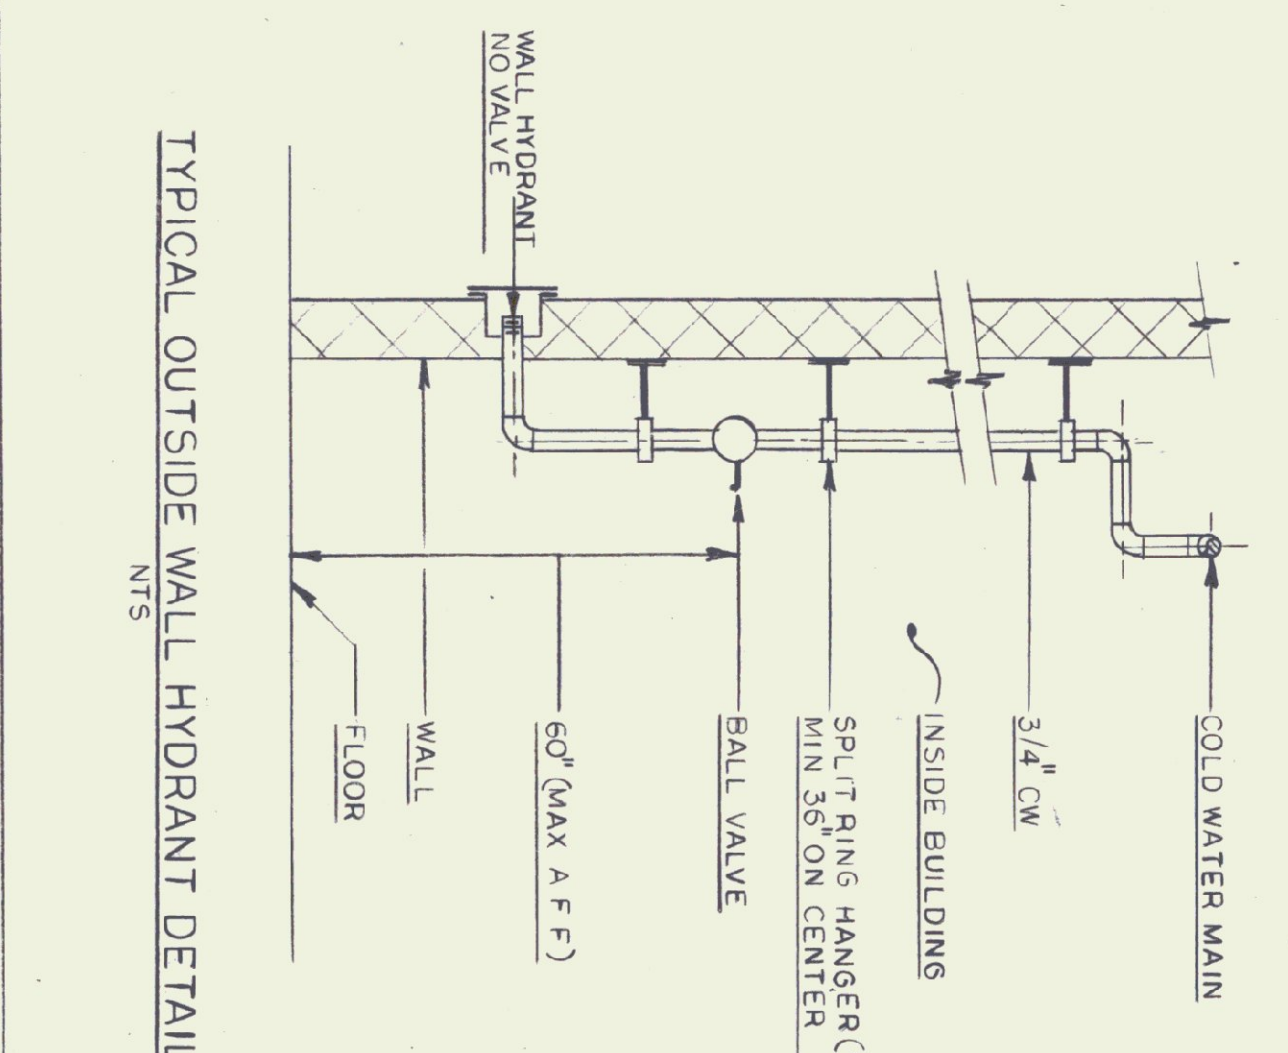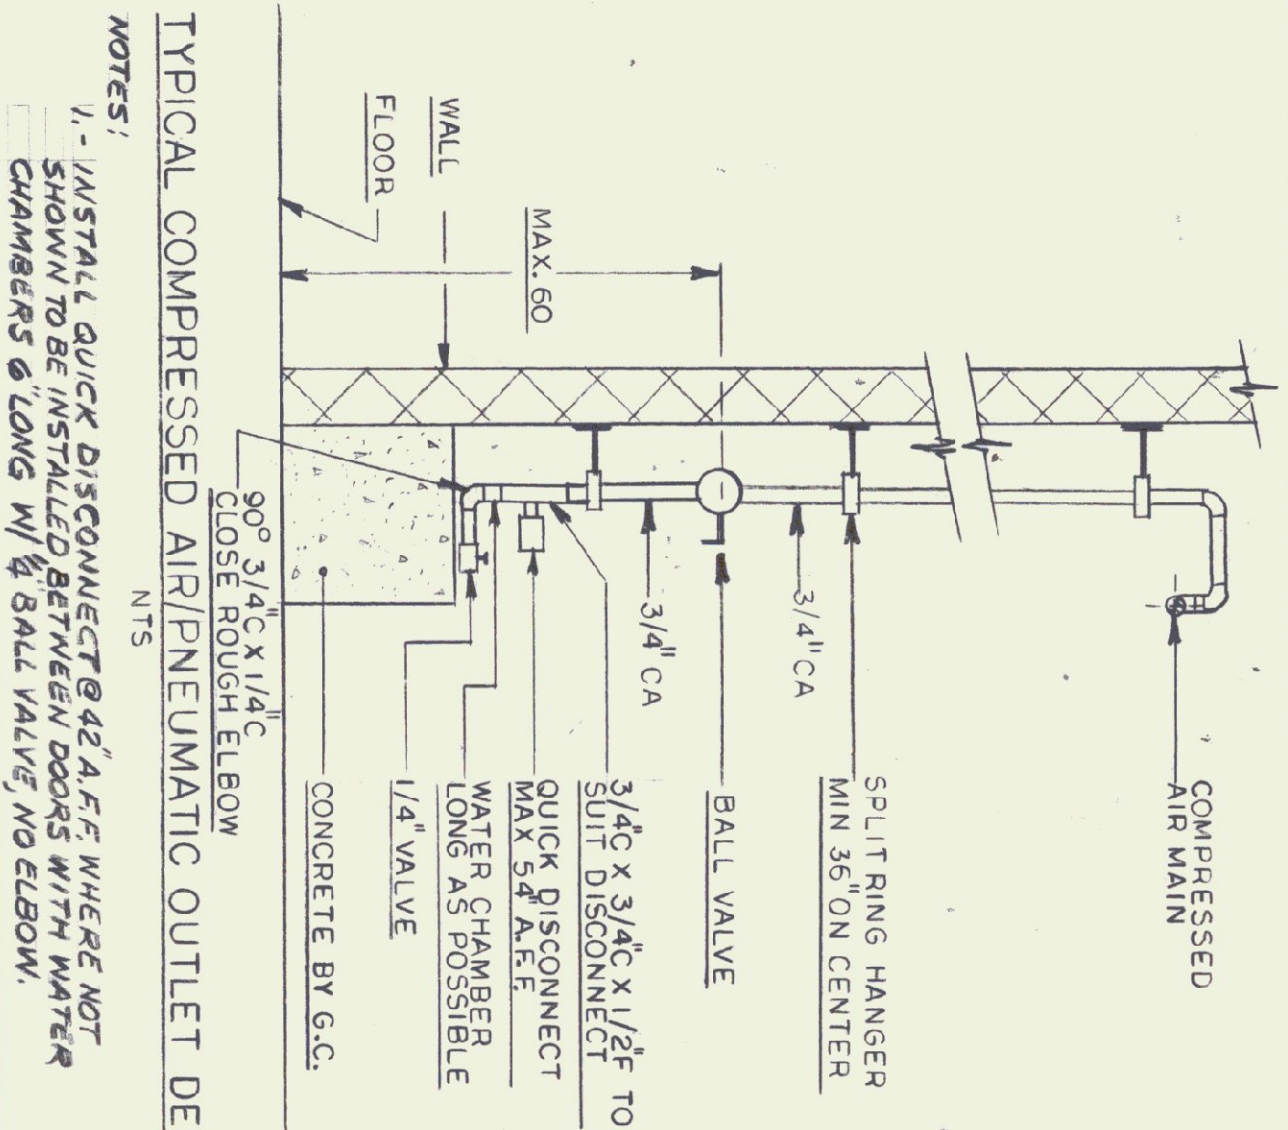

AGENCY OF TRANSPORTATION  
COLCHESTER MAINTENANCE FACILITY  
CHIMNEY CORNERS  
COLCHESTER, VERMONT

STATE OF VERMONT  
DEPARTMENT OF BUILDINGS  
AND GENERAL SERVICES  
AGENCY OF ADMINISTRATION  
MONTPELIER, VERMONT

DORE AND WHITTIER INC.  
ARCHITECTS • PROJECT MANAGERS  
ONE WILLOW ROAD, SOUTH DUBLINGTON, VERMONT  
N.F. LAURENCE and ASSOC. INC.  
113 WEST MAIN STREET NORTHBOROUGH MA.

REVISIONS  
DATE: 10/15/99  
DRAWN BY: DG  
APPR BY: NFL  
SCALE: AS NOTED  
PLUMBING LEGEND DETAILS  
P-2  
30 OF 36

