

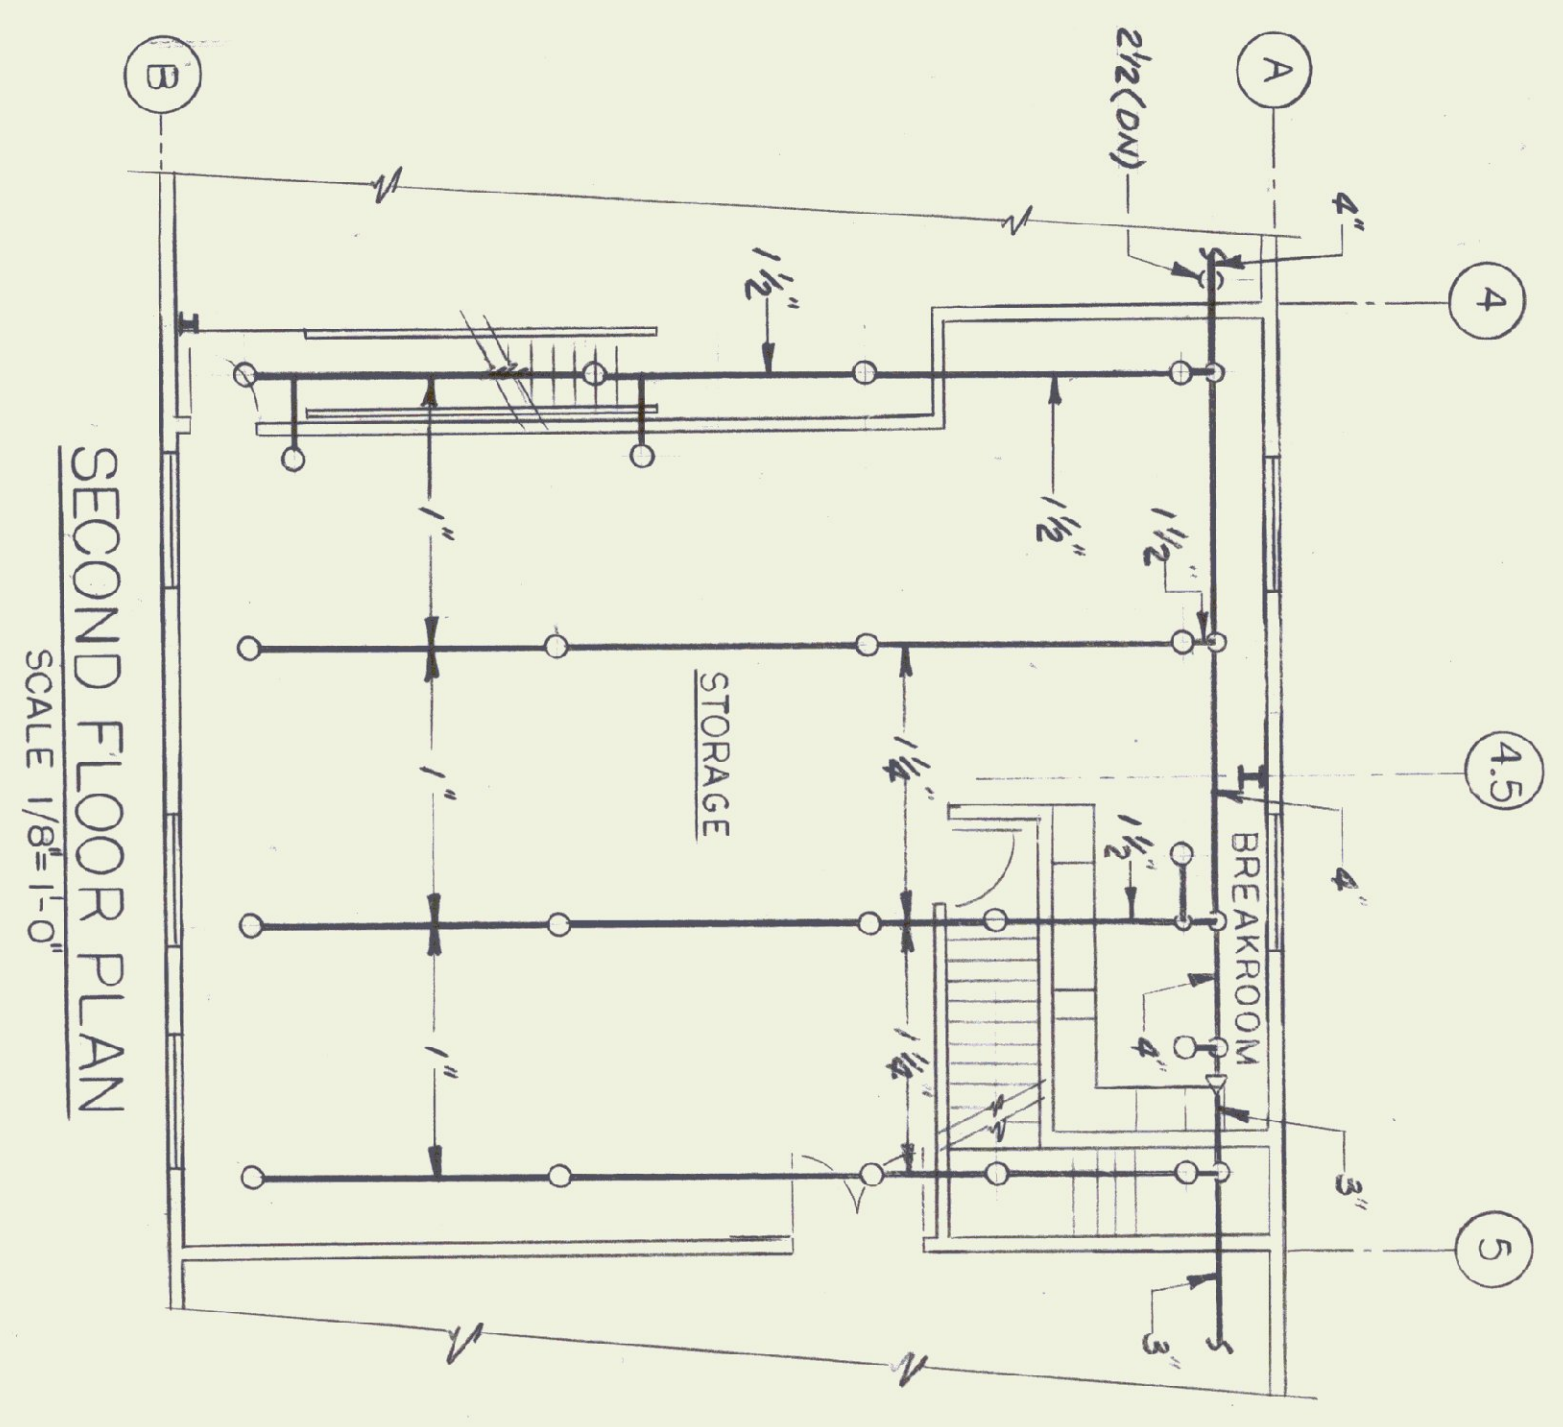


FIRE PROTECTION LEGEND	
○	UPRIGHT SP HEAD
●	PENDANT SP HEAD
▲	SIDEWALL SP HEAD
□	FIRE PROTECTION
SP	SPRINKLER
FDV	FIRE DEPT VALVE
OS&V	OUTSIDE SCREEN+YOKE
OS&V	VALVE W/TAMP SW
□	CHECK VALVE
Δ	FLOW SWITCH
Δ	FIRE ALARM VALVE
—	SPRINKLER/FIRE PROTECTION LINE


FIRE PROTECTION-MAIN LEVEL PLAN  
SCALE 1/8"=1'-0"

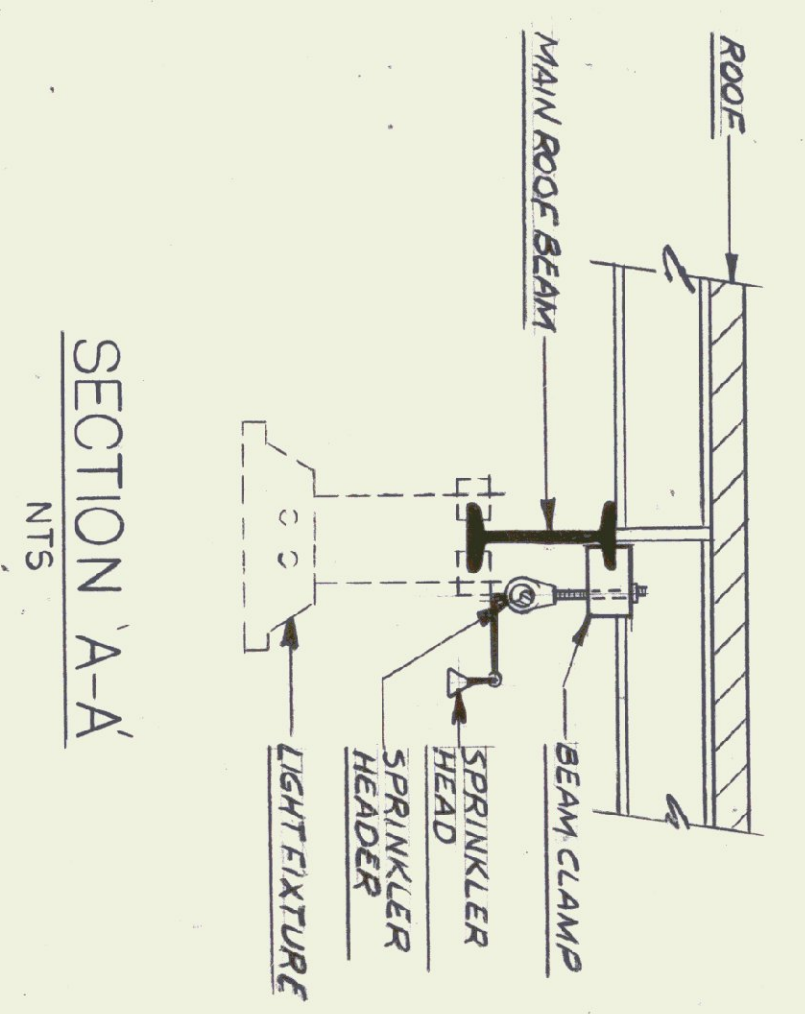

FIRE ALARM VALVE DETAIL  
NTS

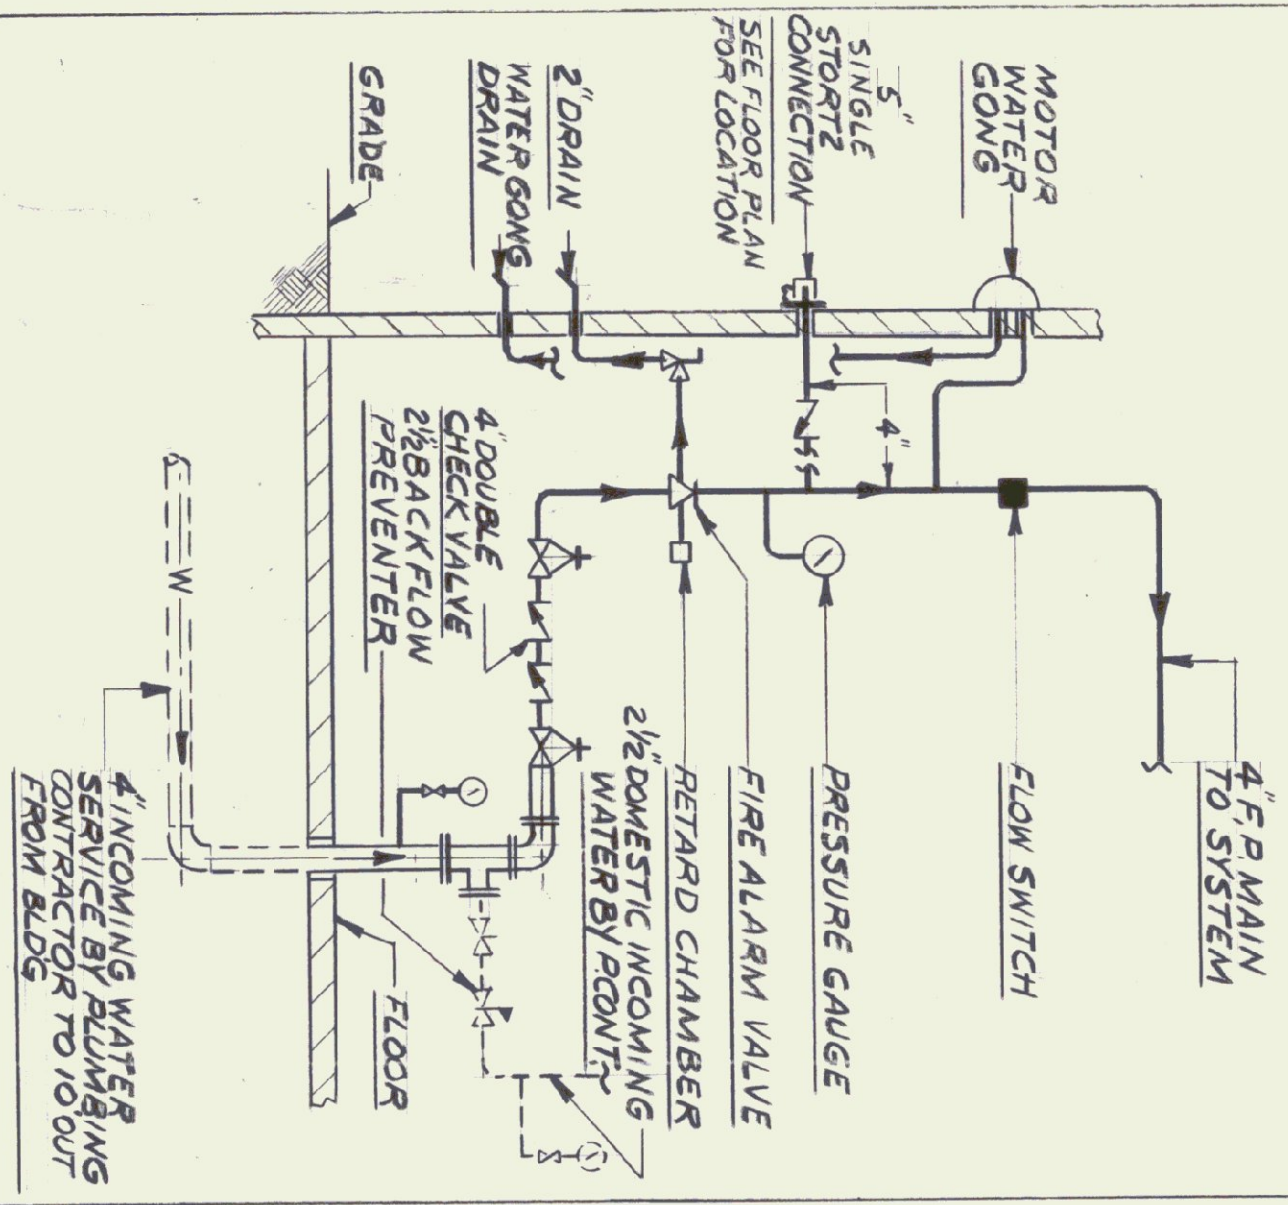

FIRE PROTECTION-PARTIAL MAIN LEVEL PLAN  
SCALE: 1/8"=1'-0"

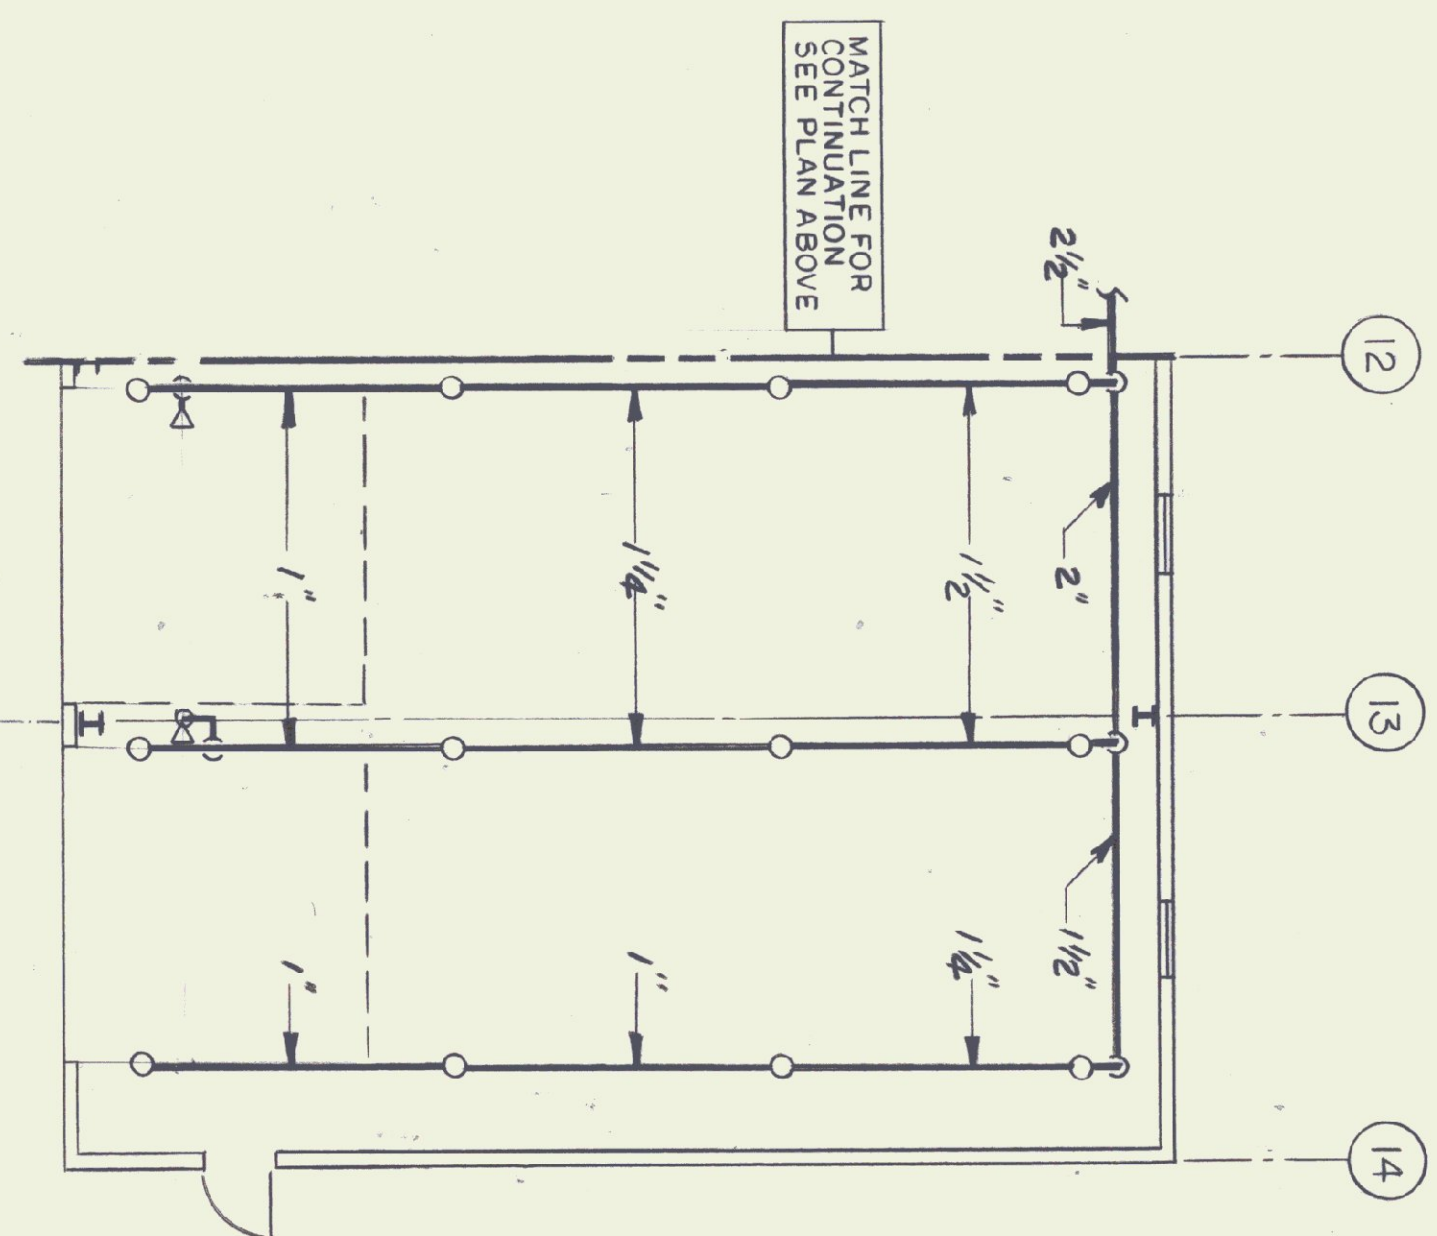

31 OF 36  
FP-1

MAINTENANCE GARAGE FIRE PROTECTION MAIN LEVEL PLAN 2ND FLOOR PLAN	COLCHESTER	SCALE: AS NOTED DATE: 10/15/99 DRAWN BY: KA, DG APPR BY: NFL	REVISIONS 1 2 3 11/8/00
---	------------	---	-------------------------------------

AGENCY OF TRANSPORTATION  
COLCHESTER MAINTENANCE FACILITY  
CHIMNEY CORNERS  
COLCHESTER, VERMONT

STATE OF VERMONT  
DEPARTMENT OF BUILDINGS AND GENERAL SERVICES  
AGENCY OF ADMINISTRATION  
MONTPELIER, VERMONT

DORE AND WHITTIER INC.  
ARCHITECTS • PROJECT MANAGERS  
1765 WILKINSON ROAD, SOUTH BURLINGTON, VERMONT  
N.F. LAURENCE and ASSOC. INC.  
113 WEST MAIN STREET NORTHBOROUGH, MA.