




LIGHTING-MAIN LEVEL PLAN
SCALE: 1/8"=1'-0"

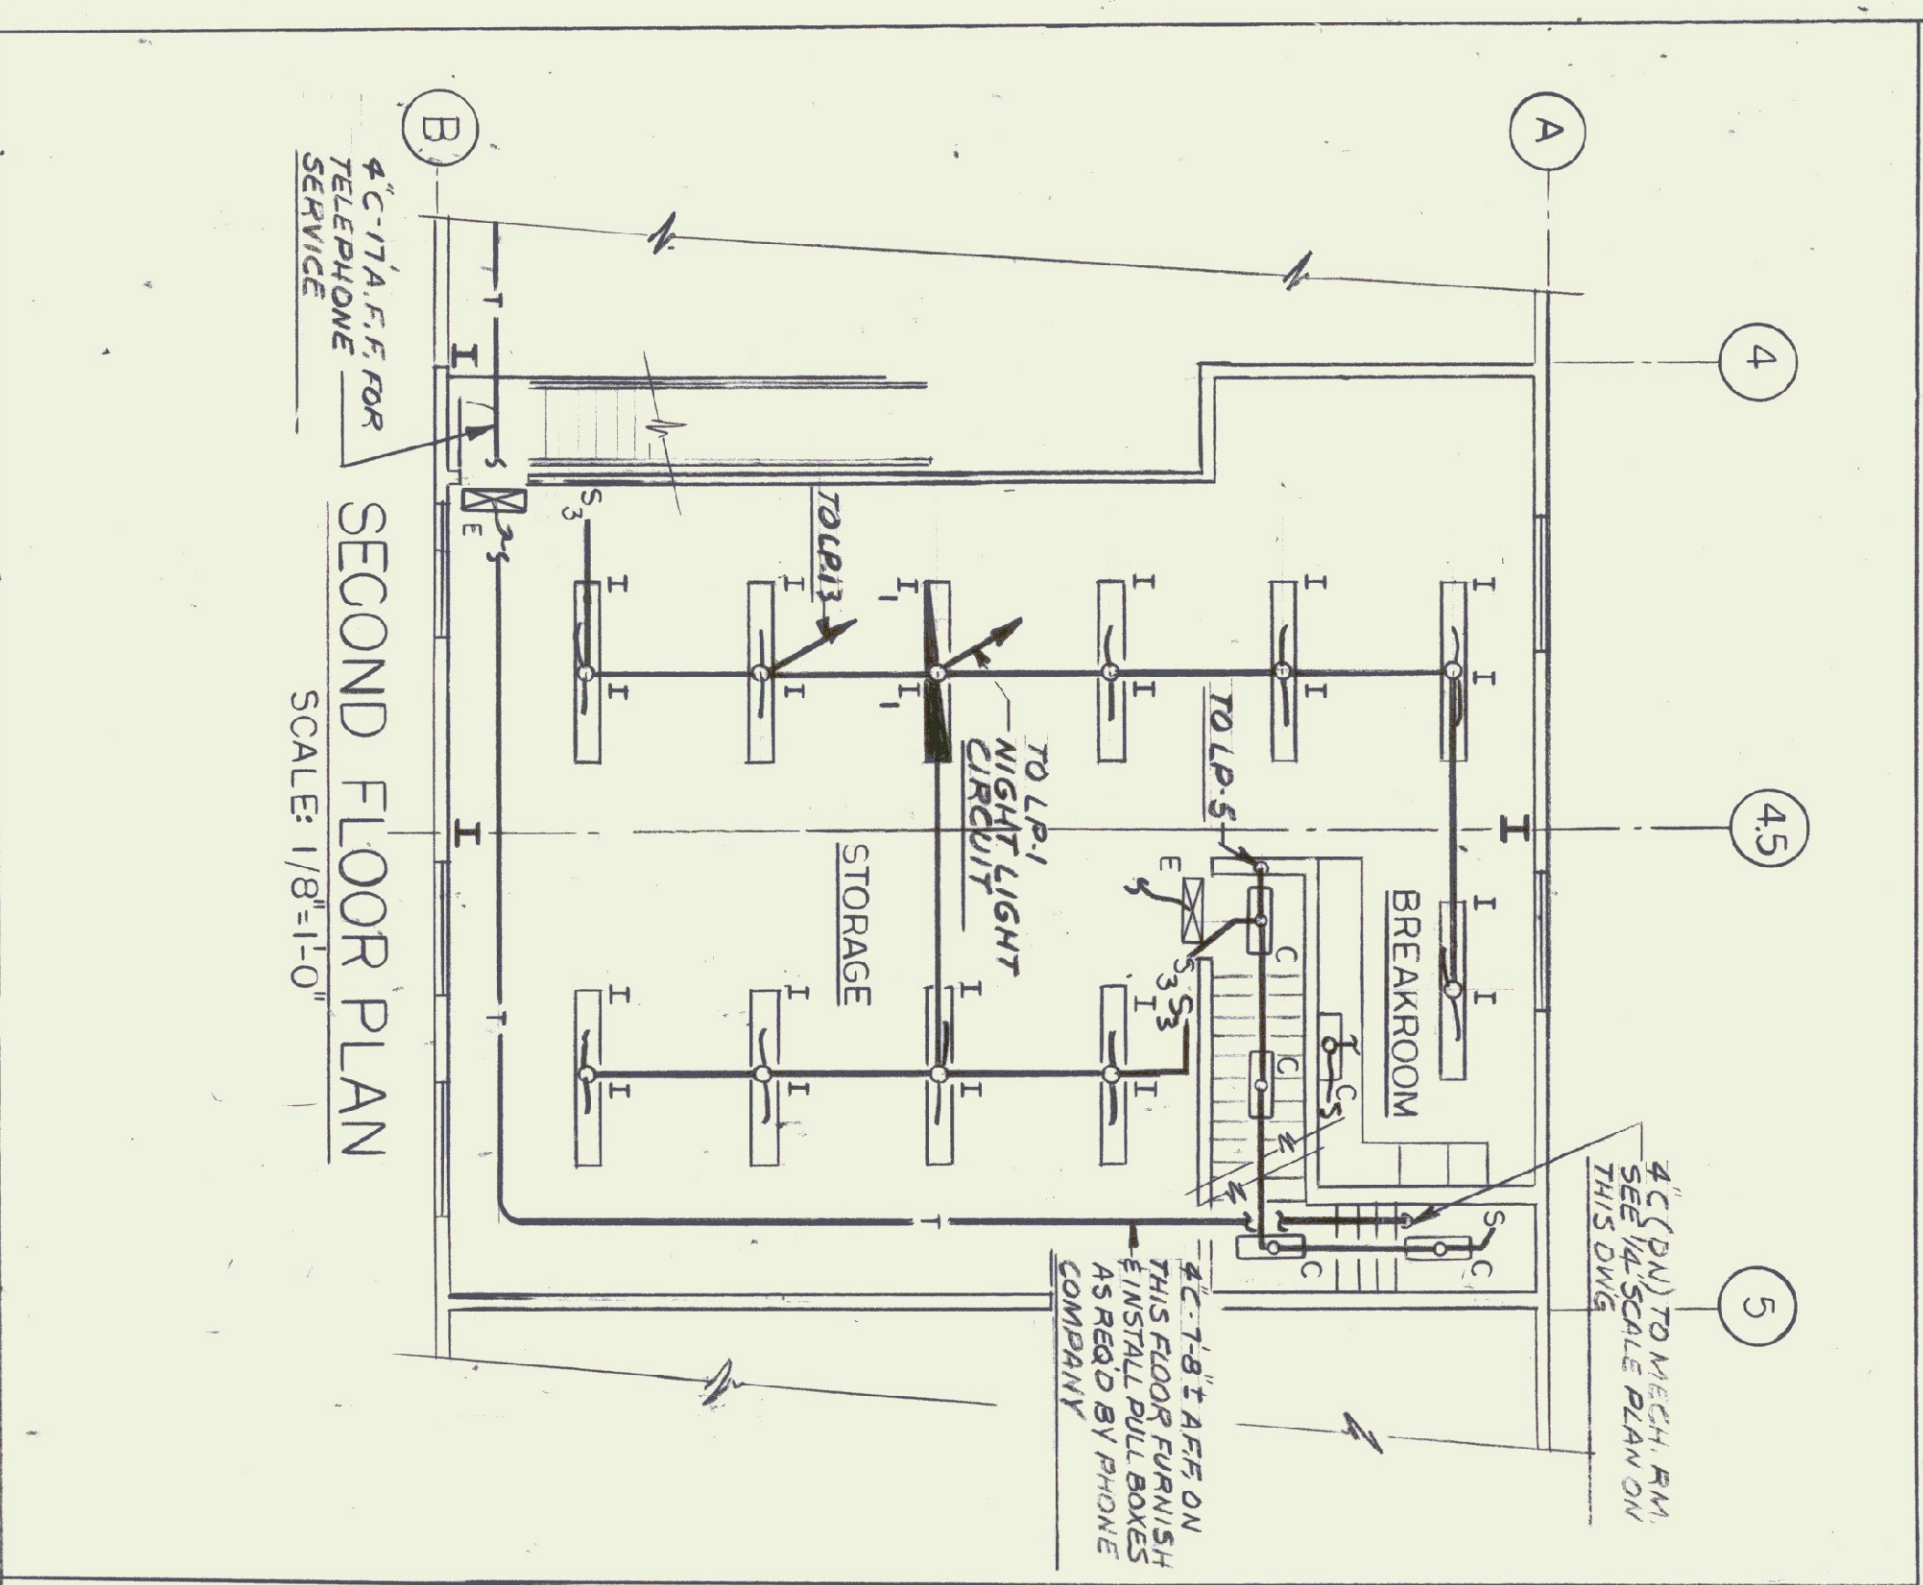


SECOND FLOOR PLAN
SCALE: 1/8"=1'-0"

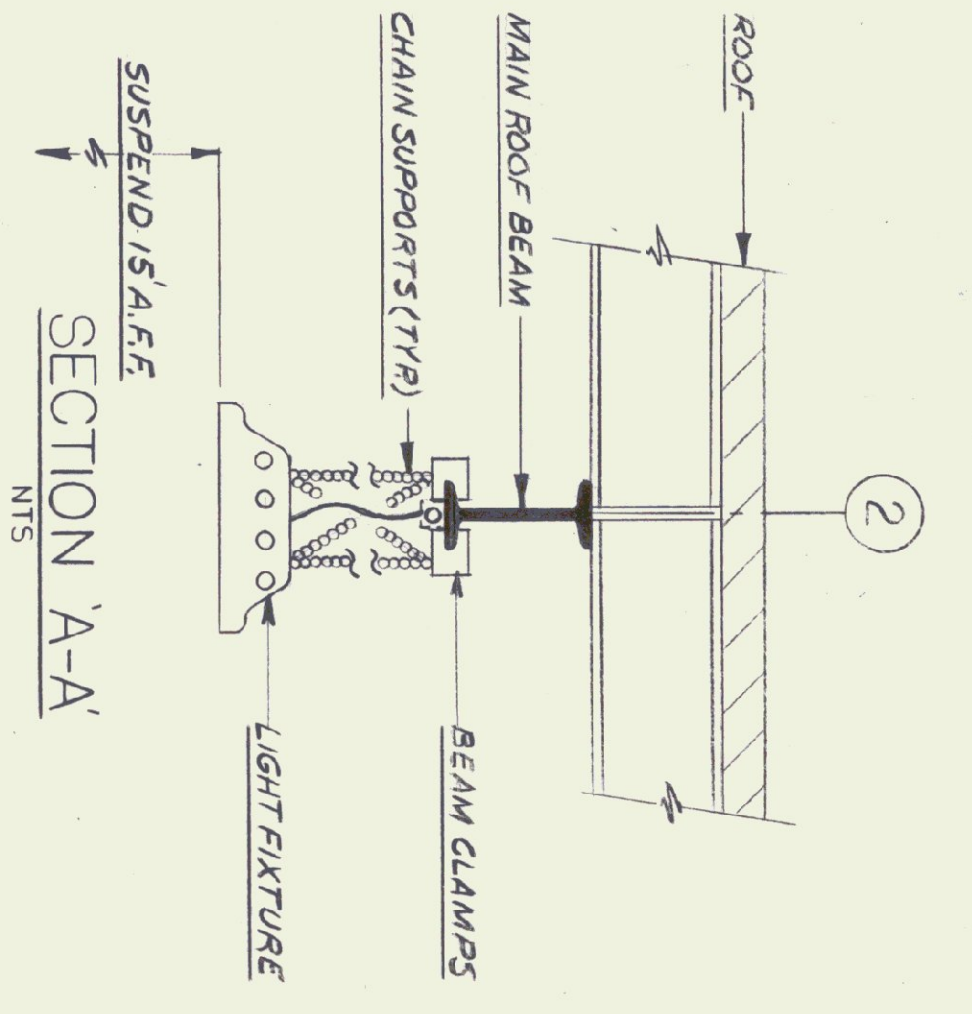


SECTION A-A
NTS

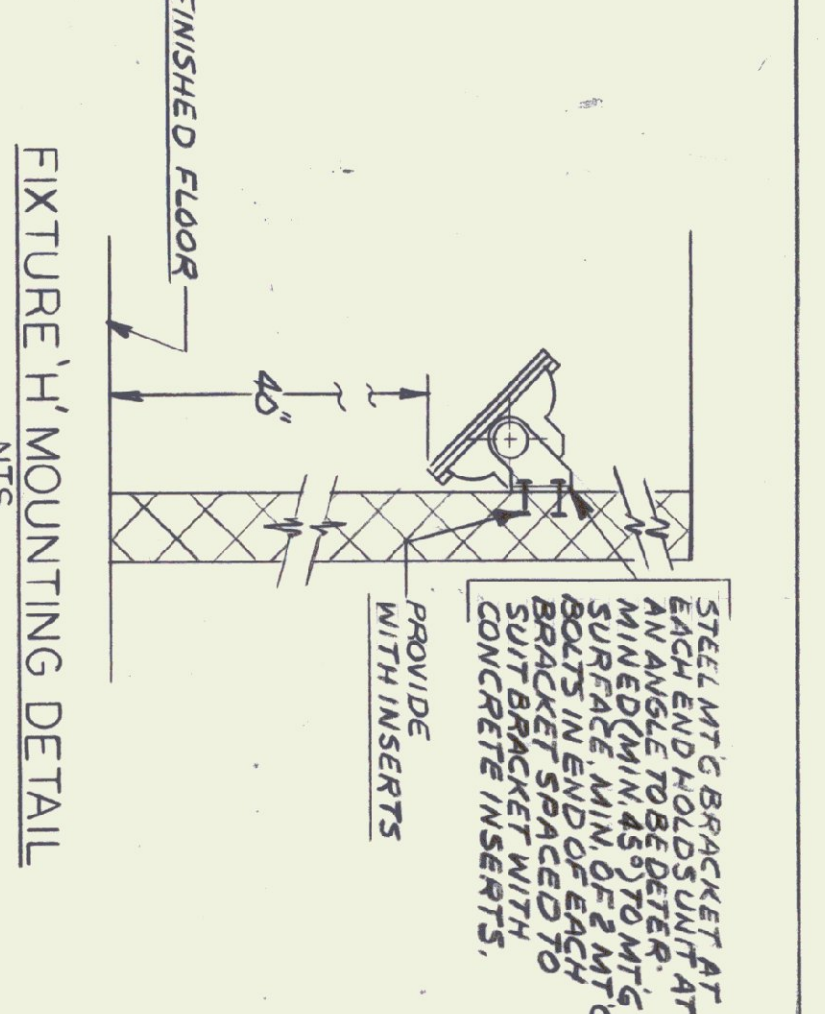

FIXTURE 'H' MOUNTING DETAIL
NTS

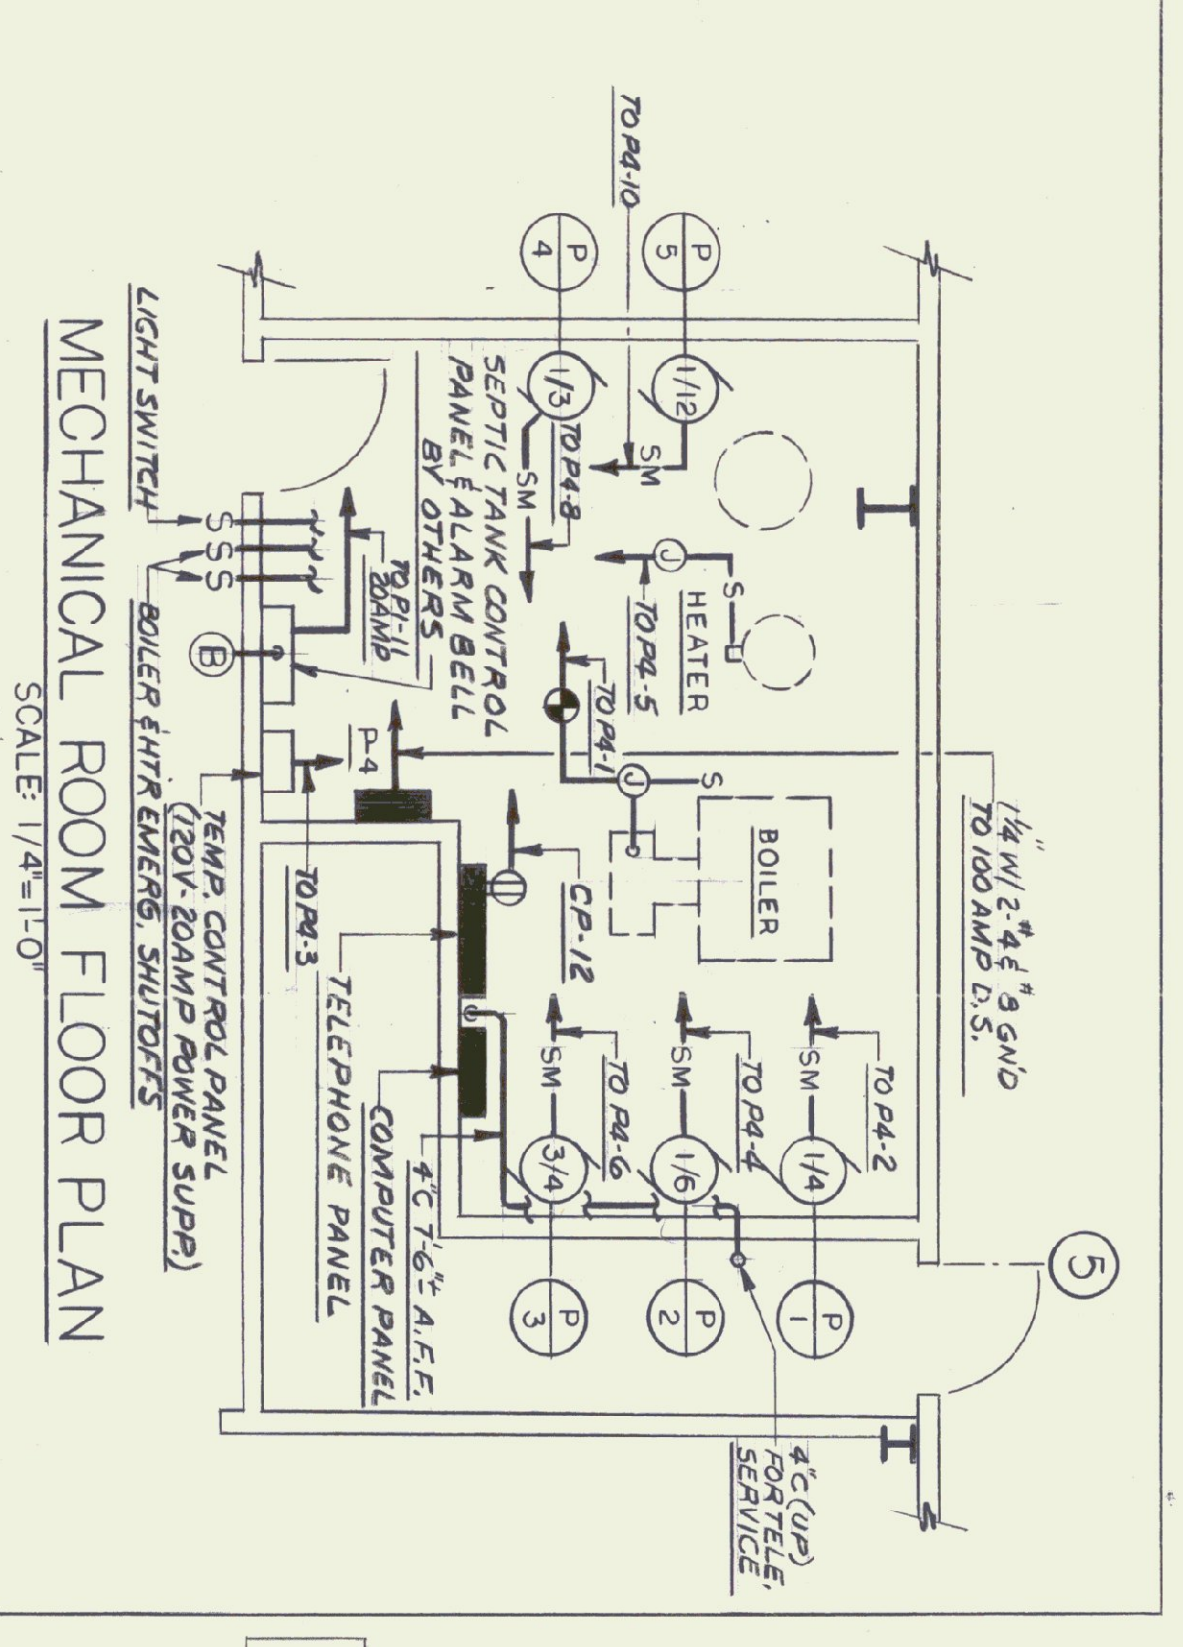


MECHANICAL ROOM FLOOR PLAN
SCALE: 1/4"=1'-0"

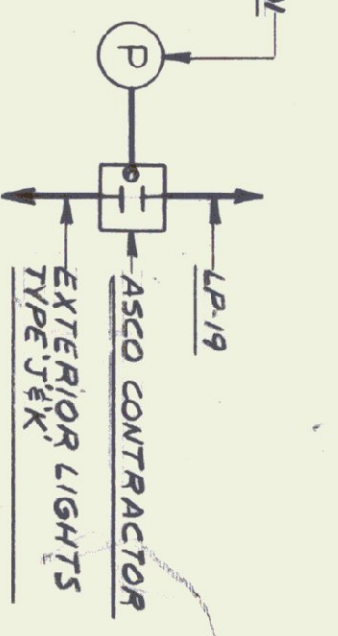


PHOTOCELL CONTROL ONE LINE
NTS

NOTE:
LOCATION OF PHOTOCELL SHALL BE COORDINATED WITH ARCH. & SHOULD BE LOCATED ON THE EAST SIDE OF BLDG.

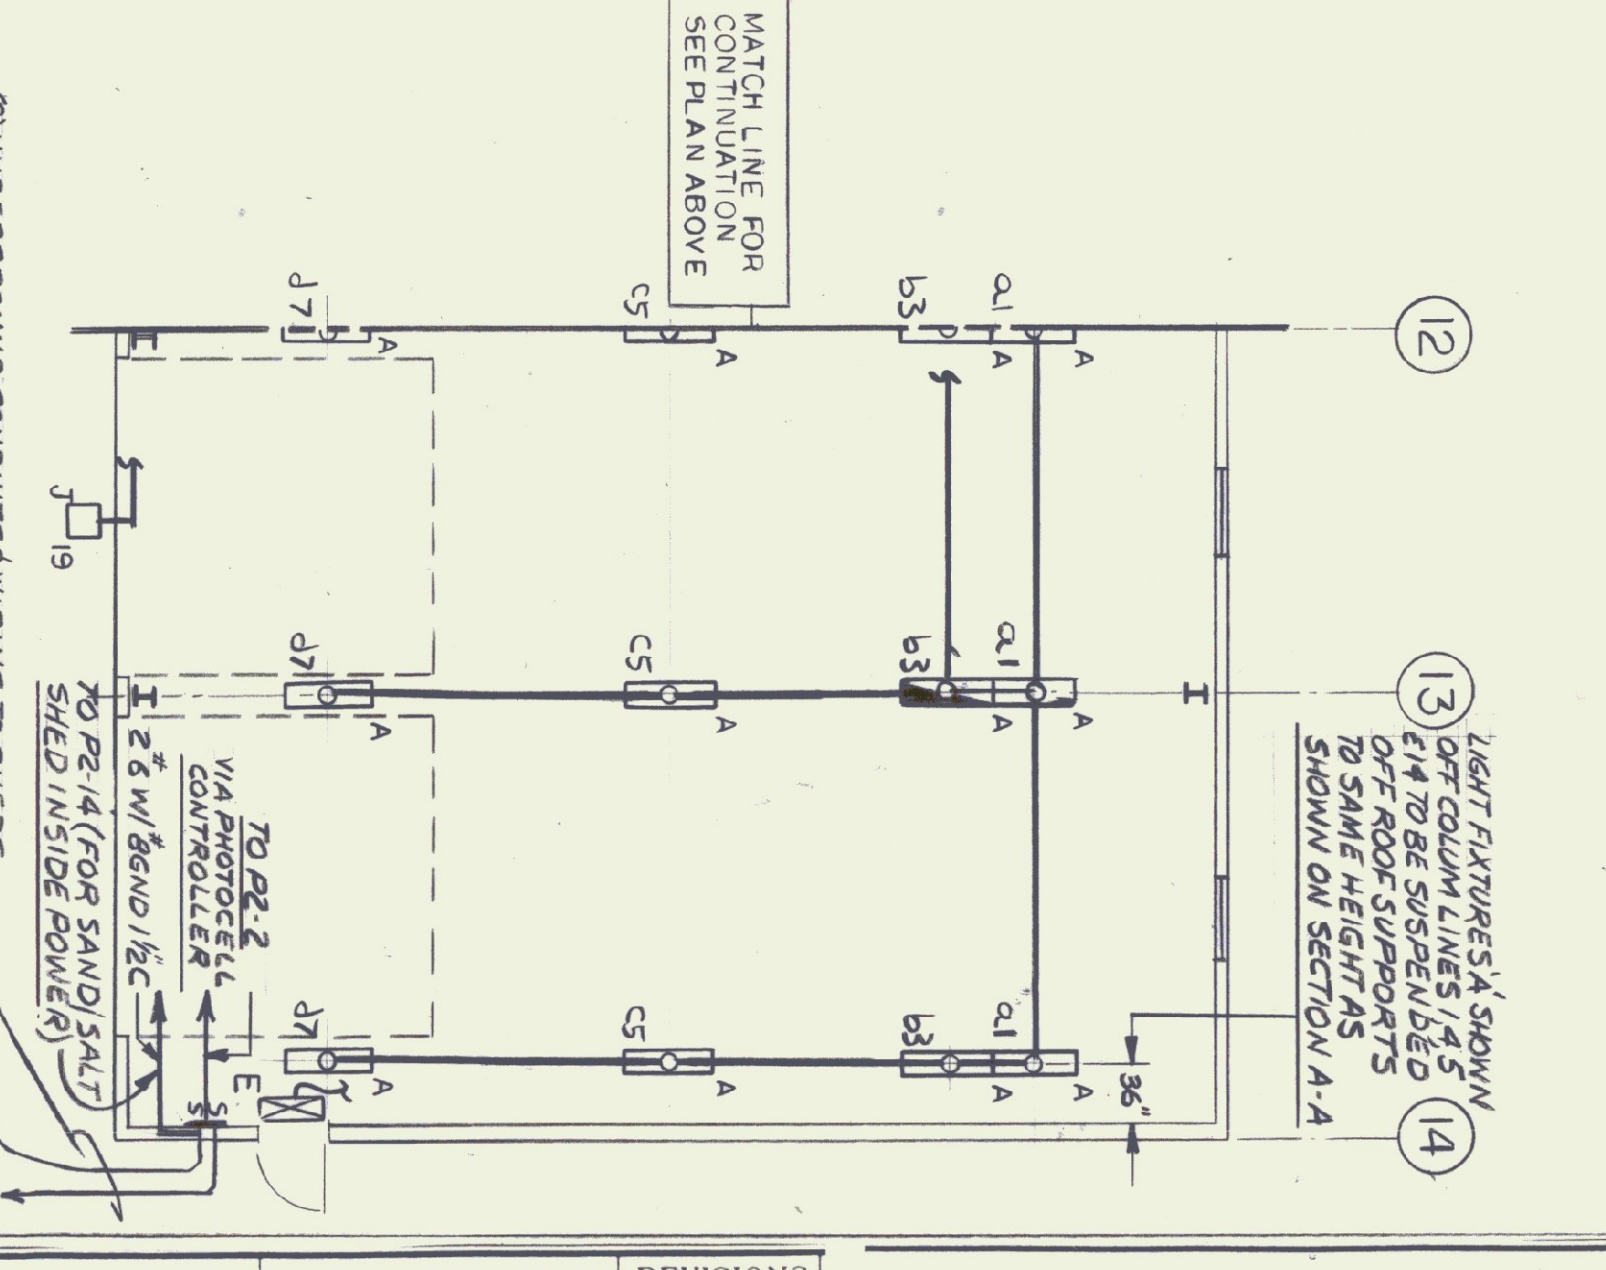

13 LIGHT FIXTURES & SHOWN OFF COLUMN LINES 1/4"=1'-0" TO BE SUSPENDED OFF ROOF SUPPORTS TO SAME HEIGHT AS SHOWN ON SECTION A-A

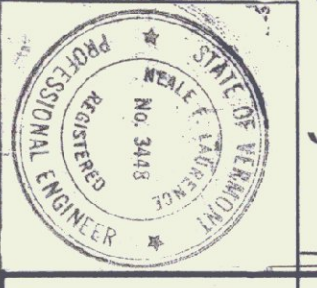

REVISIONS	DATE	BY	APPR.
1	10/15/66	DG	NFL
2	10/21/66	DG	NFL

SCALE: AS NOTED
DATE: 10/15/66
DRAWN BY: DG
APPR BY: NFL

AGENCY OF TRANSPORTATION
COLCHESTER MAINTENANCE FACILITY
CHIMNEY CORNERS
COLCHESTER, VERMONT

STATE OF VERMONT
DEPARTMENT OF BUILDINGS
AND GENERAL SERVICES
AGENCY OF ADMINISTRATION
MONTPELIER, VERMONT

DORE AND WHITTIER INC.
ARCHITECTS • PROJECT MANAGERS
206 WILKINSON ROAD, SOUTH BURLINGTON, VERMONT
N.F. LAURENCE and ASSOC. INC.
113 WEST MAIN STREET NORTHBOROUGH MA.