
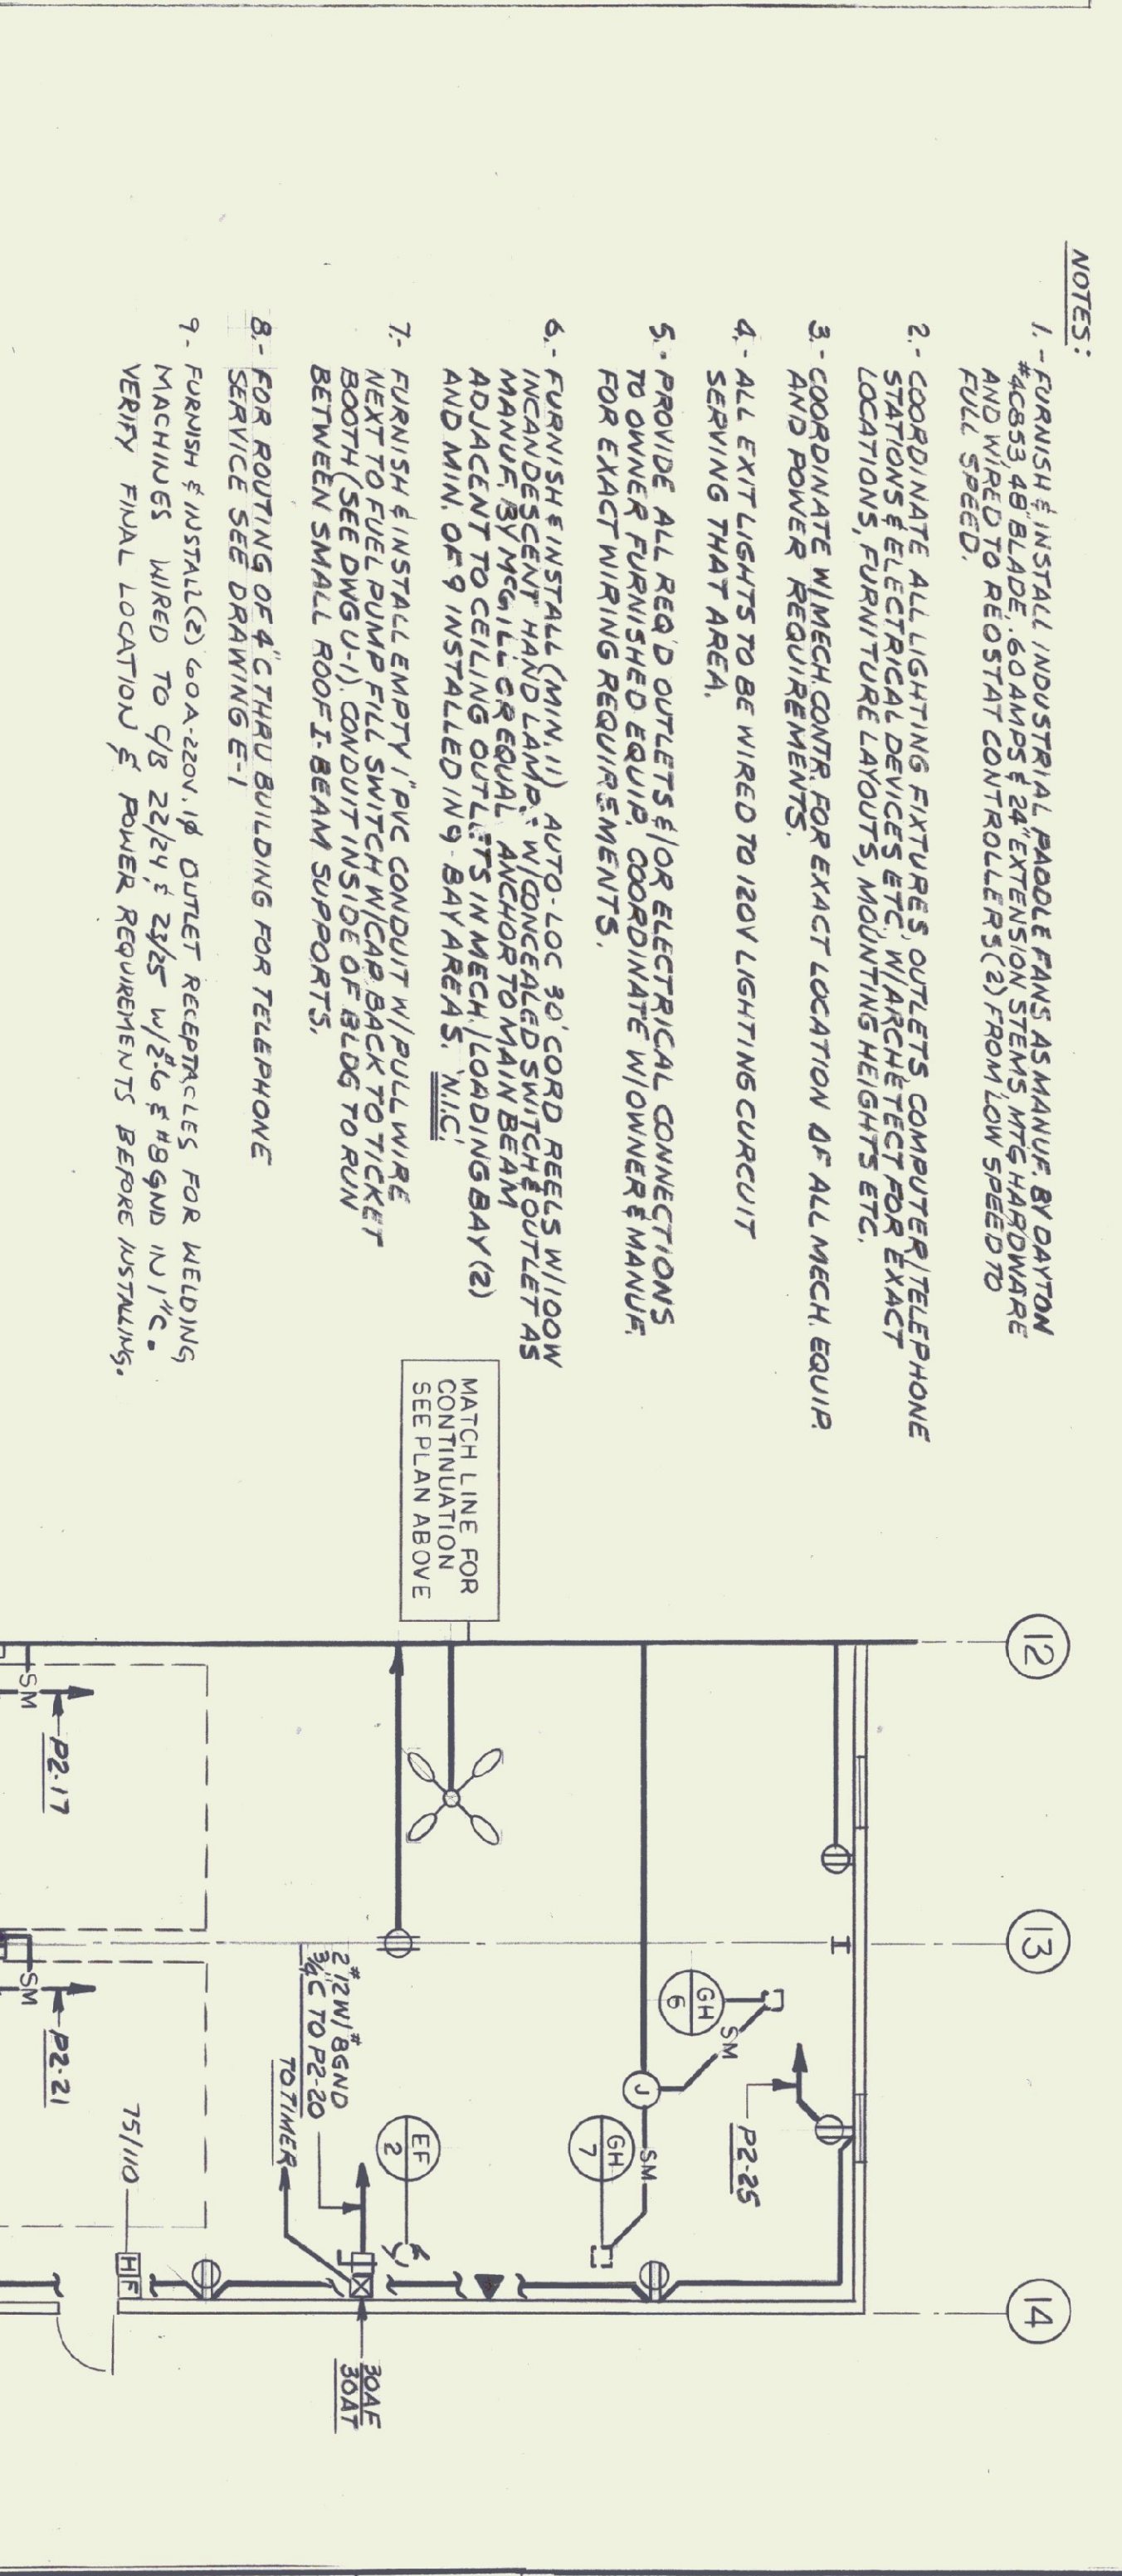


ELECTRICAL-MAIN LEVEL PLAN
SCALE: 1/8"=1'-0"

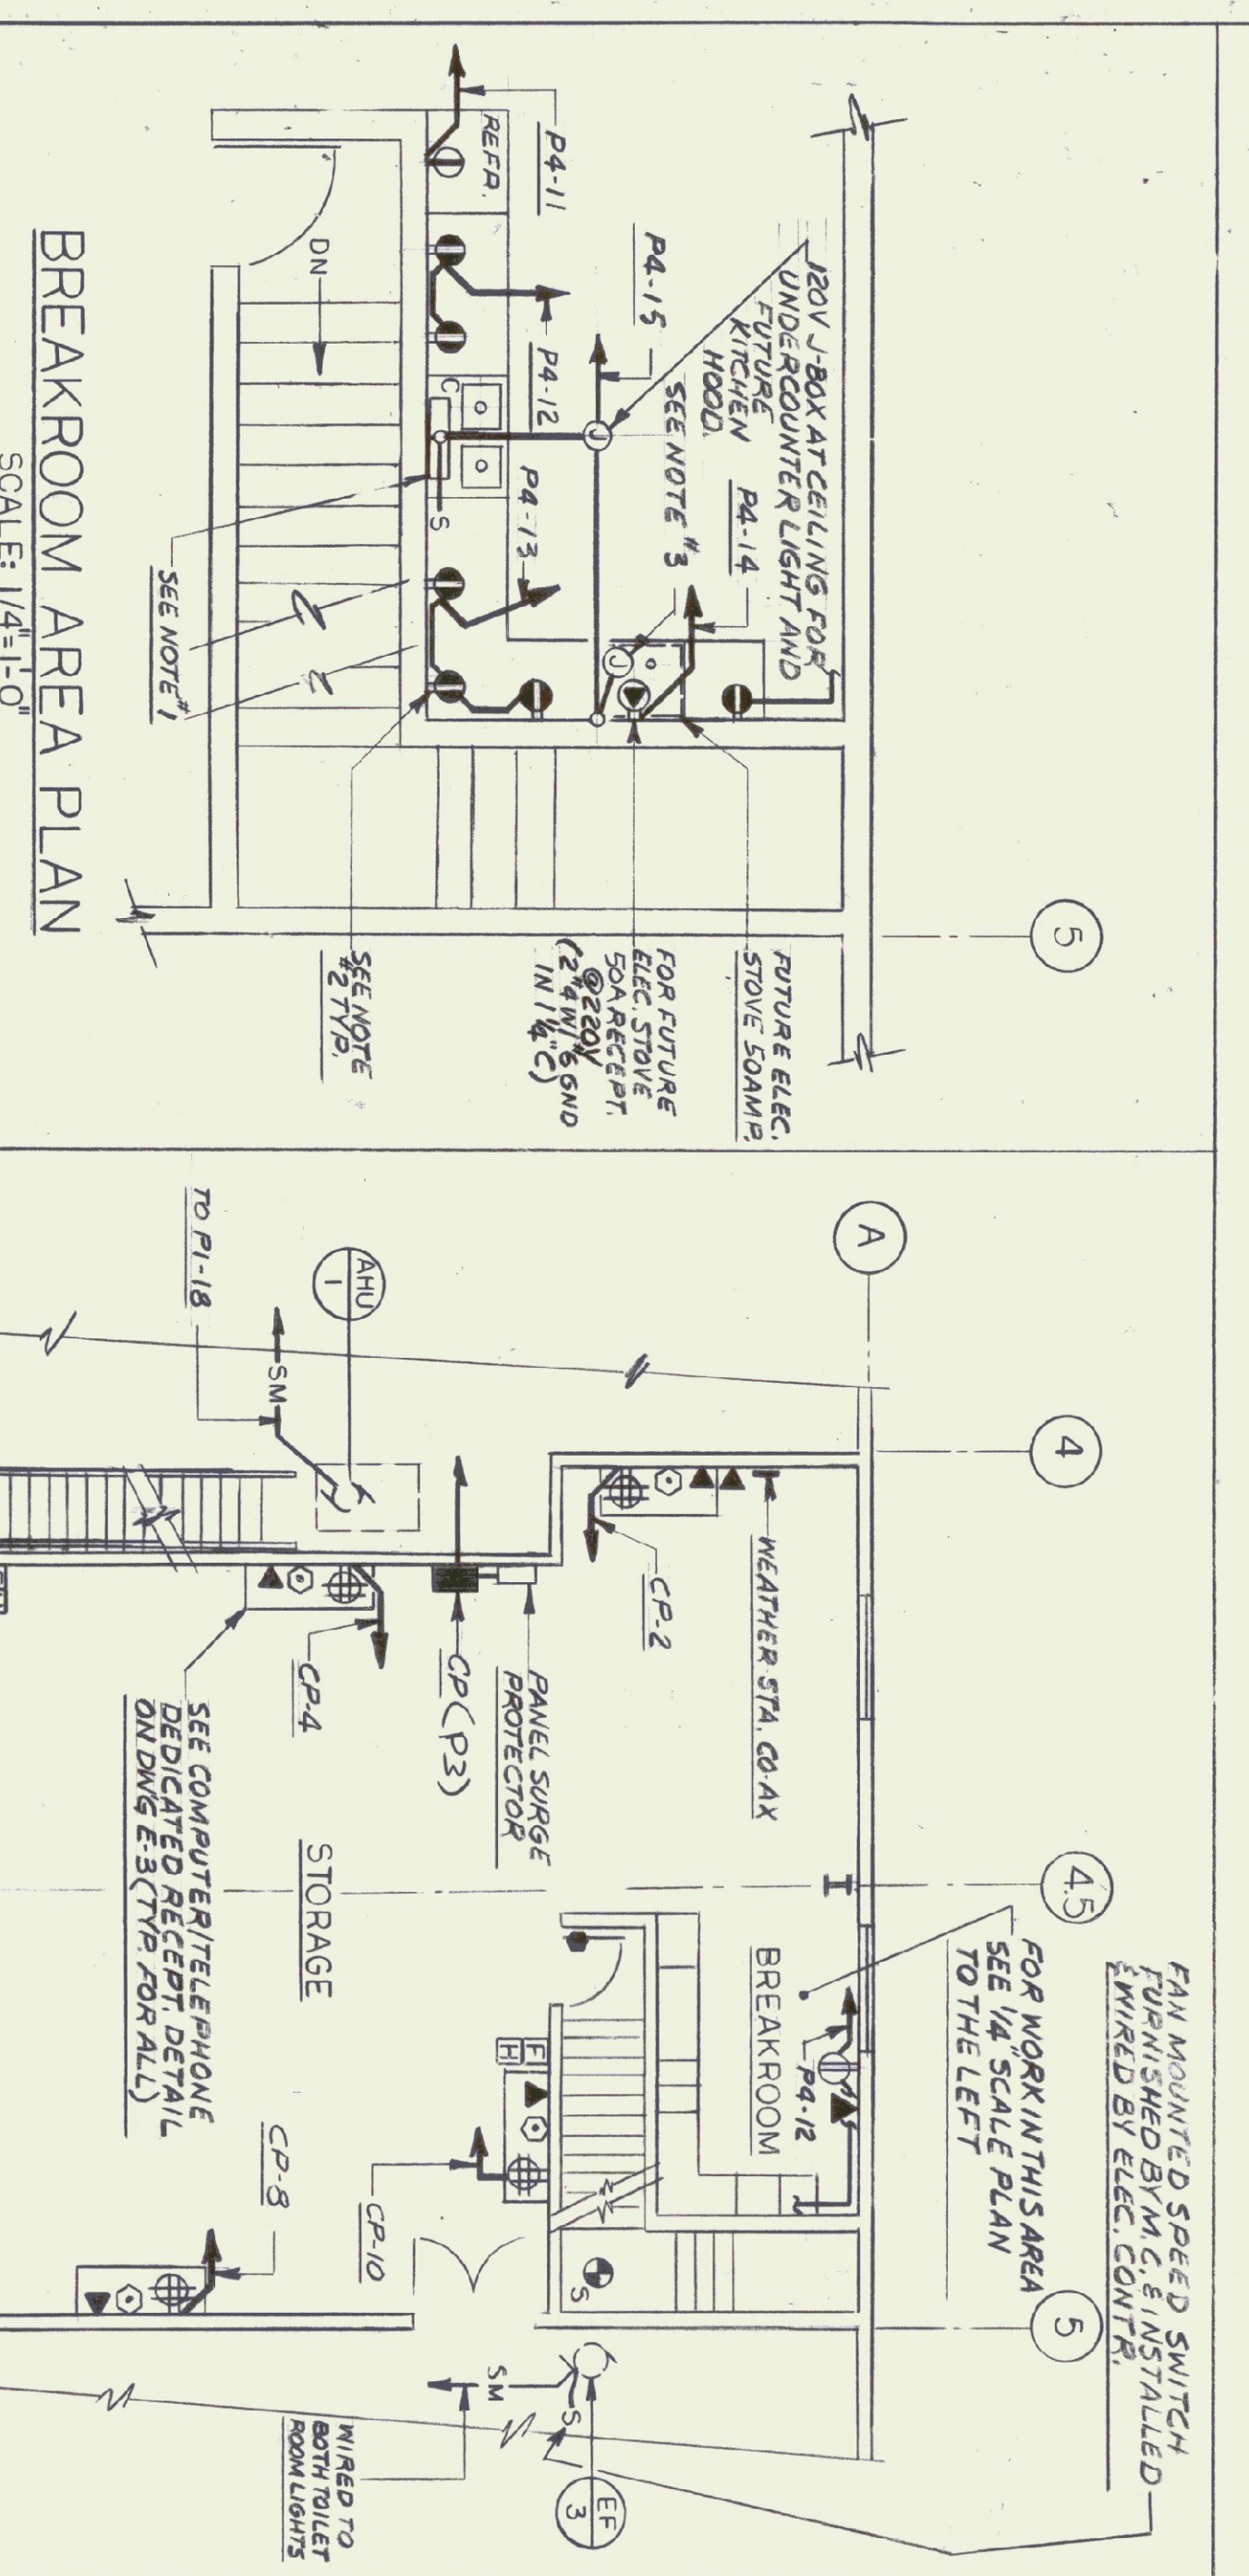

ELECTRICAL-PARTIAL MAIN LEVEL PLAN
SCALE: 1/8"=1'-0"

BREAKROOM AREA PLAN
SCALE: 1/4"=1'-0"

NOTES:
1. - INSTALL LIGHT UNDER OVERHEAD COUNTER WITH WALL SWITCH.
2. - ALL G.F.I. RECEPTS MOUNTED ABOVE COUNTER & NO GREATER THAN 24" ON CENTER ALONG ALL COUNTER TOPS.
3. - FURNISH & INSTALL 1'Ø PVC CONDUIT W/ PULL WIRE NEXT TO FUEL PUMP FILL SWITCH W/ CAB BACK TO TICKET BOOTH (SEE DWG U-1) CONDUIT INSIDE OF BEAM TO RUN BETWEEN SMALL ROOF-I-BEAM SUPPORTS.

SECOND FLOOR PLAN
SCALE: 1/8"=1'-0"

NOTES:
1. - FURNISH & INSTALL 1'Ø PVC CONDUIT W/ PULL WIRE NEXT TO FUEL PUMP FILL SWITCH W/ CAB BACK TO TICKET BOOTH (SEE DWG U-1) CONDUIT INSIDE OF BEAM TO RUN BETWEEN SMALL ROOF-I-BEAM SUPPORTS.
2. - COORDINATE ALL LIGHTING FIXTURES, OUTLETS, COMPUTER/TELEPHONE STATIONS & ELECTRICAL DEVICES ETC. MARCH HEIGHTS FOR EXACT LOCATIONS, FURNITURE LAYOUTS, MOUNTING HEIGHTS ETC.
3. - COORDINATE W/MECH CONTR FOR EXACT LOCATION OF ALL MECH EQUIP AND POWER REQUIREMENTS.
4. - ALL EXIT LIGHTS TO BE WIRED TO 1ØV LIGHTING CIRCUIT SERVING THAT AREA.
5. - PROVIDE ALL RECD OUTLETS & FOR ELECTRICAL CONNECTIONS TO OWNER FURNISHED EQUIP. COORDINATE W/OWNER & MANUF FOR EXACT WIRING REQUIREMENTS.
6. - FURNISH & INSTALL (MIN 11) AUTO-LOC 90' CORD REELS W/ 1ØV INCANDESCENT HAND LAMP. W/ CONCEALED SWITCH & OUTLET AS MANUF. BY M.G. ILL OR EQUAL ANCHOR TO MAIN BEAM ADJACENT TO CEILING OUTLETS IN MECH LOADING BAY (2) AND MIN. OF 9' INSTALLED IN BAY AREAS. W/IC.
7. - FURNISH & INSTALL 1'Ø PVC CONDUIT W/ PULL WIRE NEXT TO FUEL PUMP FILL SWITCH W/ CAB BACK TO TICKET BOOTH (SEE DWG U-1) CONDUIT INSIDE OF BEAM TO RUN BETWEEN SMALL ROOF-I-BEAM SUPPORTS.
8. - FOR ROUTING OF 4' CTRAP BUILDING FOR TELEPHONE SERVICE (SEE DRAWING E-1)
9. - FURNISH & INSTALL (3) 60A-2ØV 1Ø DUTLET RECEPTS FOR WELDING MACHINES WIRED TO C/B 2Ø/1Ø 2ØS W/ 2Ø & Ø 9Ø GND IN 1/2" C. VERIFY FINAL LOCATION & POWER REQUIREMENTS BEFORE INSTALLING.

ELECTRICAL-MAIN LEVEL PLAN
SCALE: 1/8"=1'-0"

	E-2 35 OF 36
	MAINTENANCE GARAGE ELECTRICAL MAIN LEVEL PLAN 2ND FLOOR PLAN BREAKROOM PLAN

SCALE: AS NOTED DATE: 10/15/99 DRAWN BY: KA, DG APPR. BY: NFL	REVISIONS 1. 10/15/99 2. 10/15/99
--	--

AGENCY OF TRANSPORTATION COLCHESTER MAINTENANCE FACILITY CHIMNEY CORNERS COLCHESTER, VERMONT	STATE OF VERMONT DEPARTMENT OF BUILDINGS AND GENERAL SERVICES AGENCY OF ADMINISTRATION MONTPELIER, VERMONT
---	--

DORE AND WHITTIER INC. ARCHITECTS • PROJECT MANAGERS 695 WILLISTON ROAD, SOUTH BURLINGTON, VERMONT	N.F. LAURENCE and ASSOC. INC. 113 WEST MAIN STREET NORTHBOROUGH, MA.
--	---