




1 WALL SECTION
SCALE: 1" = 1'-0"

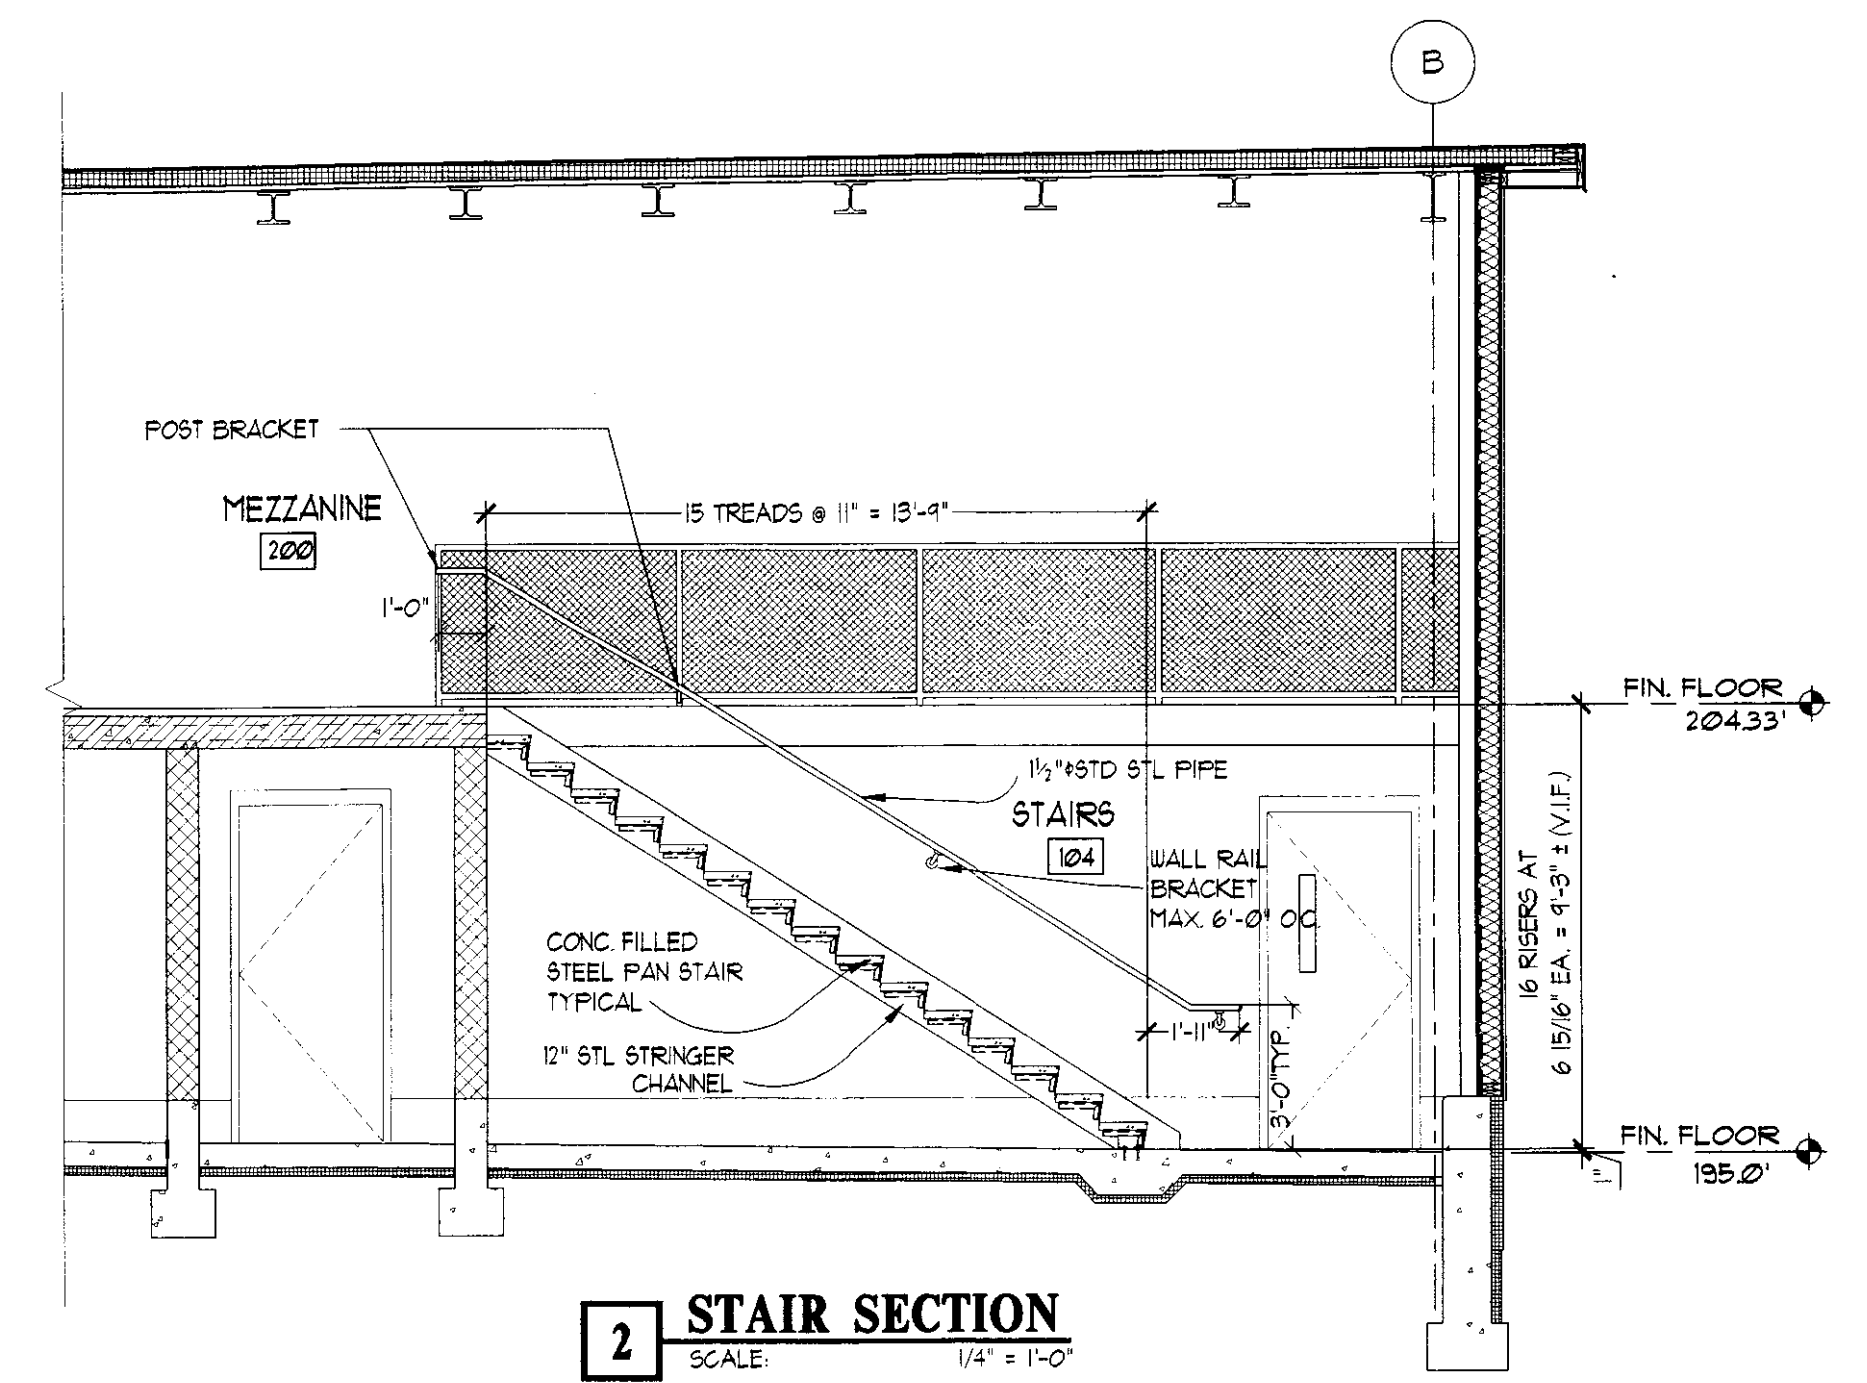


2 STAIR SECTION
SCALE: 1/4" = 1'-0"

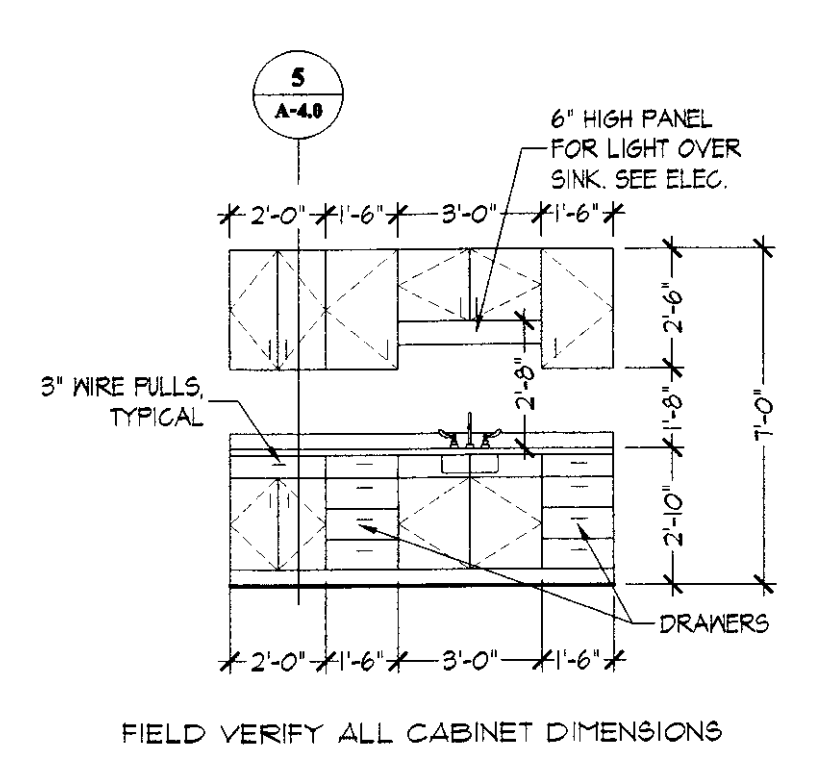


3 CABINET ELEV. @ ROOM 111
SCALE: 1/4" = 1'-0"

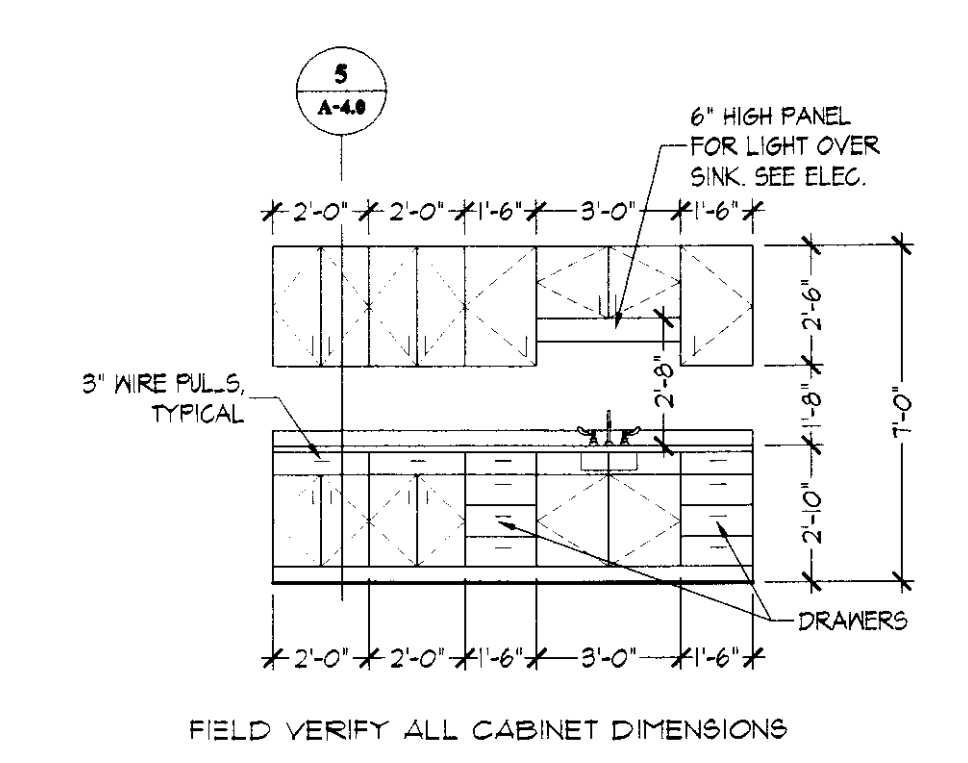


4 CABINET ELEV. @ BREAK ROOM 105
SCALE: 1/4" = 1'-0"

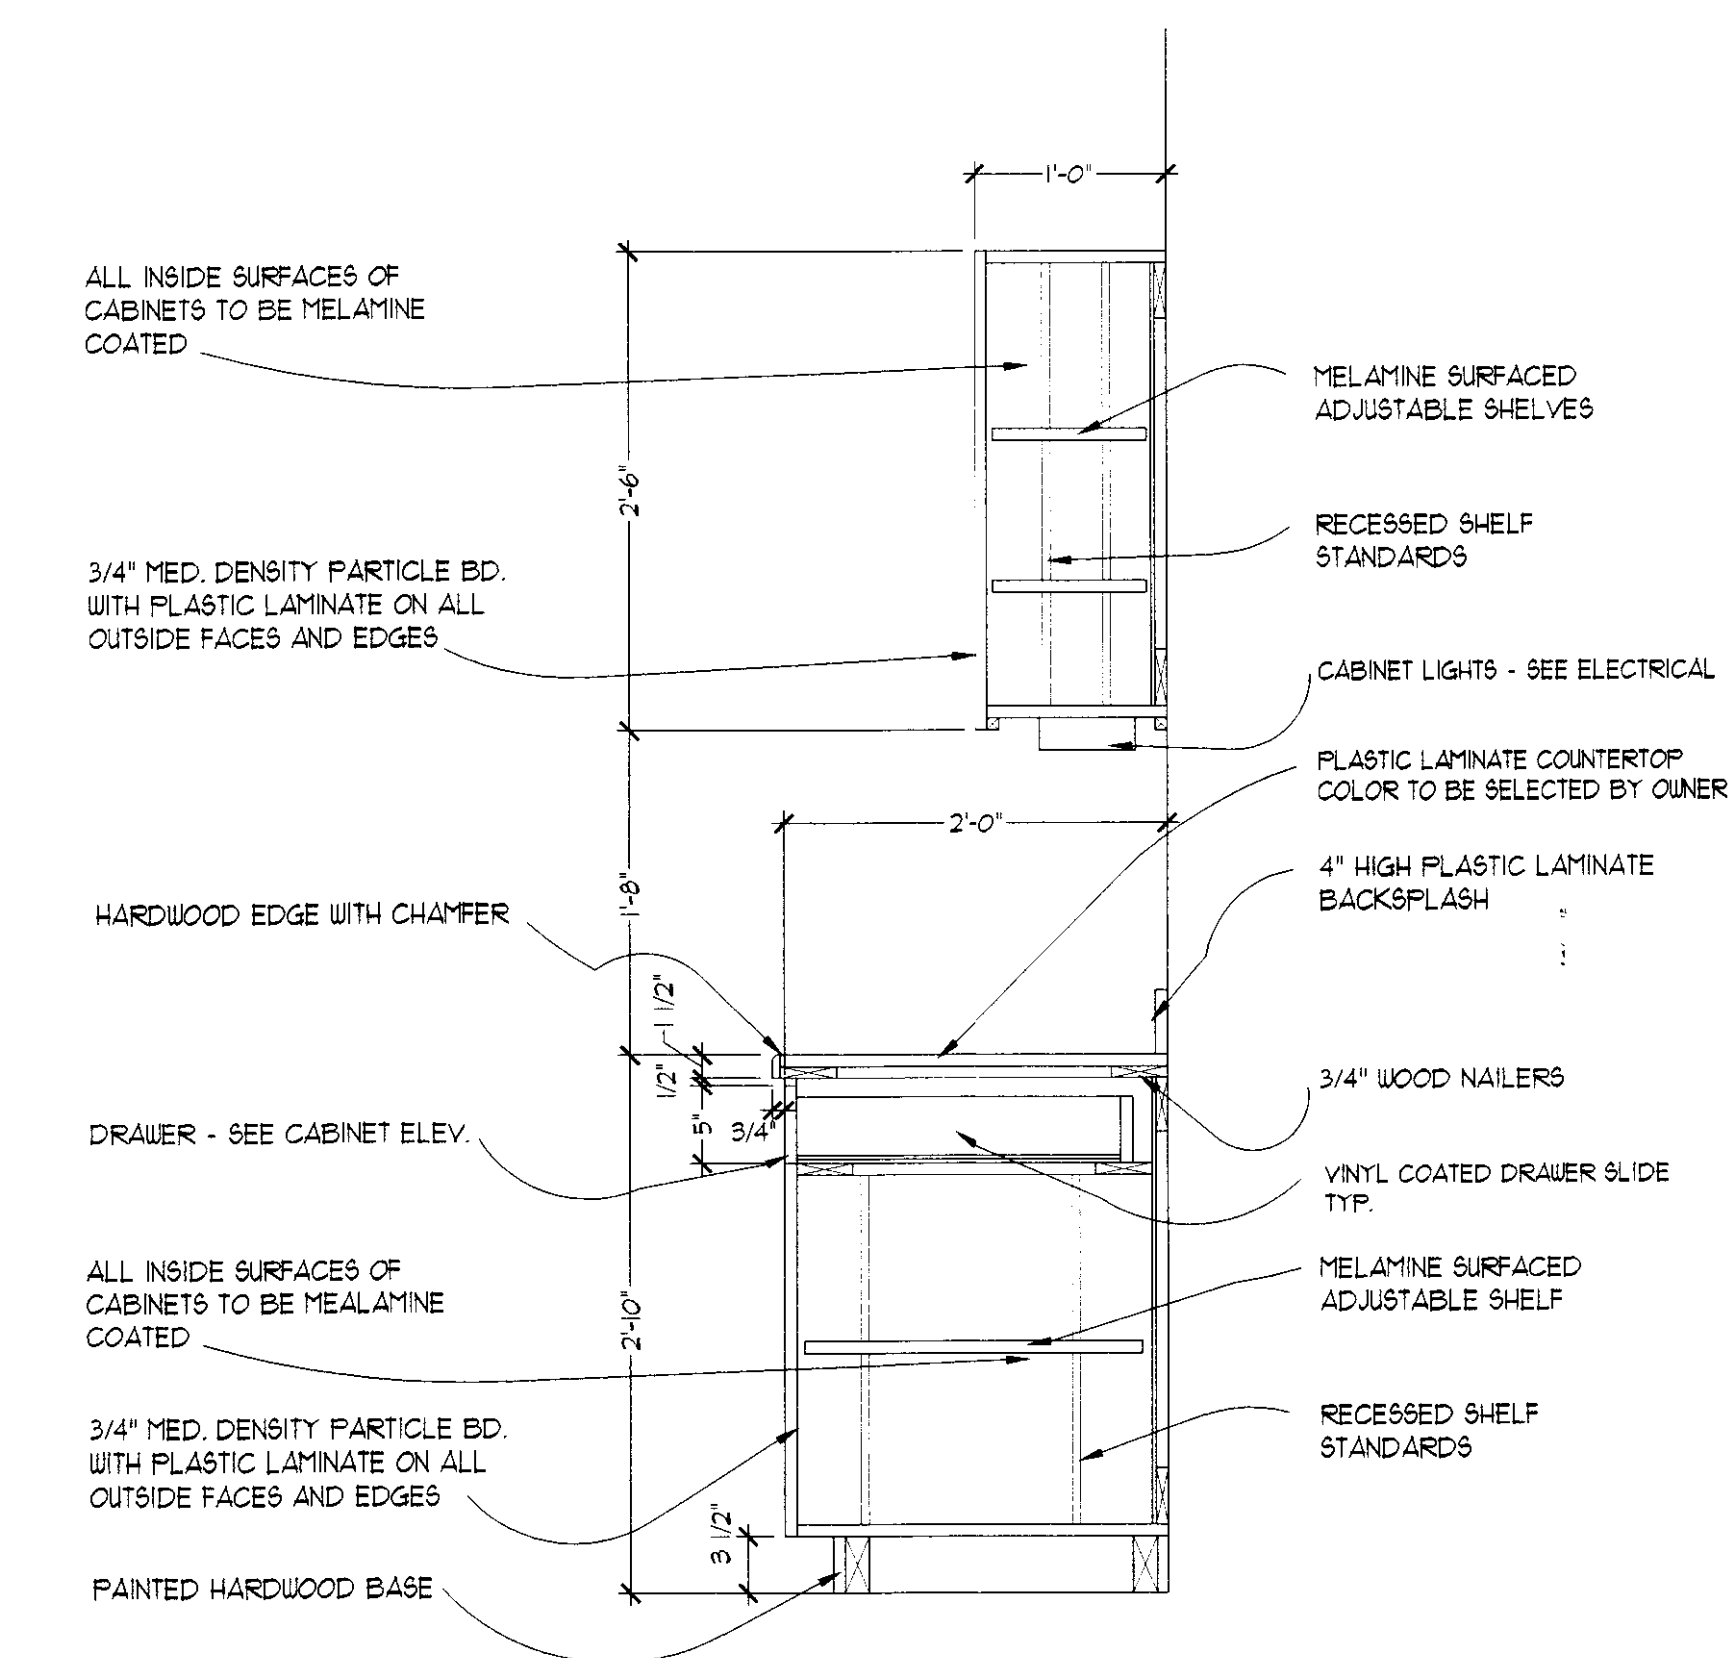

5 TYPICAL CABINET SECTION
SCALE: 1" = 1'-0"

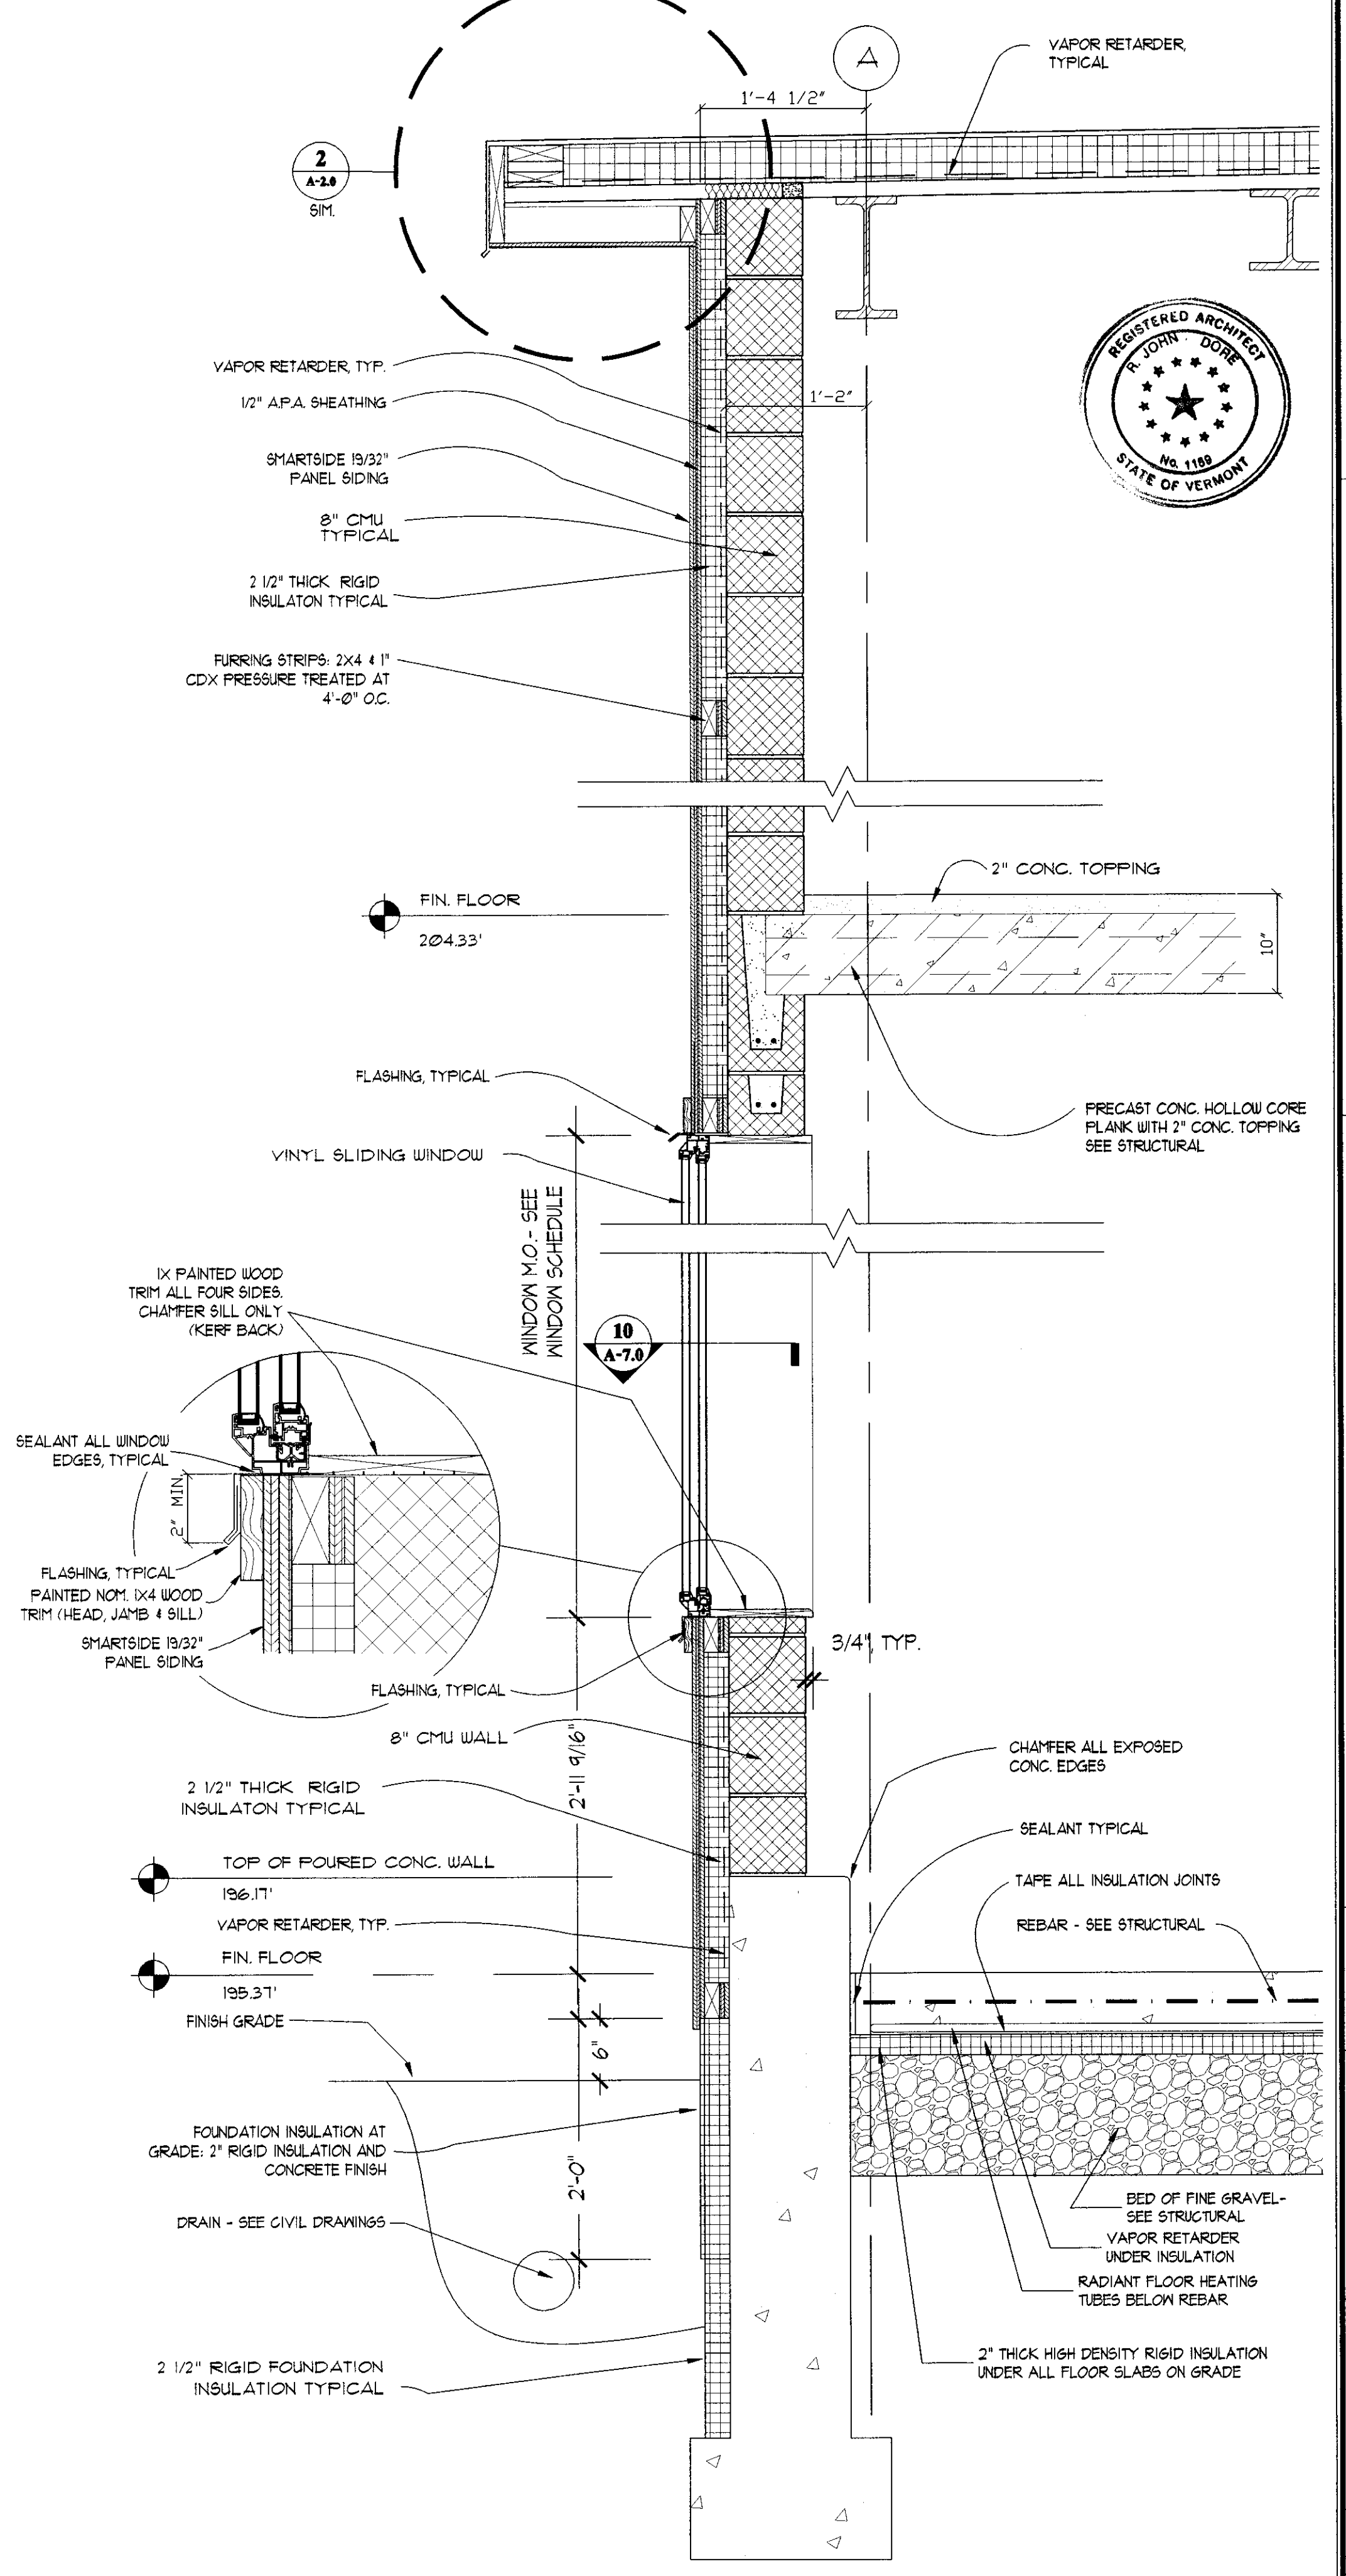

6 WALL SECTION
SCALE: 1" = 1'-0"

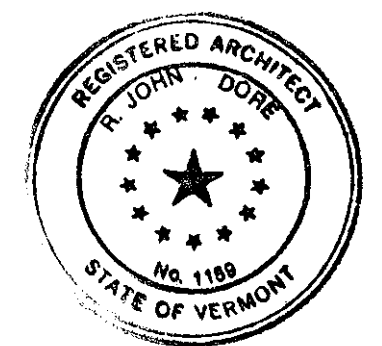

D&W
DORE AND WHITLER, INC.
Architects • Project Managers

STATE OF VERMONT
DEPARTMENT OF TRANSPORTATION
GENERAL SERVICES
AGENCY OF ADMINISTRATION
MONTPELIER, VERMONT

AGENCY OF TRANSPORTATION
N. FERRISBURGH MAINTENANCE FACILITY
NORTH FERRISBURGH VERMONT

REVISIONS	SCALE: AS NOTED	DATE: 1/4/06	DRAWN BY: VFW	APP. BY: APD

MAINTENANCE GARAGE WALL, STAIR & CABINET SECTIONS
A-6.0
27 OF 43

V:\user\proj\proj35\A01 North Ferrisburgh\REVISED A01 12-2-05\Drawings\Sheet Drawings\A424-6.0.dwg, 01/22/2006 09:38:35 AM, abrown