


SECOND FLOOR PLAN - MECH ROOM - PLUMBING
SCALE: 1/4" = 1'-0"

PLUMBING SYMBOLS			
--- (solid line)	COLD WATER	--- (two parallel lines)	UNION
--- (dashed line)	HOT WATER	--- (line with T)	HOSE BIBB
--- (dotted line)	TEMPERED WATER	--- (line with M)	"P" TRAP
--- (long dashed line)	COMPRESSED AIR	--- (line with W)	WATER METER
--- (short dashed line)	WASTE PIPING	--- (line with X)	WYE STRAINER
--- (dash-dot line)	VENT PIPING	--- (line with 3-way symbol)	3 WAY BALL VALVE
--- (line with arrow)	FLOW DIRECTION	--- (line with circle and X)	LINKSEAL BETWEEN PIPE & SLEEVE
--- (line with valve symbol)	GATE OR BALL VALVE	--- (line with circle and X)	THERMOSTATIC MIXING VALVE
--- (line with check symbol)	CHECK VALVE	--- (line with circle and X)	EXPANSION TANK, AMTROL THERM-X-TROL ST-5
--- (line with backflow symbol)	BACK FLOW PREVENTER	--- (line with circle and X)	
--- (line with drain symbol)	DRAIN DOWN TO P-12, CUT END OF PIPE @ 45°	--- (line with circle and X)	
--- (line with pressure symbol)	PRESSURE & TEMP. RELIEF VALVE W/ DRAIN TO P-12, CUT END OF PIPE @ 45°	--- (line with circle and X)	
--- (line with hammer symbol)	WATER HAMMER ARRESTER	--- (line with circle and X)	


NOTE:
IF ANY DEVICES SUCH AS VALVES OR TRAP PRIMERS ARE INSTALLED WITHIN WALLS, PROVIDE ACCESS PANEL TO SERVICE.

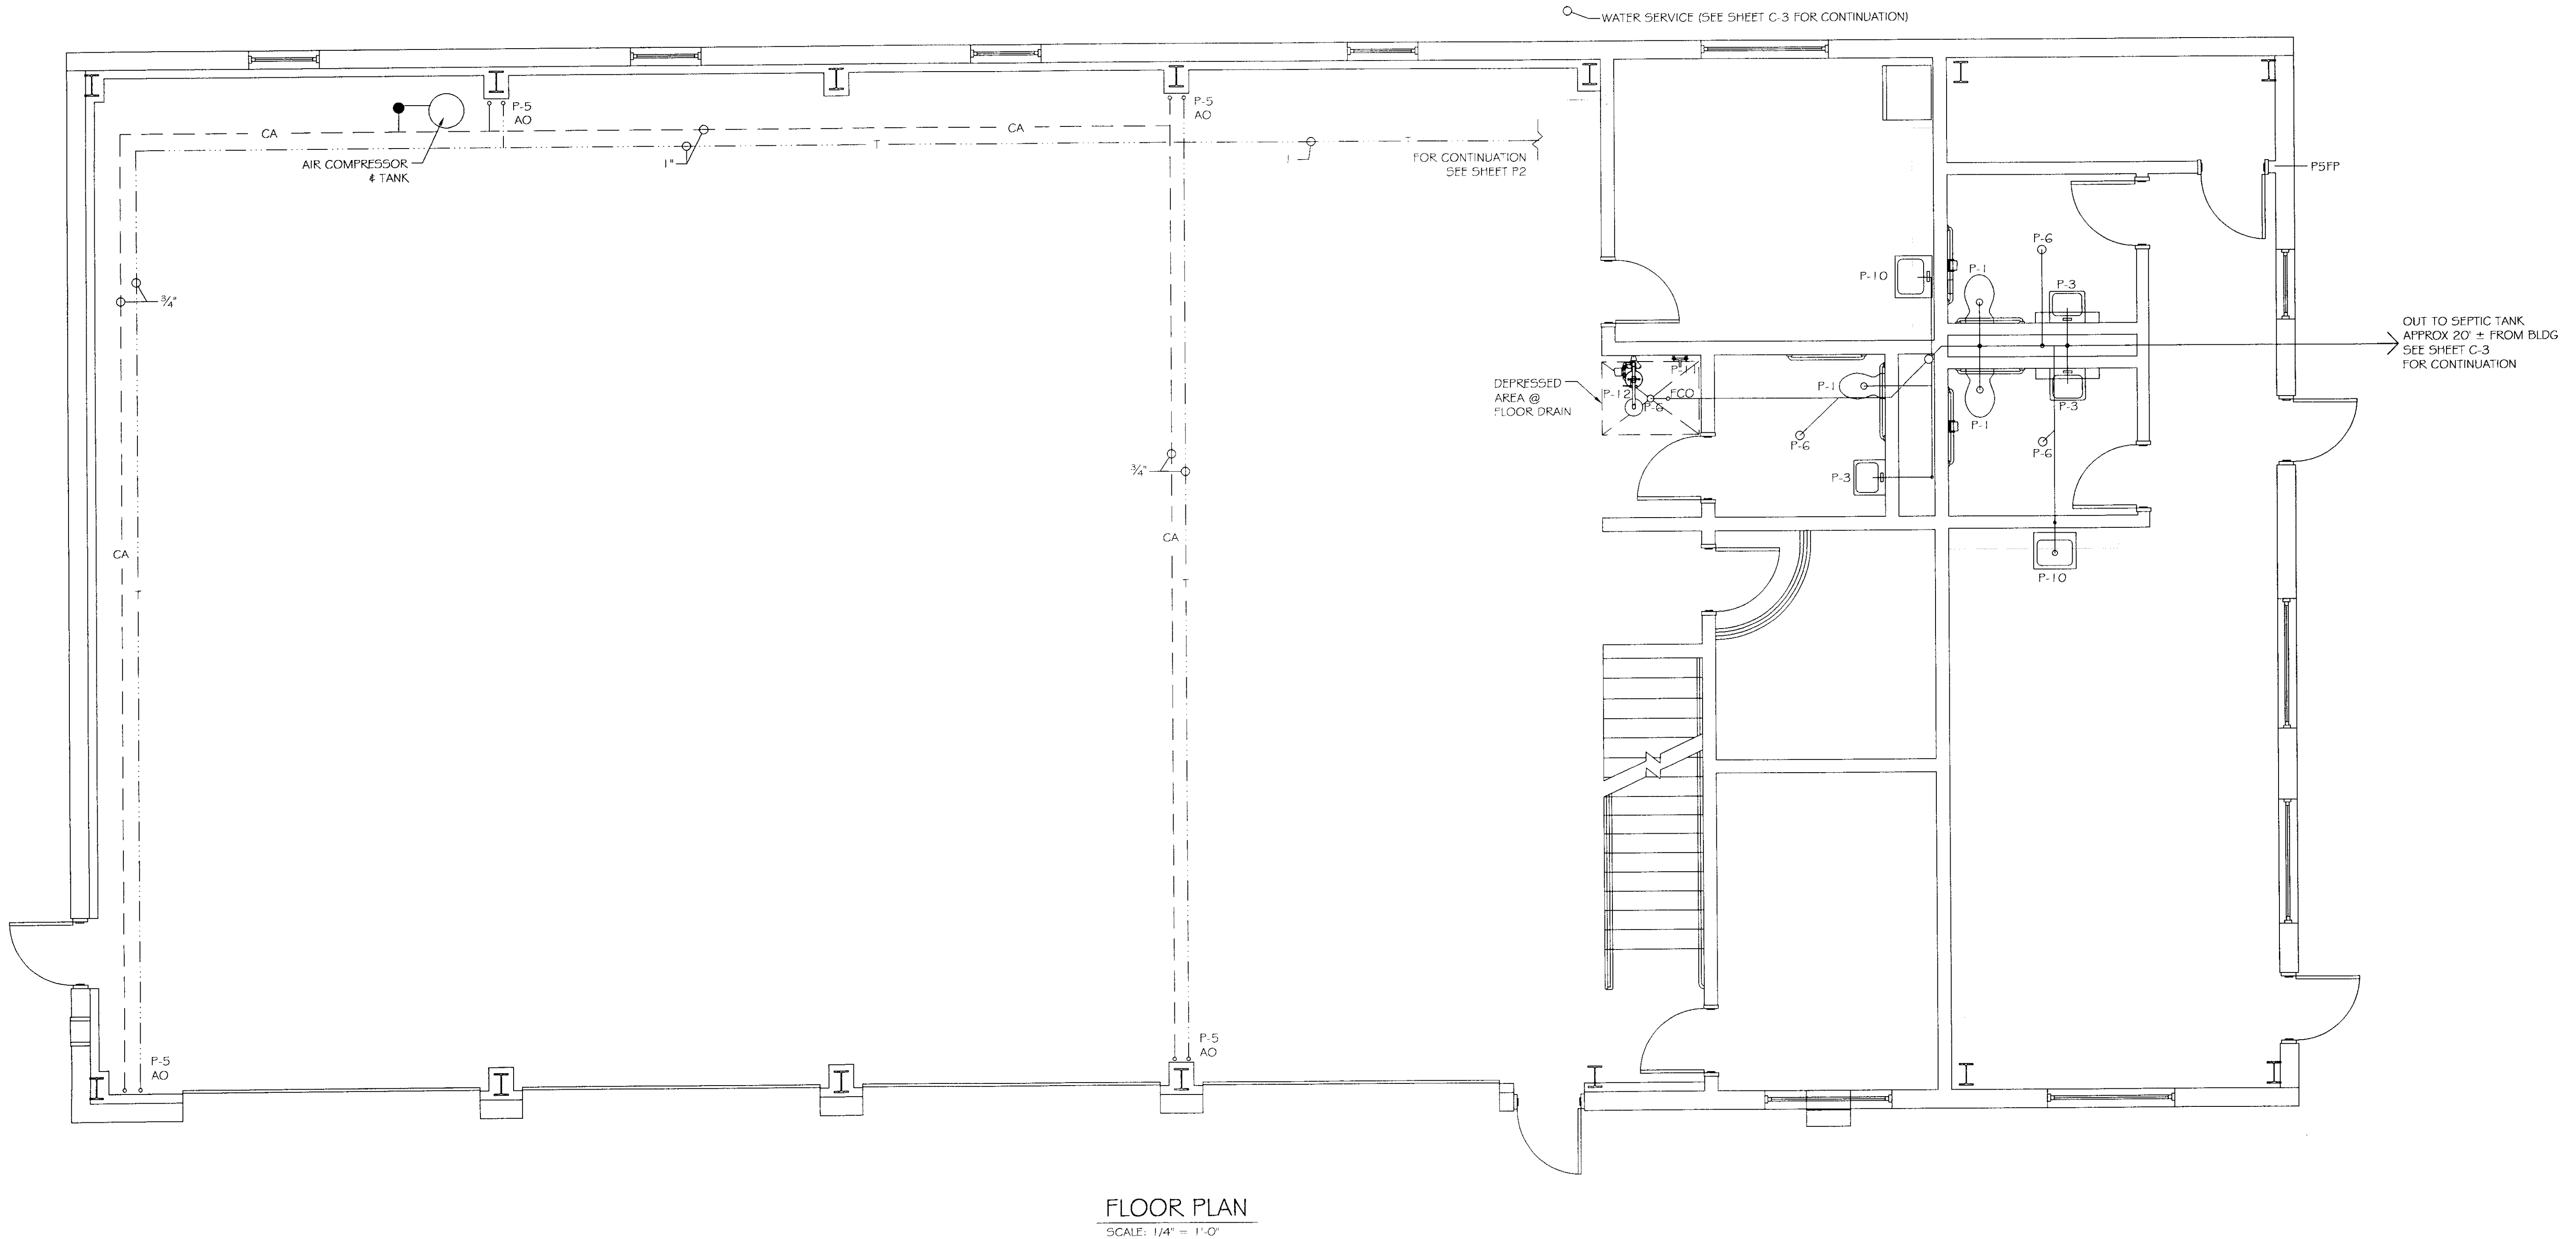

FLOOR PLAN
SCALE: 1/4" = 1'-0"



STATE OF VERMONT
Department of Buildings
and General Services
Agency of Administration
Montpelier, Vermont

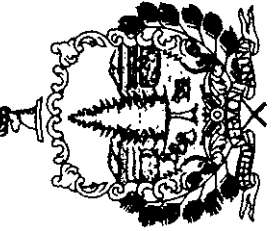

VERMONT
AGENCY OF TRANSPORTATION
NORTH FERRISBURG GARAGE
PLUMBING PLAN

REVISIONS
SCALE: AS NOTED
DATE: JANUARY 4, 2006
DRAWN BY: N. HERSEY
APPR. BY: TEIGH

A.O.T.
NORTH FERRISBURG GARAGE
PLUMBING PLAN