




DEMOLITION - HEATING - BOILER ROOM FLOOR PLAN
SCALE: 1/2" = 1'-0"

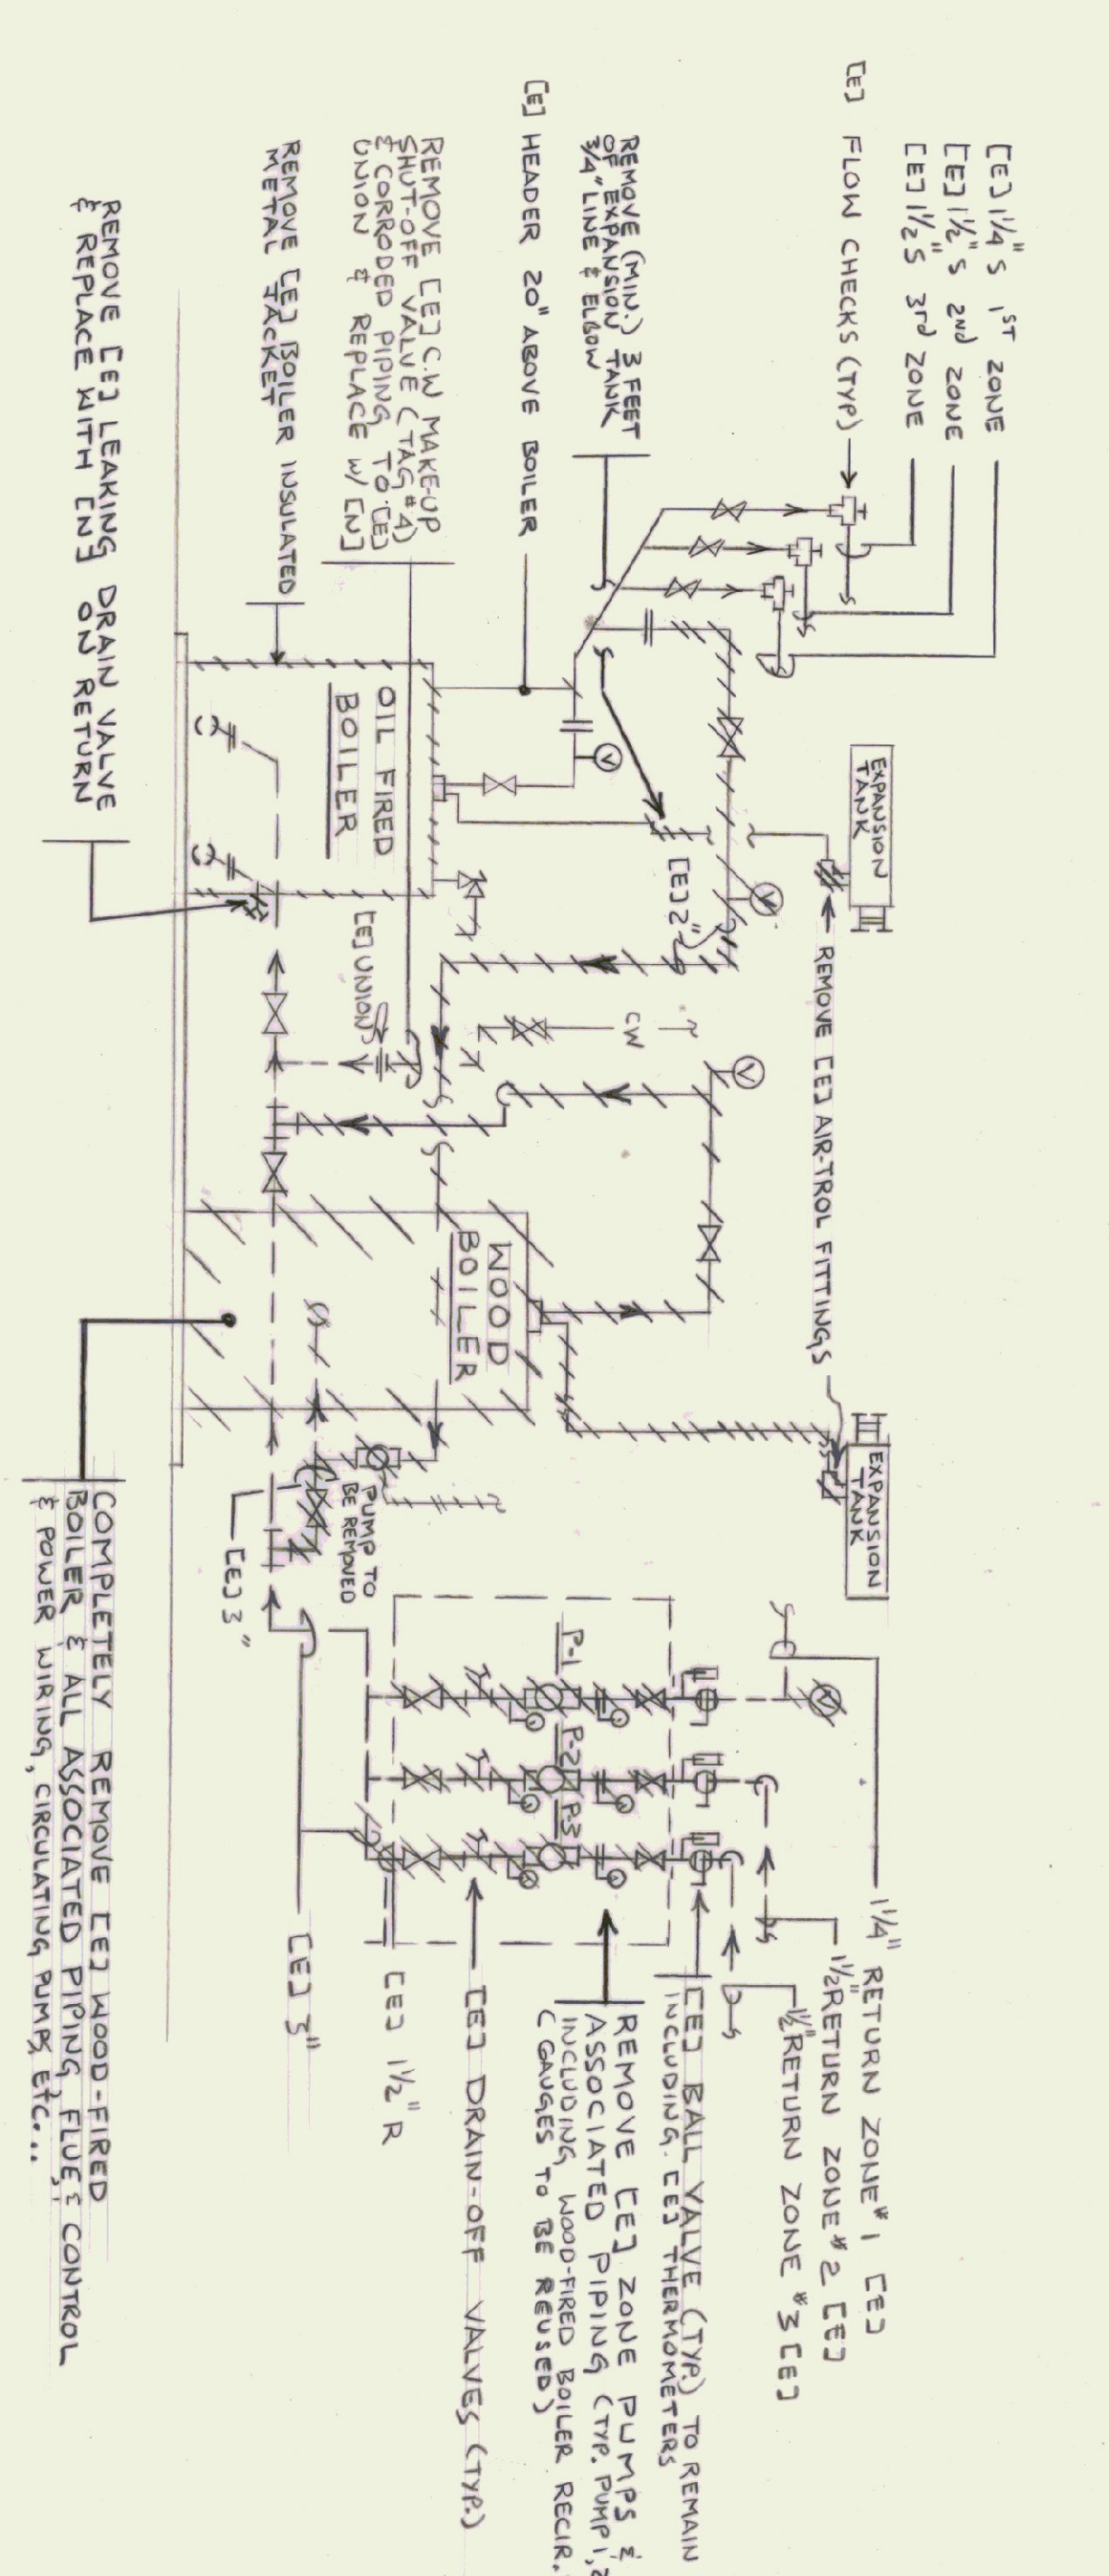


DEMOLITION - EXISTING BOILER FLOW DIAGRAM (VERIFY SIZES IN FIELD)
NOT TO SCALE

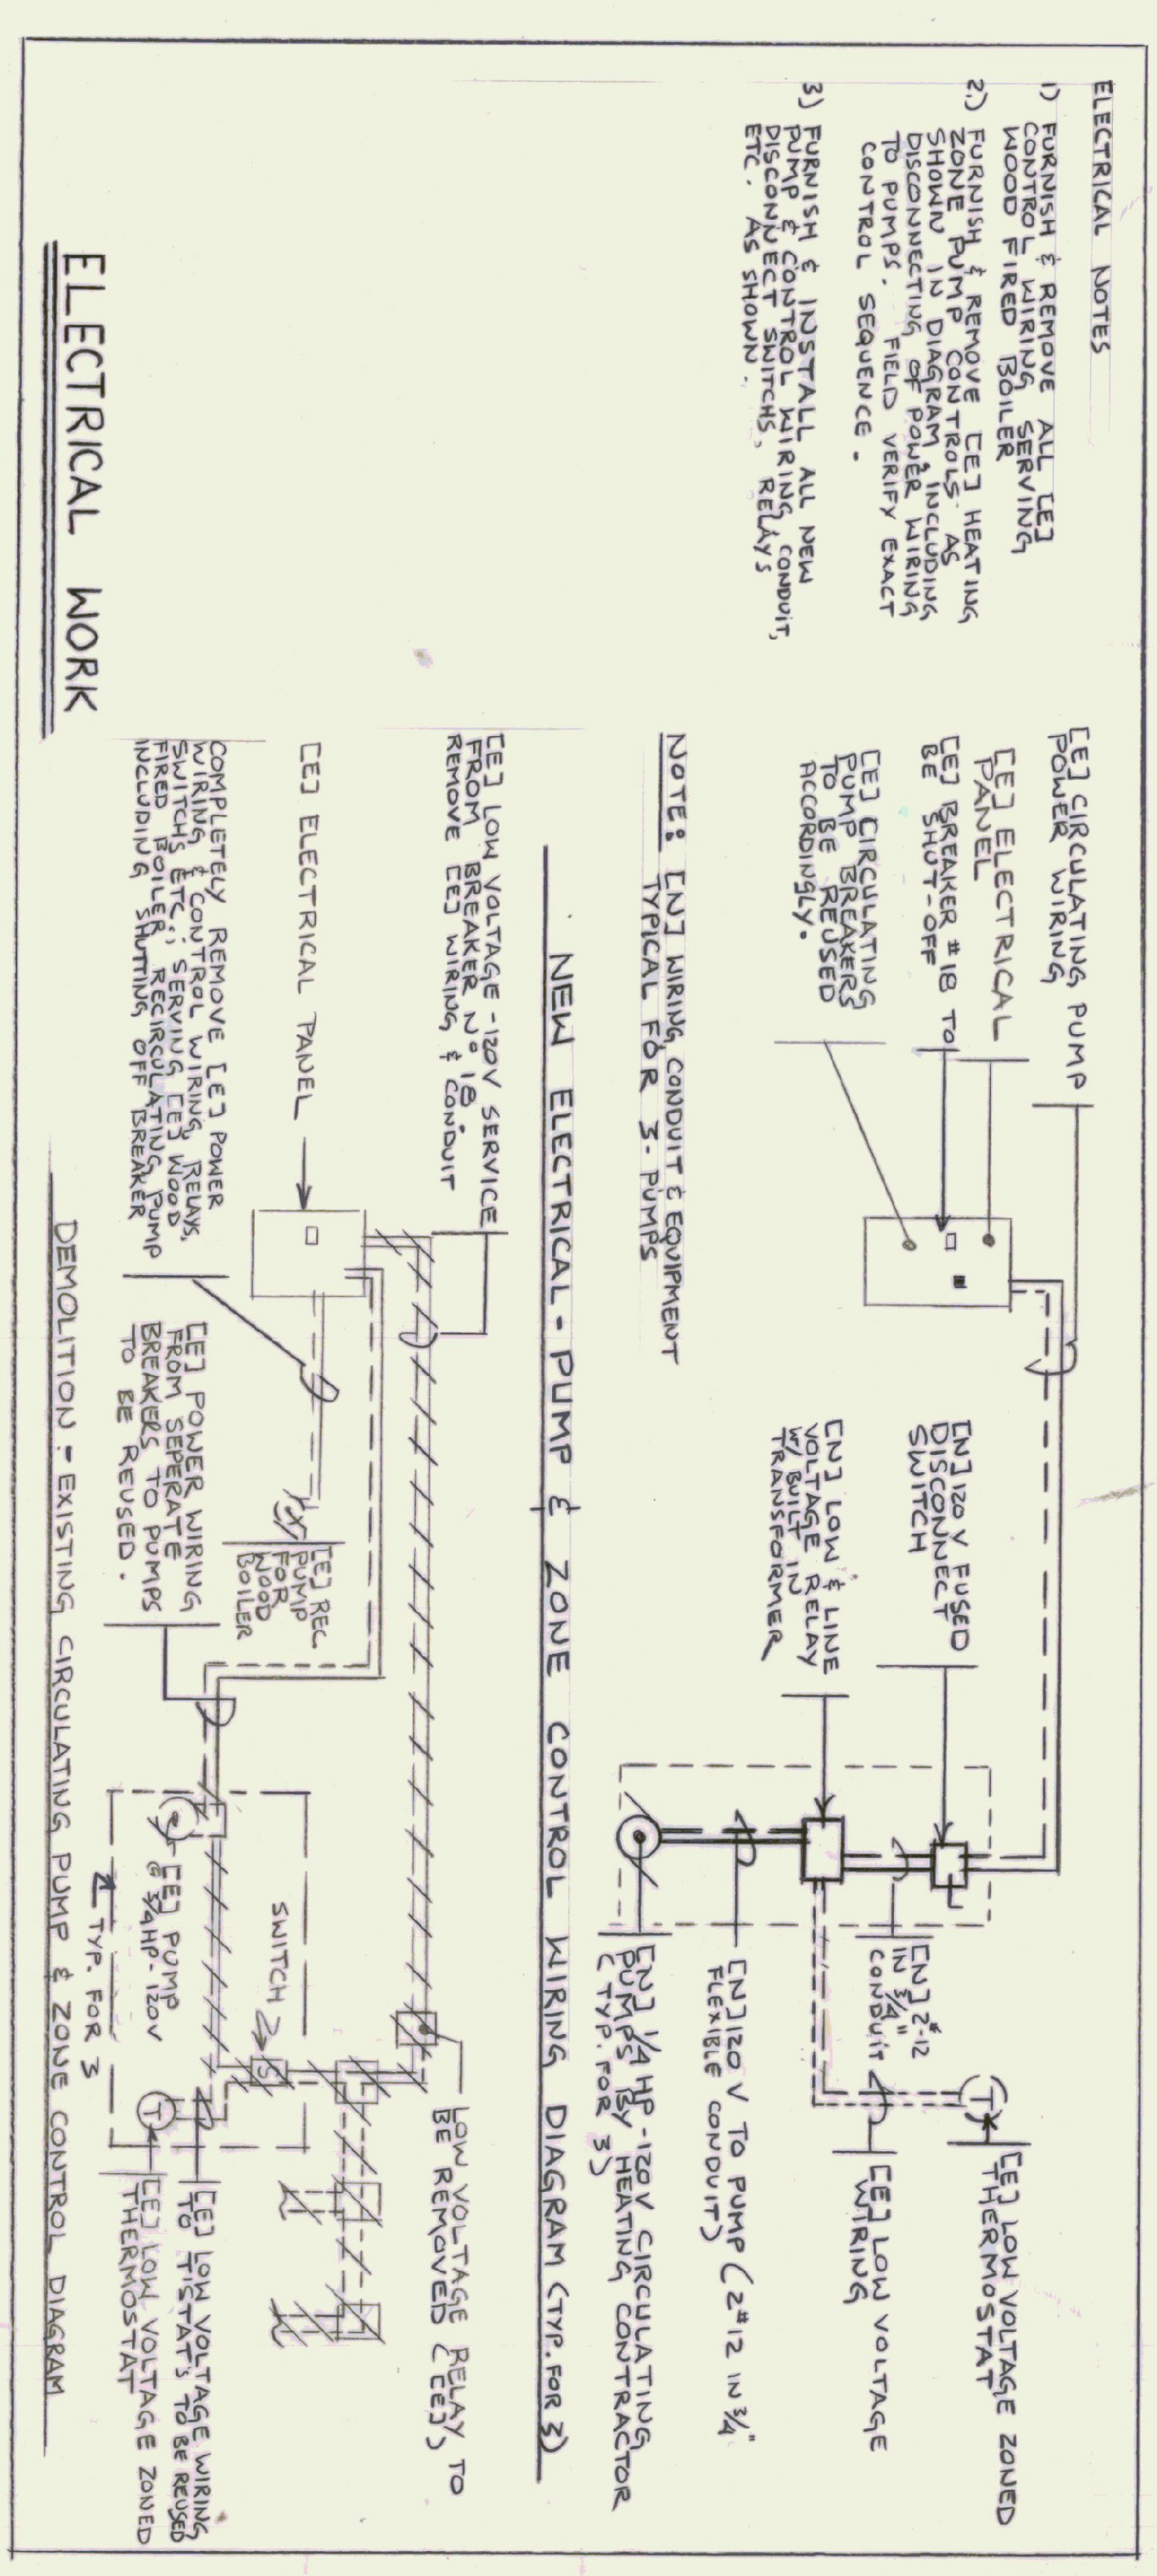

NEW ELECTRICAL - PUMP & ZONE CONTROL WIRING DIAGRAM (TYP. FOR 3)
NOT TO SCALE

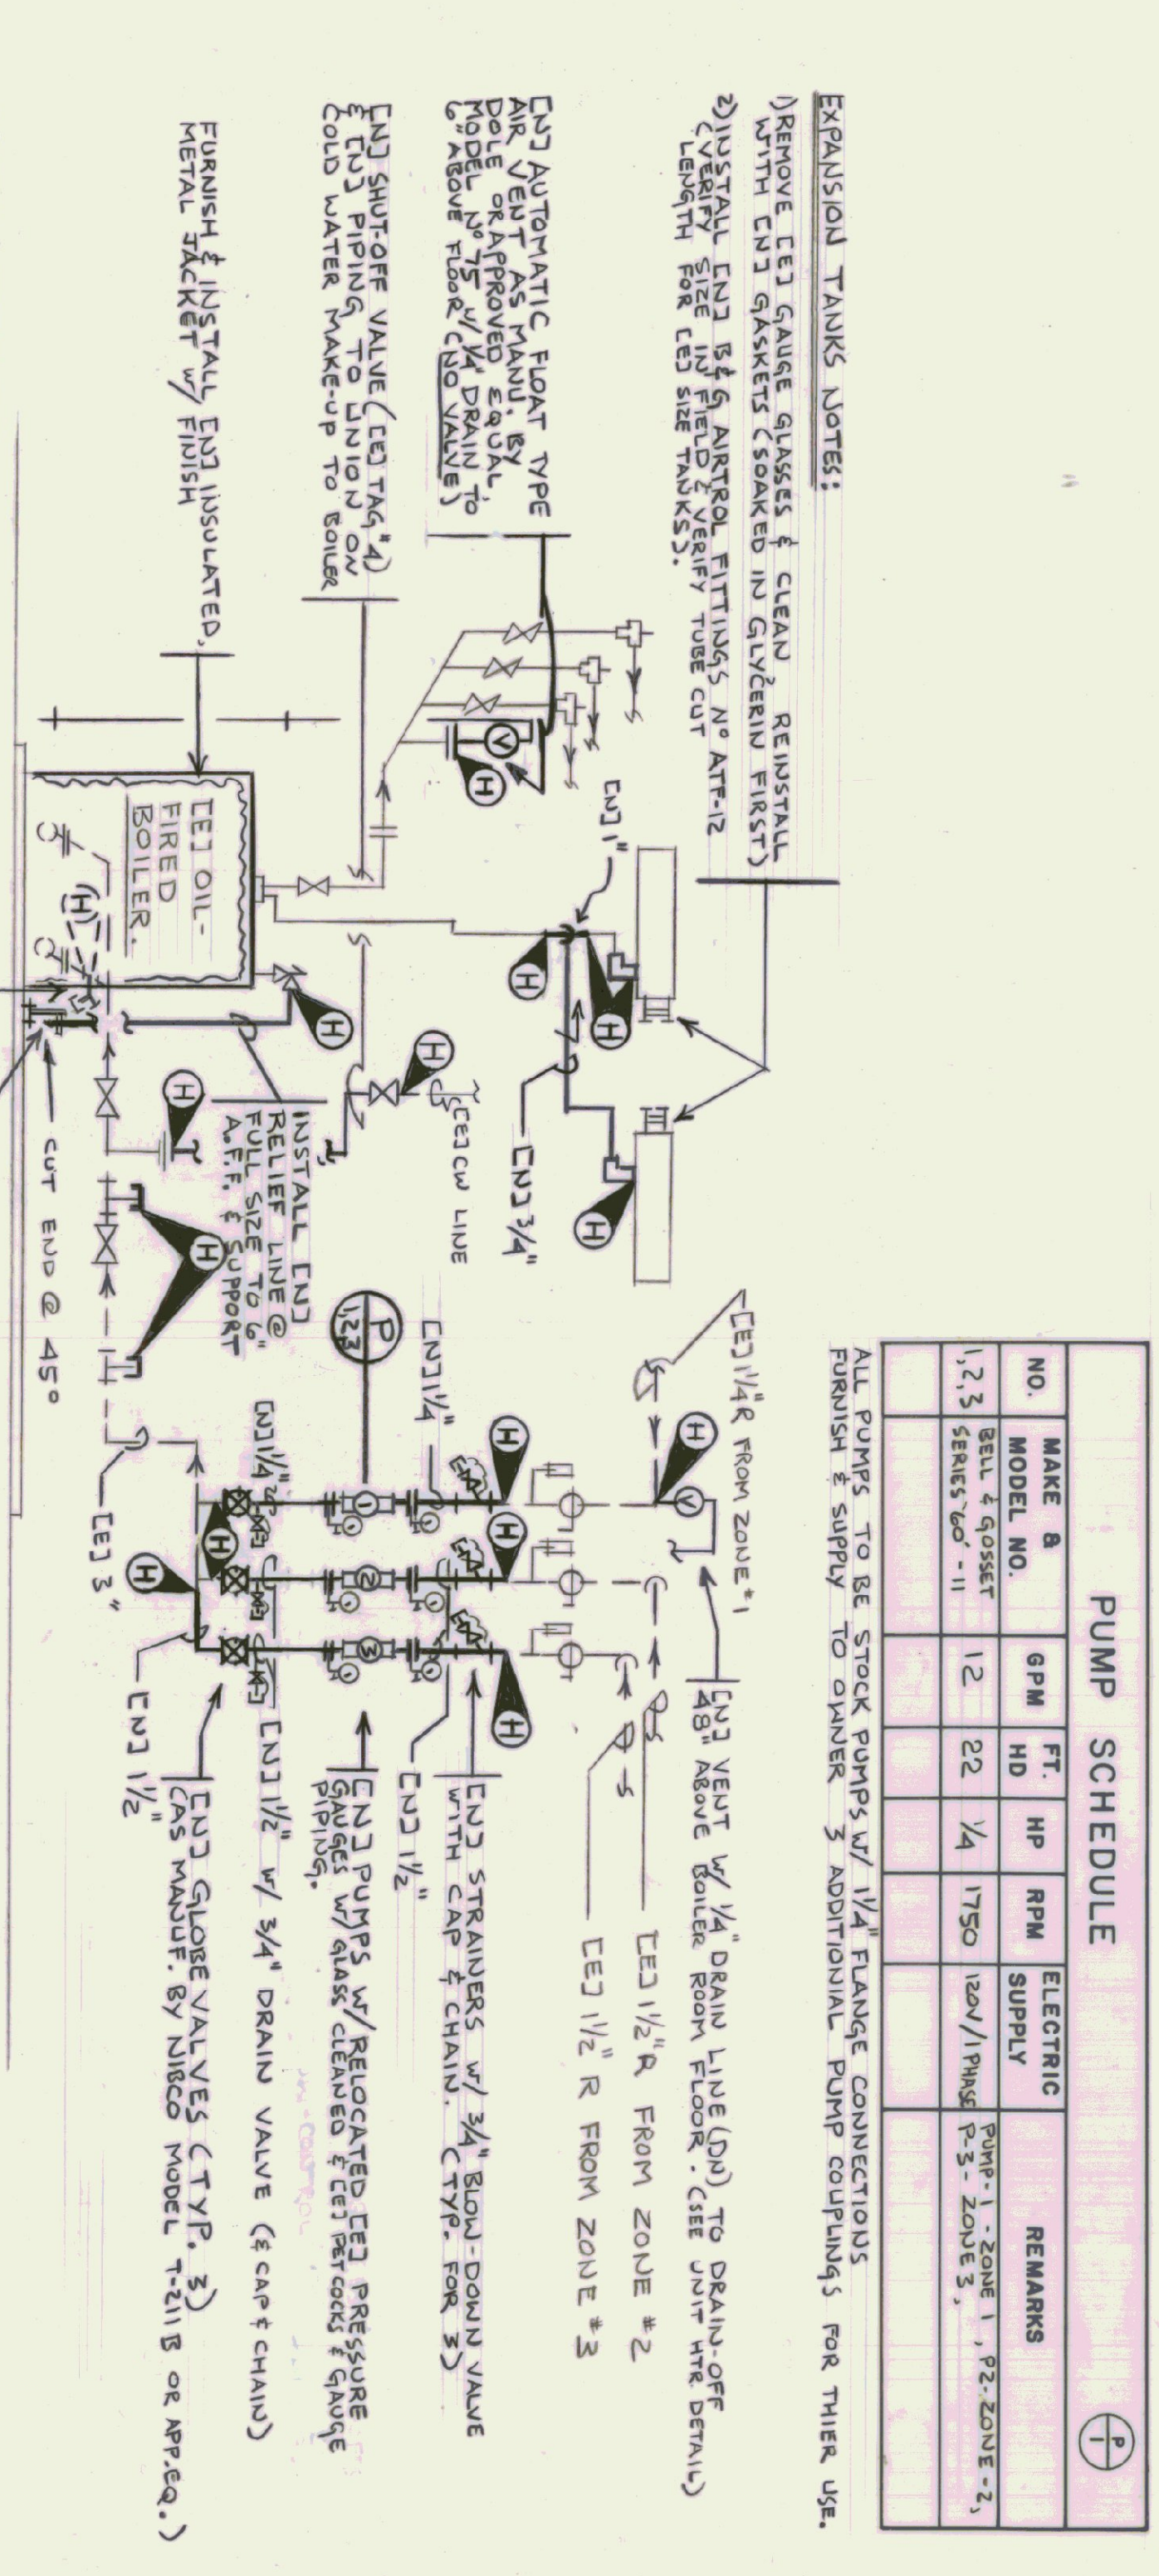

RENOVATIONS - BOILER PIPING FLOW DIAGRAM
NOT TO SCALE

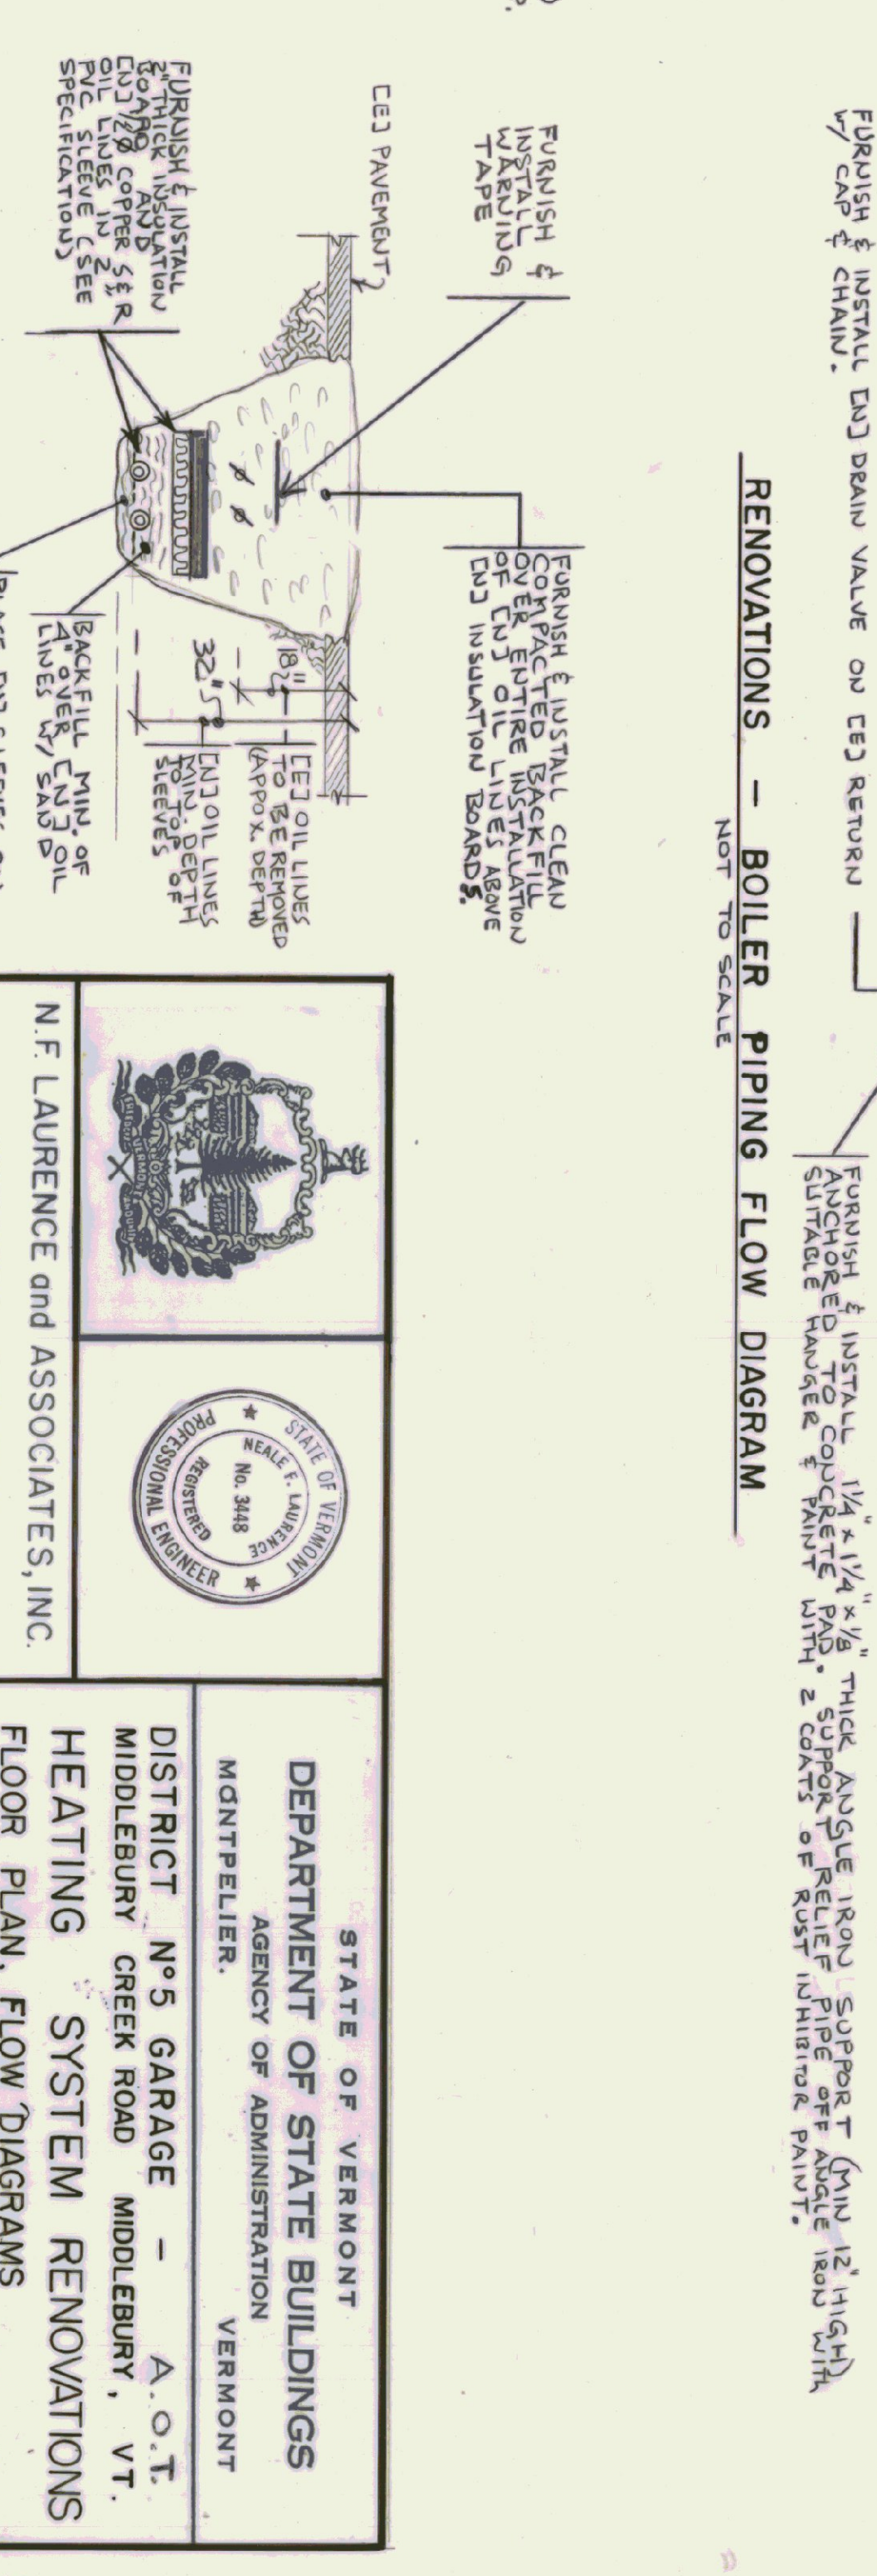

NEW OIL-LINE DETAIL
NOT TO SCALE

PUMP SCHEDULE					
NO.	MAKE & MODEL NO.	GPM	FT. HD	HP	ELECTRIC SUPPLY
1, 2, 3	BEUL & GOSSET SERIES 60-11	12	22	1/4	120V/1PH/60 P-3-ZONE 3

ALL PUMPS TO BE STOCK PUMPS W/ 1/4" FLANGE CONNECTIONS
PUMP 1 - ZONE 1, P-3-ZONE 2,
PUMP 2 - ZONE 3

STATE OF VERMONT
DEPARTMENT OF STATE BUILDINGS
AGENCY OF ADMINISTRATION
VERMONT

DISTRICT No 5 GARAGE - A.O.T.
MIDDLEBURY CREEK ROAD MIDDLEBURY, VT.
HEATING SYSTEM RENOVATIONS
FLOOR PLAN, FLOW DIAGRAMS

STATE OF VERMONT
REGISTERED PROFESSIONAL ENGINEER
No. 3488
N.F. LAURENCE and ASSOCIATES, INC.
CONSULTING ENGINEERS
103 WEST MAIN STREET
NORTHBOROUGH, MASSACHUSETTS 01532

DATE: 11-20-95 SCALE: AS NOTED DWG. NO. H-12
DRAWN BY: MFL APPROVED BY: MFL REVISIONS: 2 OF 2