



HEATING PLAN
(5 BAY)
SCALE: 3/16"


DETAIL OF END OF MAIN (GARAGE OFFICE)
SCALE: 1/16"

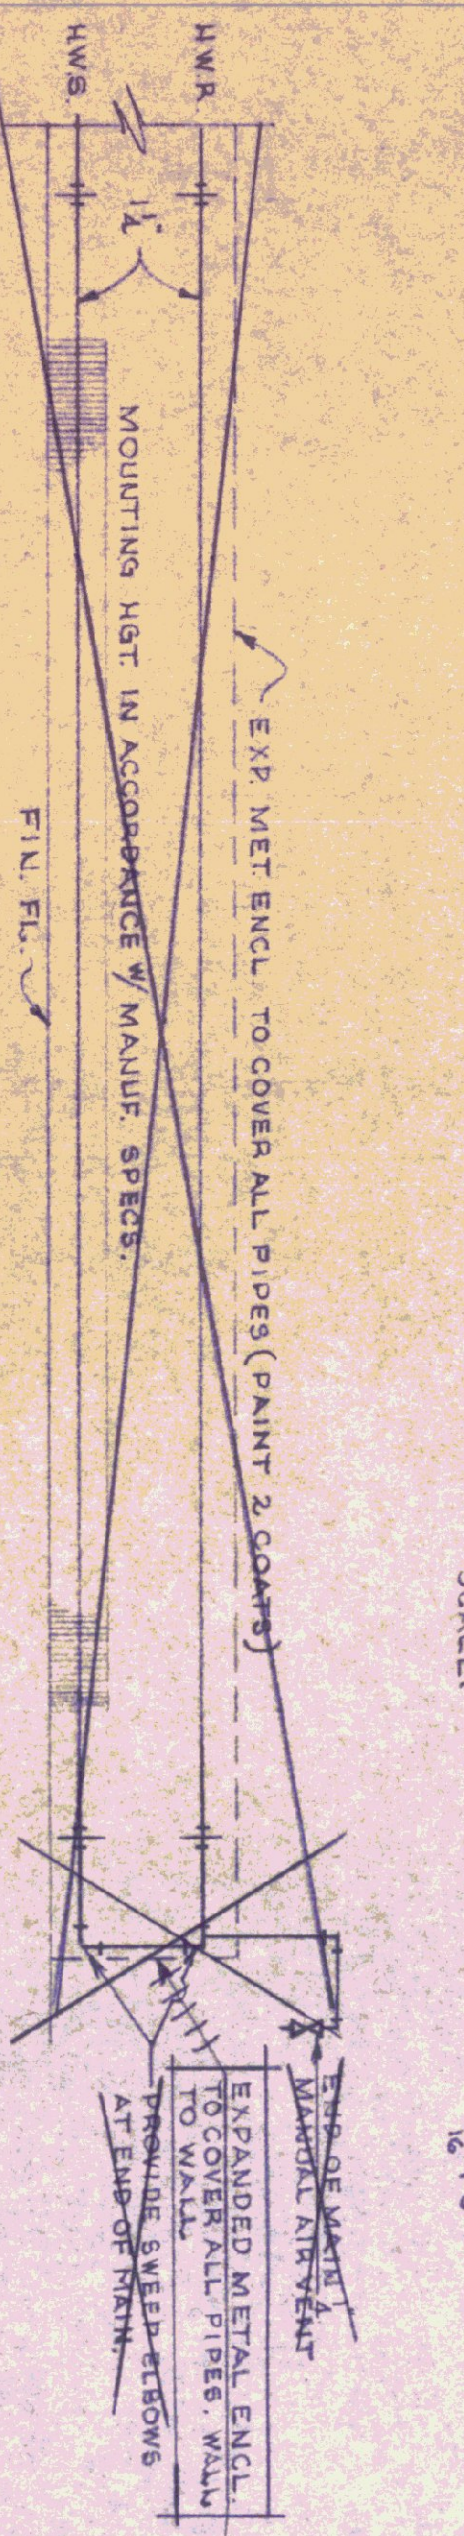


TYPICAL SECTION
SCALE: 1/16"

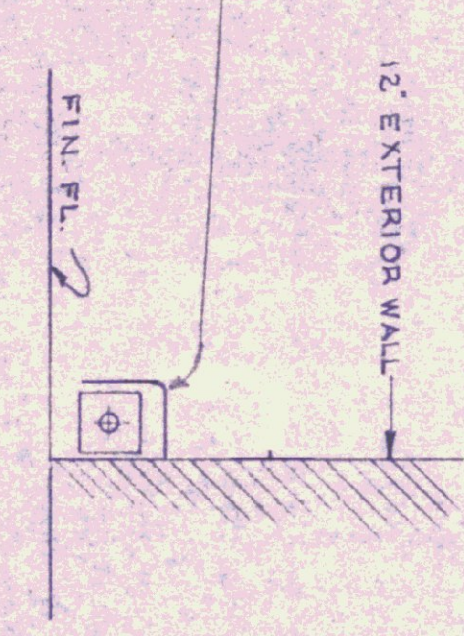

TYPICAL BASEBOARD RADIATION PIPING (PIPE SYSTEM)
SCALE: 1/16"

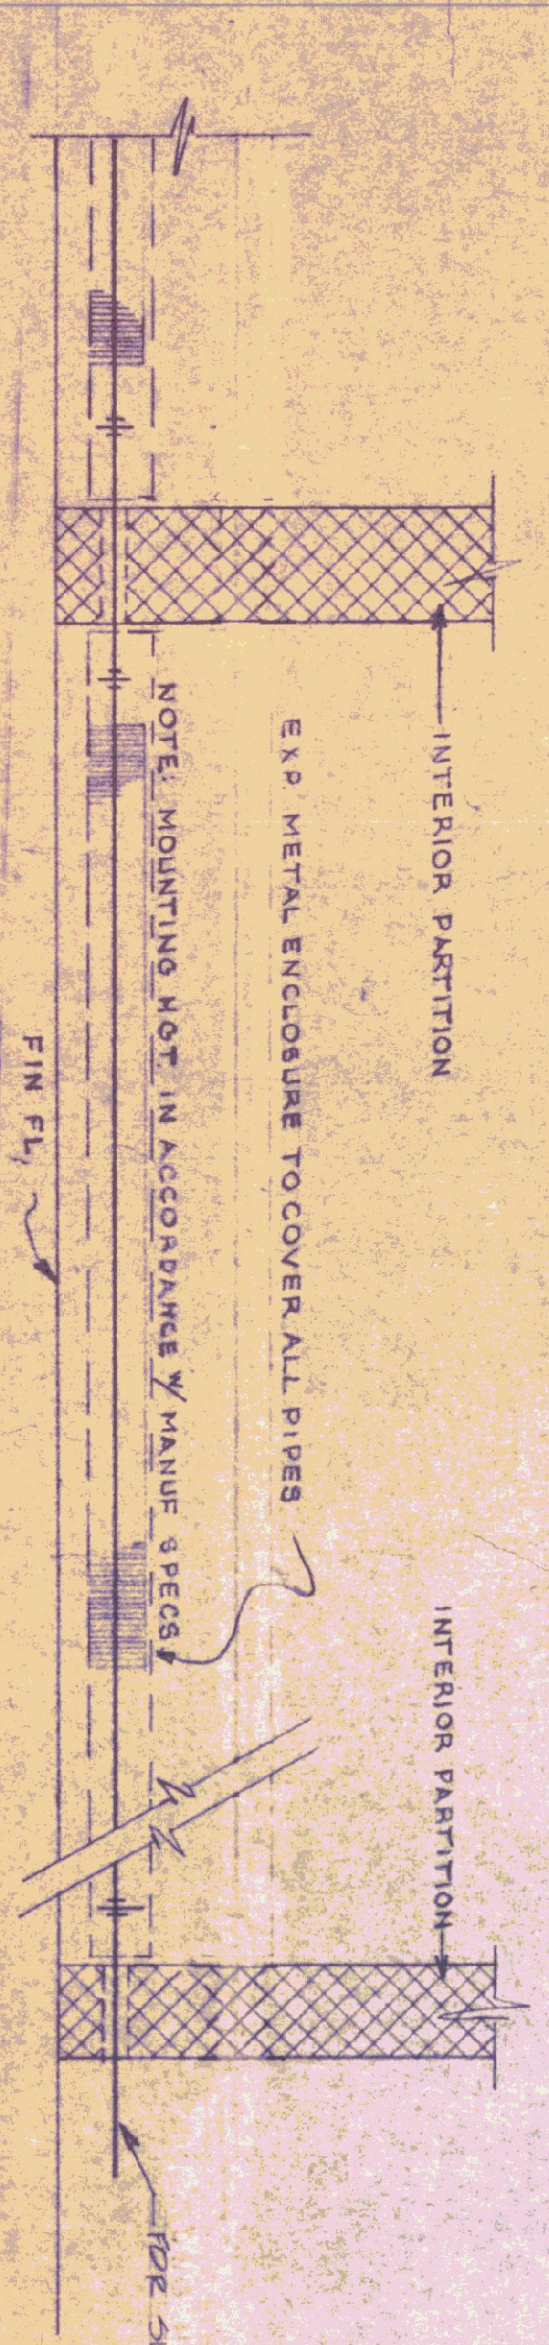


PLUMBING PLAN
SCALE: 1/16"

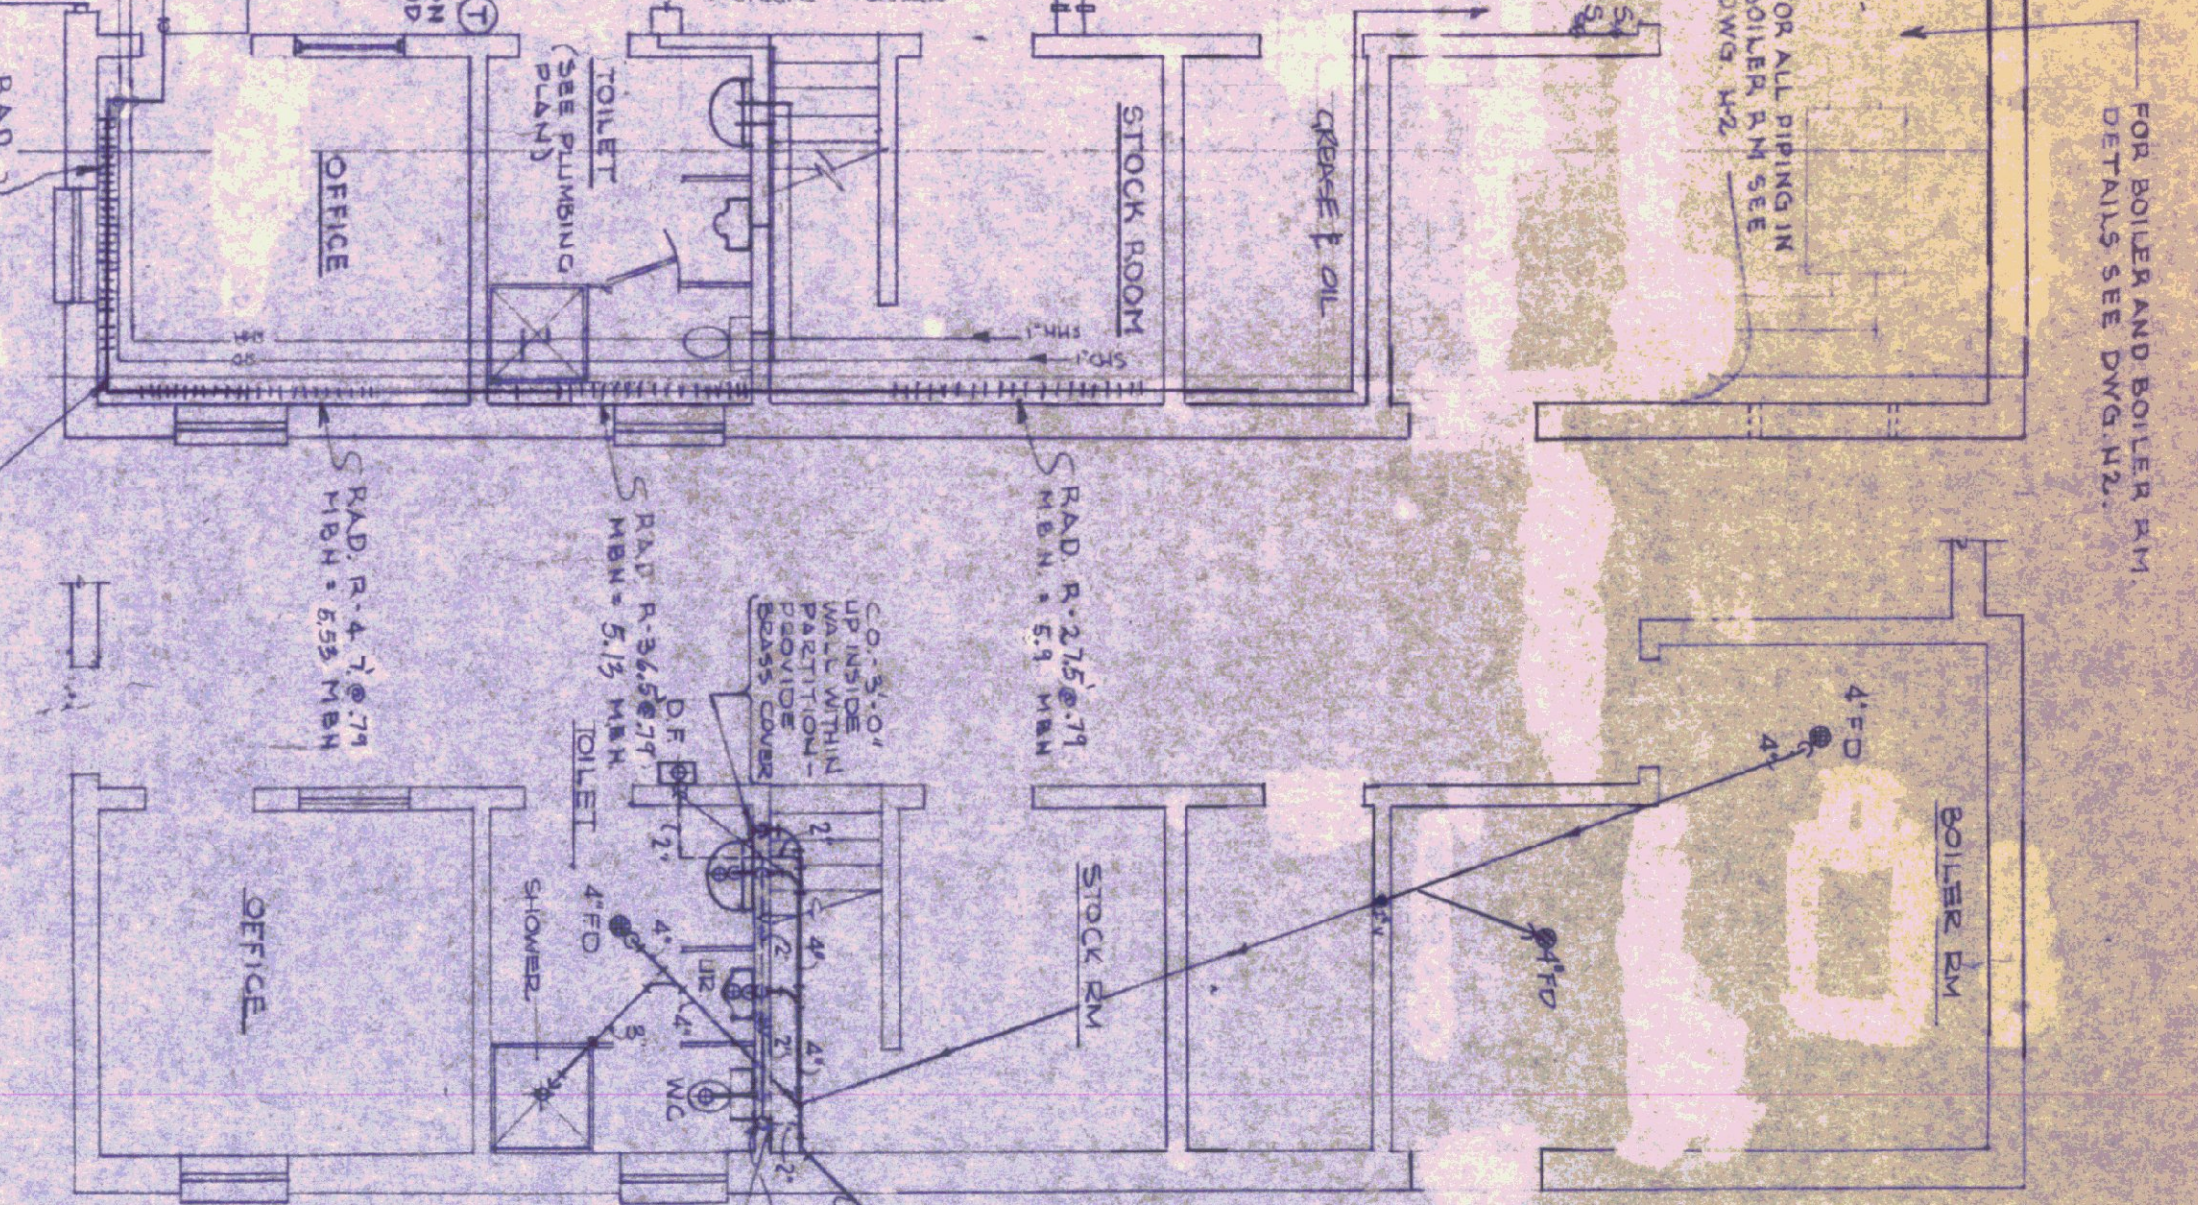

PLUMBING ISOMETRIC DIAGRAM



DOMESTIC WATER DISTRIBUTION DETAIL

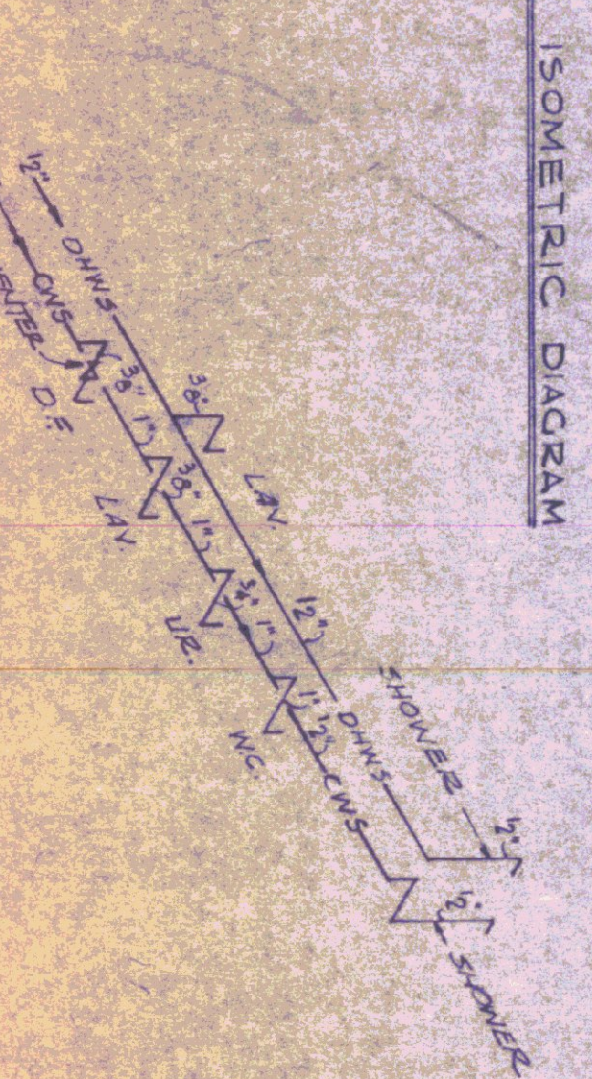

SEE DRAWING H-2 FOR SCHEDULE & GENERAL NOTES

LEGEND

- H.W.B. --- HEATING WATER BAY
- 5/8" --- BULKHEAD SAFETY SWITCH (T.D. & 3/8" BAY PIPE)
- T --- T STAYS
- X --- PIPE SUPPLY TO BOTTOM & RETURN TO TOP
- M --- GATE VALVE
- CHECK VALVE
- BALANCING COCK
- FLOW CONTROL VALVE
- LIQUID
- FUSIBLE LEVER, WAT.C. VALVE
- STRAIGHT
- PR.V. - ALL BRONZE
- BACK FLOW RESTRICTOR

| DATE | REVISIONS | REVISION |
|----------|-----------|--|
| 10-18-74 | 10-18-74 | ADD WATER SUPPLY TO BOTTOM & RETURN TO TOP |
| 10-18-74 | 10-18-74 | ADD WATER SUPPLY TO BOTTOM & RETURN TO TOP |

STATE OF VERMONT
DIVISION OF STATE BUILDINGS
AGENCY OF ADMINISTRATION
MONTPELIER, VERMONT

Standard Five Bay Highway Garage Bldg.
HEATING PLAN

| | | |
|-----------------------|--------------------------|--------------|
| DATE: 10-18-74 | DESIGNED BY: GUS MASTERS | DWG. NO. H-1 |
| DRAWN BY: [Signature] | APPROVED BY: [Signature] | 1 of 1 |
| SCALE: As noted | | RSM |
| STUDIO 3000 INC. | | |