


State of Vermont
Department of Buildings & General Services
HUNTINGTON HANGER SITEWORK
EDWARD F. KNAPP STATE AIRPORT
Berlin, Vermont

AGENCY OF ADMINISTRATION
DEPT. OF BUILDINGS & GENERAL SERVICES
2 GOVERNOR AIKEN AVENUE
MONTPELIER, VERMONT 05633-5801
THOMAS W. TORTI, COMMISSIONER

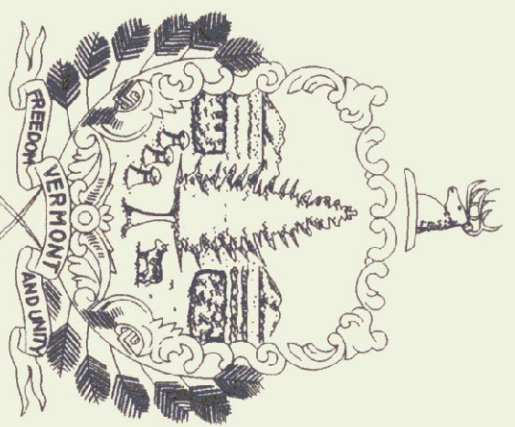

Howard Dean, M.D.
Governor

September 1996


C1 SITE PLAN
C2 DETAILS
SE-1 SITE ELECTRICAL PLAN

INDEX OF SHEETS

ARCHITECT: Provan & Lorber
7 Main Street
Montpelier, Vermont 05602
(802) 229-1442


MECH/ELEC. ENGINEER: Pearson & Associates
P.O. Box 610
Stowe, Vermont 05672
(802) 253-9290

AGENCY OF TRANSPORTATION
133 STATE STREET
MONTPELIER, VERMONT 05602
GLENN GERSHANECK, SECRETARY

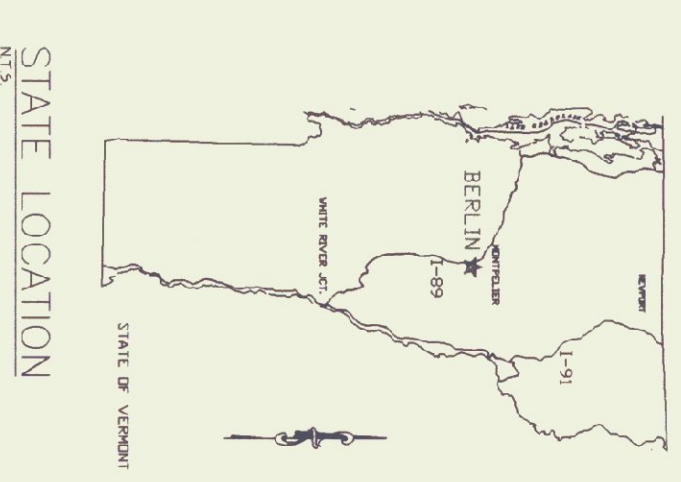

PROJECT LOCATION

N/F
NICOM INC.

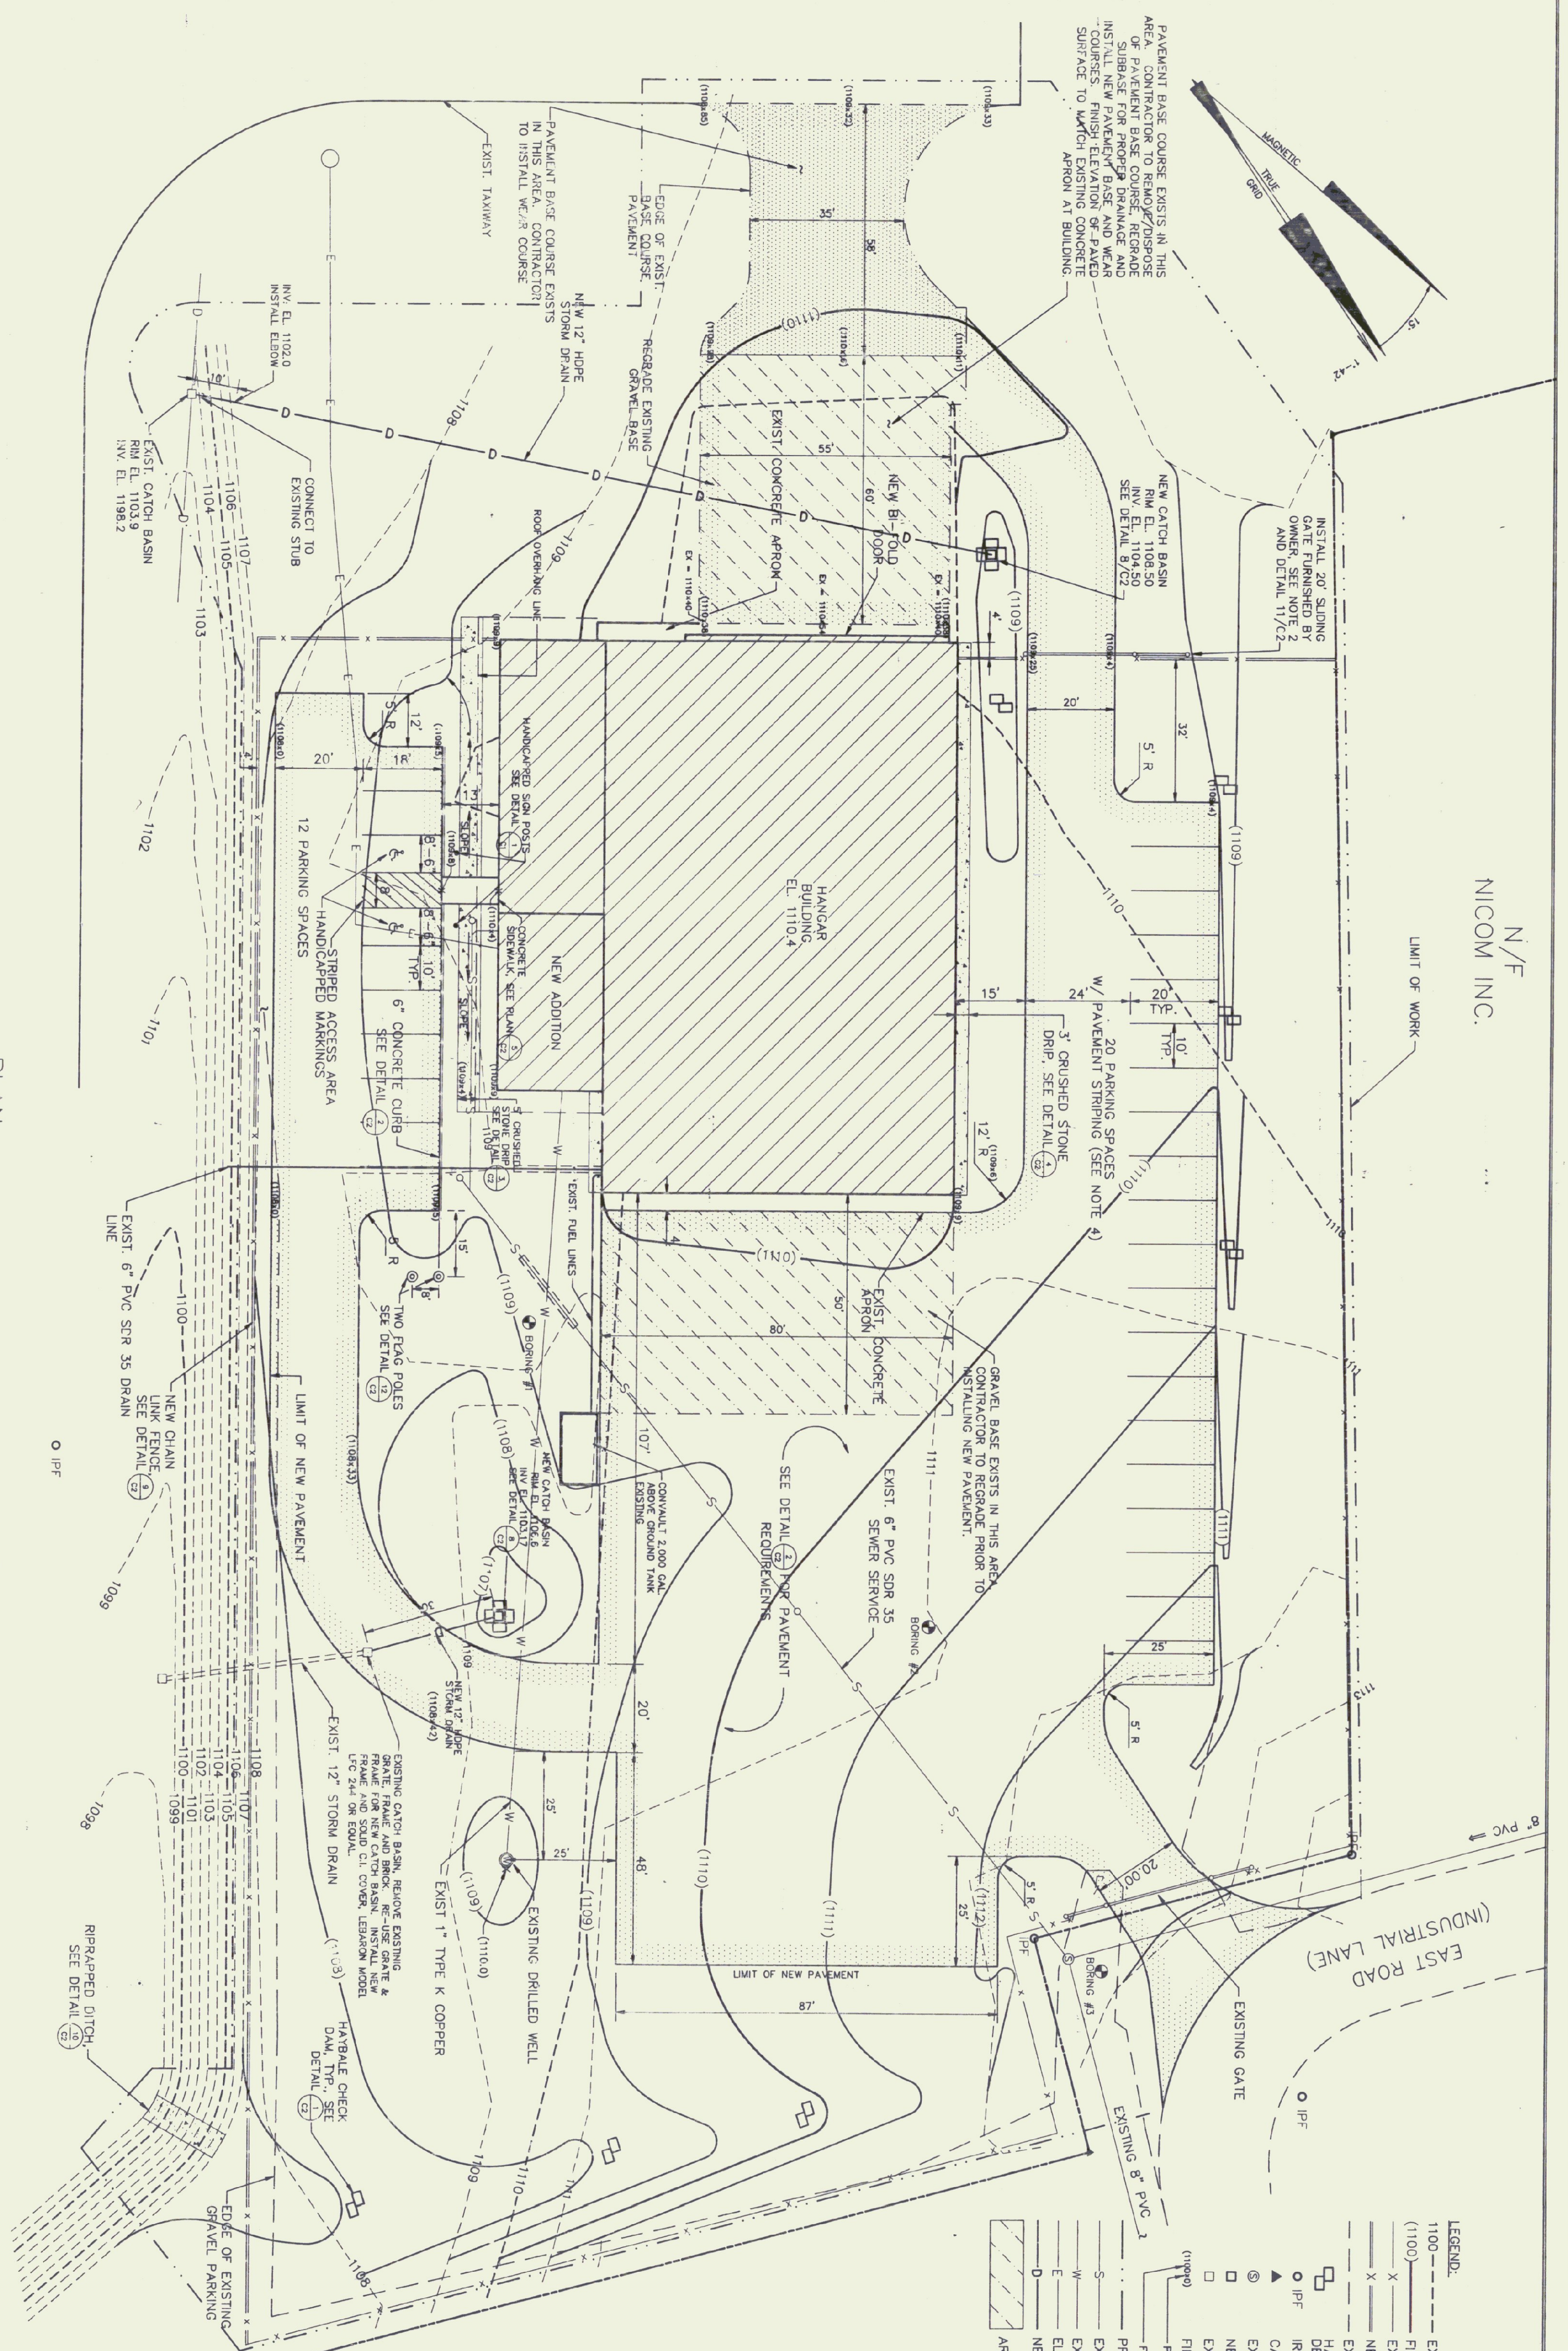

PAVEMENT BASE COURSE EXISTS IN THIS AREA. CONTRACTOR TO REMOVE EXISTING SUBBASE FOR PROPER DRAINAGE AND INSTALL NEW PAVEMENT BASE AND WEAR COURSE TO FINISH ELEVATION OF PAVED SURFACE TO MATCH ELEVATION OF APRON AT BUILDING.


INSTALL 20' SLIDING GATE FINISHED BY OWNER. SEE NOTE 2 AND DETAIL 17/02.

NEW CATCH BASIN FINV. EL. 1104.30 SEE DETAIL 8/02.

HANGAR BUILDING EL. 1110.4

12 PARKING SPACES
HAND STRIPED MARKINGS

PLAN
SCALE: 1" = 20'

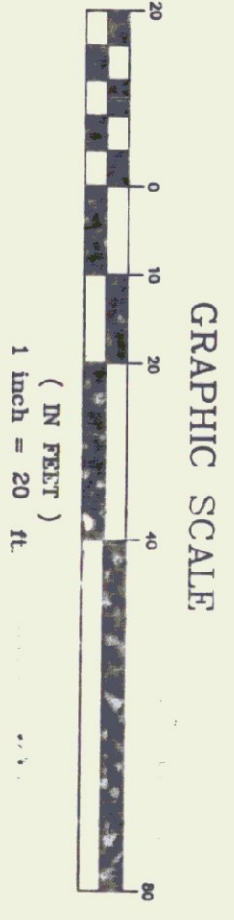


EAST ROAD (INDUSTRIAL LANE)

- LEGEND:
- EXISTING GROUND CONTOUR LINE
 - (1100) FINISHED GRADE CONTOUR LINE
 - X EXISTING SECURITY FENCE
 - X NEW CHAIN LINK FENCE
 - EXIST. GRAVEL ROAD/PARKING
 - HAY BALE CHECK DAM, SEE DETAIL 17/02
 - IRON PIN FOUND
 - ▲ CALCULATED POINT
 - EXISTING SEWER MANHOLE
 - NEW CATCH BASIN
 - EXISTING CATCH BASIN
 - FINISH GRADE SPOT ELEVATION
 - POINT OF ELEVATION
 - FINISH ELEVATION
 - PROJECT LIMIT
 - S EXISTING SEWER
 - W EXISTING WATER
 - E ELECTRICAL CONDUIT
 - D NEW STORM DRAIN
 - ▨ AREA OF EXISTING GRAVEL BASE


- NOTES:
- 1) EXISTING GROUND CONTOURS ARE APPROXIMATE AND MAY VARY FROM THOSE SHOWN.
 - 2) CONTRACTOR TO REVIEW EXISTING SLIDING GATE TO BE FINISHED BY OWNER, LOCATED ON SITE. CONTRACTOR TO PROVIDE ALL NECESSARY ACCESSORIES REQUIRED FOR A COMPLETE INSTALLATION.
 - 3) CONTRACTOR TO CONTACT DIG SAFE (1-800) 225-4877 FROM TO START OF ANY EXCAVATION WORK.
 - 4) PAVEMENT MARKINGS SHALL BE THERMOPLASTIC CONFORMING TO SECTIONS 708.10 AND 646 OF THE VERMONT A.O.T. STANDARD SPECIFICATIONS FOR CONSTRUCTION.

DETAIL
SCALE: NONE

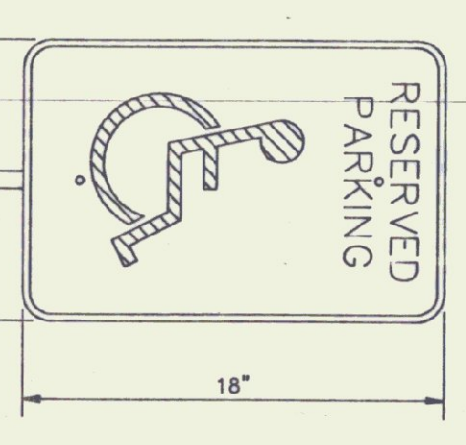

SIGN TO BE MOUNTED ON STEEL SIGN POST IN ACCORDANCE WITH VERMONT A.O.T. STANDARD DETAIL SHEET E-160. A.D.A. APPROVED SIGN

NO.	DATE	REVISION	ENCLING




















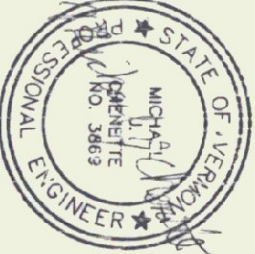


Provan & Lorber, Inc.
ENGINEERS AND PLANNERS
Home Office: PO Box 388, Colchester, NH 03232 (603) 746-2820
Northwestern NH Office: PO Box 187, Littleton, NH 03761 (603) 444-0501
Vermont Office: Main St., Montpelier, VT 05602 (802) 229-1442

HUNTINGTON HANGAR
VERMONT AGENCY OF TRANSPORTATION
KNAPP AIRPORT
BERLIN, VERMONT

DATE	PROJ. NO.
SEPT. 1996	987.01
ENG. BY MJC	DRWN. BY JLS
CHKD. BY MJC	DRWG. NO. C1

SHEET 1 OF 3

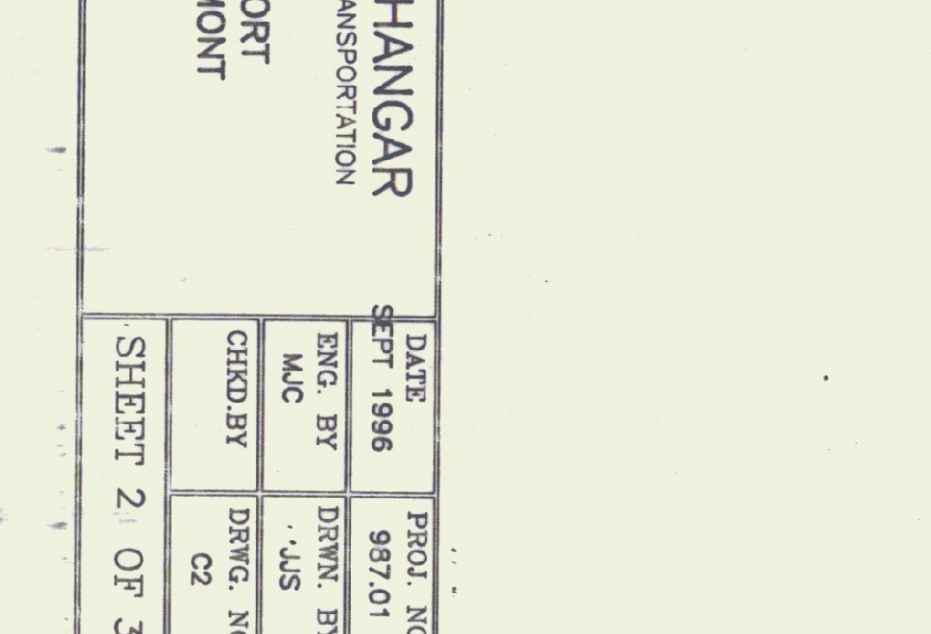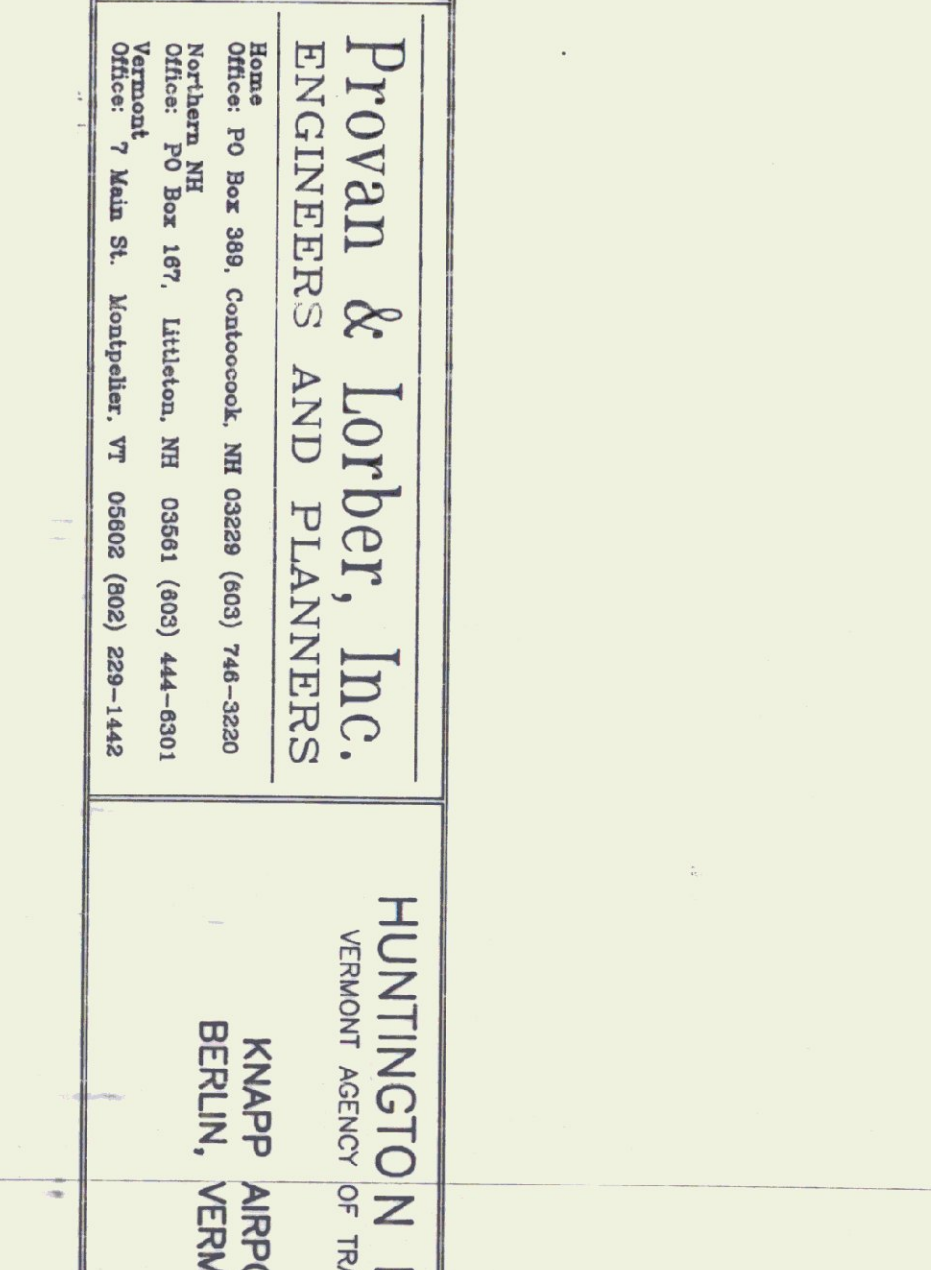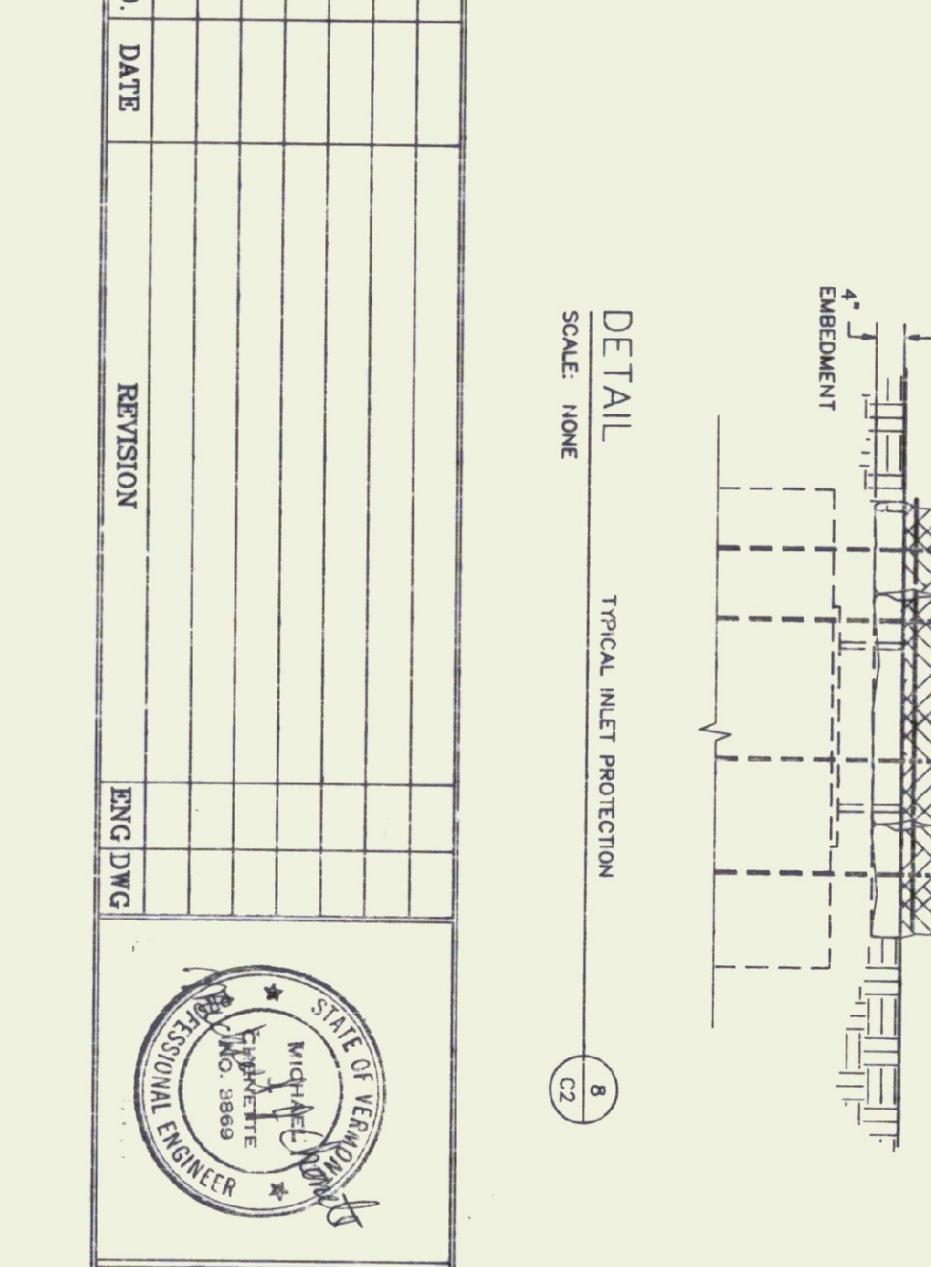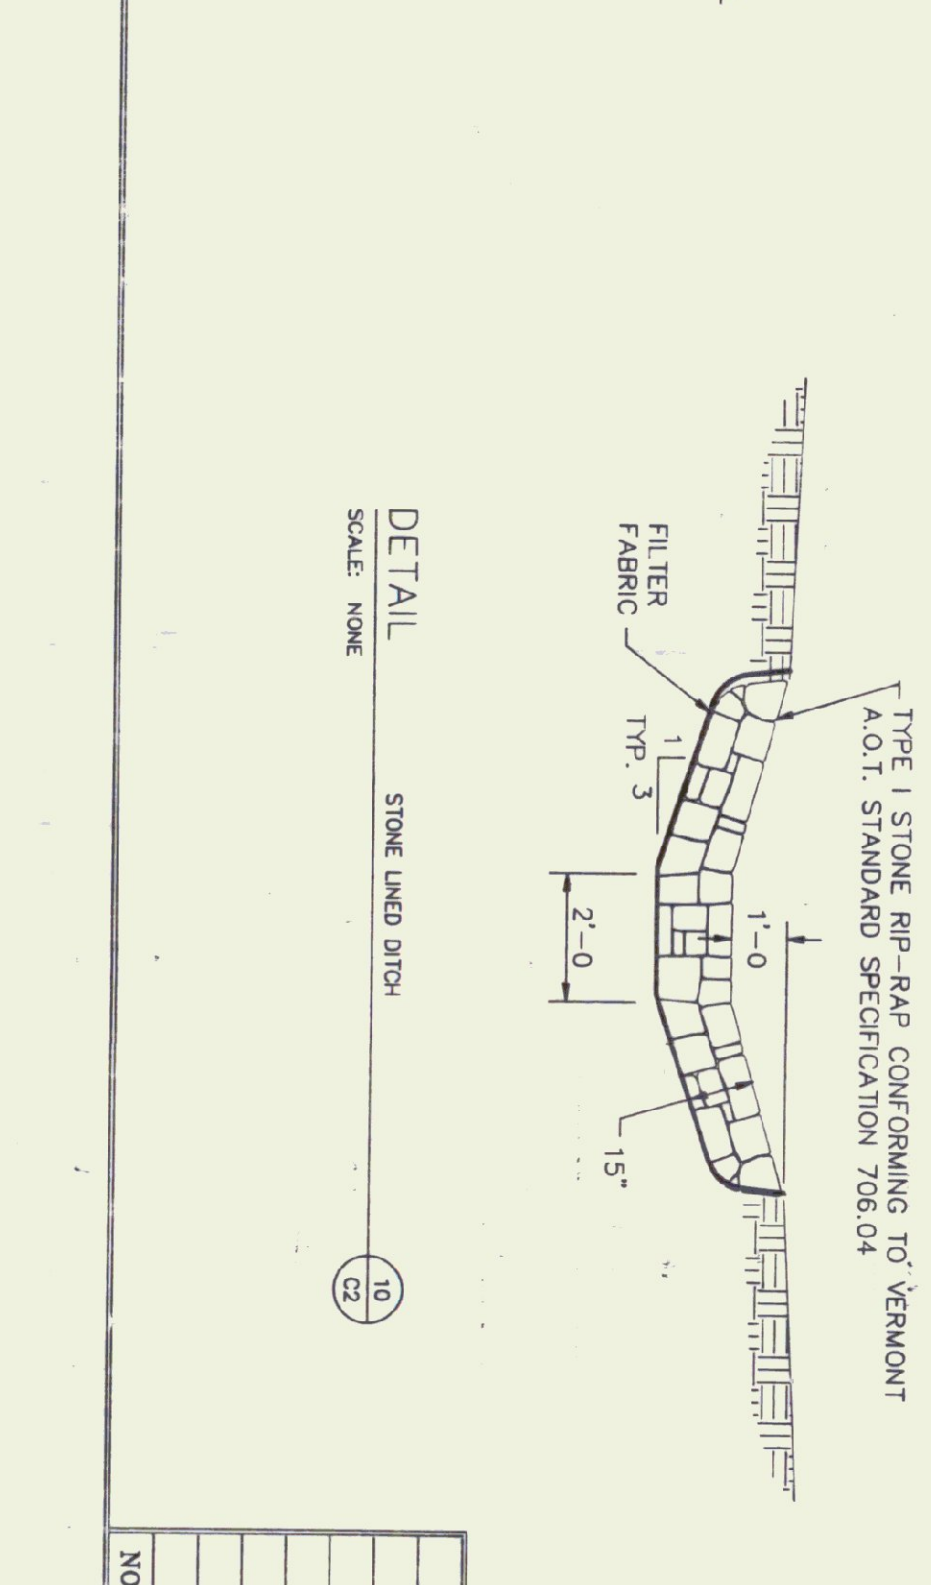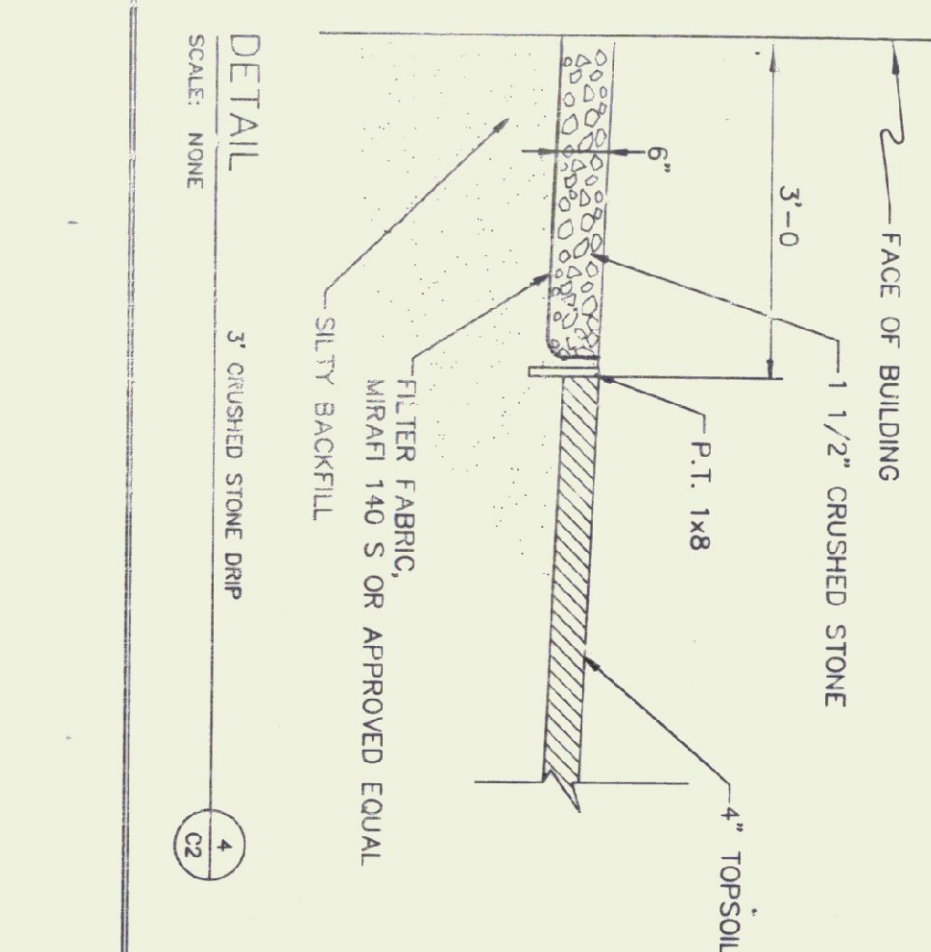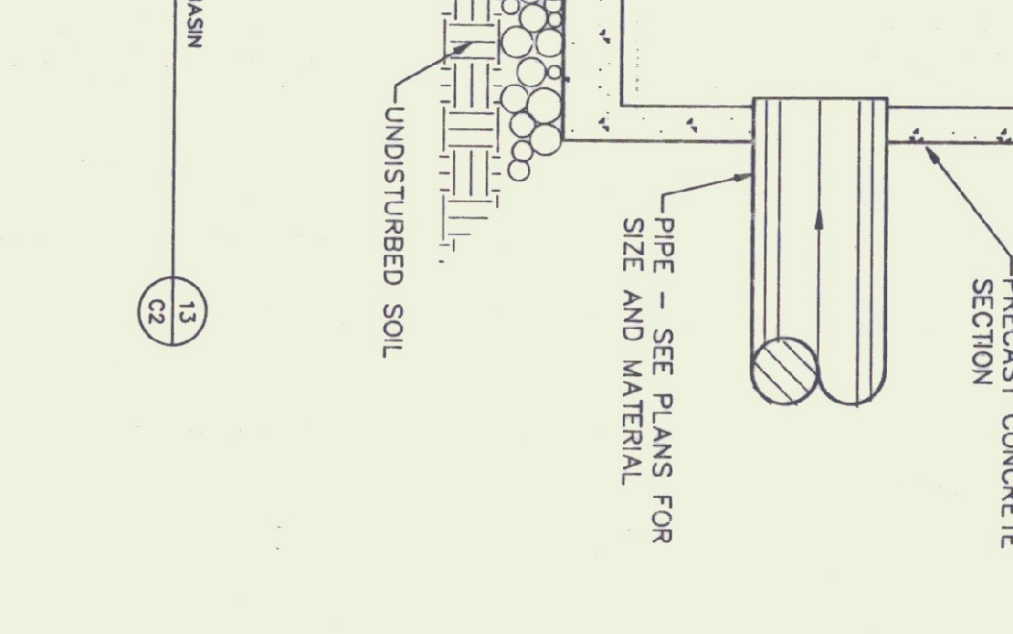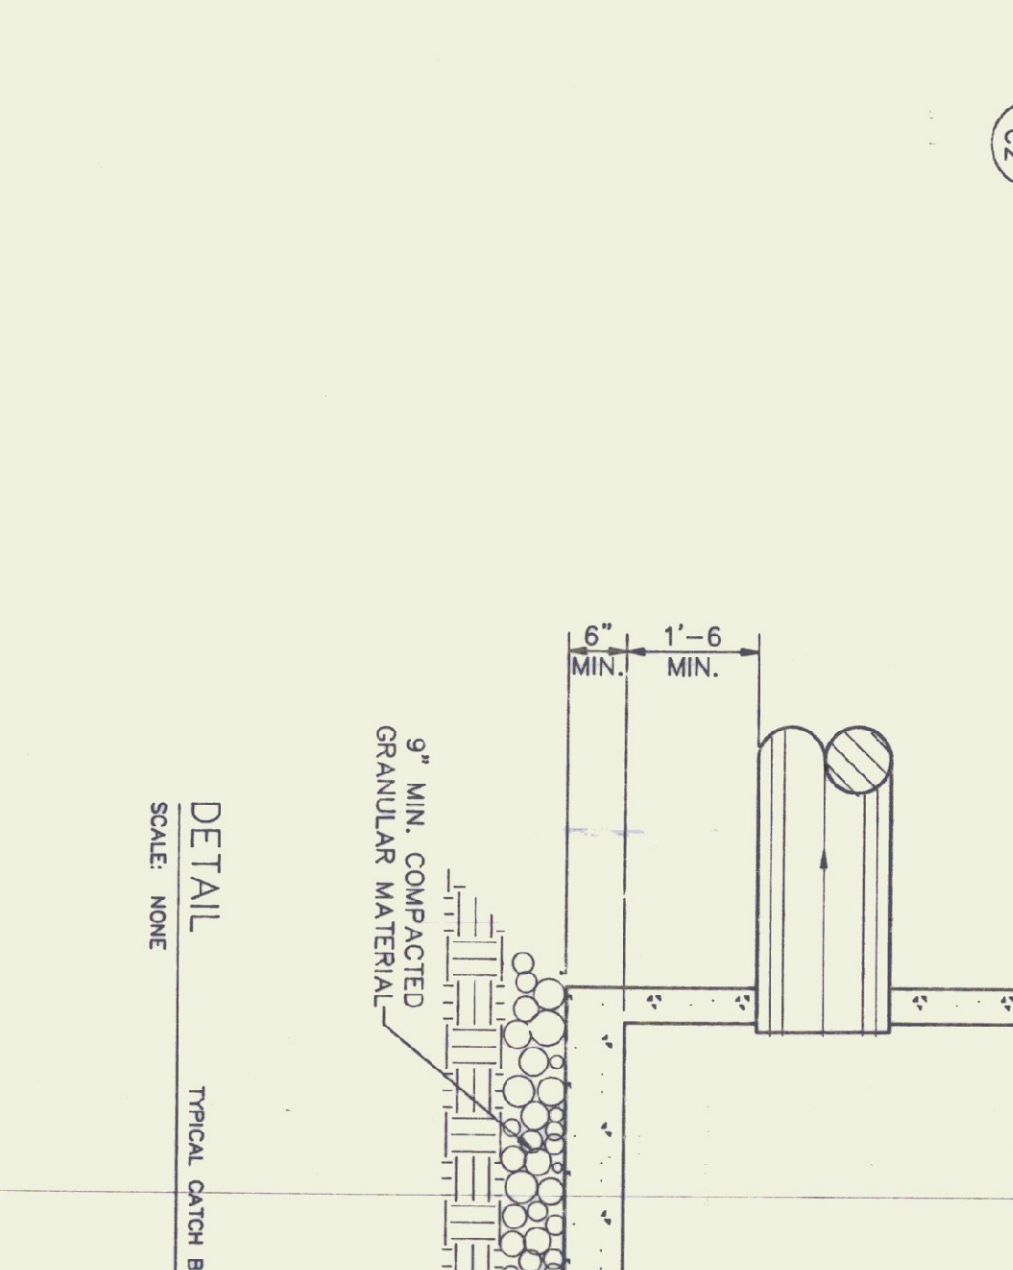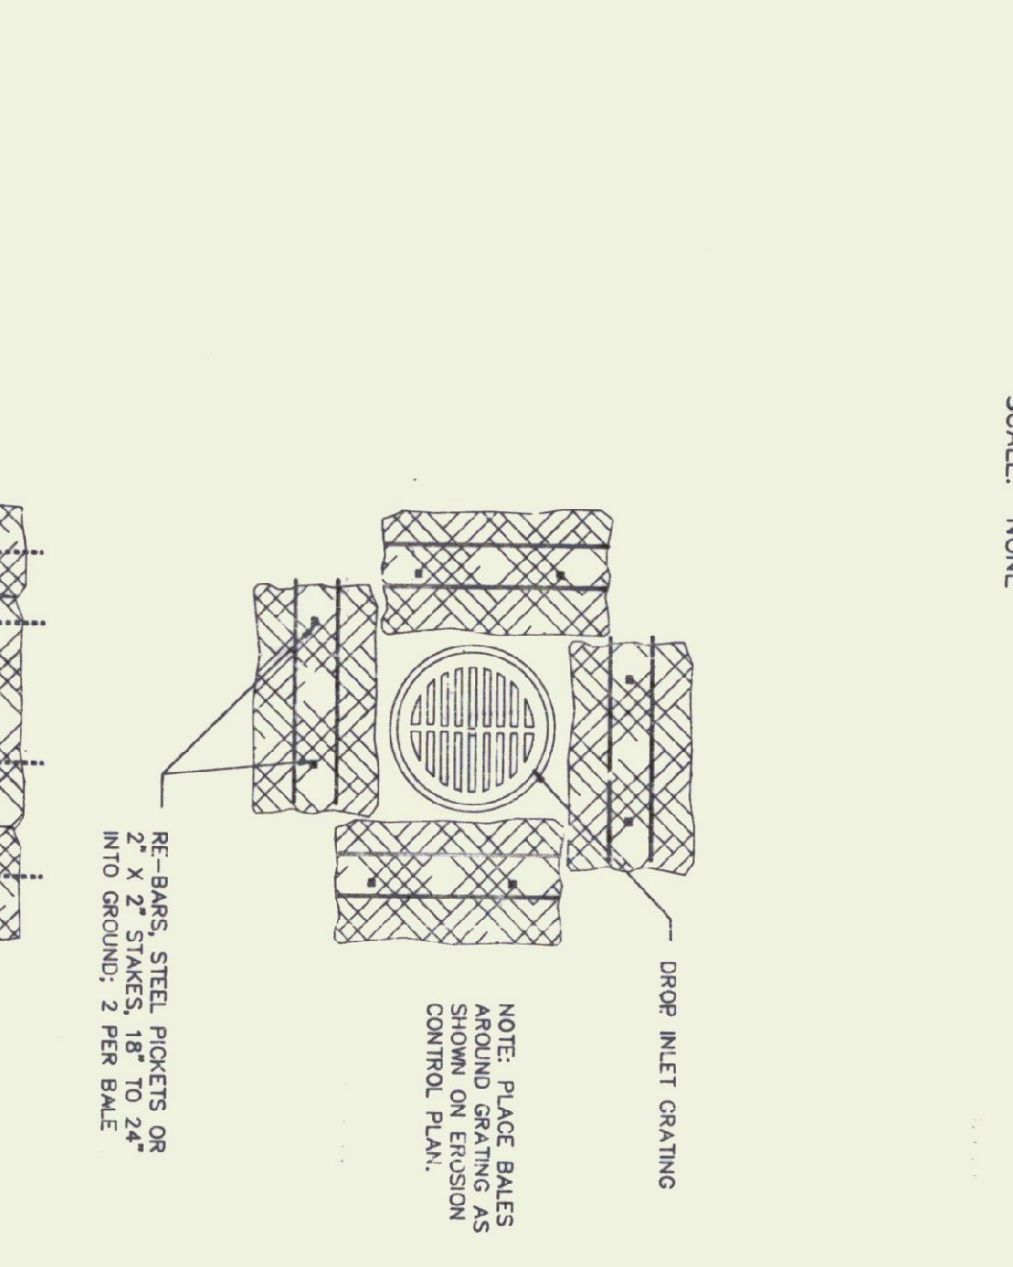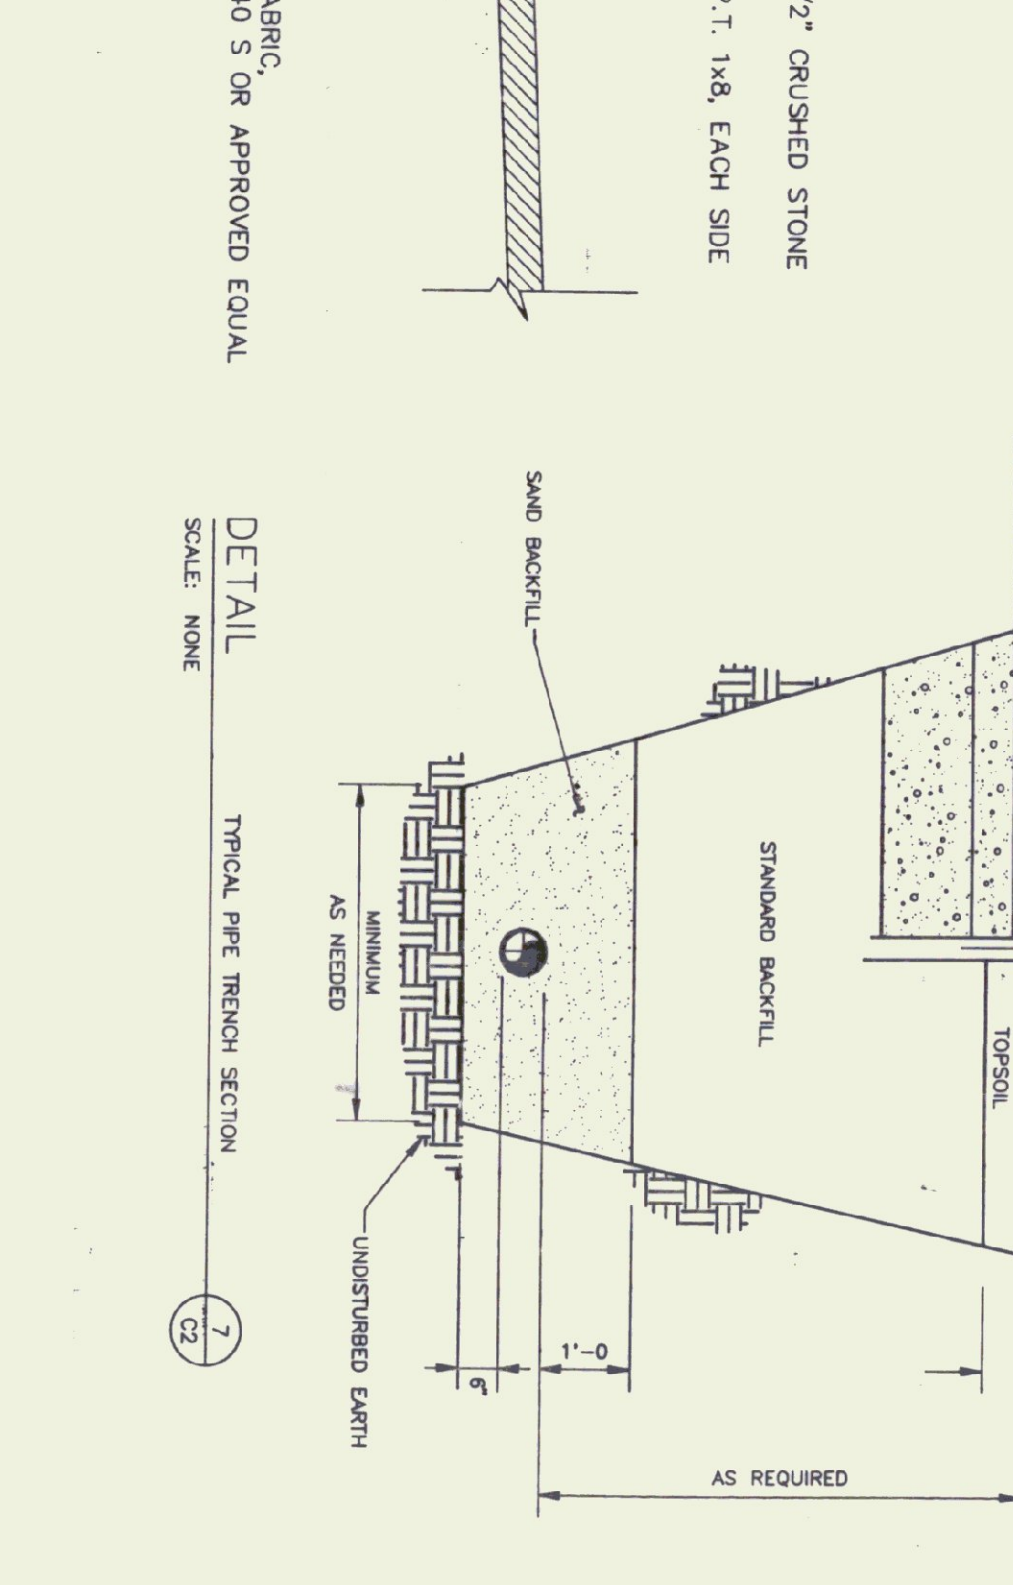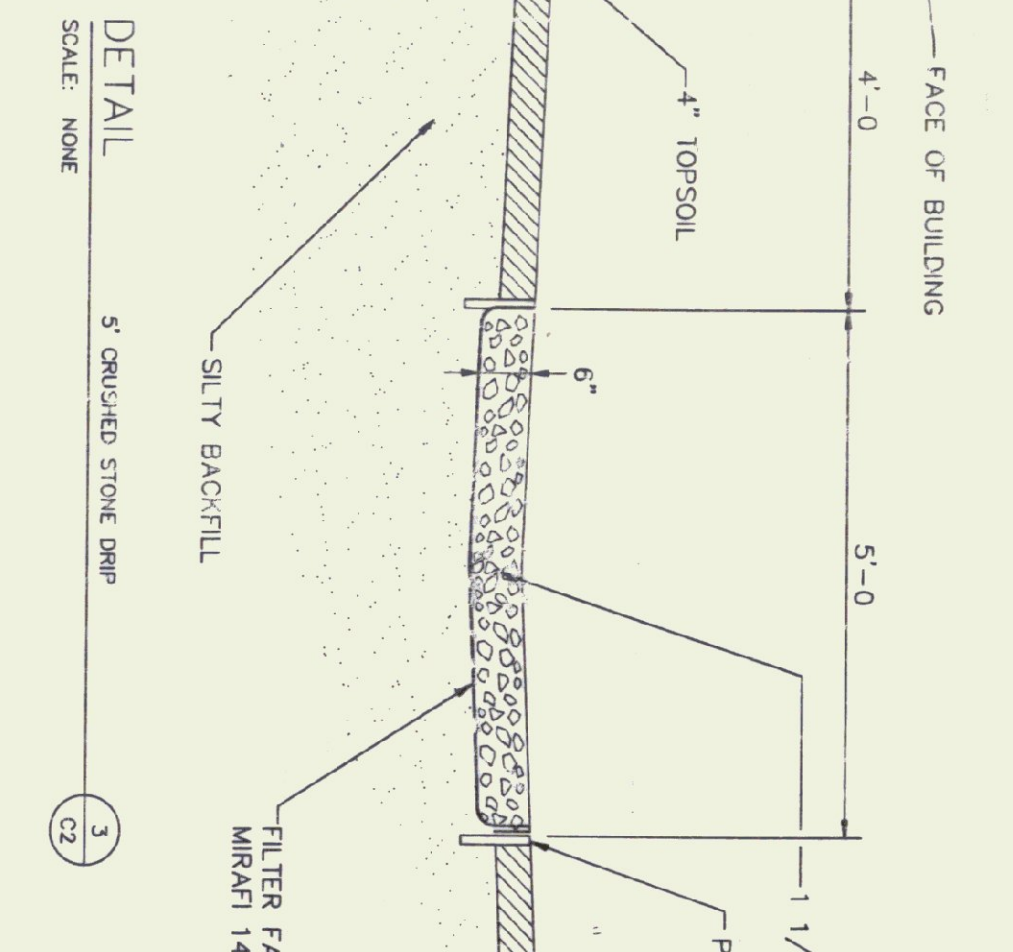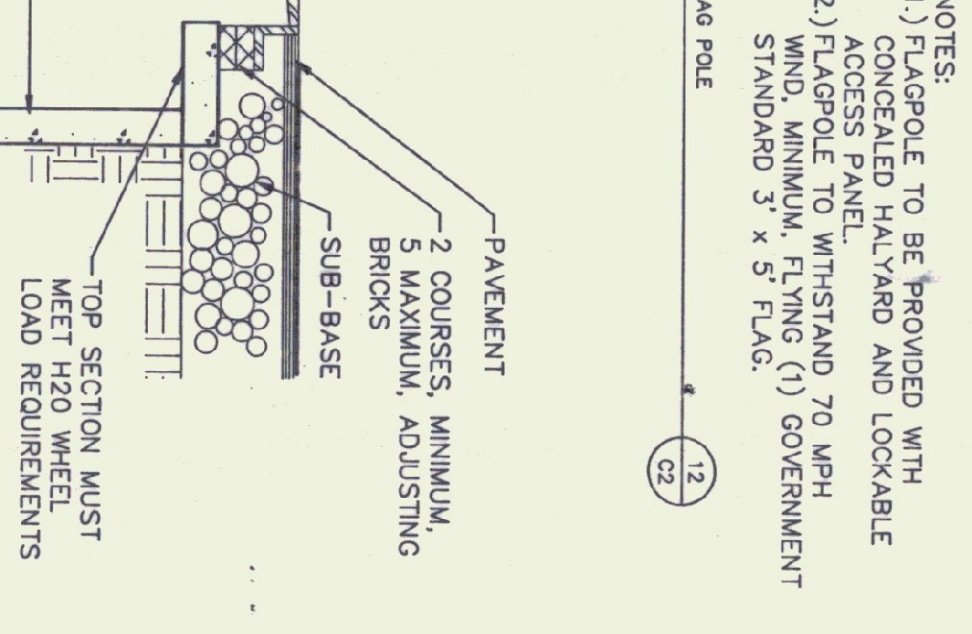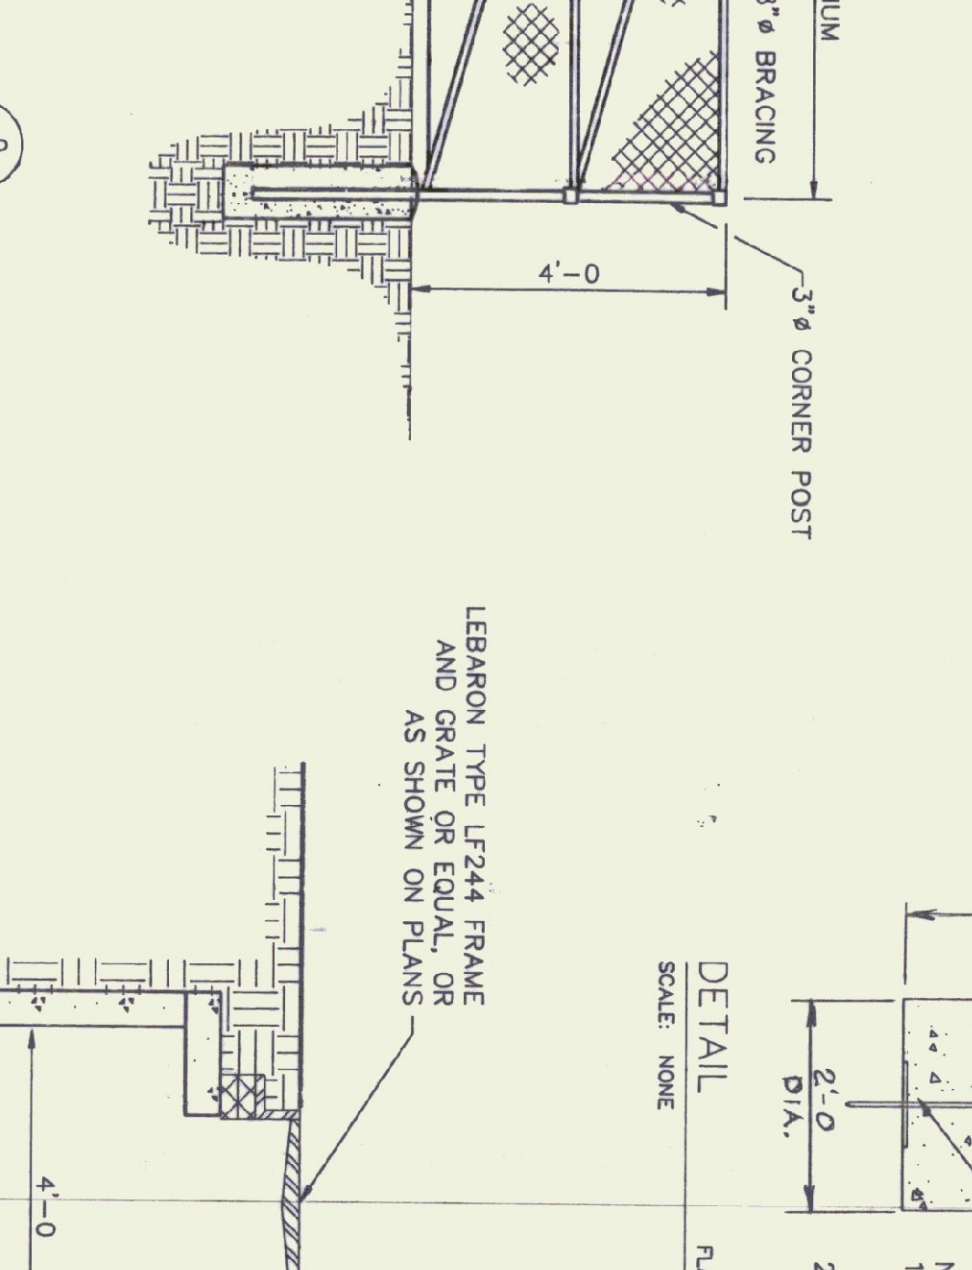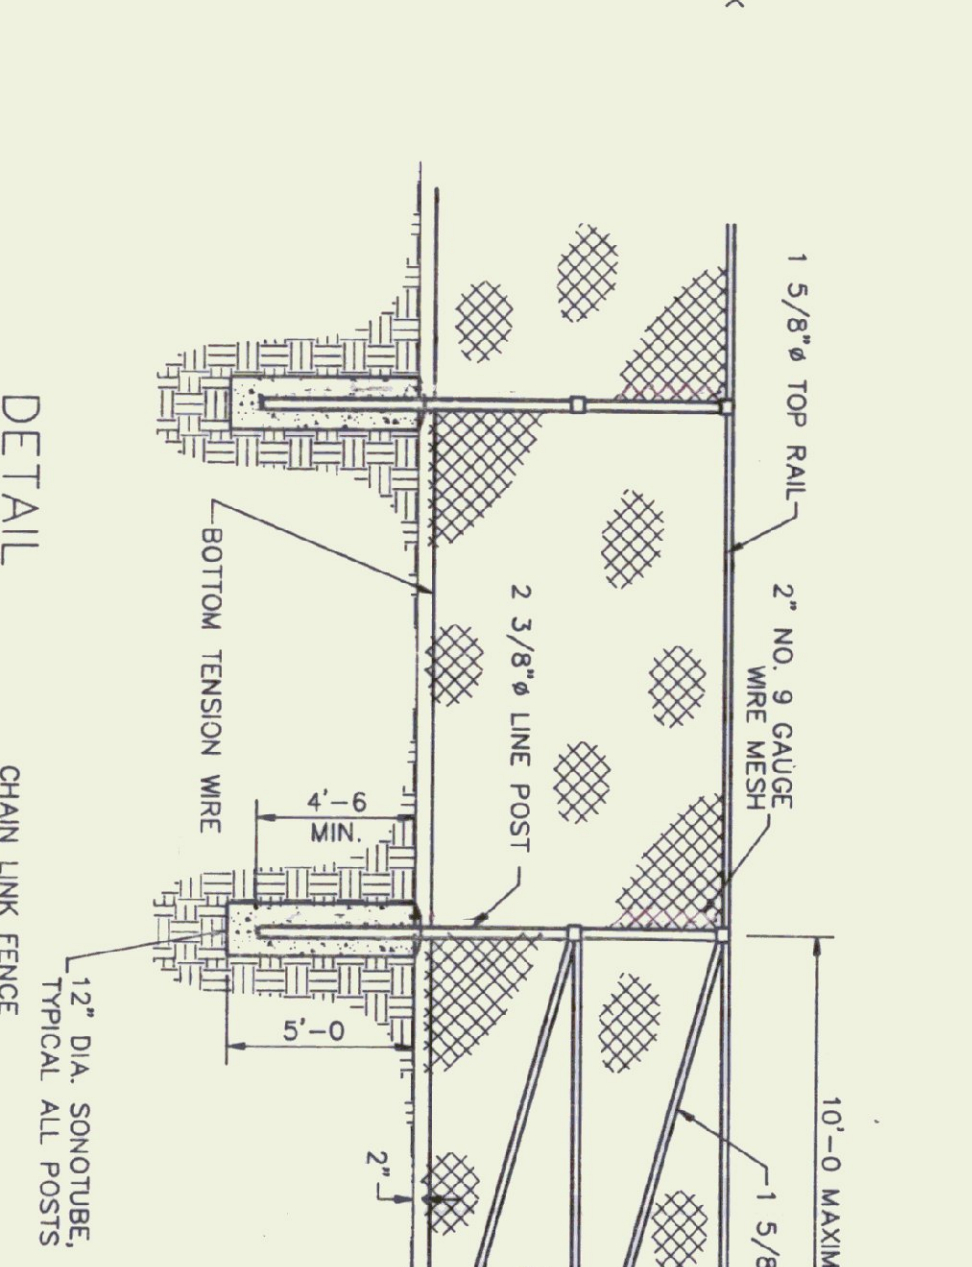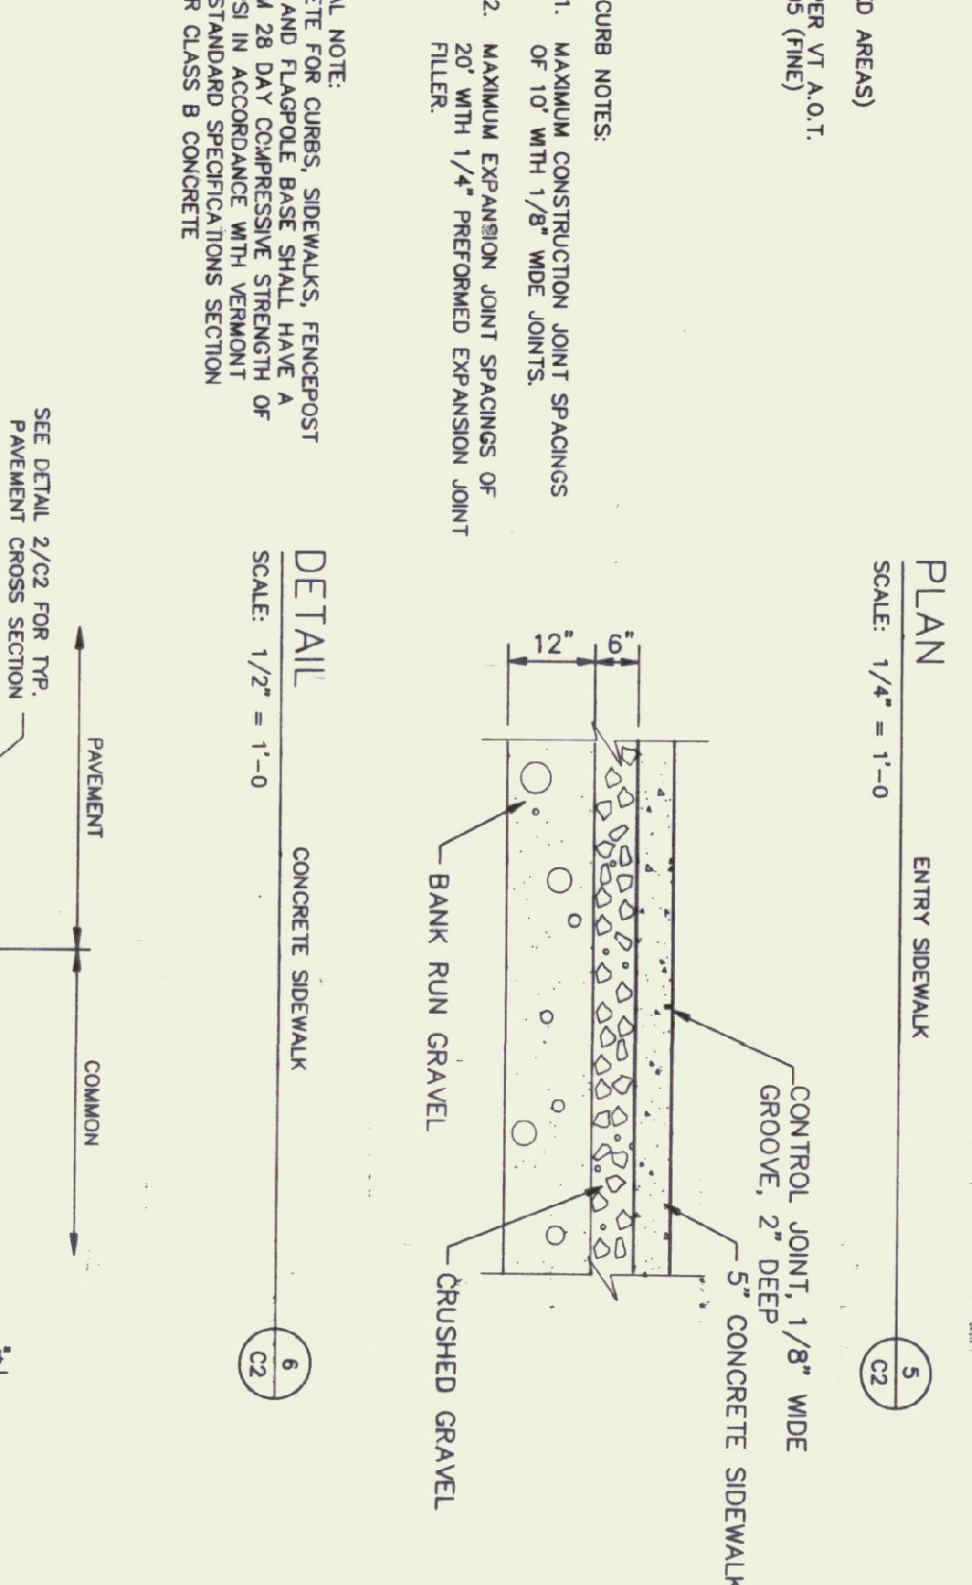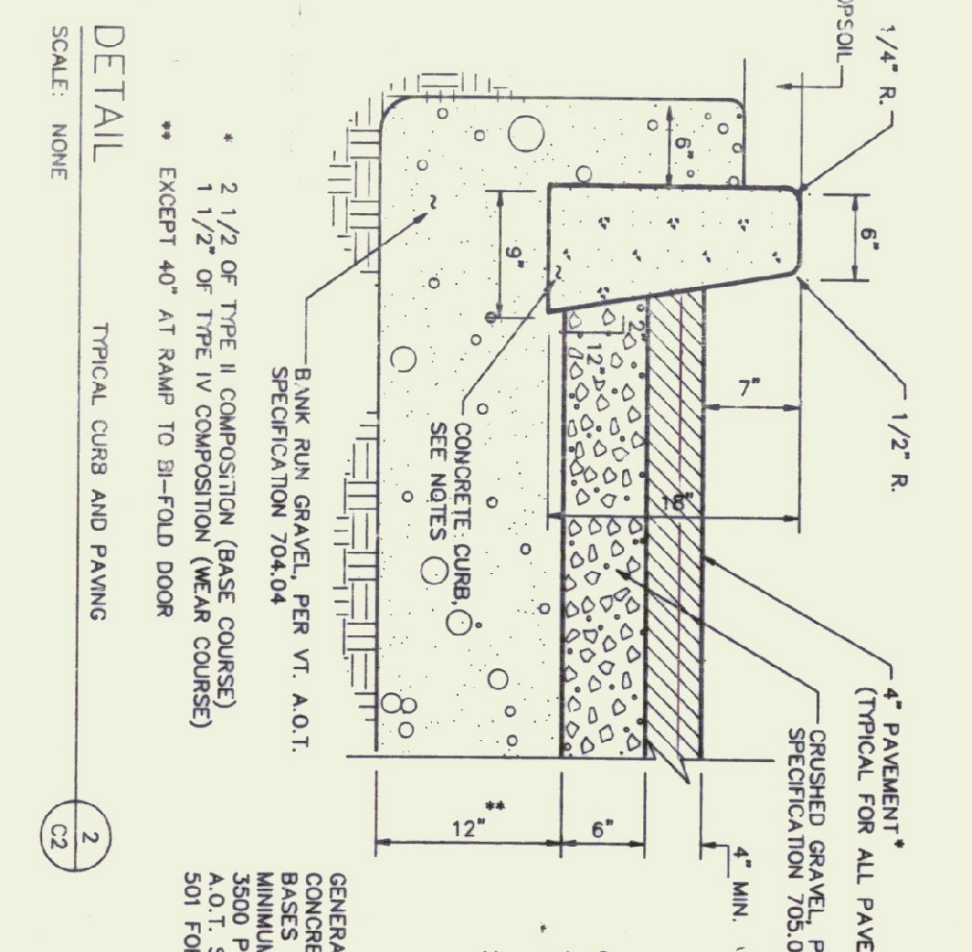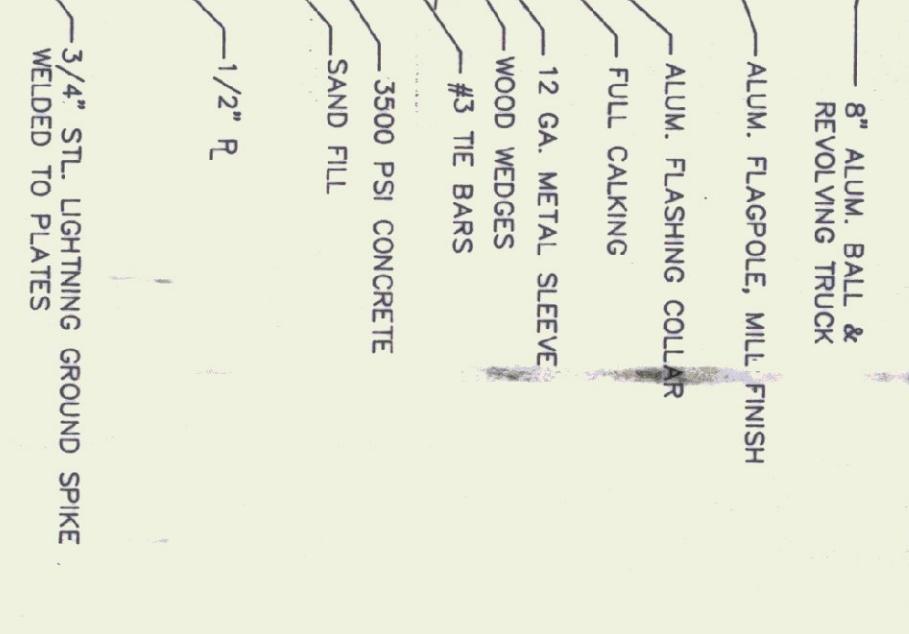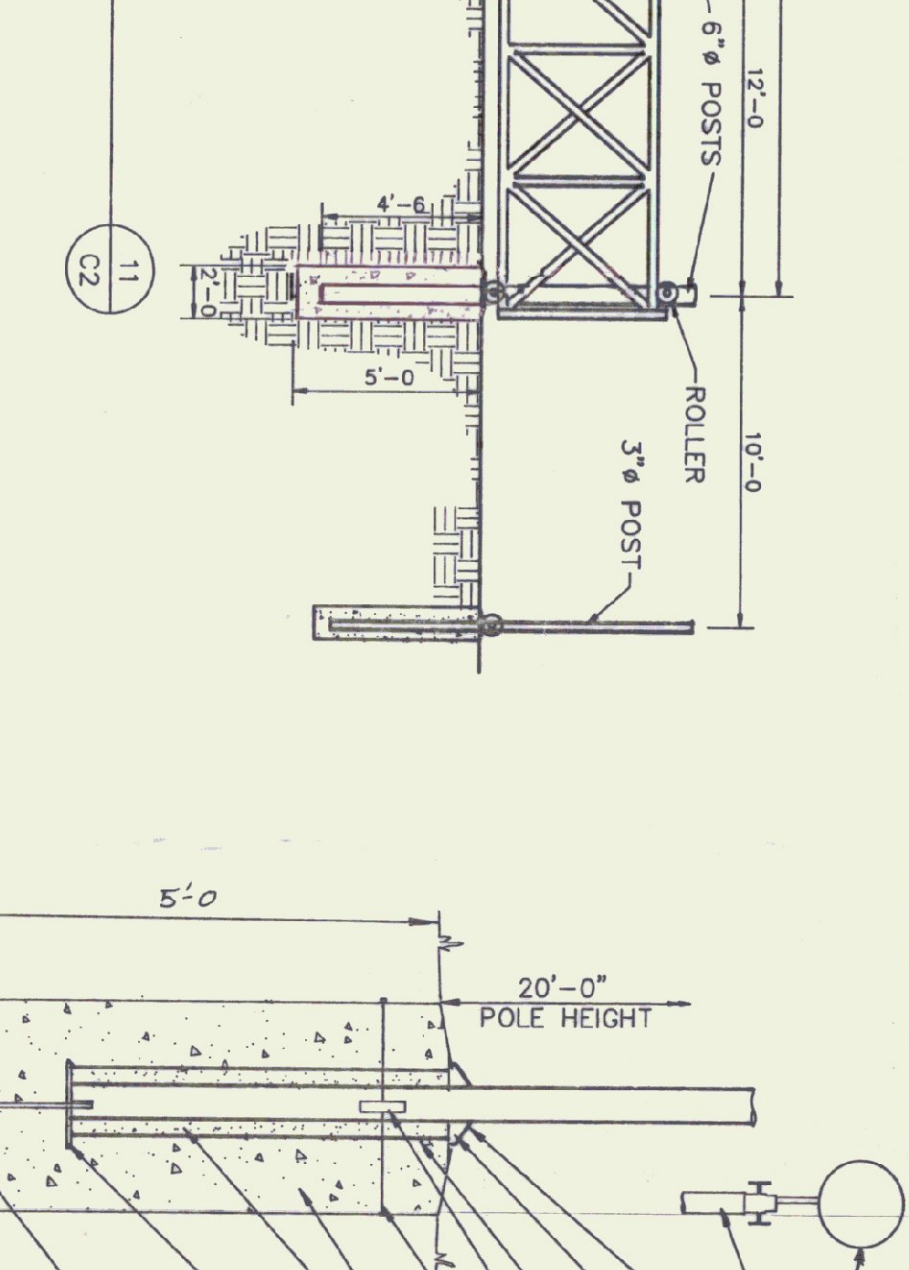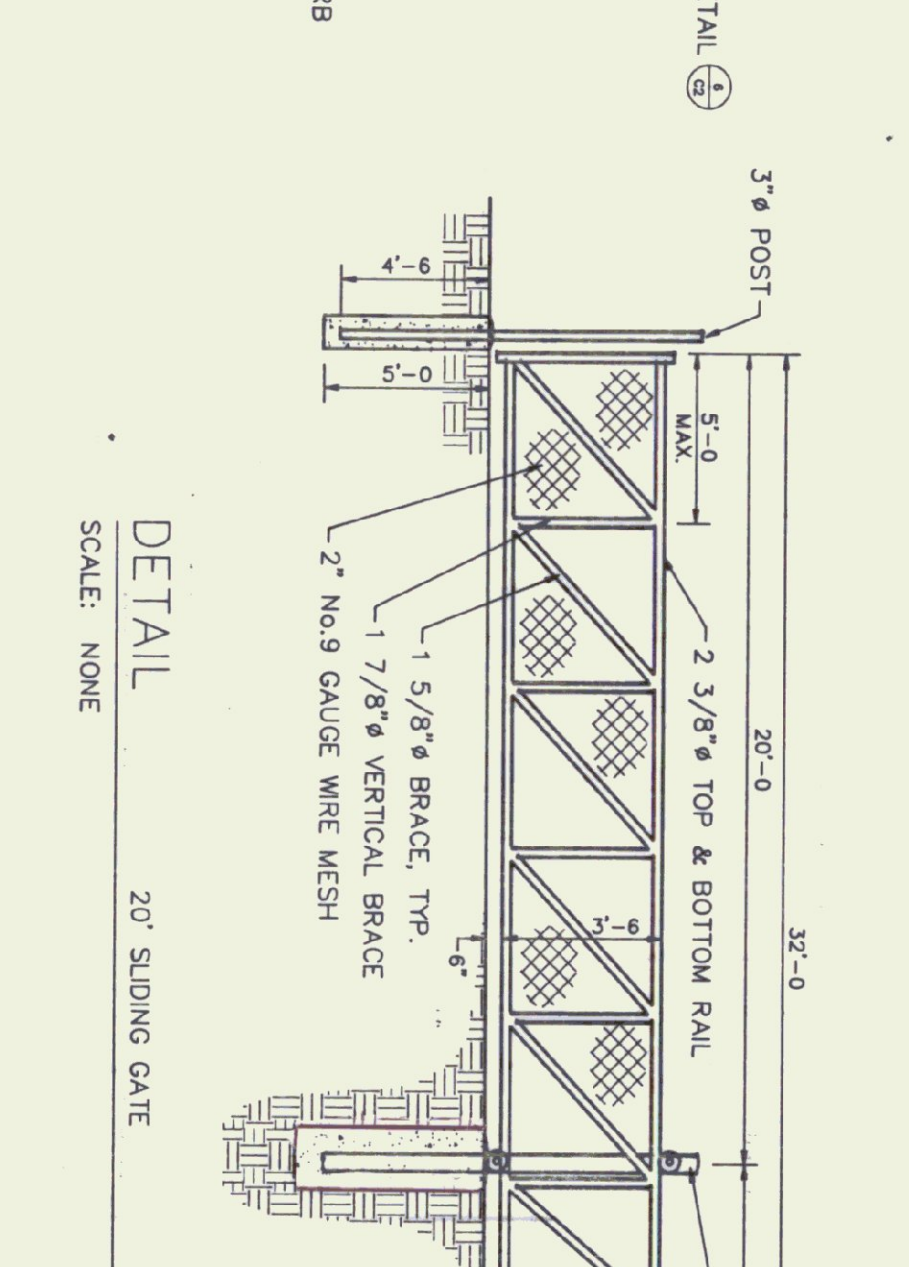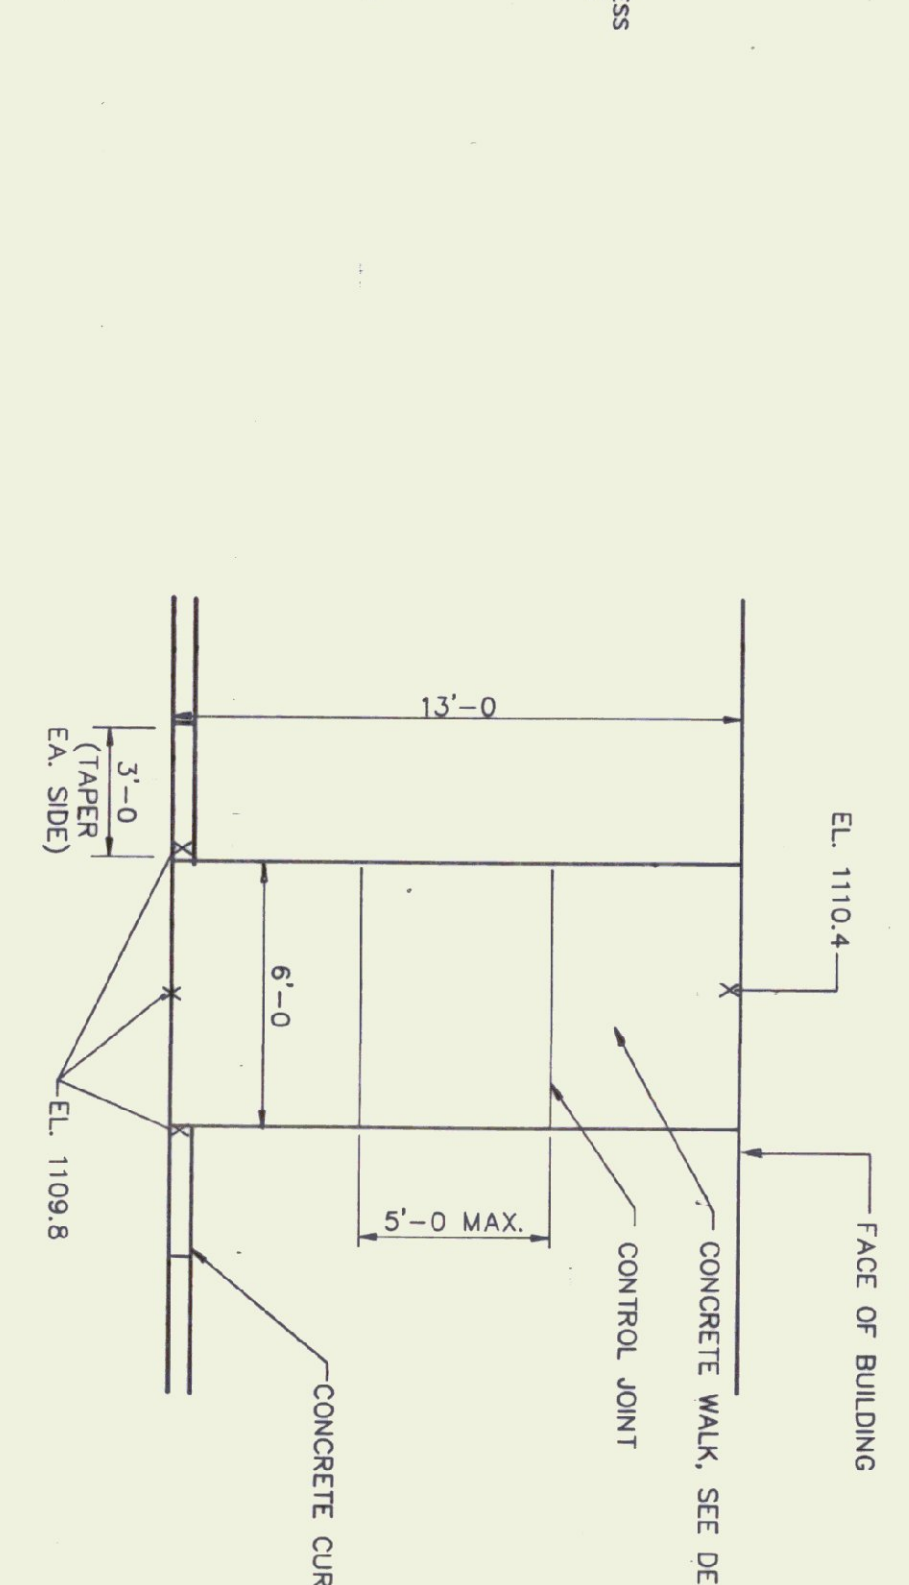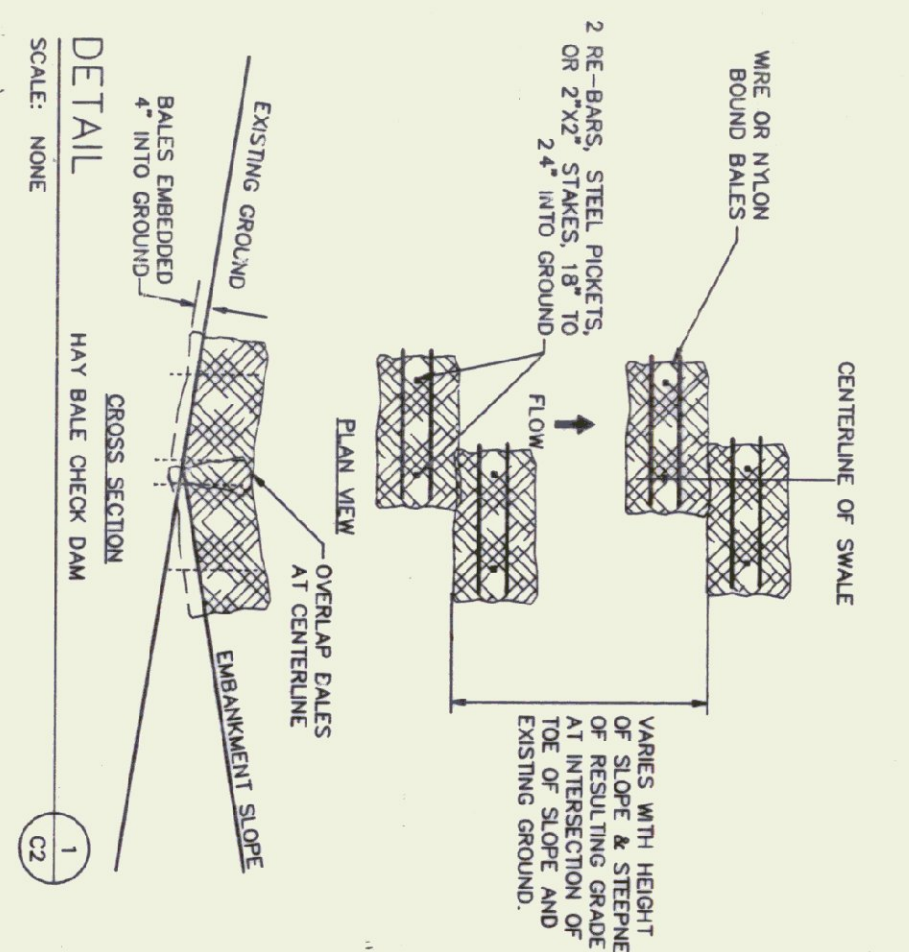

NO.	DATE	REVISION	ENG. DWG.




Provan & Lorber, Inc.
ENGINEERS AND PLANNERS
Home Office: PO Box 389, Colchester, NH 03228 (603) 748-3820
Northern NH Office: PO Box 167, Littleton, NH 03581 (603) 444-6301
Vermont Office: 7 Main St., Montpelier, VT 05602 (802) 229-1442

HUNTINGTON HANGAR
VERMONT AGENCY OF TRANSPORTATION
KNAPP AIRPORT
BERLIN, VERMONT

DATE	PROJ. NO.
SEPT 1996	997.01
ENG. BY MJC	DRAWN BY JUS
CHKD. BY MJC	DRWG. NO. C2




SHEET 2 OF 3

SITE ELECTRIC PLAN
SCALE - 1"=20'

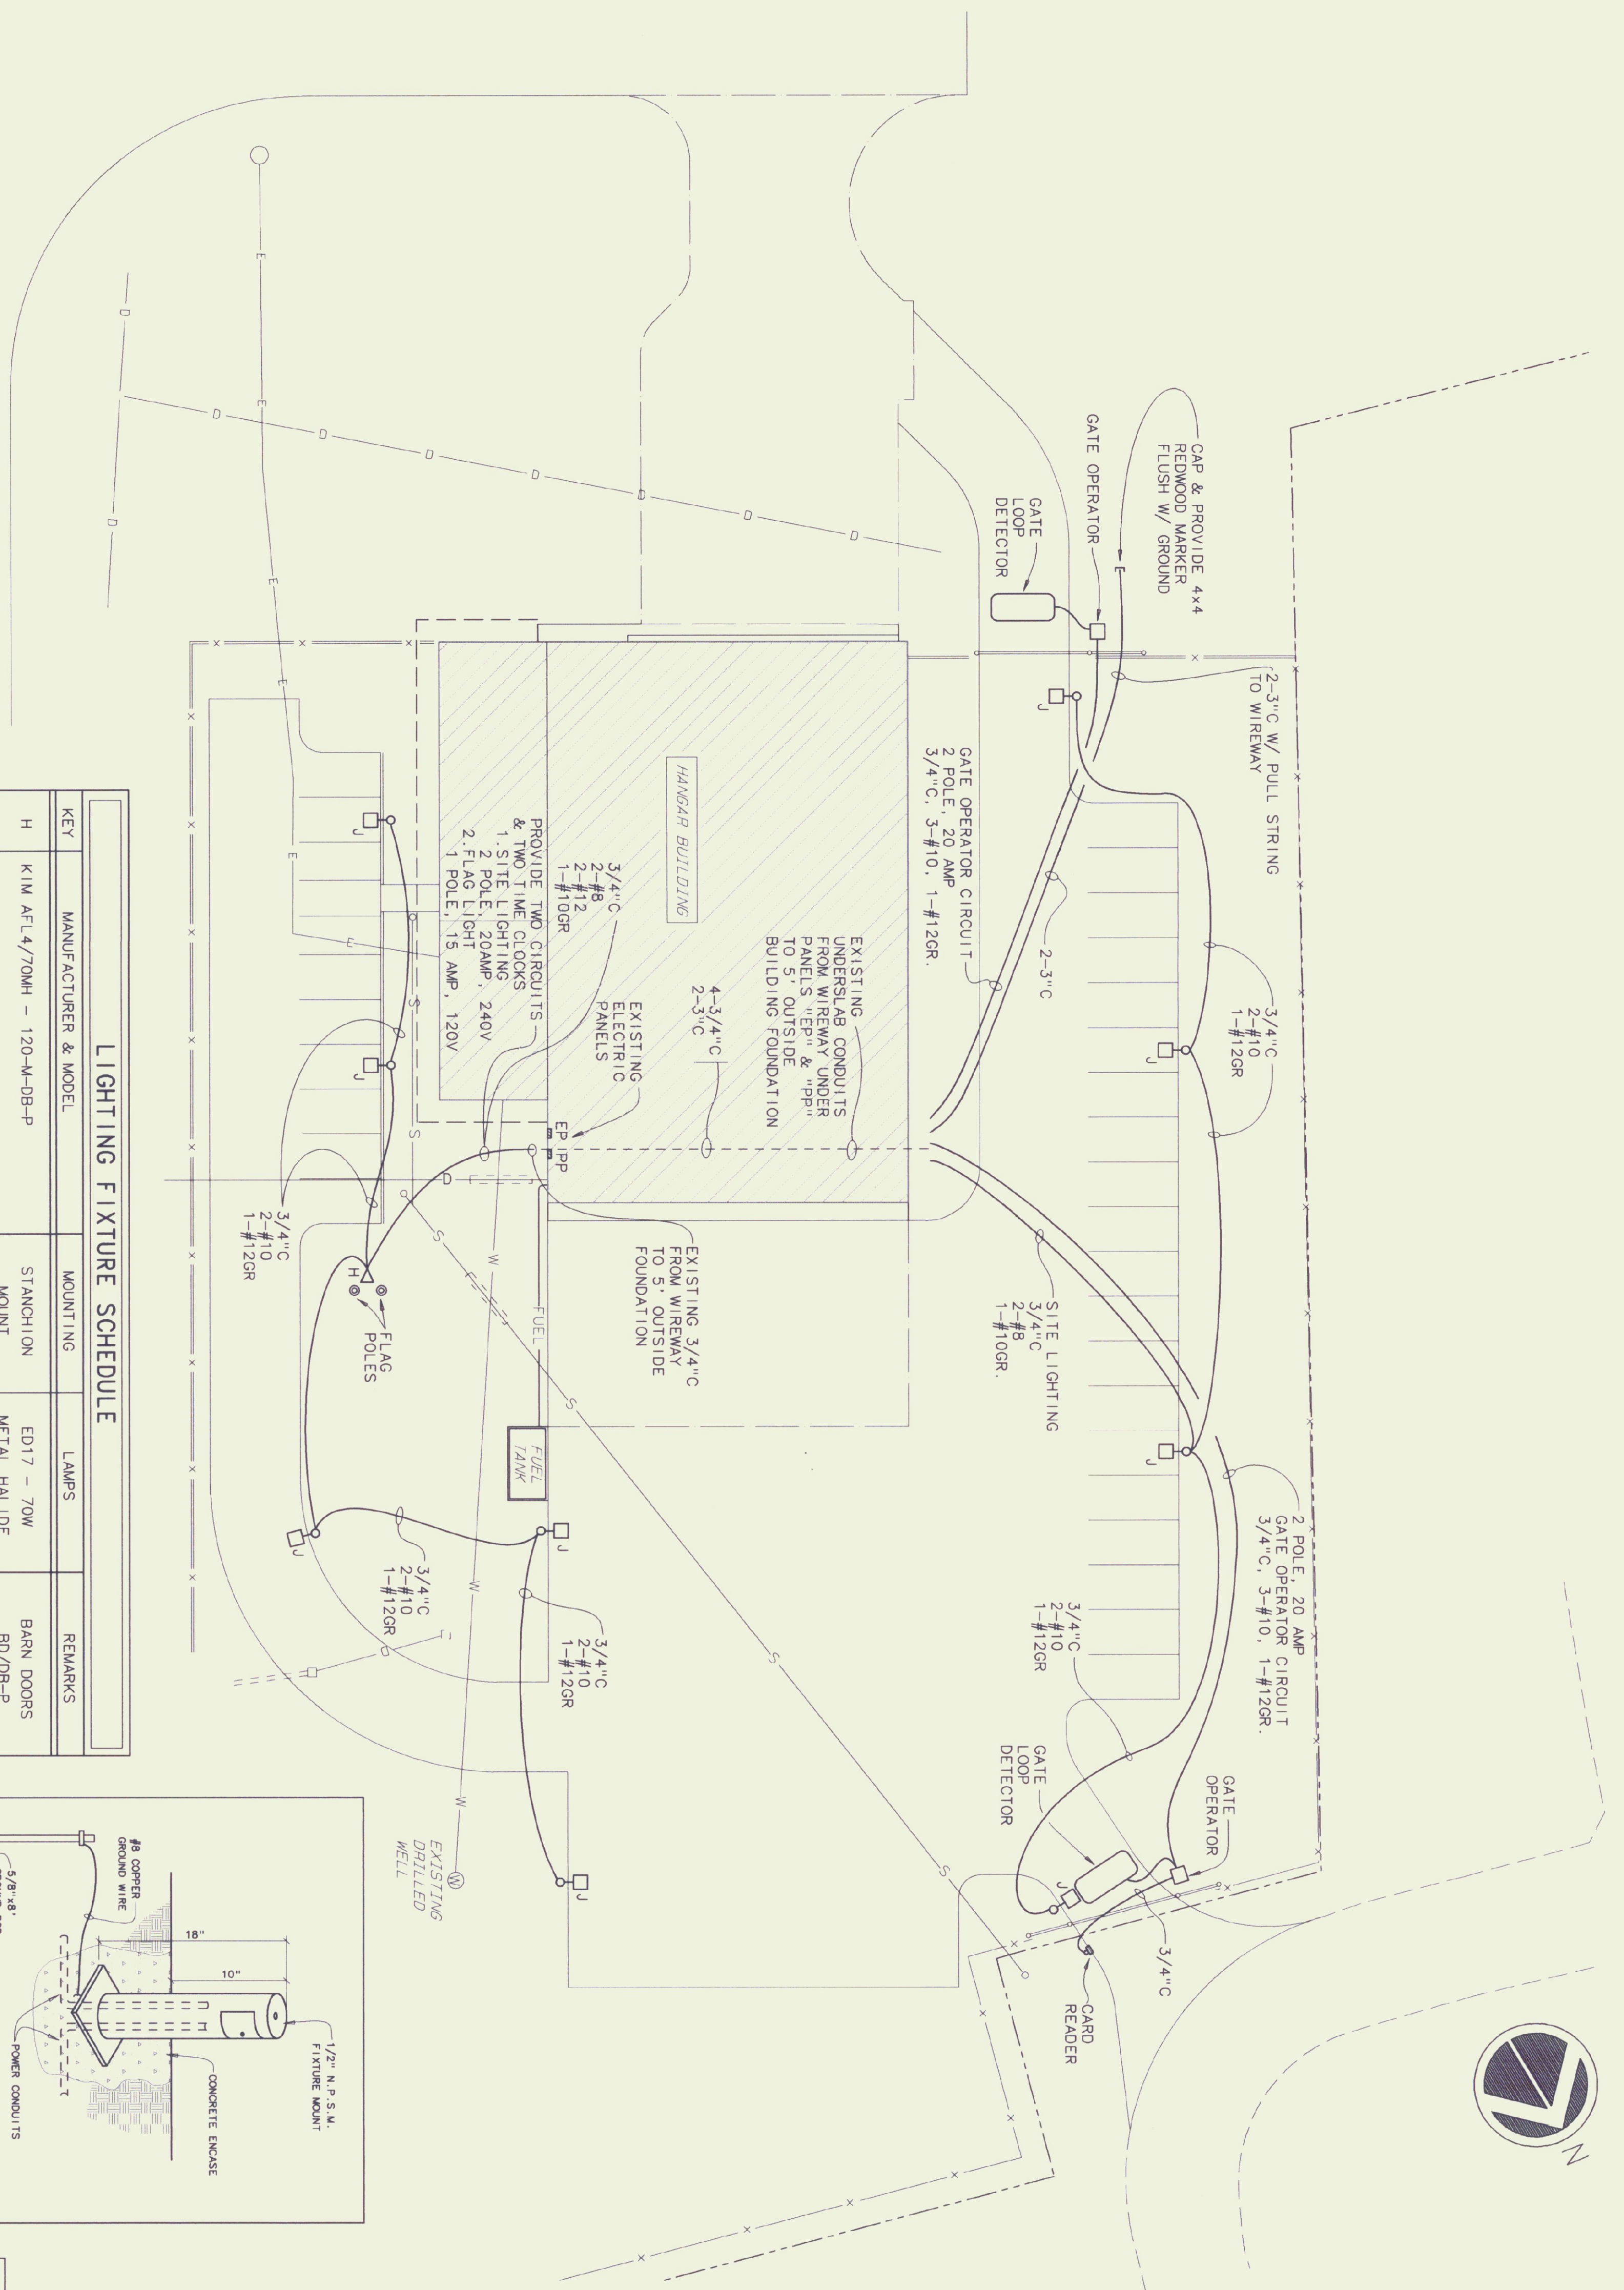

LIGHTING FIXTURE SCHEDULE

KEY	MANUFACTURER & MODEL	MOUNTING	LAMPS	REMARKS
H	KIM AFL4/70MH - 120-M-DB-P	STANCHION MOUNT	ED17 - 70W METAL HALIDE	BARN DOORS BD/DB-P
J	KIM 1A/AR2/150HPS/240 VOLT/DB-P/A25	20' POLE	150W HPS	PHOTOCELL

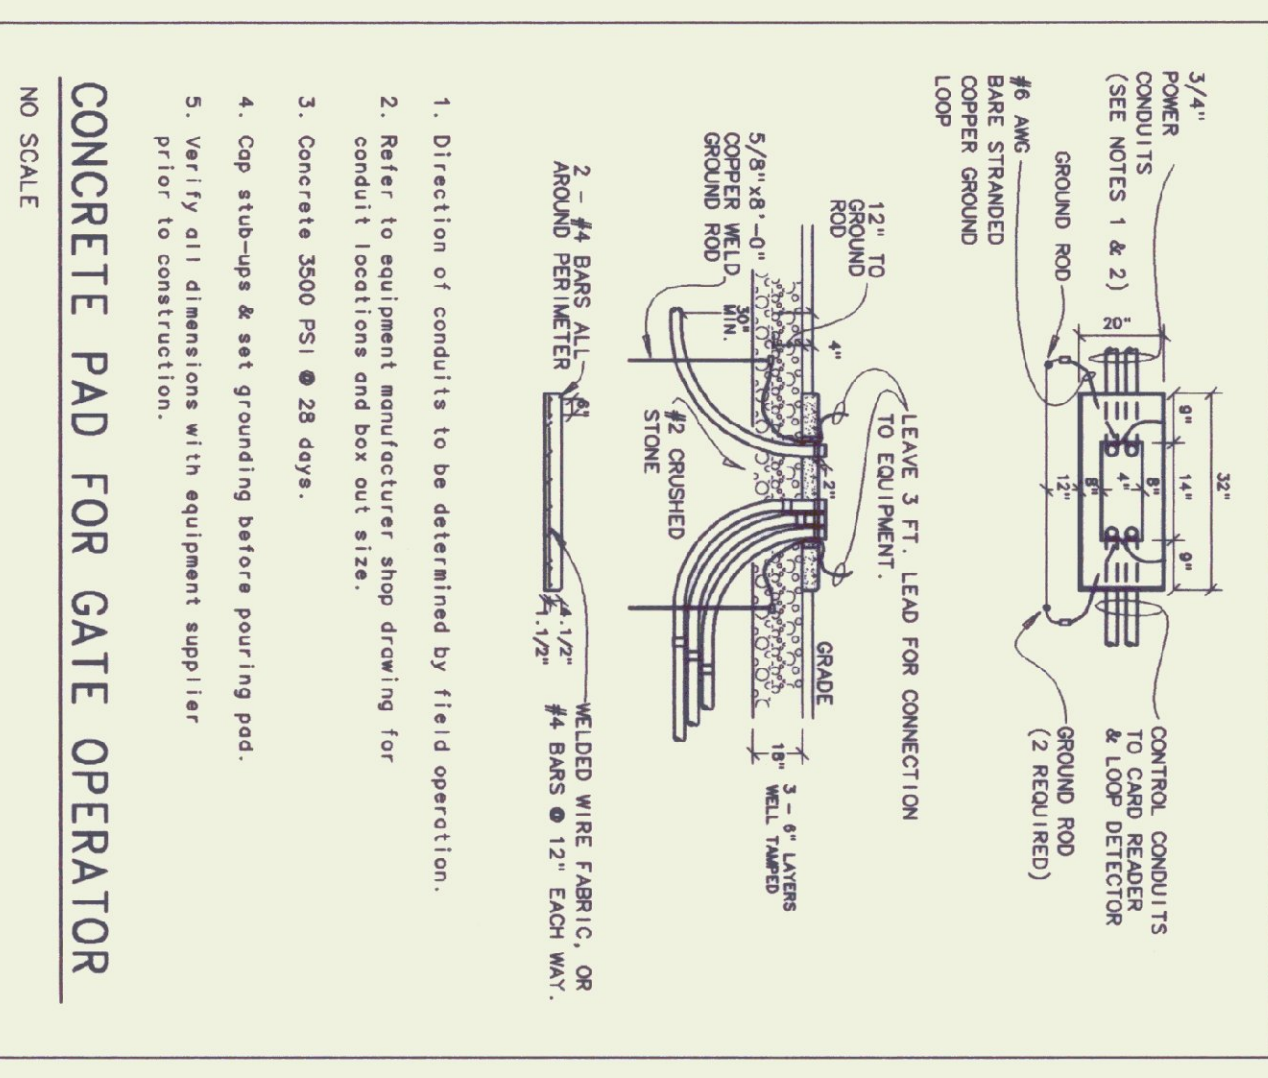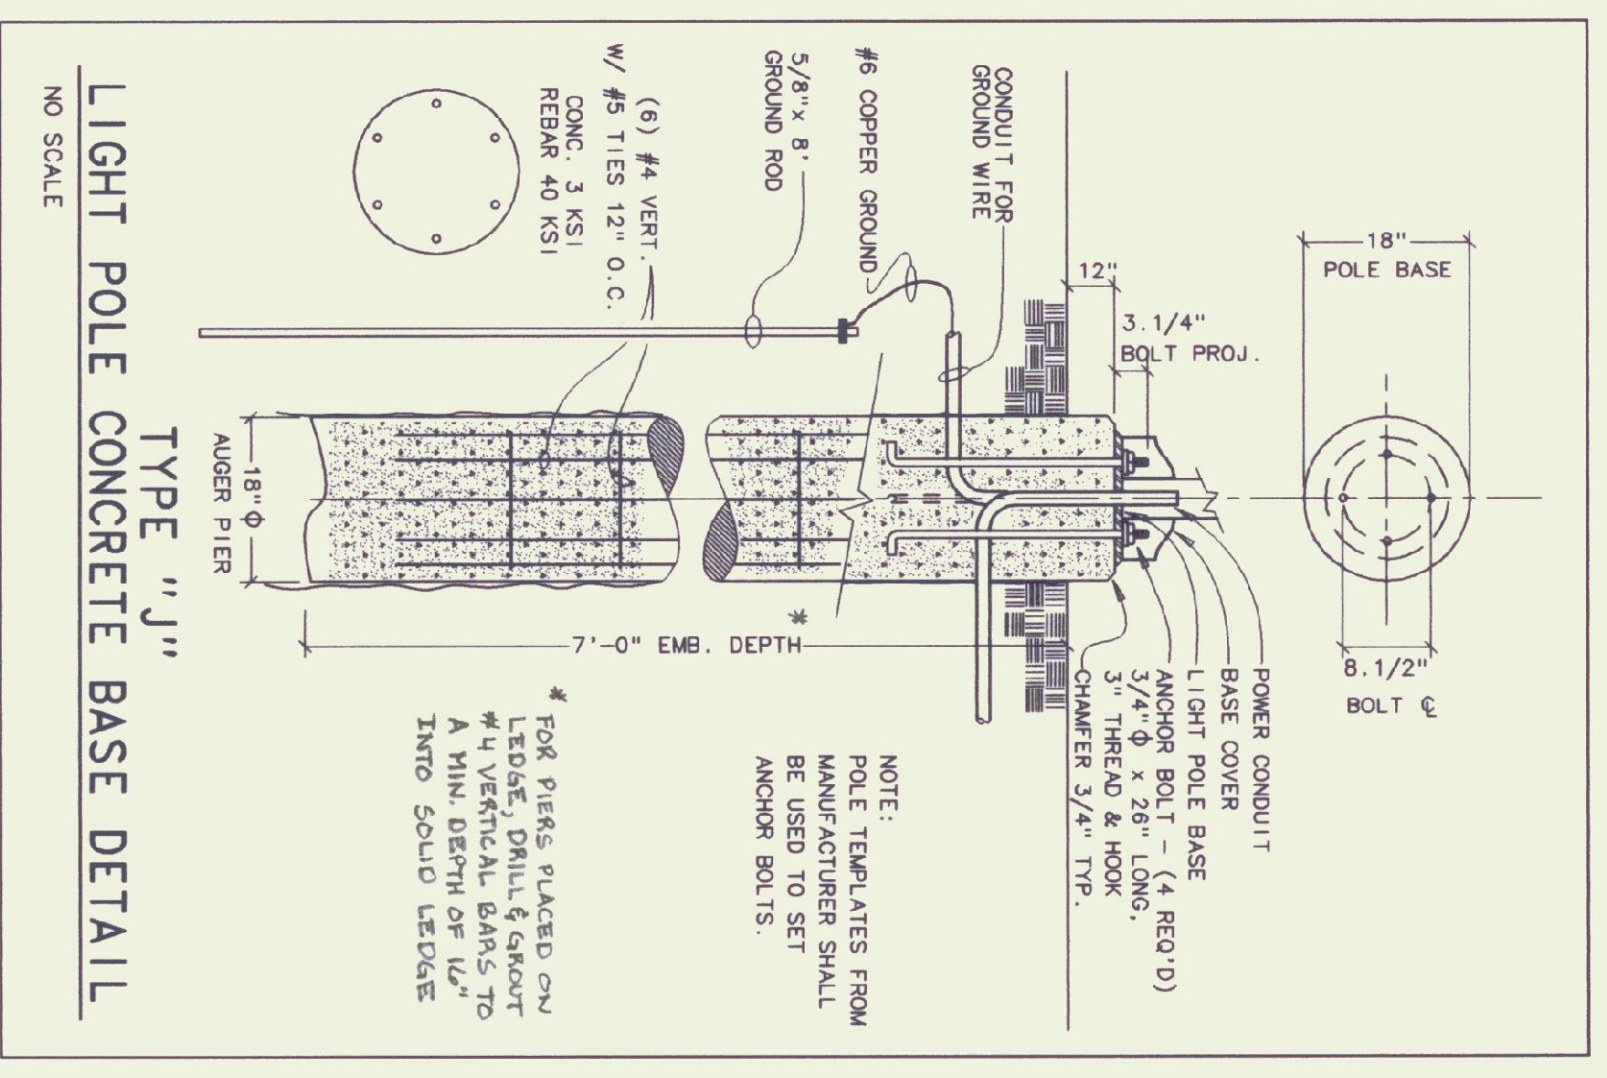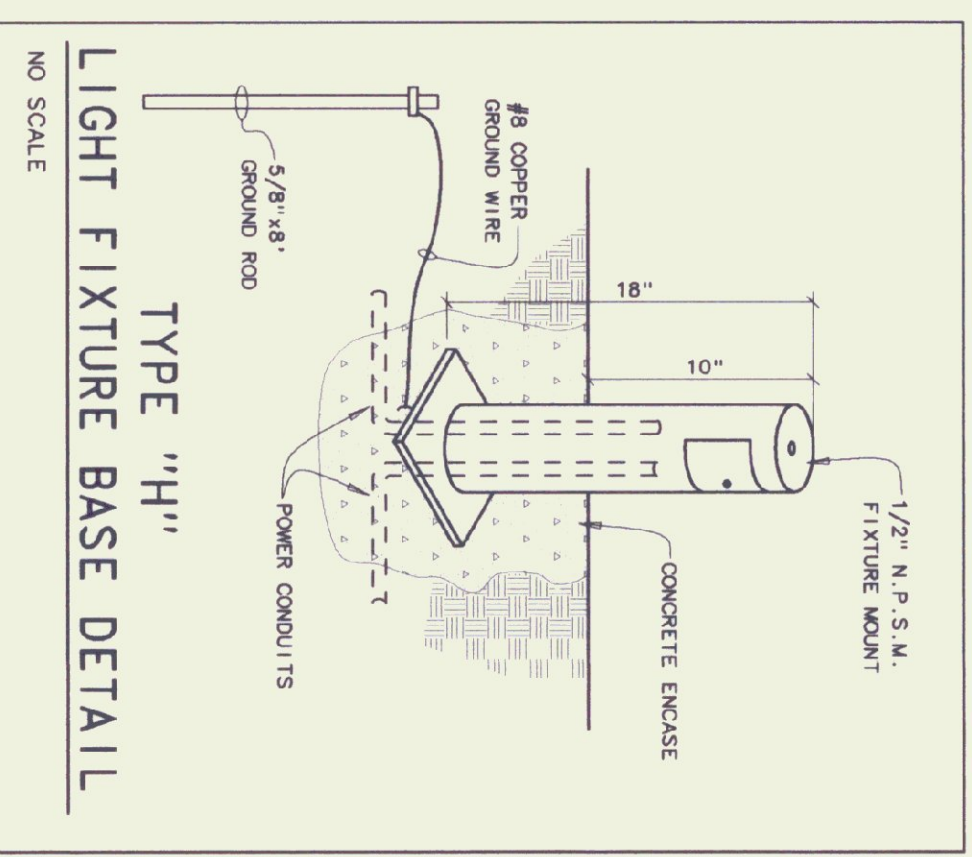

Pearson & Associates
MECHANICAL & ELECTRICAL ENGINEERS

P. O. BOX 610 STOWE, VERMONT 05672
TEL. (802) 253-9607 FAX. (802) 253-9290


Provan & Lorber, Inc.
ENGINEERS & PLANNERS

Base Office: PO Box 309, Contooscook, NH 03229 (603) 746-9220
Northern NH Office: PO Box 187, Littleton, NH 03561 (603) 444-6301
Vermont Office: 7 Main St., Montpelier, VT 05602 (802) 229-1442

STATE OF VERMONT
DEPARTMENT OF ADMINISTRATION
AGENCY OF BUILDINGS AND GENERAL SERVICES
VERMONT

Agency of Transportation
HUNTINGTON HANGER
Berlin, Vermont
SITE ELECTRIC PLAN


DATE: FEB. 1997	SCALE: 1" = 20'	REVISIONS:	CAD FILE: P-HH-SE1	DWG NO.:
DRAWN BY: B.W.M.	APPROVED BY: E.E.P.		SHEET: 3 OF 3	SE-1

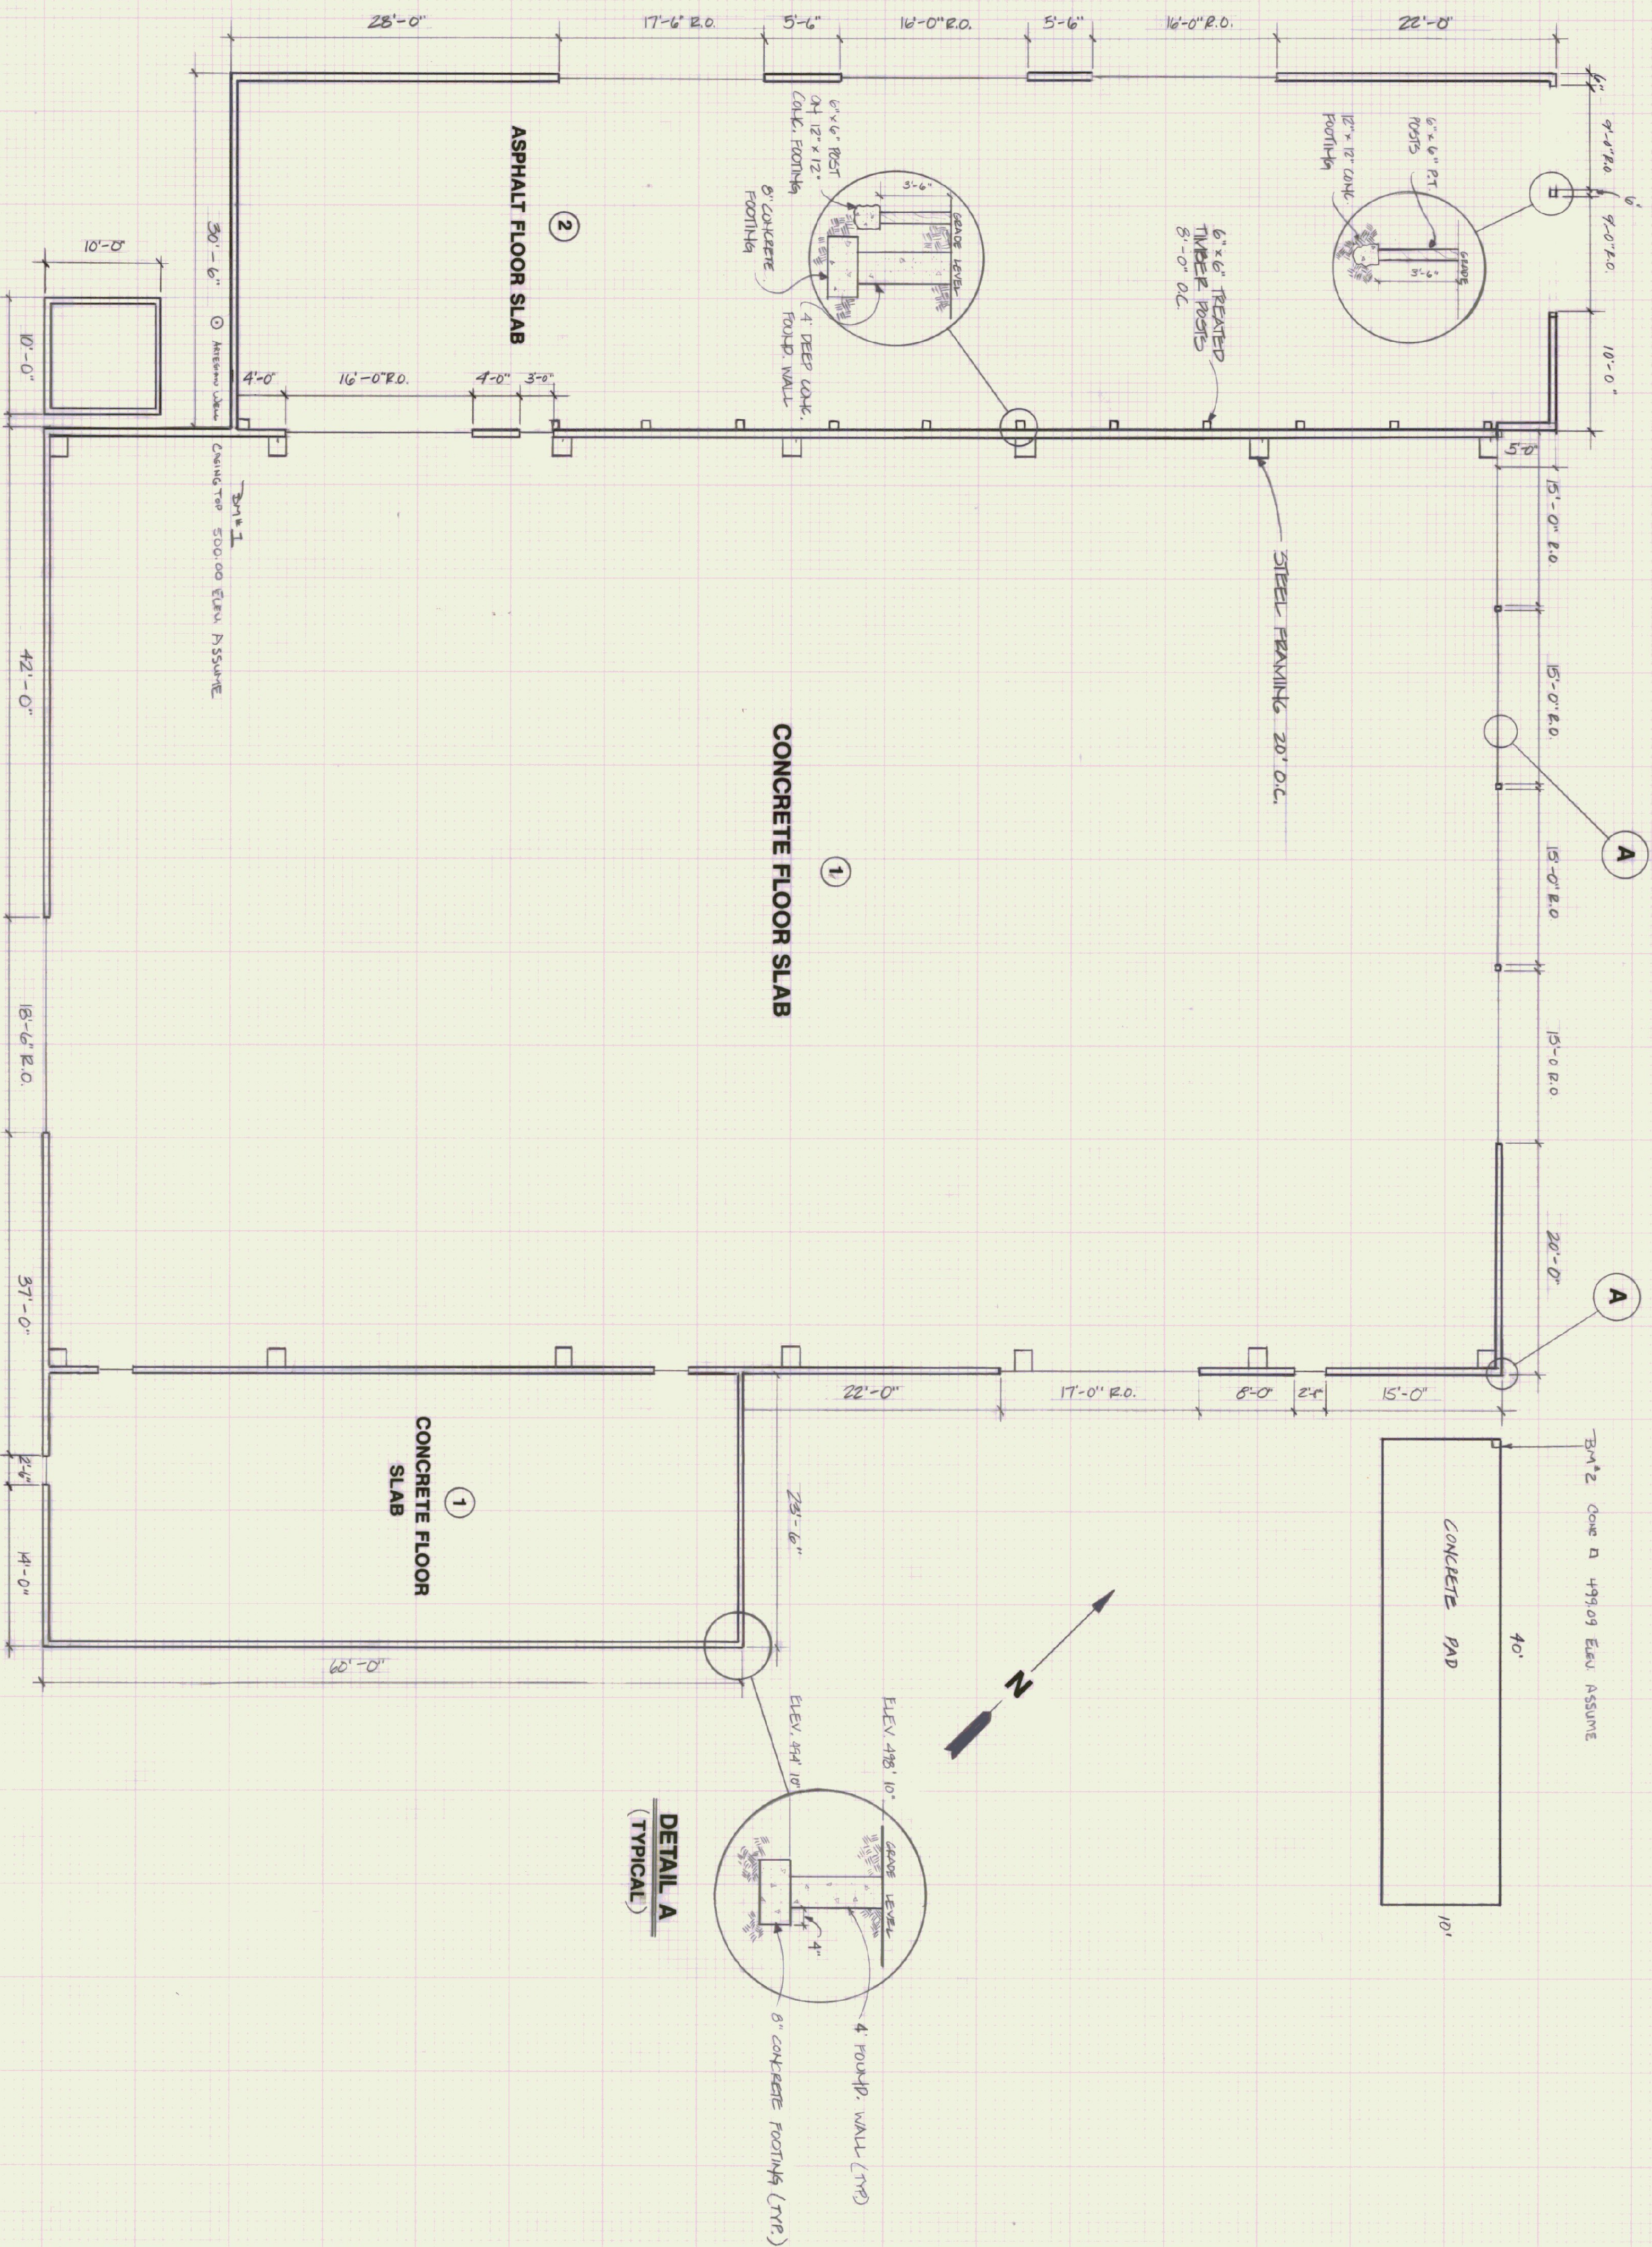


FLOOR PLAN
SCALE 1/8" = 1'-0"

- NOTES :**
- ① BUILDING SUPPORTED BY A 4' DEEP CONCRETE FOUNDATION WALL ON A 8" X 16" CONCRETE FOOTING.
 - ② BAY AREA ROOF SUPPORTED BY 6" X 6" PRESSURE TREATED POSTS RESTING ON A 12" DIA. FOOTING 12" DEEP.

STATE OF VERMONT			
DEPARTMENT OF STATE BUILDINGS			
AGENCY OF ADMINISTRATION			
MONTPELIER, VERMONT			
AGENCY OF TRANSPORTATION PROPERTY			
FORMER HUNTINGTON HOMES SITE			
DATE	SCALE	REVISIONS	DWG. NO.
7/12/89	1/8" = 1'-0"		S-1
DRAWN BY: B. McAVOY	APPROVED BY: F.R.		1 OF 1

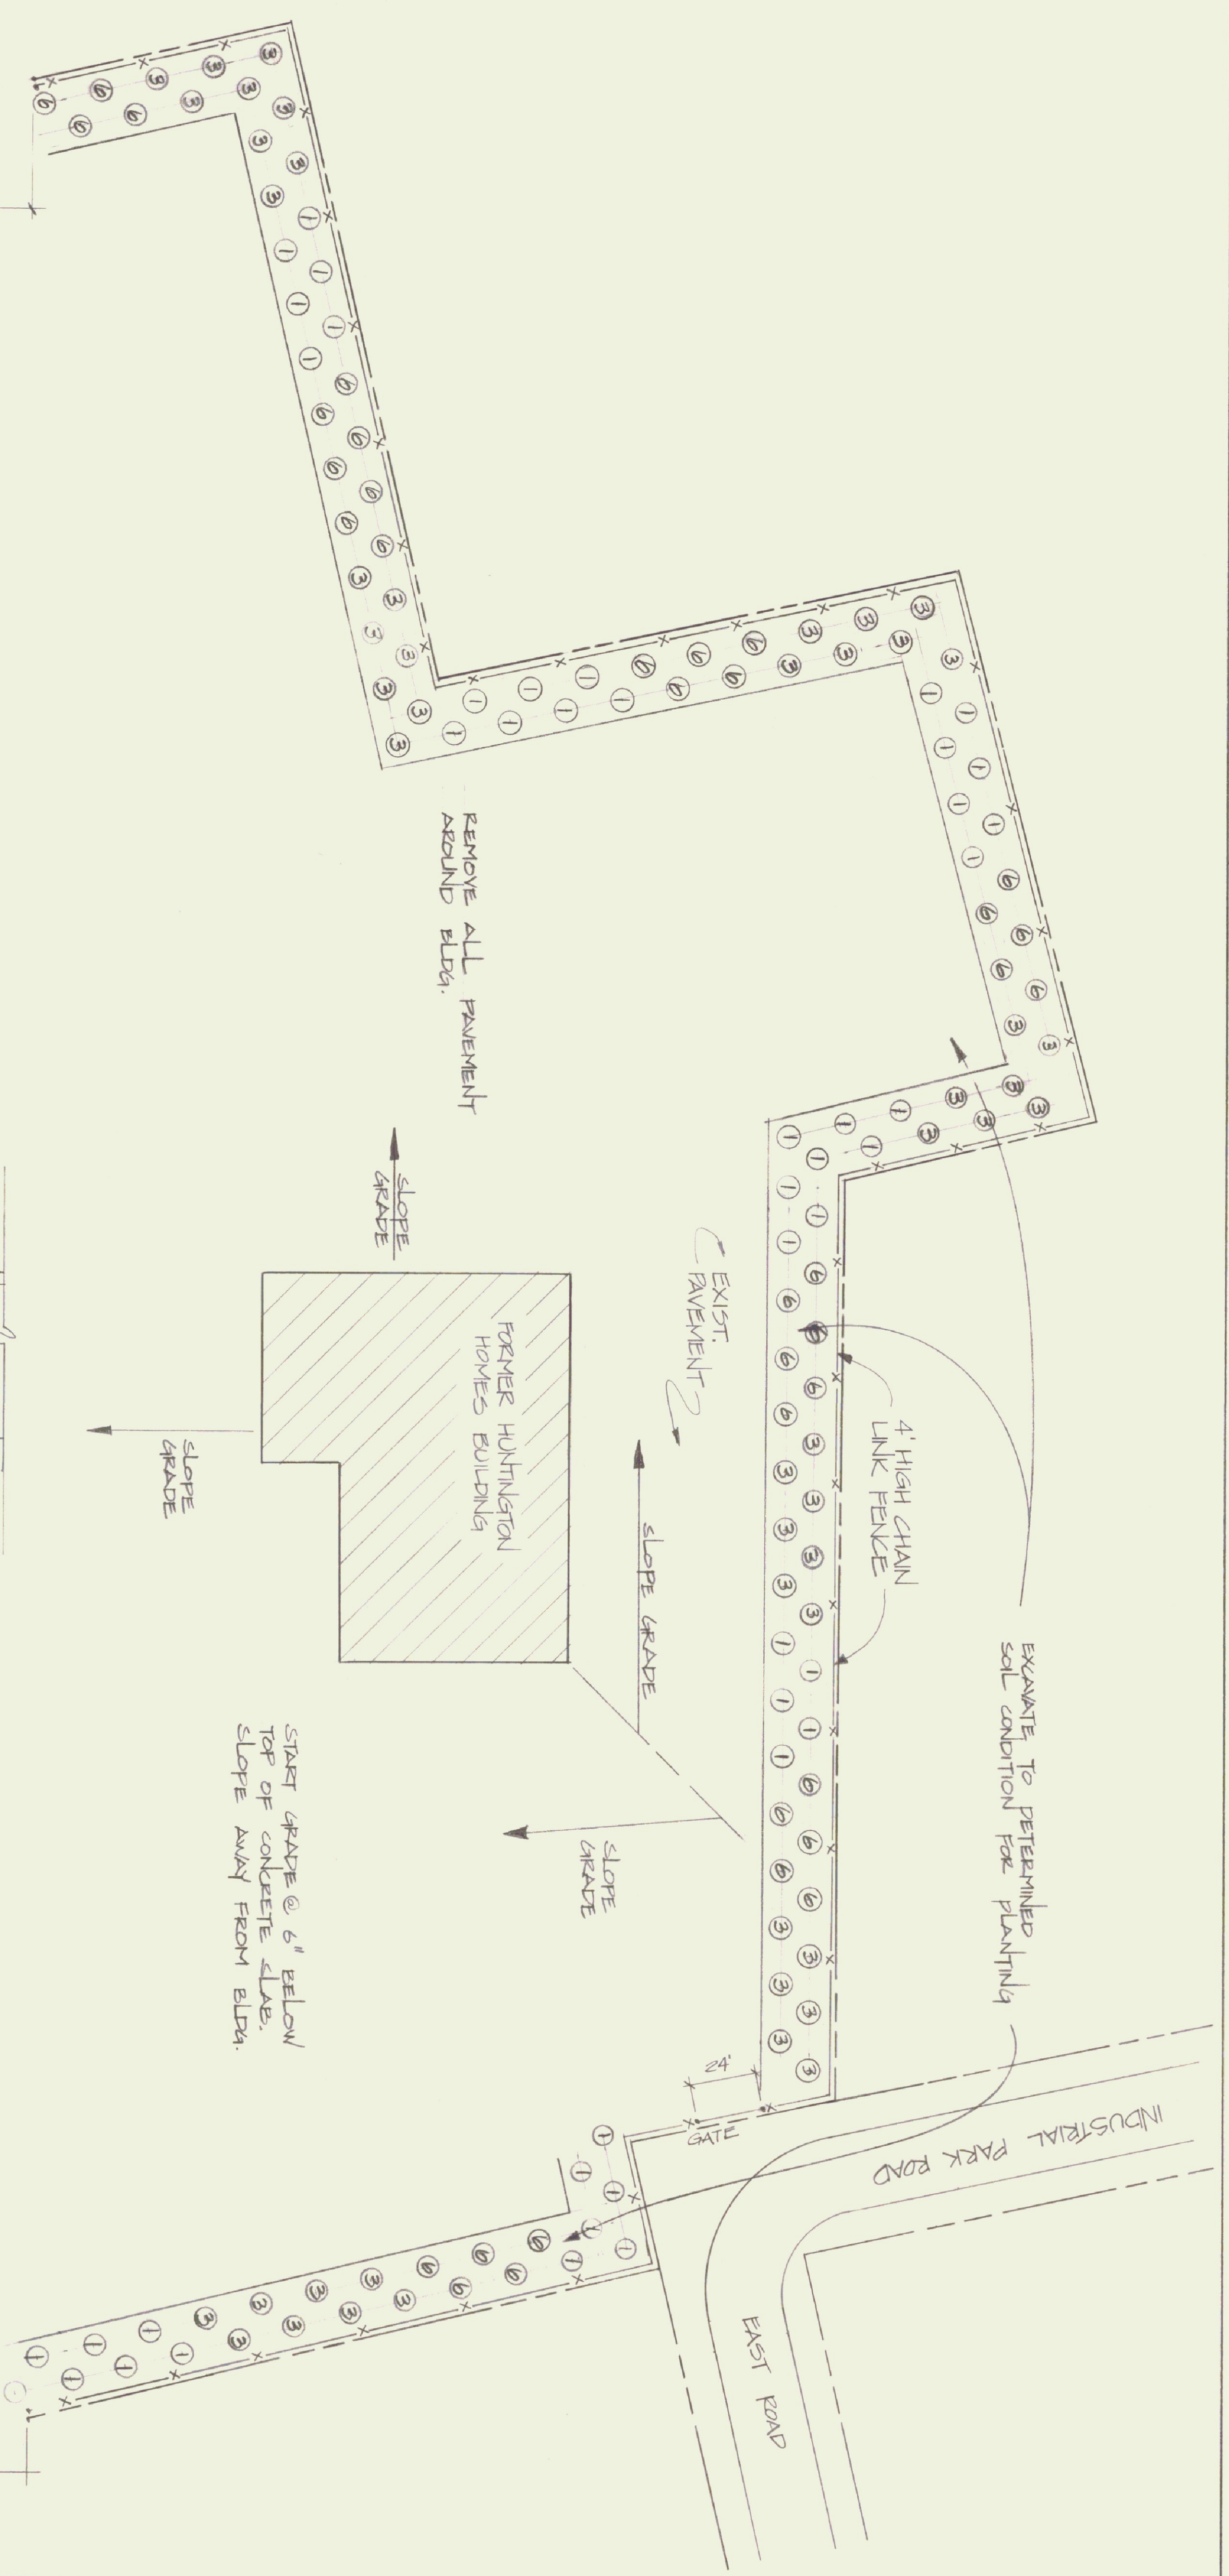

KEY	QTY	COMMON NAME
①	9	AUSTRIAN FINE
③	7	BALSAM FIR
⑥	7	WHITE SPRUCE

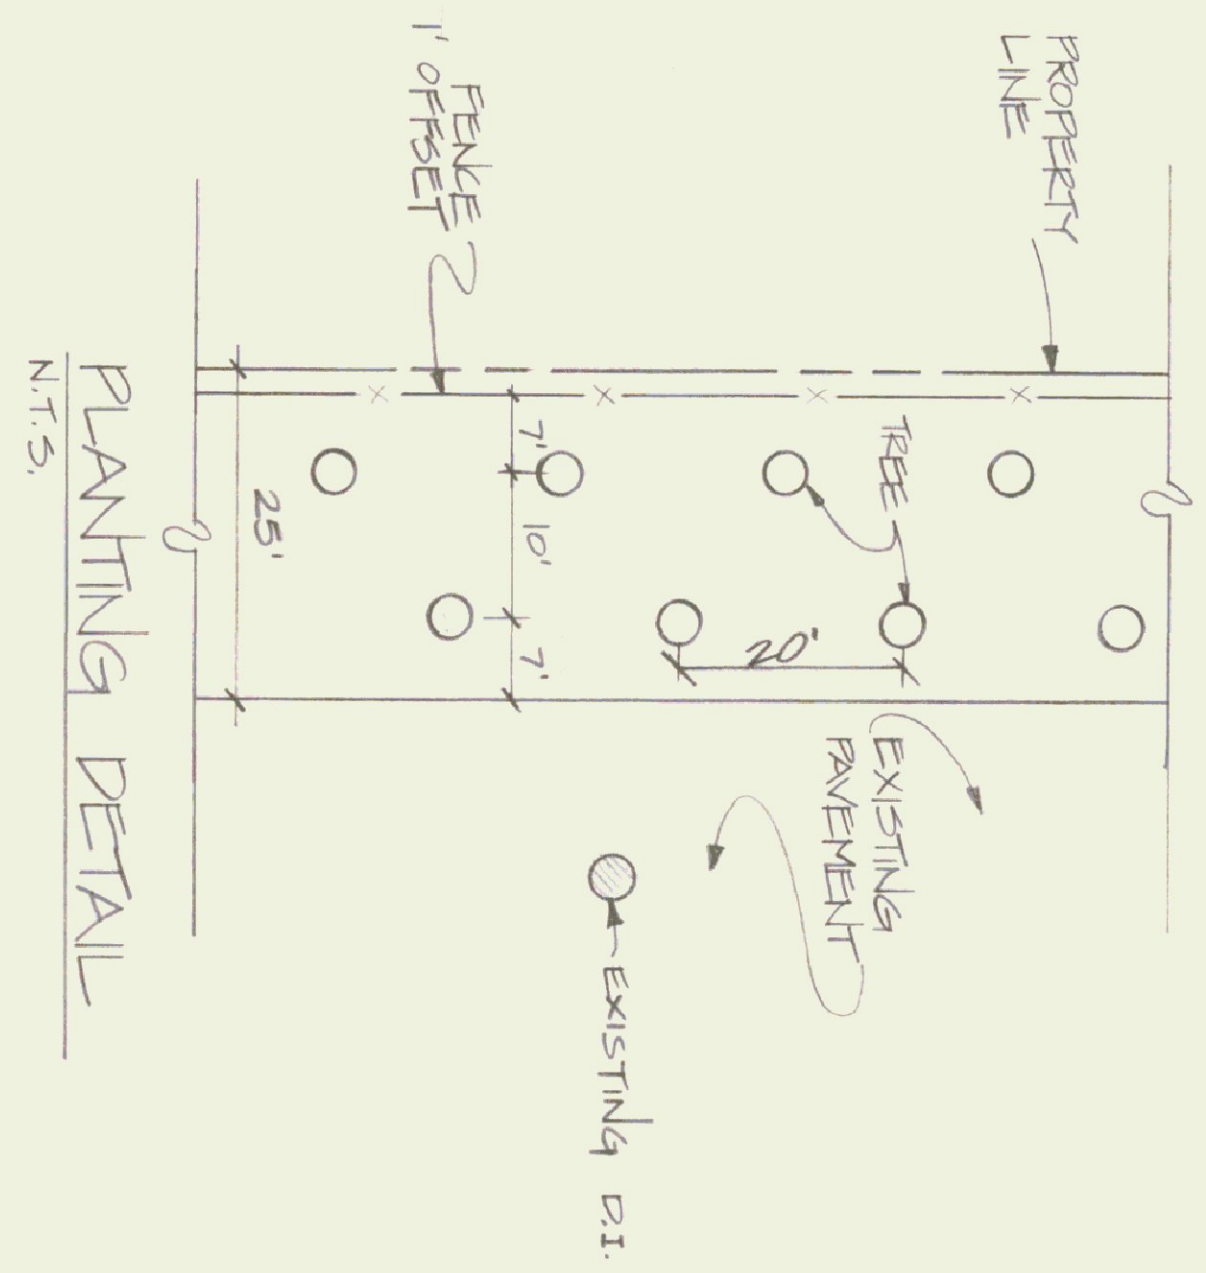

RUNWAY 5/23

STATE OF VERMONT
DEPARTMENT OF STATE BUILDINGS
AGENCY OF ADMINISTRATION
MONTPELIER, VERMONT

**FORMER HUNTINGTON HOMES PROPERTY
EDWARD F. KNAPP STATE AIRPORT
LANDSCAPING PLAN**

BERLIN, VERMONT

DATE	SCALE	REVISIONS	DWG NO.
SEPT. 1990	1" = 40'-0"	7/17/91: u.a. 12/4/95 AVP	5-1
DRAWN BY: B. McAVOY	APPROVED BY: [Signature]		1 OF 1