

**NOTE - GEN CONTRACTOR**  
 PROVIDE FINISH GRADING AROUND BOILER HOUSE UNDERGROUND STORAGE TANK AND ANY OTHER AREAS DISTURBED BY FROM DRAINING COURSE. CONTRACTOR SHALL PROVIDE STORAGE TANK TOWARD EXISTING BROOK.

**GC**  
 PROVIDE CONCRETE PAD 3' LARGER THAN COMPRESSOR UNIT. ALL AROUND RELOCATE COMPRESSOR UNIT FROM MAIN HOLES. DISCONNECT EXISTING FLOW DAMPERS, ETC. PAD TO BE 3" THICK MOUNT DISCONNECT ON 3/4" GID PLYWOOD PAINTED GRAY ALL AROUND. SIZE SUFFICIENT FOR CONTROLS.

COMBUSTION AIR INTAKE  
 SEE DETAIL DWG N-2  
 SHEET 2 OF 2

FIN-TUBE RADIATION-GRU SUPPLY & RETURN PIPES SHALL BE 1/2" DIA. FIN-TUBE RADIATION SHALL HAVE FINNS AND FINNS SHALL BE CONTIGUOUS.


ZONE 4 THERMOSTAT TO BE PLACED ON PARTITION IN SHOP FOREMAN'S OFFICE.

CONTRACTOR SHALL CUT EXISTING WALLS AS NECESSARY FOR PROPER INSTALLATION OF FIN-TUBE RADIATION.

MAINTAIN EXISTING C.W.S. PIPES TO EXIST SERVICE SINK

CONTRACTOR SHALL REMOVE EXIST. H.W. HEATER AND APPURTENANCES. HEATER TO REMAIN THE PROPERTY OF OWNER.

PROVIDE MANUAL AIR VENT-ON END OF MAIN

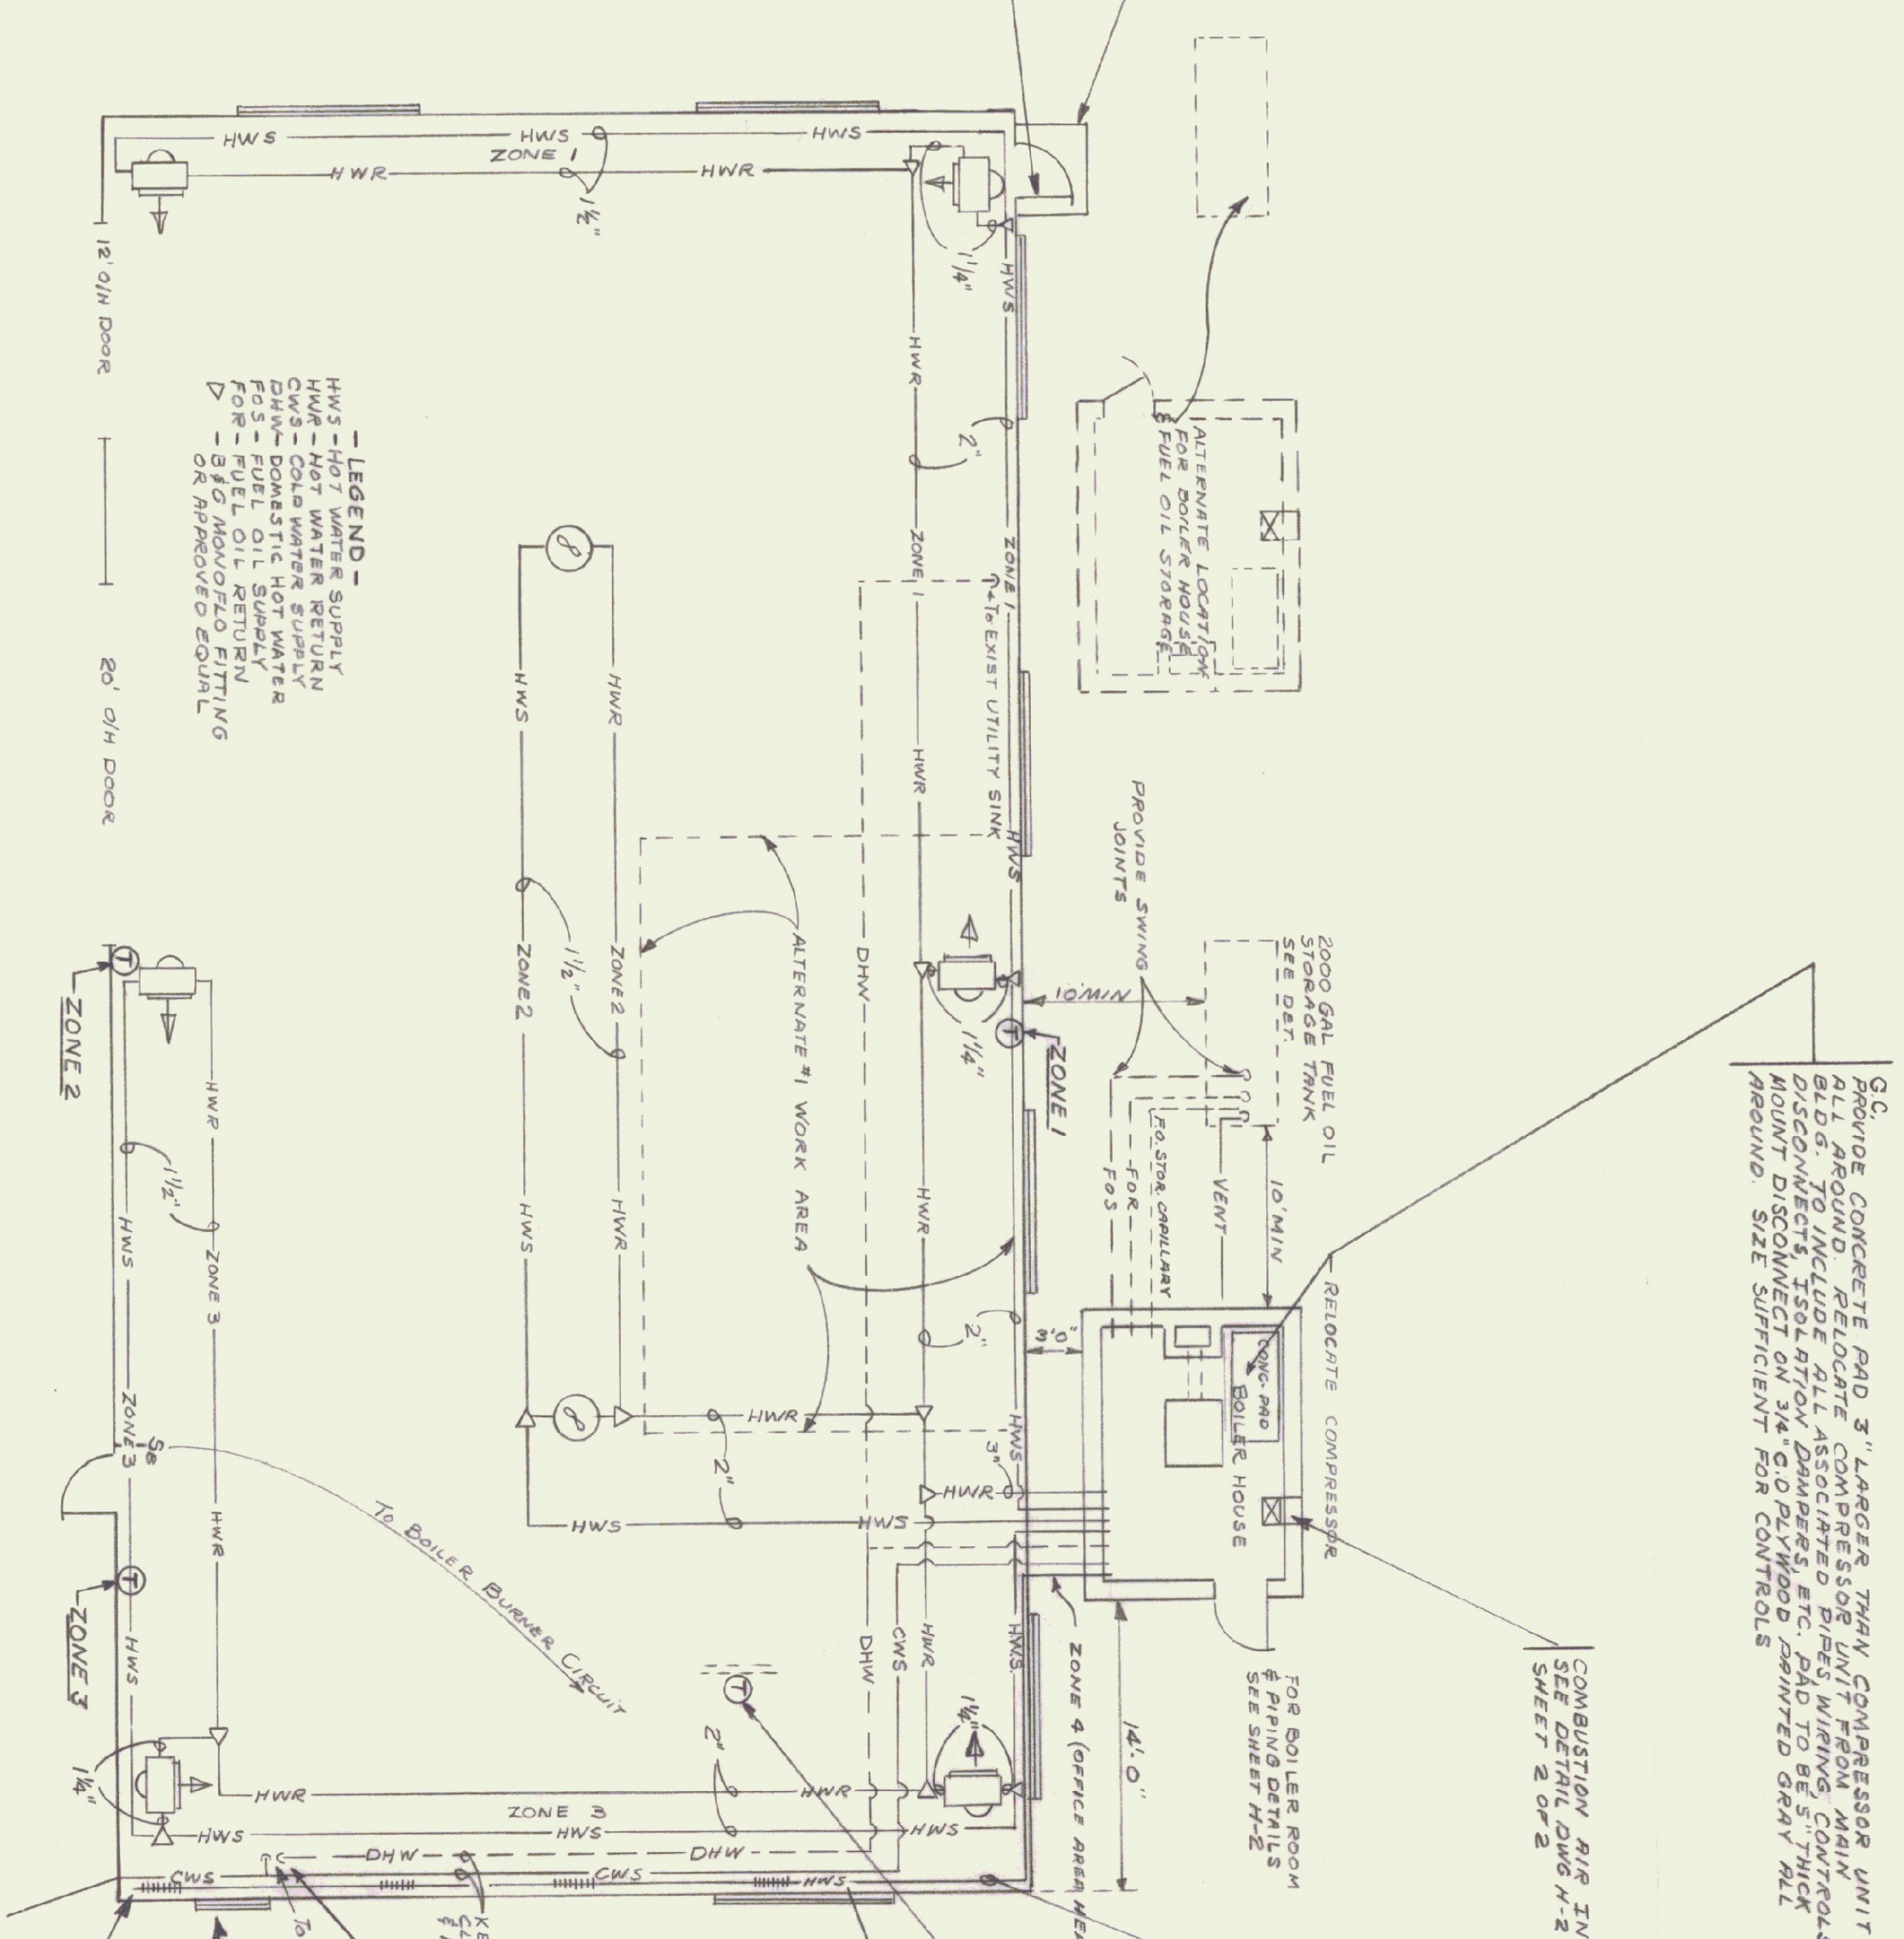

**LEGEND -**  
 HWS - HOT WATER SUPPLY  
 HWR - HOT WATER RETURN  
 DHW - DOMESTIC HOT WATER  
 CWS - COLD WATER SUPPLY  
 FOS - FUEL OIL STORAGE  
 S/C - SIGHT MOVEMENT EQUAL OR APPROVED EQUAL

SCALE 1/8" = 1'-0"

**NOTE - USE THIS HEATING PLAN FOR BASE BID ON HEATING**

STATE OF VERMONT STATE BUILDINGS DIVISION DEPARTMENT OF ADMINISTRATION MONTPELIER, VERMONT	
BERLIN, VT. TRAFFIC SHOP - DEPARTMENT OF HIGHWAYS HEATING PLAN	
DATE 2-73	DESIGNED BY G.N.M.
DRAWN BY D.C.S.	APPROVED BY
DWG. NO. H-1-R	
1 OF 3	