


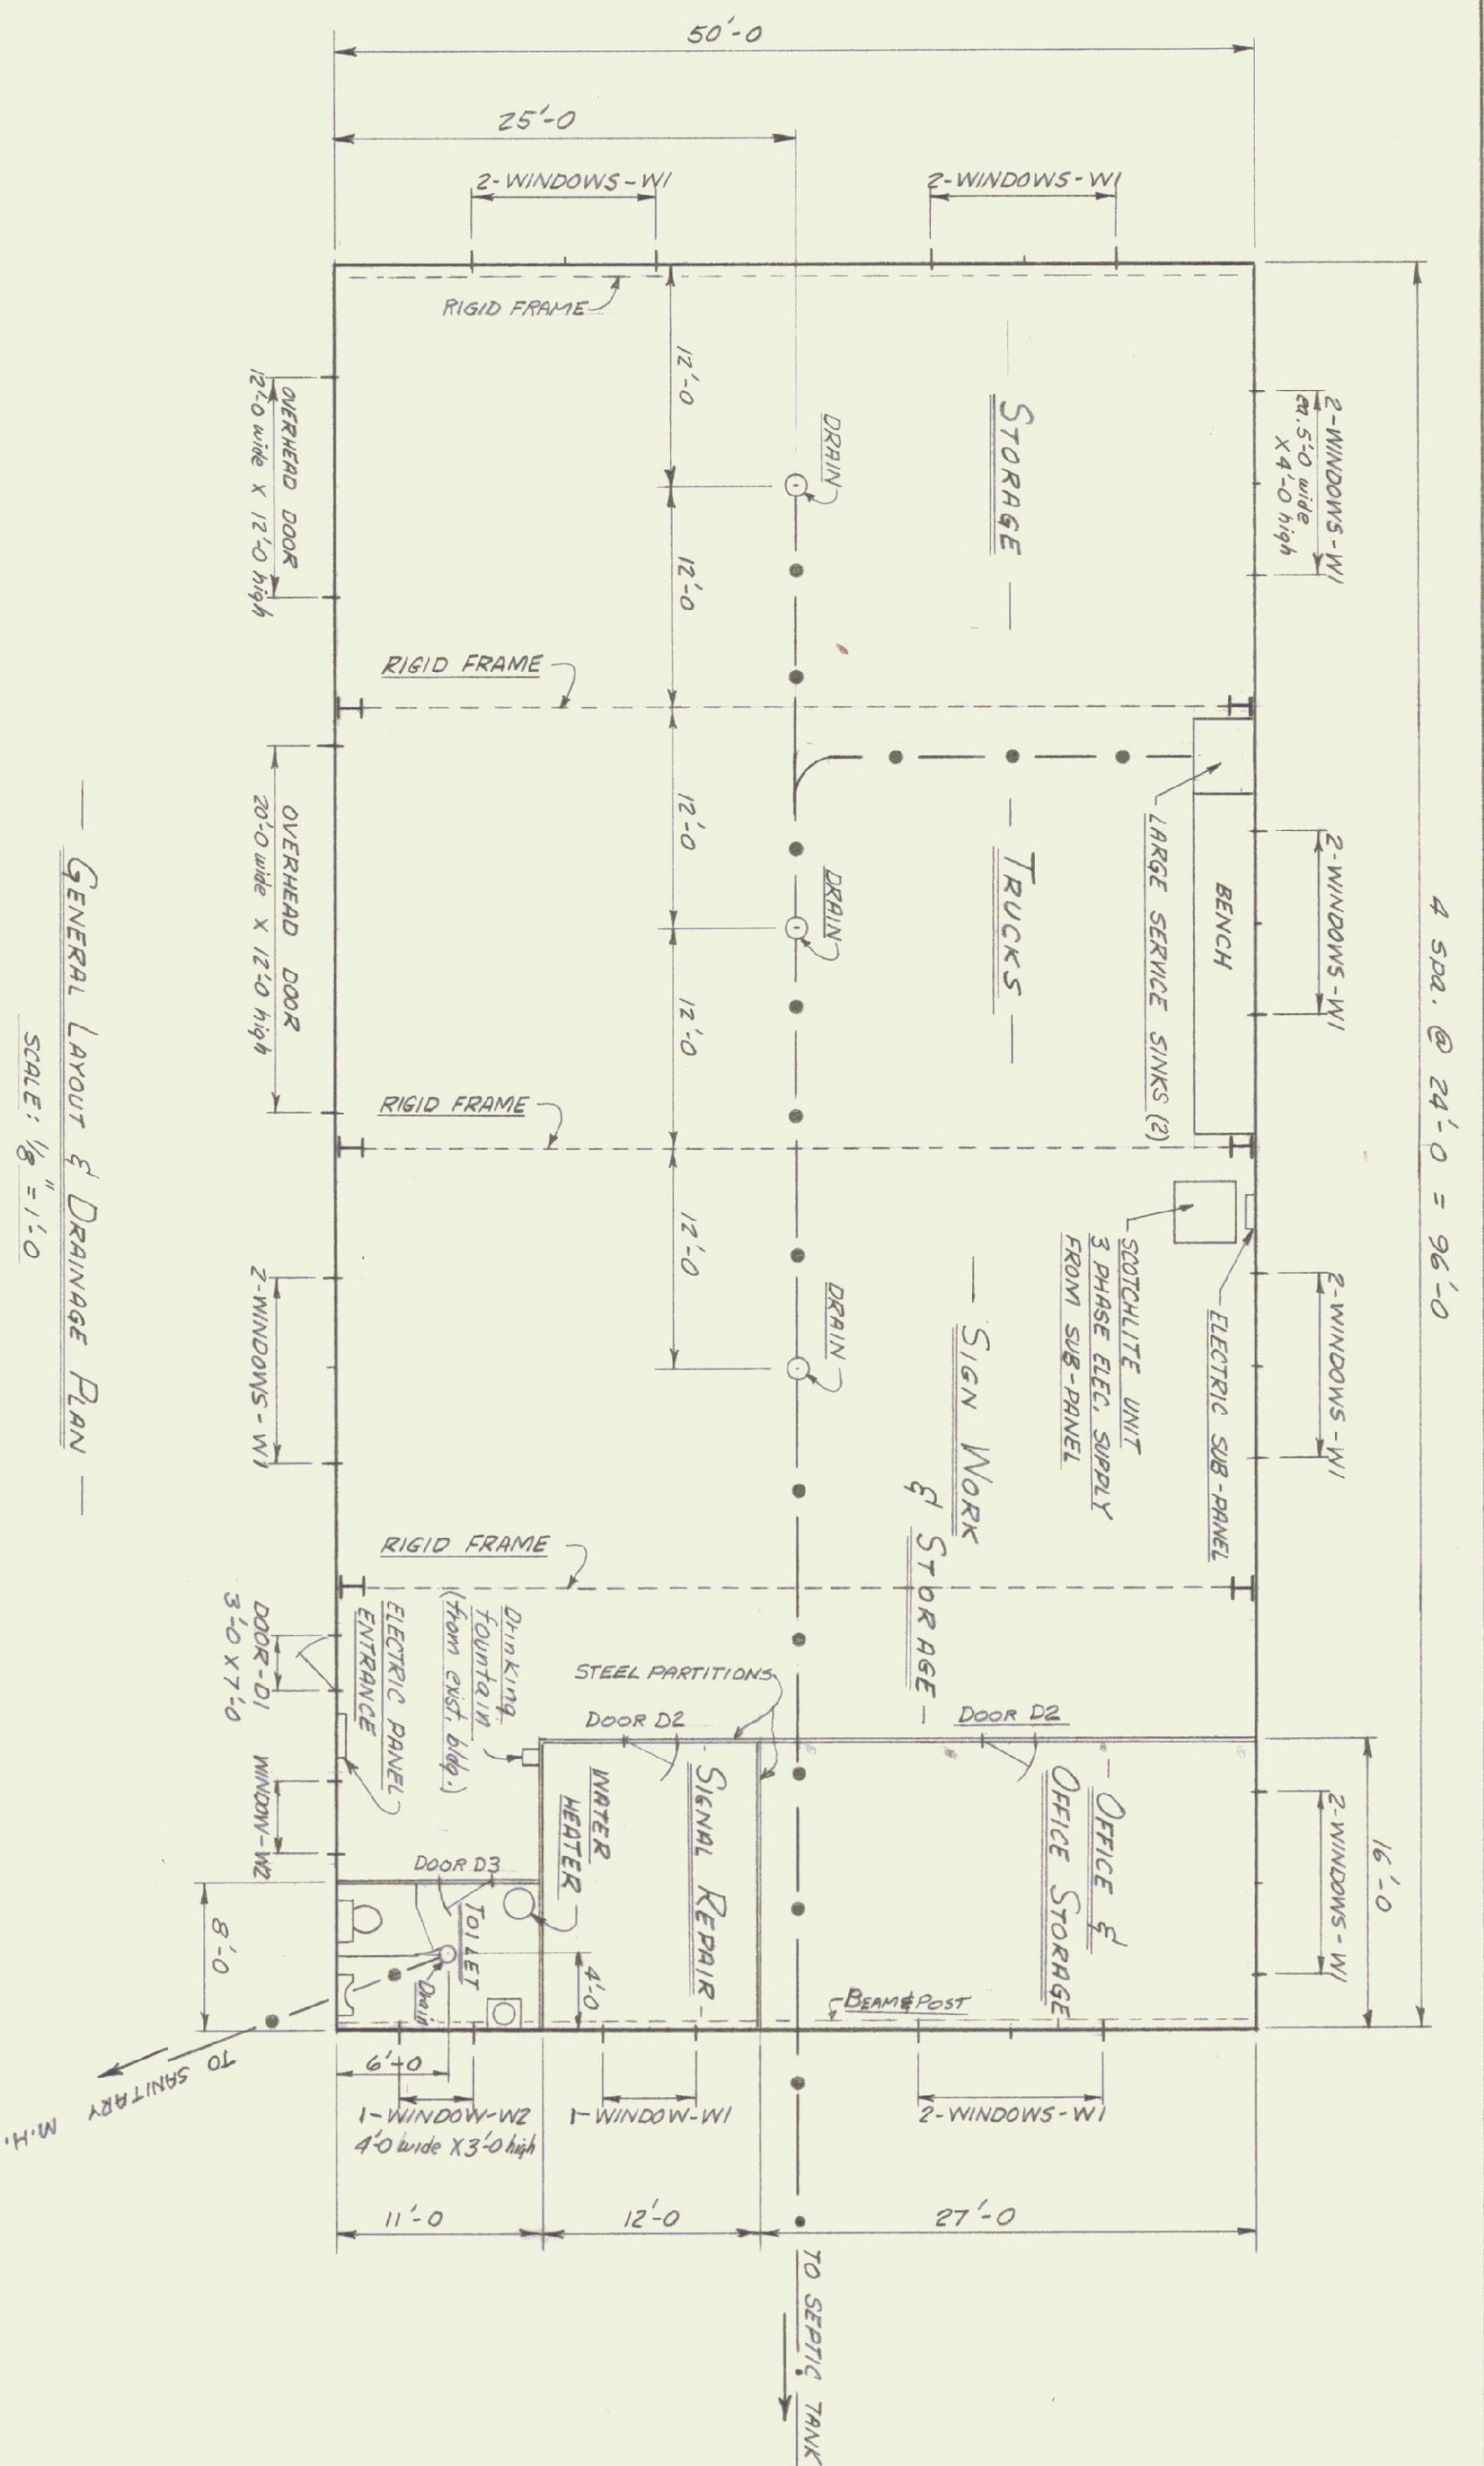


GENERAL LAYOUT & DRAINAGE PLAN

SCALE: $1/8" = 1'-0"$


ROOF U FACTOR = 0.18

WALL U FACTOR = 0.20

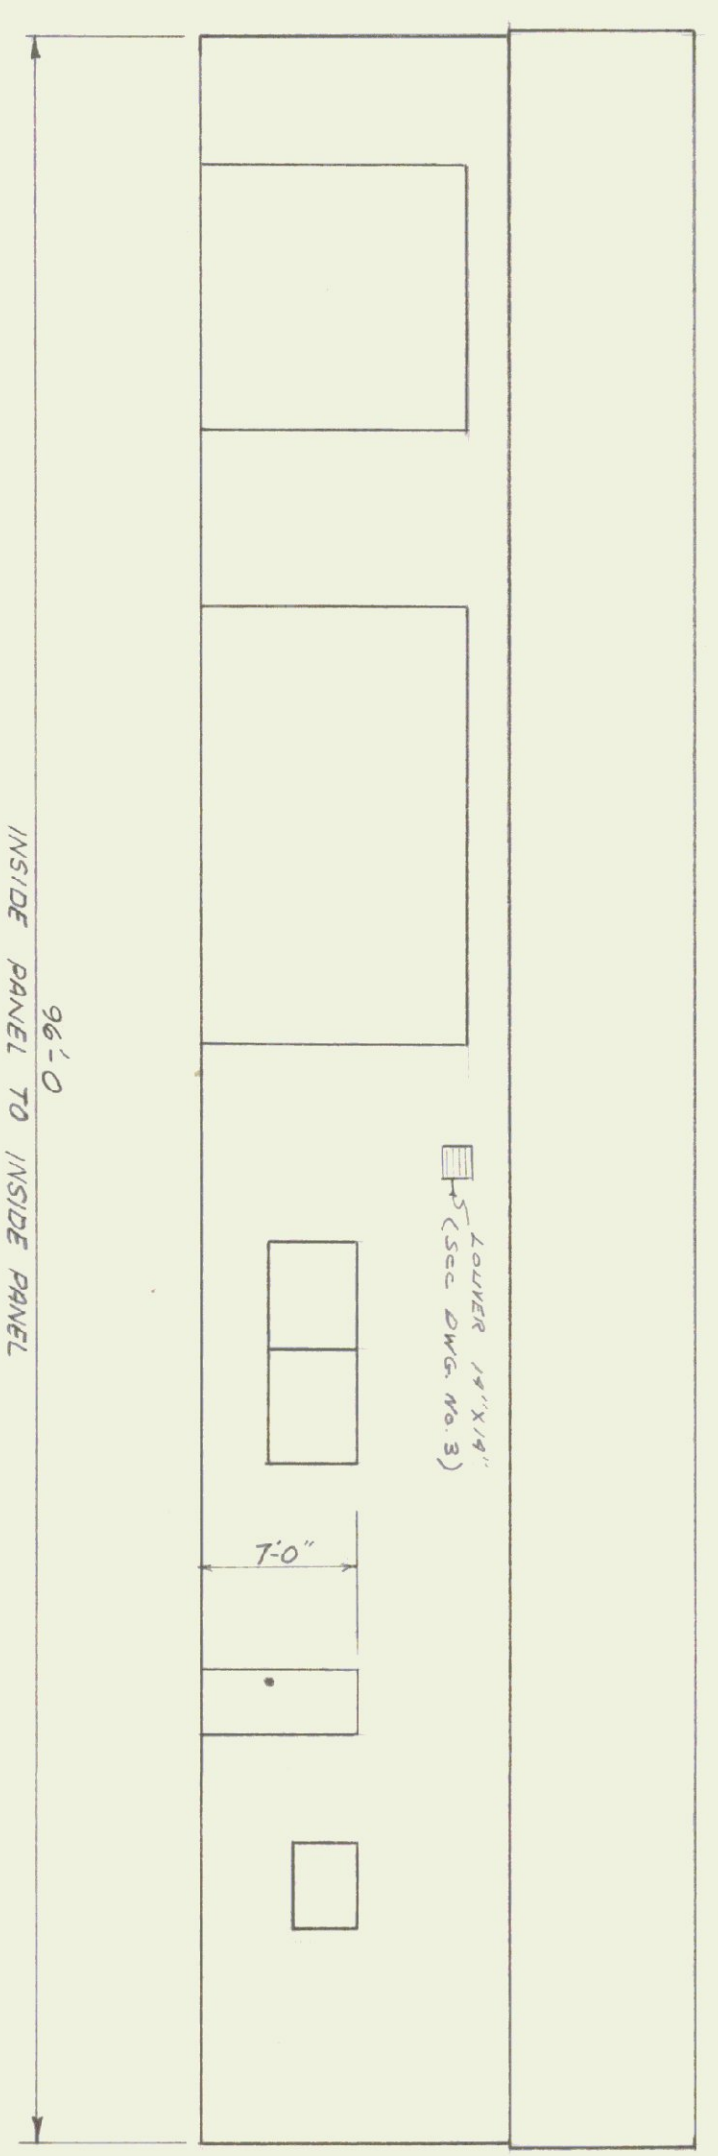


WEST ELEVATION

SCALE: $\frac{1}{8}$ " = 1'-0"

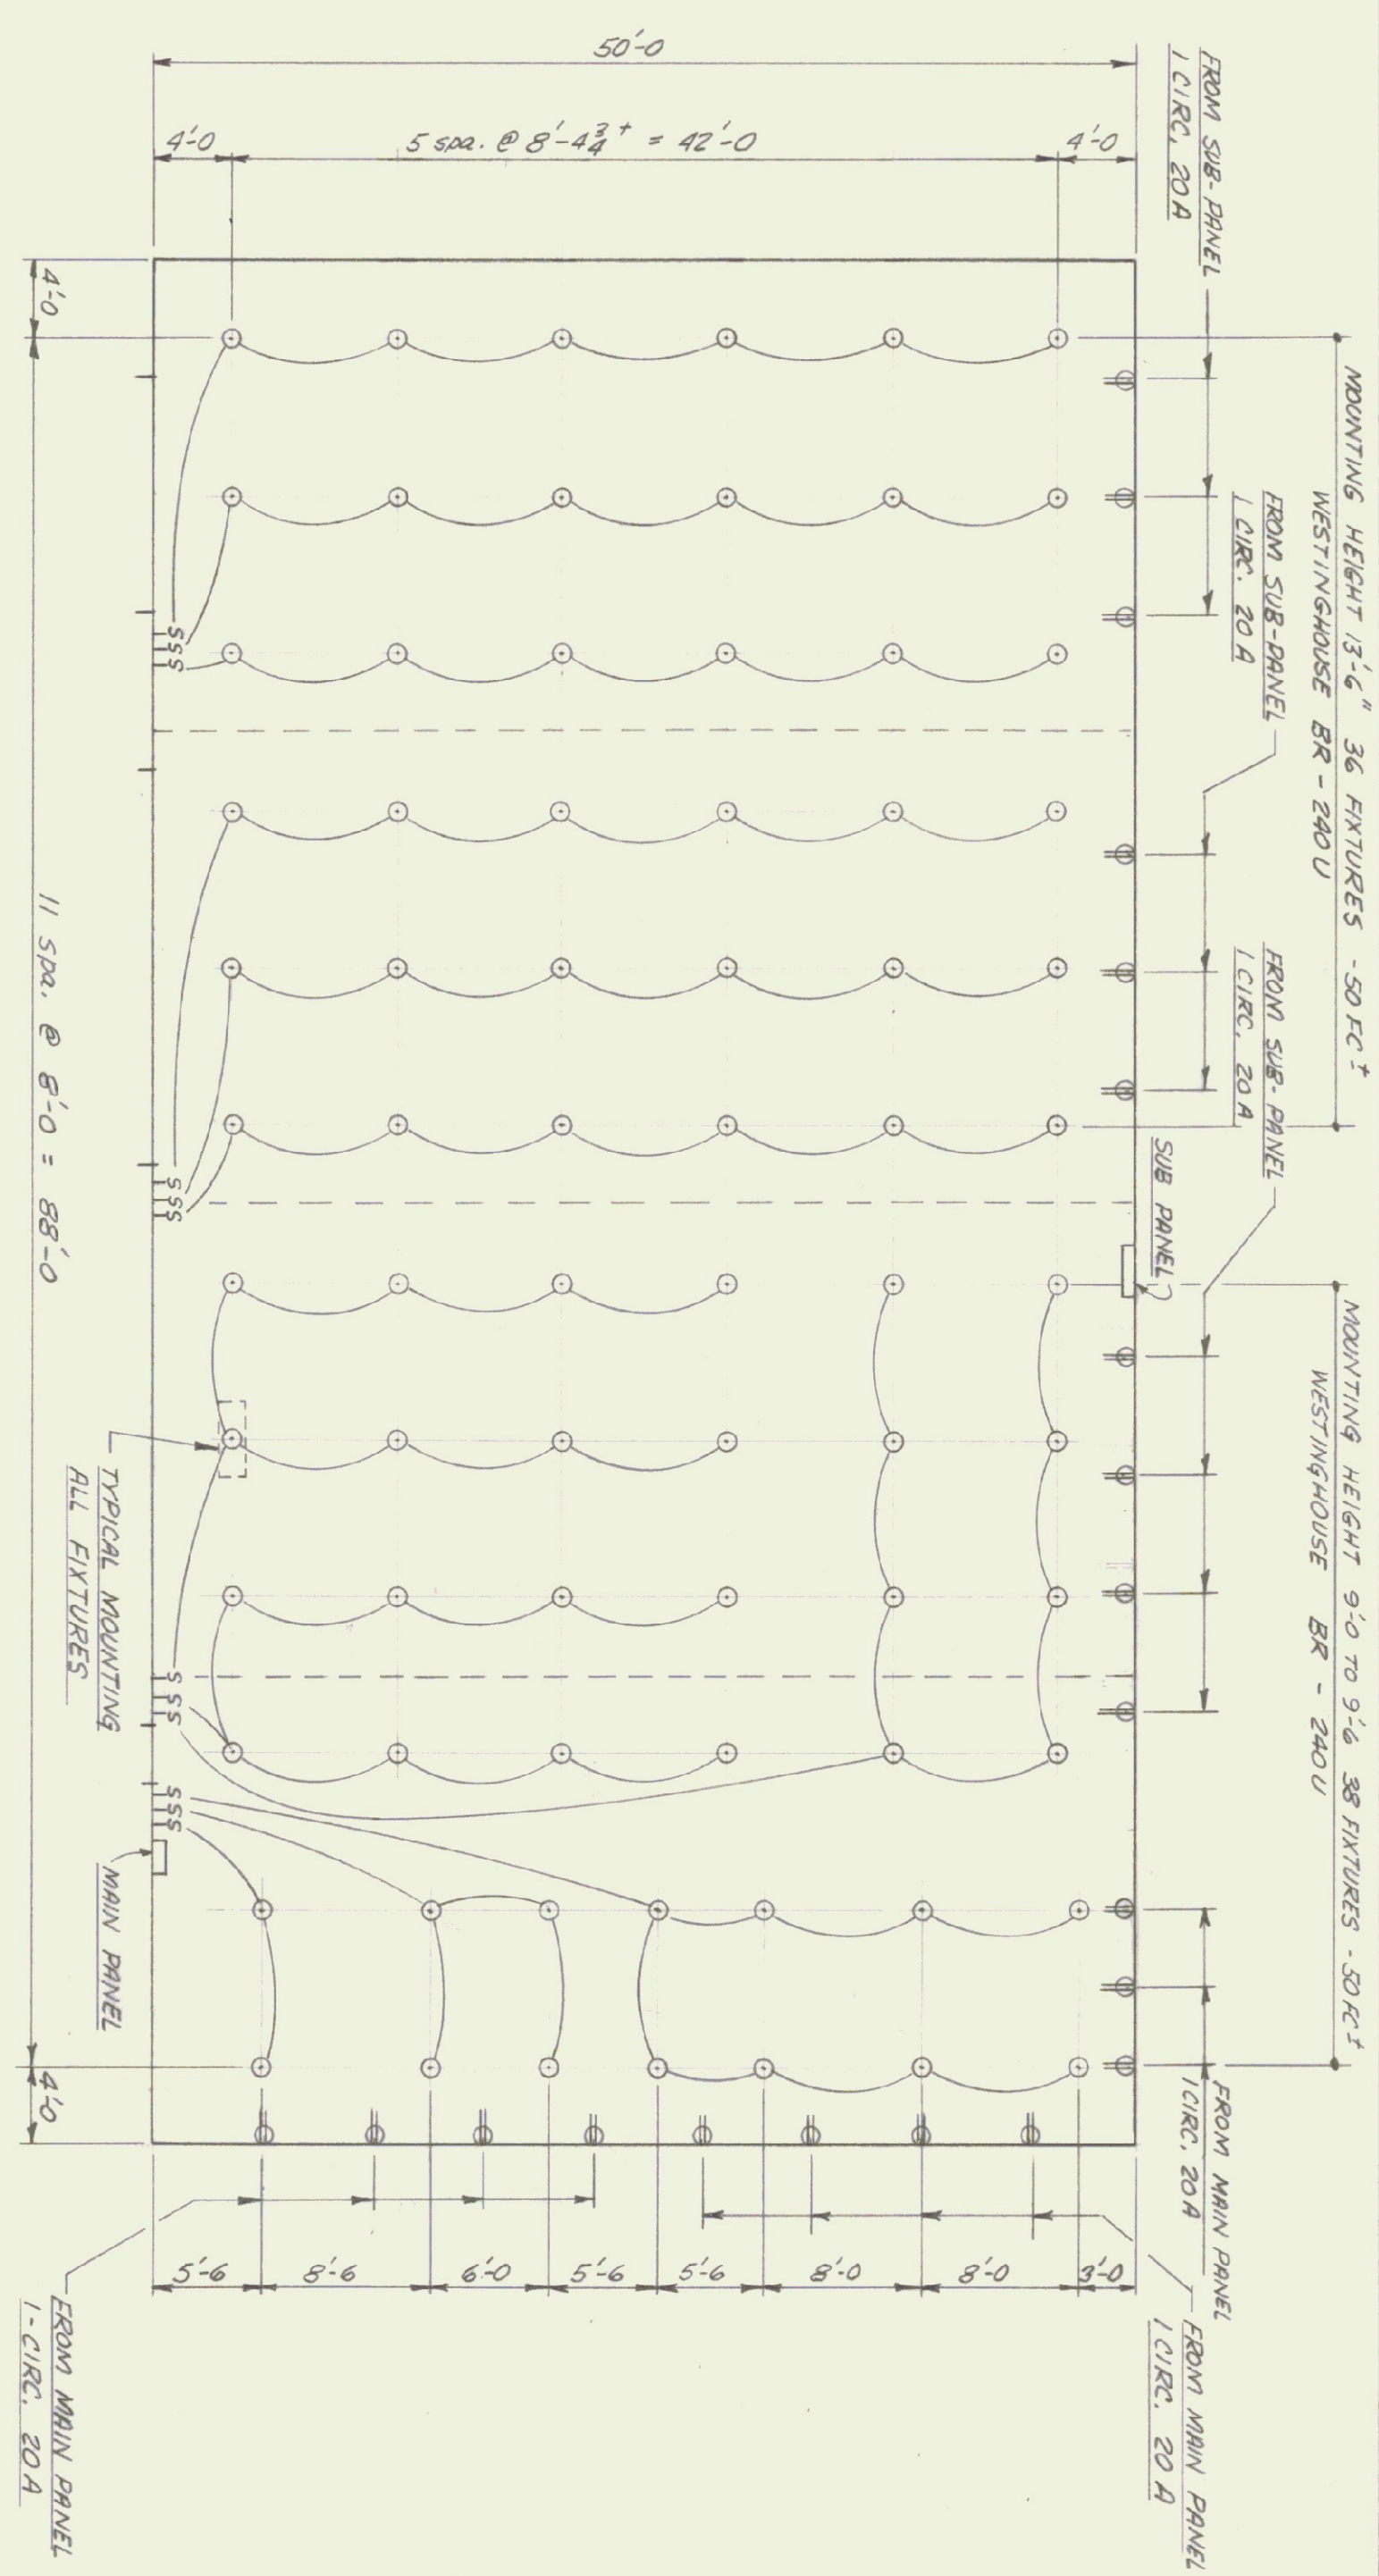

— ELECTRICAL LAYOUT —
SCALE: $\frac{1}{8}'' = 1'-0''$

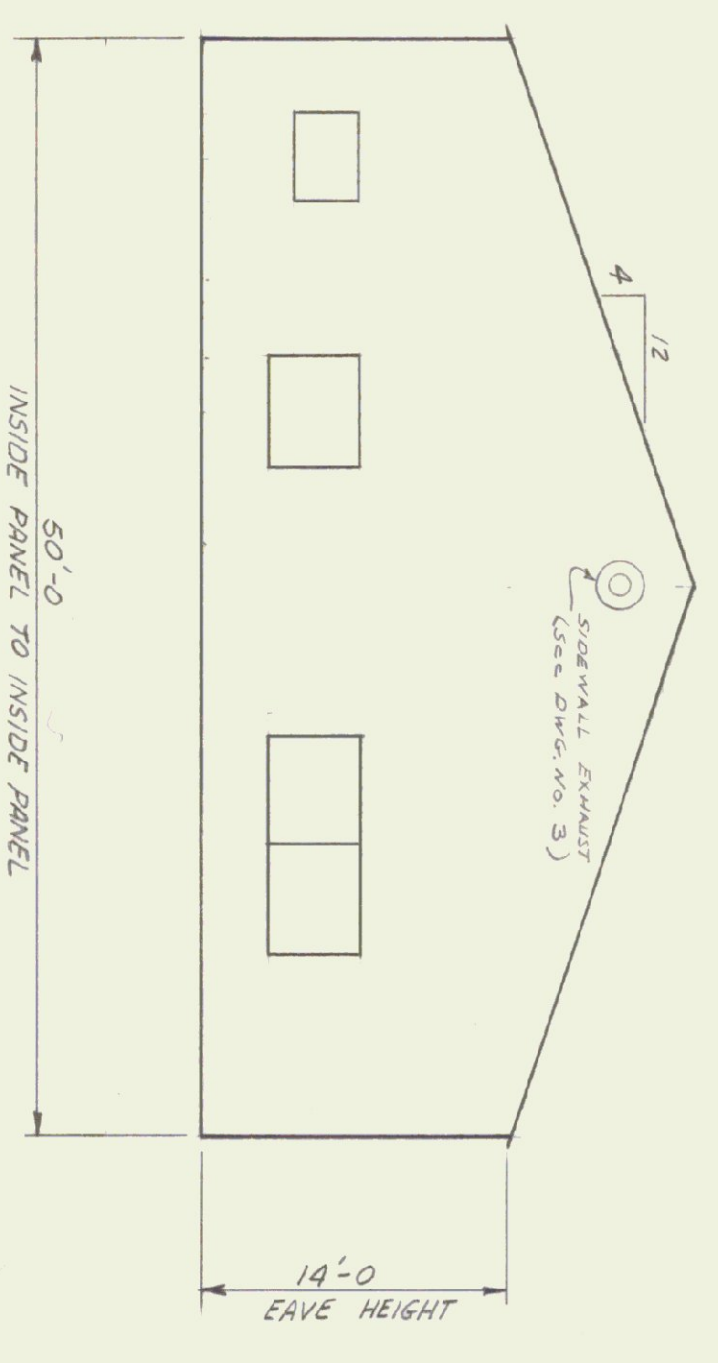

SOUTH ELEVATION -

SCALE: $\frac{1}{8}'' = 1'-0$

LEGEND (ELECTRICAL)

— S — SWITCHES - UP 4'-0" FROM FLOOR

⊖ DUALX OUTLETS UP 3'-0" FROM FLOOR
(OUTLETS RED FROM MAIN & SUB-PANELS
AS SHOWN)

⊙ LIGHTING FIXTURES - 11 CIRCUITS - 204
1-CIRC. PER 6 OR 8 FIXTURES.