

NO.	KEYED NOTES
1	REMOVE 2 EXISTING CIRCUIT BREAKERS AND ENCLOSE PATCH WALL. CONNECT CIRCUIT FOR ENTRY HEATER TO EXISTING CIRCUIT BREAKER IN PANEL P-1. 30 AMP, 2POLE.
2	EXISTING ENTRY HEATER TO REMAIN. PROVIDE CIRCUIT FROM PANEL P-1.
3	EXISTING DEVICES TO BE EXTENDED TO ALLOW INSTALLATION OF WOOD STRAPPING AND SHEETROCK.

ELECTRICAL FIXTURE SCHEDULE			
KEY	MANUFACTURE & MODEL	MOUNTING	LAMPS
FA	COLUMBIA TB-P4-243G-49	RECESSED	QUAN 3, 18 OCTOLUME 3500K, 32W

- DESCRIPTION OF WORK**
- FIRE PROTECTION SYSTEM - REMOVE EXISTING DRY HEADS IN EXISTING CEILING. EXTEND PIPING TO NEW SUSPENDED CEILING. PROVIDE NEW HEADS, CENTERED IN TILE (STAR MODEL, ME-1 FLUSH TYPE DRY PENDENT OR EQUAL) AND PROVIDE STANDARD DRY HEADS IN PLENUM SPACE ABOVE CEILING.
 - AIR CONDITIONING SYSTEM - PROVIDE COMPLETE AIR CONDITIONING SYSTEM INCLUDING ROOF TOP UNIT, CURB, GALVANIZED SHEET METAL DUCTWORK AS PER SMACNA, CONTROL WIRING, DAMPERS, GRILLES AND REGISTERS.
 - SUPPLY DUCT TO BE INSULATED WITH MIN. 1" THICK FOIL-REINFORCED KRAFT FACED VAPOR BARRIER JACKETED, INORGANIC GLASS FIBER BLANKET, COMMERCIAL GRADE.
- APPROVED ROOFING CONTRACTOR TO WEATHER PROOF CURB TO EXISTING TROCAL ROOF AS PER TROCAL FACTORY APPROVED PROCEDURES.
- ELECTRIC - REMOVE EXISTING LIGHT FIXTURES IN GENERAL OFFICE AREA. PROVIDE RECESSED LIGHT FIXTURES AND ALL NECESSARY CONDUIT AND WIRE FOR COMPLETE INSTALLATION.
- PROVIDE POWER WIRING, WEATHER PROOF SAFETY SWITCH AND CIRCUIT BREAKER FOR ROOF TOP AIR CONDITIONER.


MECHANICAL EQUIPMENT SCHEDULE	
ITEM	DESCRIPTION
A/C	AIR CONDITIONING UNIT, ROOF MOUNTED, LENNOX CHA 16-413, 34,000 BTU/HOUR, 208 VOLT, 3 PHASE, WITH FOLLOWING OPTIONS: 1. ROOF MOUNTING FRAME, RMF-16-41 2. ECONOMIZER DAMPERS W/GRAVITY EXHAUST, REMD 16 M-41 3. TWO STAGE THERMOSTAT TB74E1032 (13F09) & SUBBASE 0674C1009 (13F15)

GRILLE & REGISTER SCHEDULE	
ITEM	DESCRIPTION
RG-1	RETURN GRILLE - METAL AIRE SERIES C03, 22x10, OFF WHITE, ALUMINUM
RG-2	SAME AS RG-1 EXCEPT 22x32
SR-1	SUPPLY REGISTER - METAL AIRE SERIES 5000 - M6-05, 34, 9x9, T-BAR MOUNT (24 X 24), W/OBD, OFF-WHITE, EXTRUDED ALUMINUM
SR-2	SUPPLY REGISTER - METAL AIRE SERIES 5000 - M6-05, 34, 12x12, T-BAR MOUNT (24x24), W/OBD, OFF-WHITE, EXTRUDED ALUMINUM

NOTES:

- OLD LIGHT FIXTURES TO BE TURNED OVER TO OWNER.
- RELOCATION THROUGH ROOF, SETTING OF AC UNIT & FUEL ELIC. CONNECTION TO BE DONE BY THE OWNER.
- AS-BUILT OF SPRINKLER INSTALLATION MUST BE SUBMITTED TO OWNER & INDUSTRY AND APPROVED BEFORE RELEASE OF RETAINAGE.
- PUT WORK TO BE INSTALLED TIGHT TO BASE UNIT.
- REMOVE ALL UPPER-FLOOR WIRE & DEVICES. PATCH HOLES TO MATCH EXISTING FLOOR LEVEL.
- AC UNIT TO BE STORED ON SITE UNTIL SPRINKLER INSTALLATION.

SITE PLAN

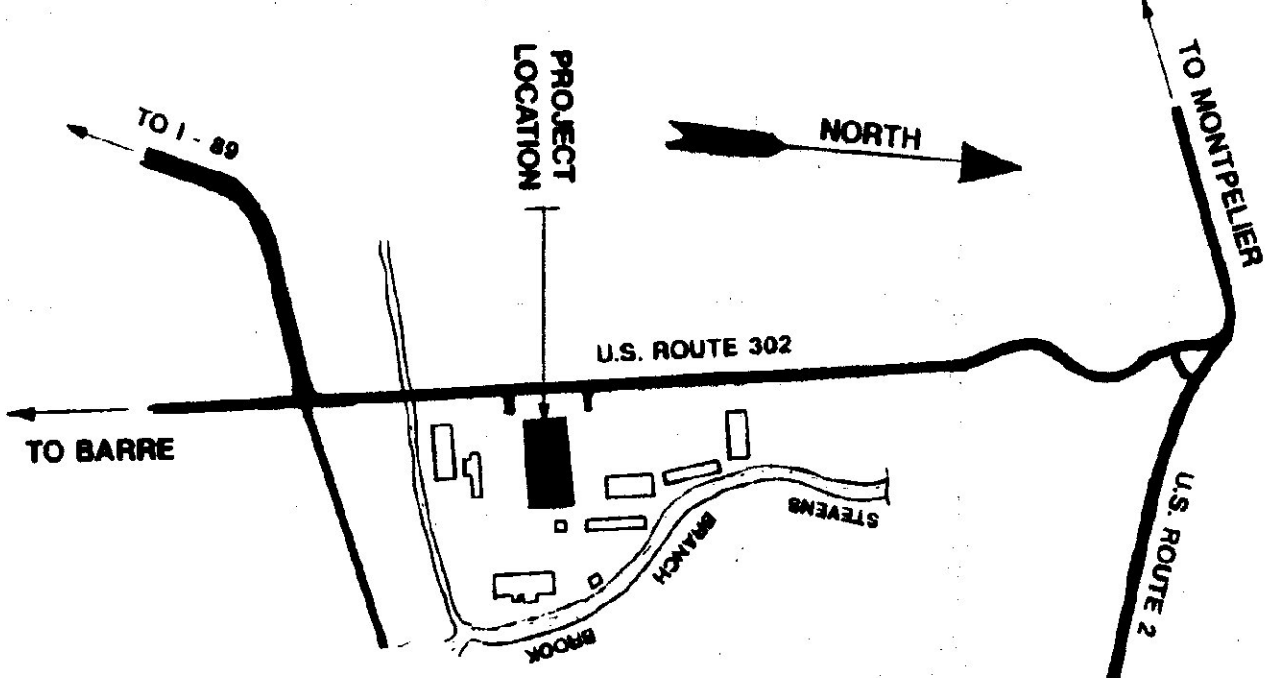


STATE OF VERMONT
DEPARTMENT OF STATE BUILDINGS
AGENCY OF ADMINISTRATION

OFFICE RENOVATION PLAN
CENTRAL GARAGE

DATE: 11/07/81
SCALE: 1/4"=1'-0"
DRAWN BY: B.M.M.
APPROVED BY: [Signature]
VERMONT
2 OF 2


AIR CONDITIONING PLAN

SCALE - 1/4"=1'-0"

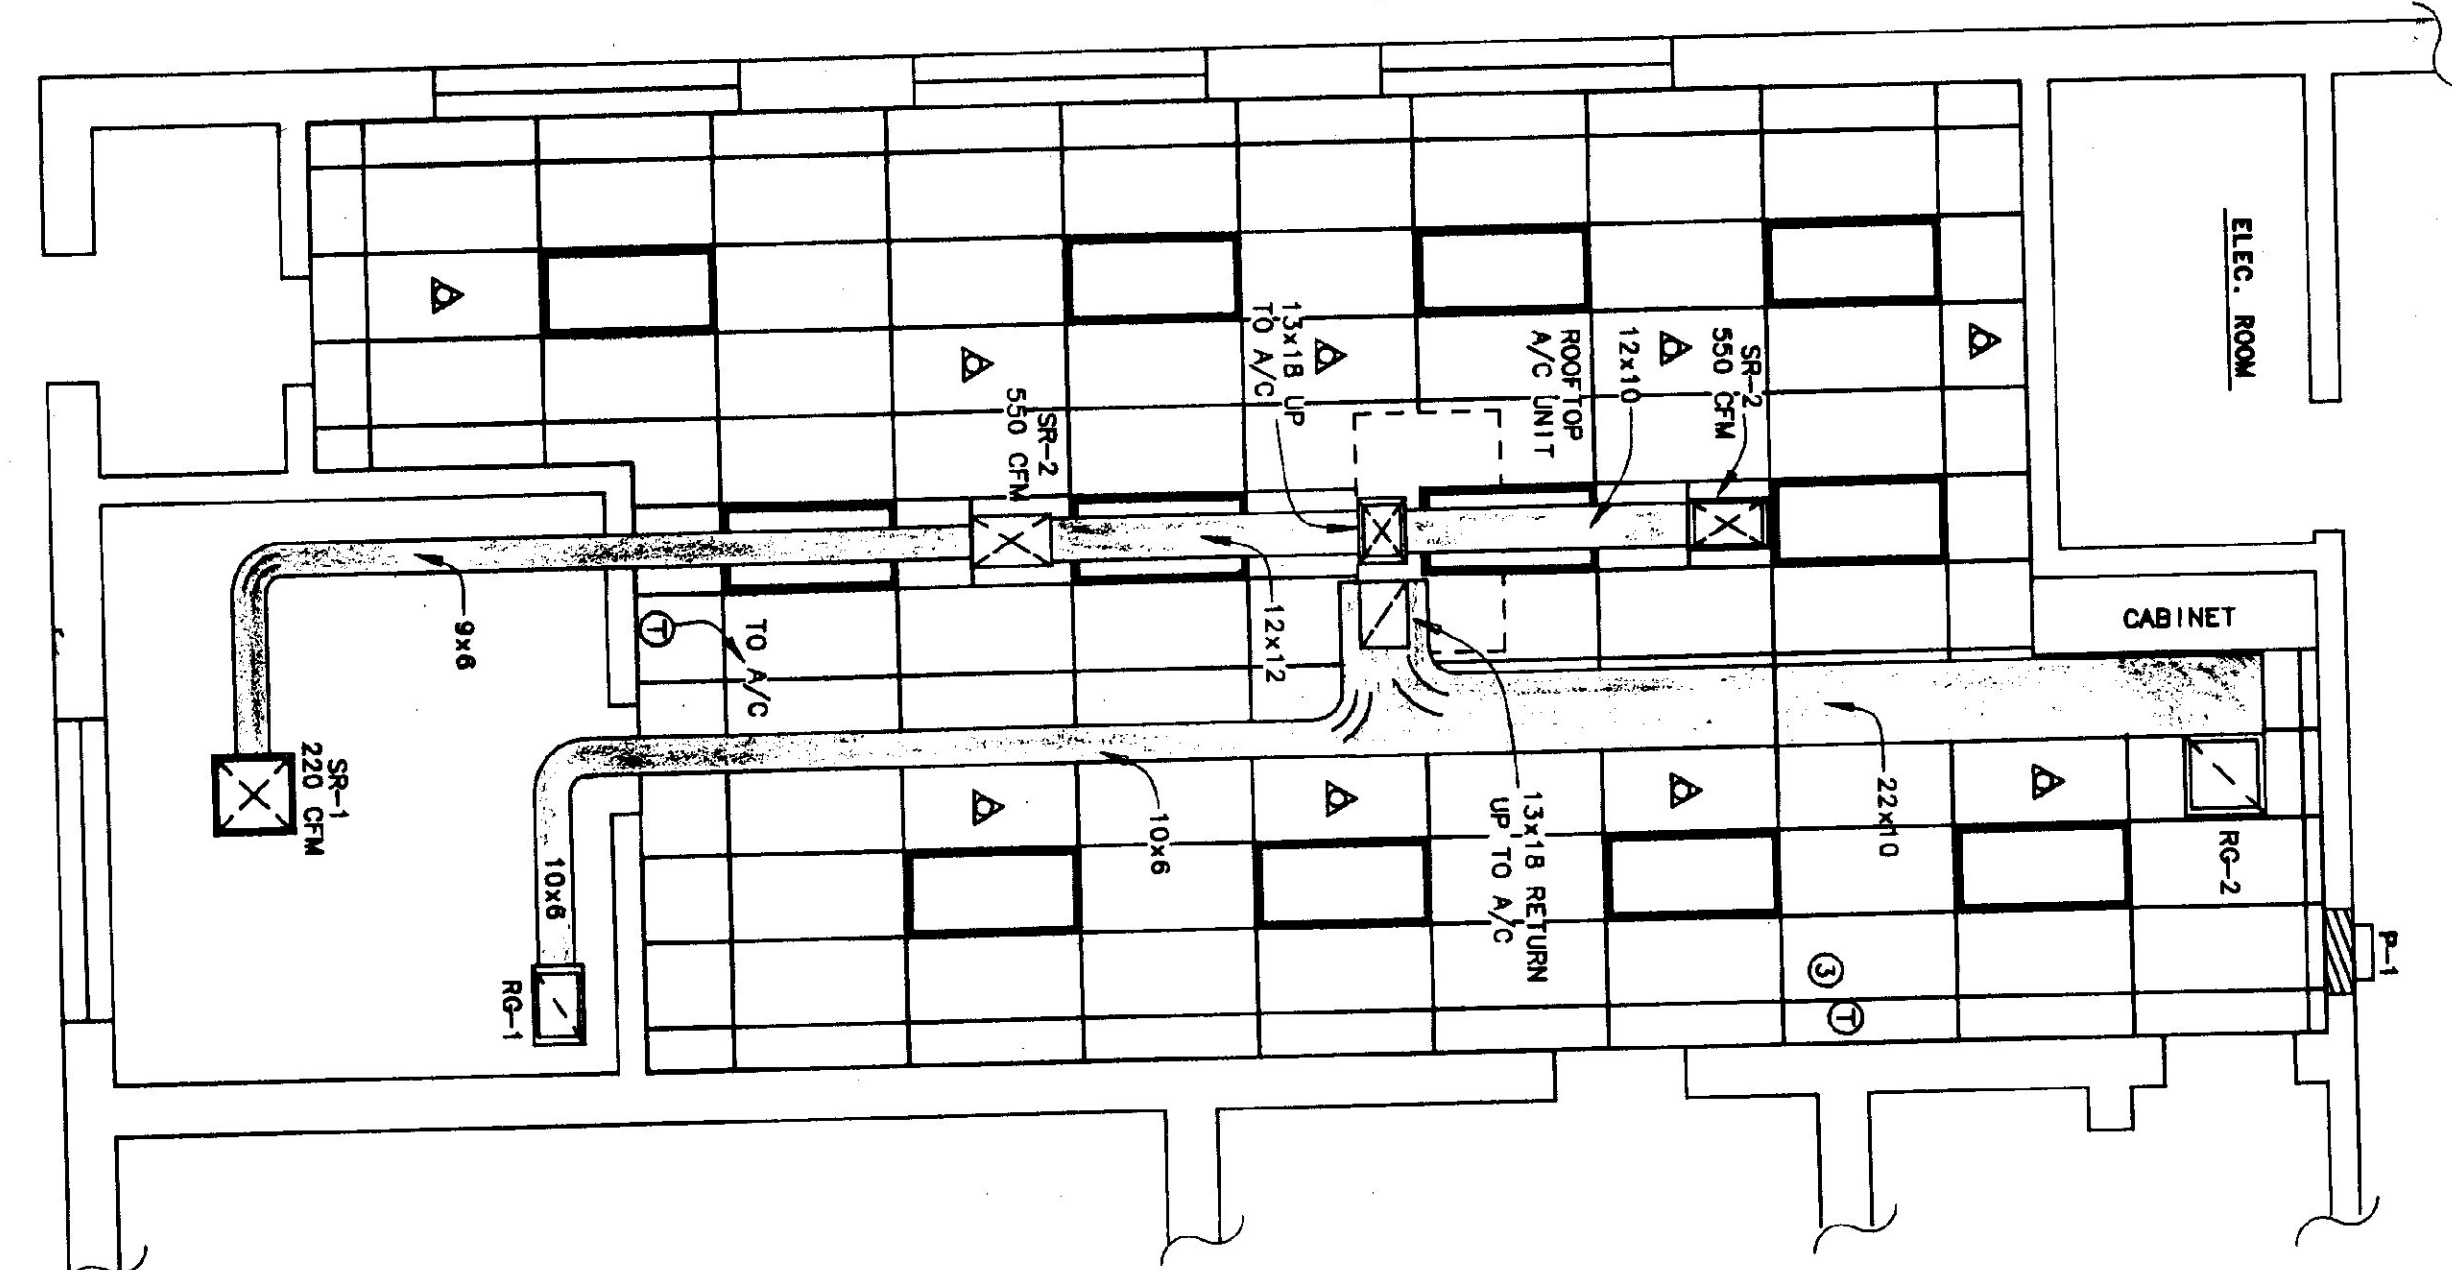

LIGHTING & FIRE PROTECTION PLAN

SCALE - 1/4"=1'-0"

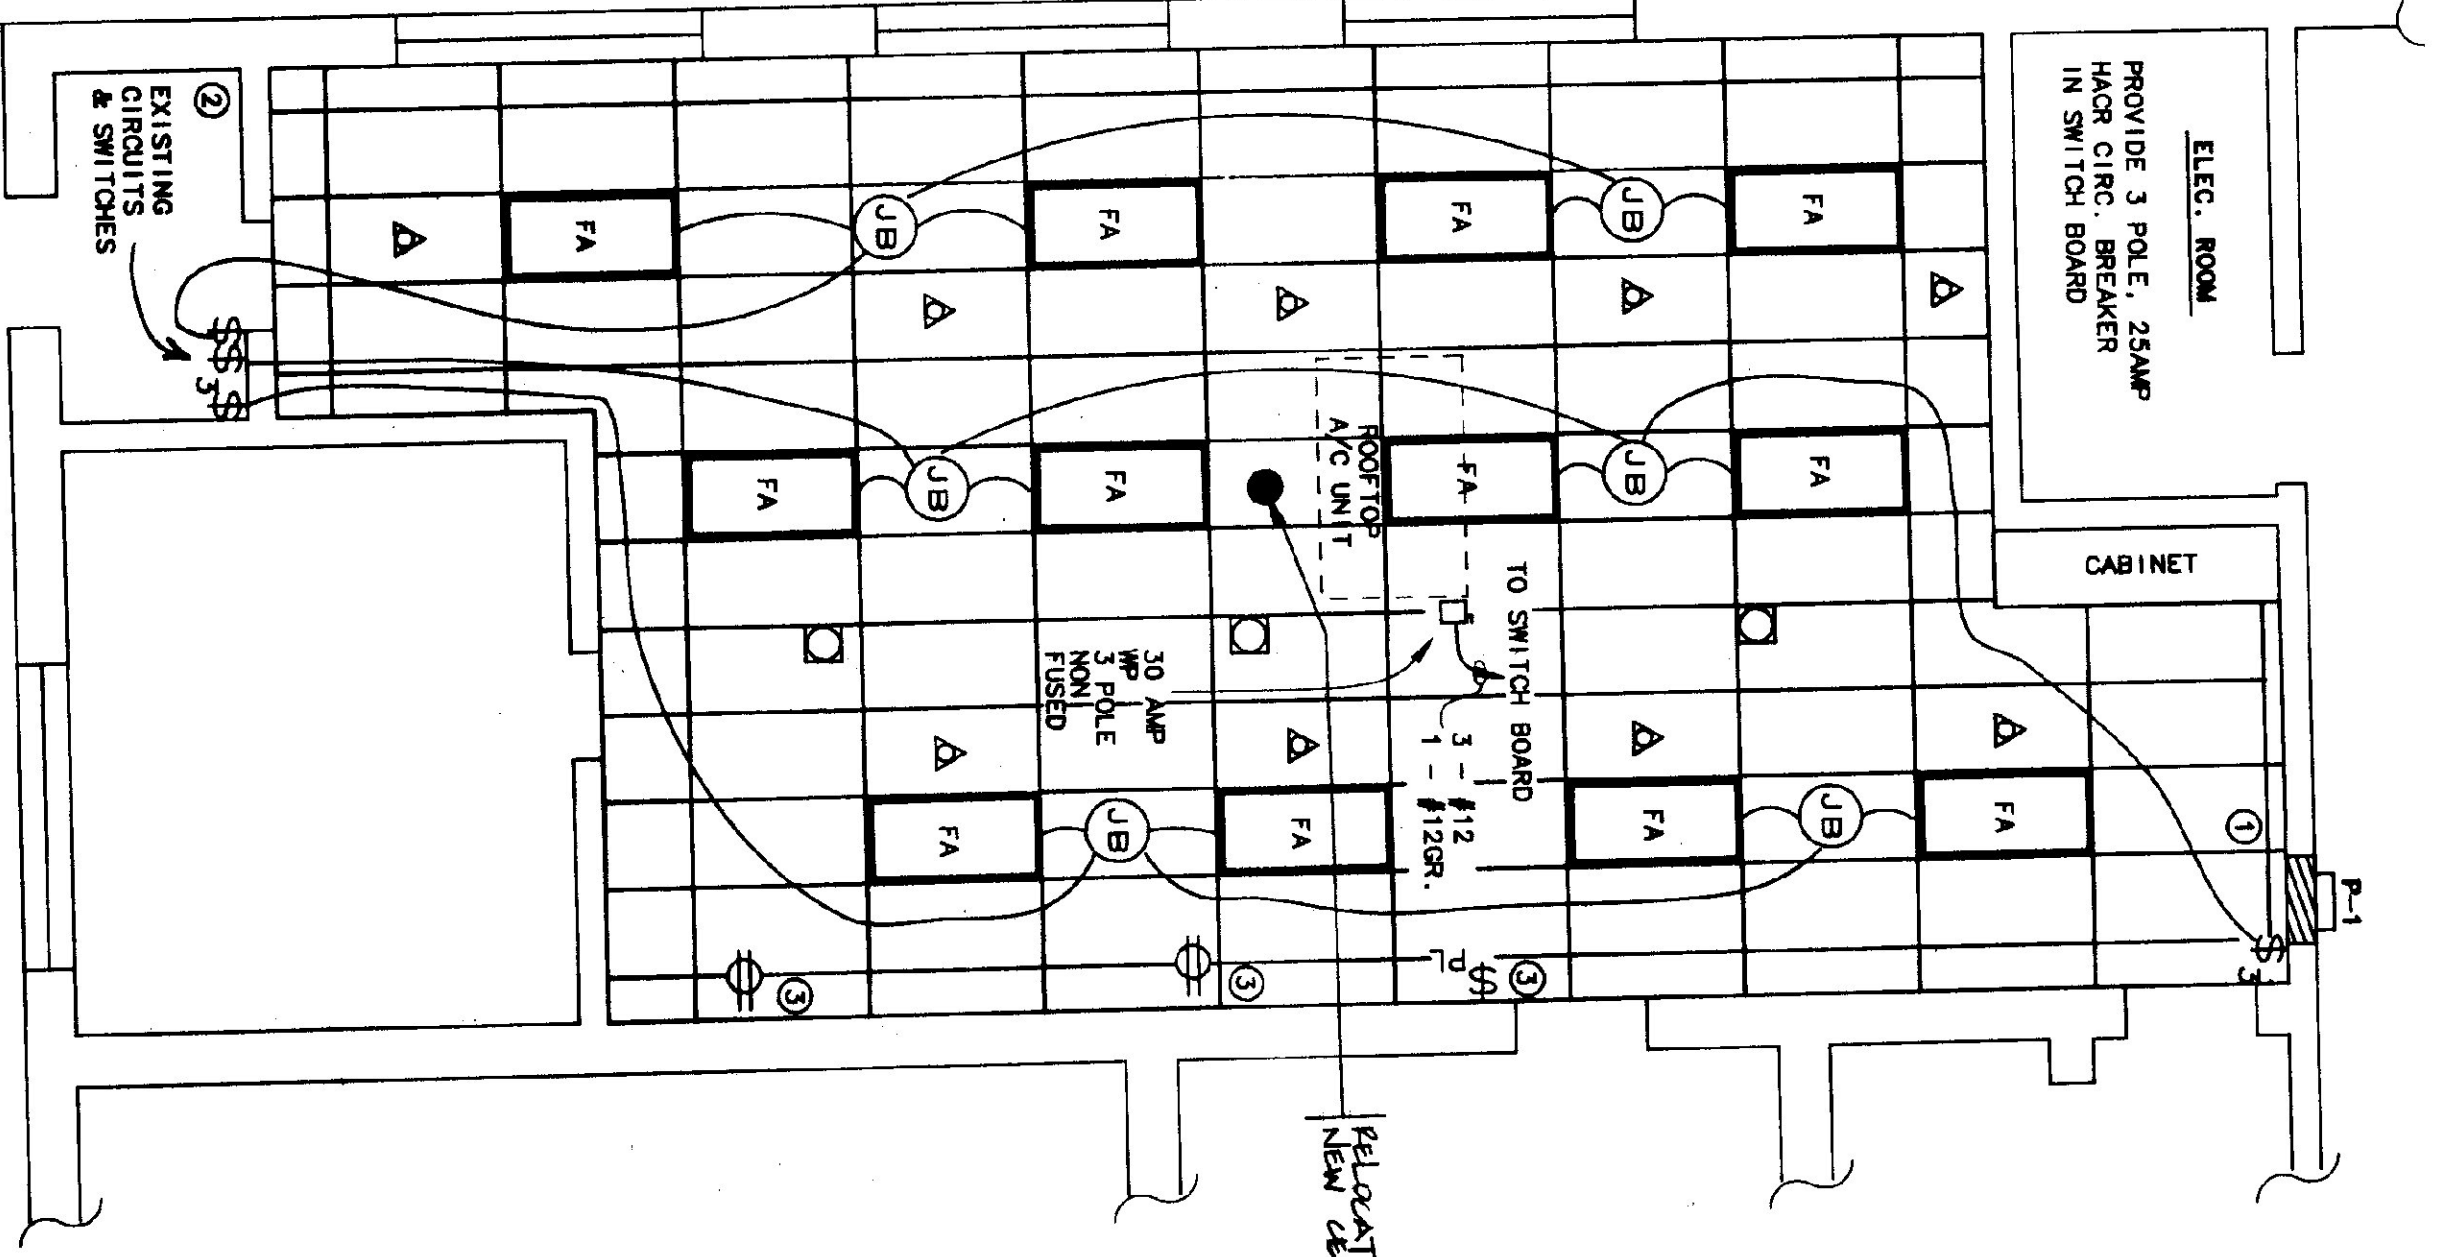

LEGEND	
FA	FLUORESCENT LIGHT
\$	SWITCH
\$3	3-WAY SWITCH
⊖	DUPLEX OUTLET
⊕	FIRE SPRINKLER HEAD
⊙	THERMOSTAT
□	SAFETY SWITCH
□	POWER POLE
⊗	SUPPLY REGISTER
⊙	RETURN GRILLE
⊕	ABOVE FINISHED FLOOR
⊖	JUNCTION BOX
⊙	GROUND
⊕	PILOT LIGHT

Pederson & Associates
MECHANICAL & ELECTRICAL ENGINEERS
P.O. BOX 610 STONE, VERMONT 05672
TEL. (802) 253-9607 FAX (802) 253-9290