



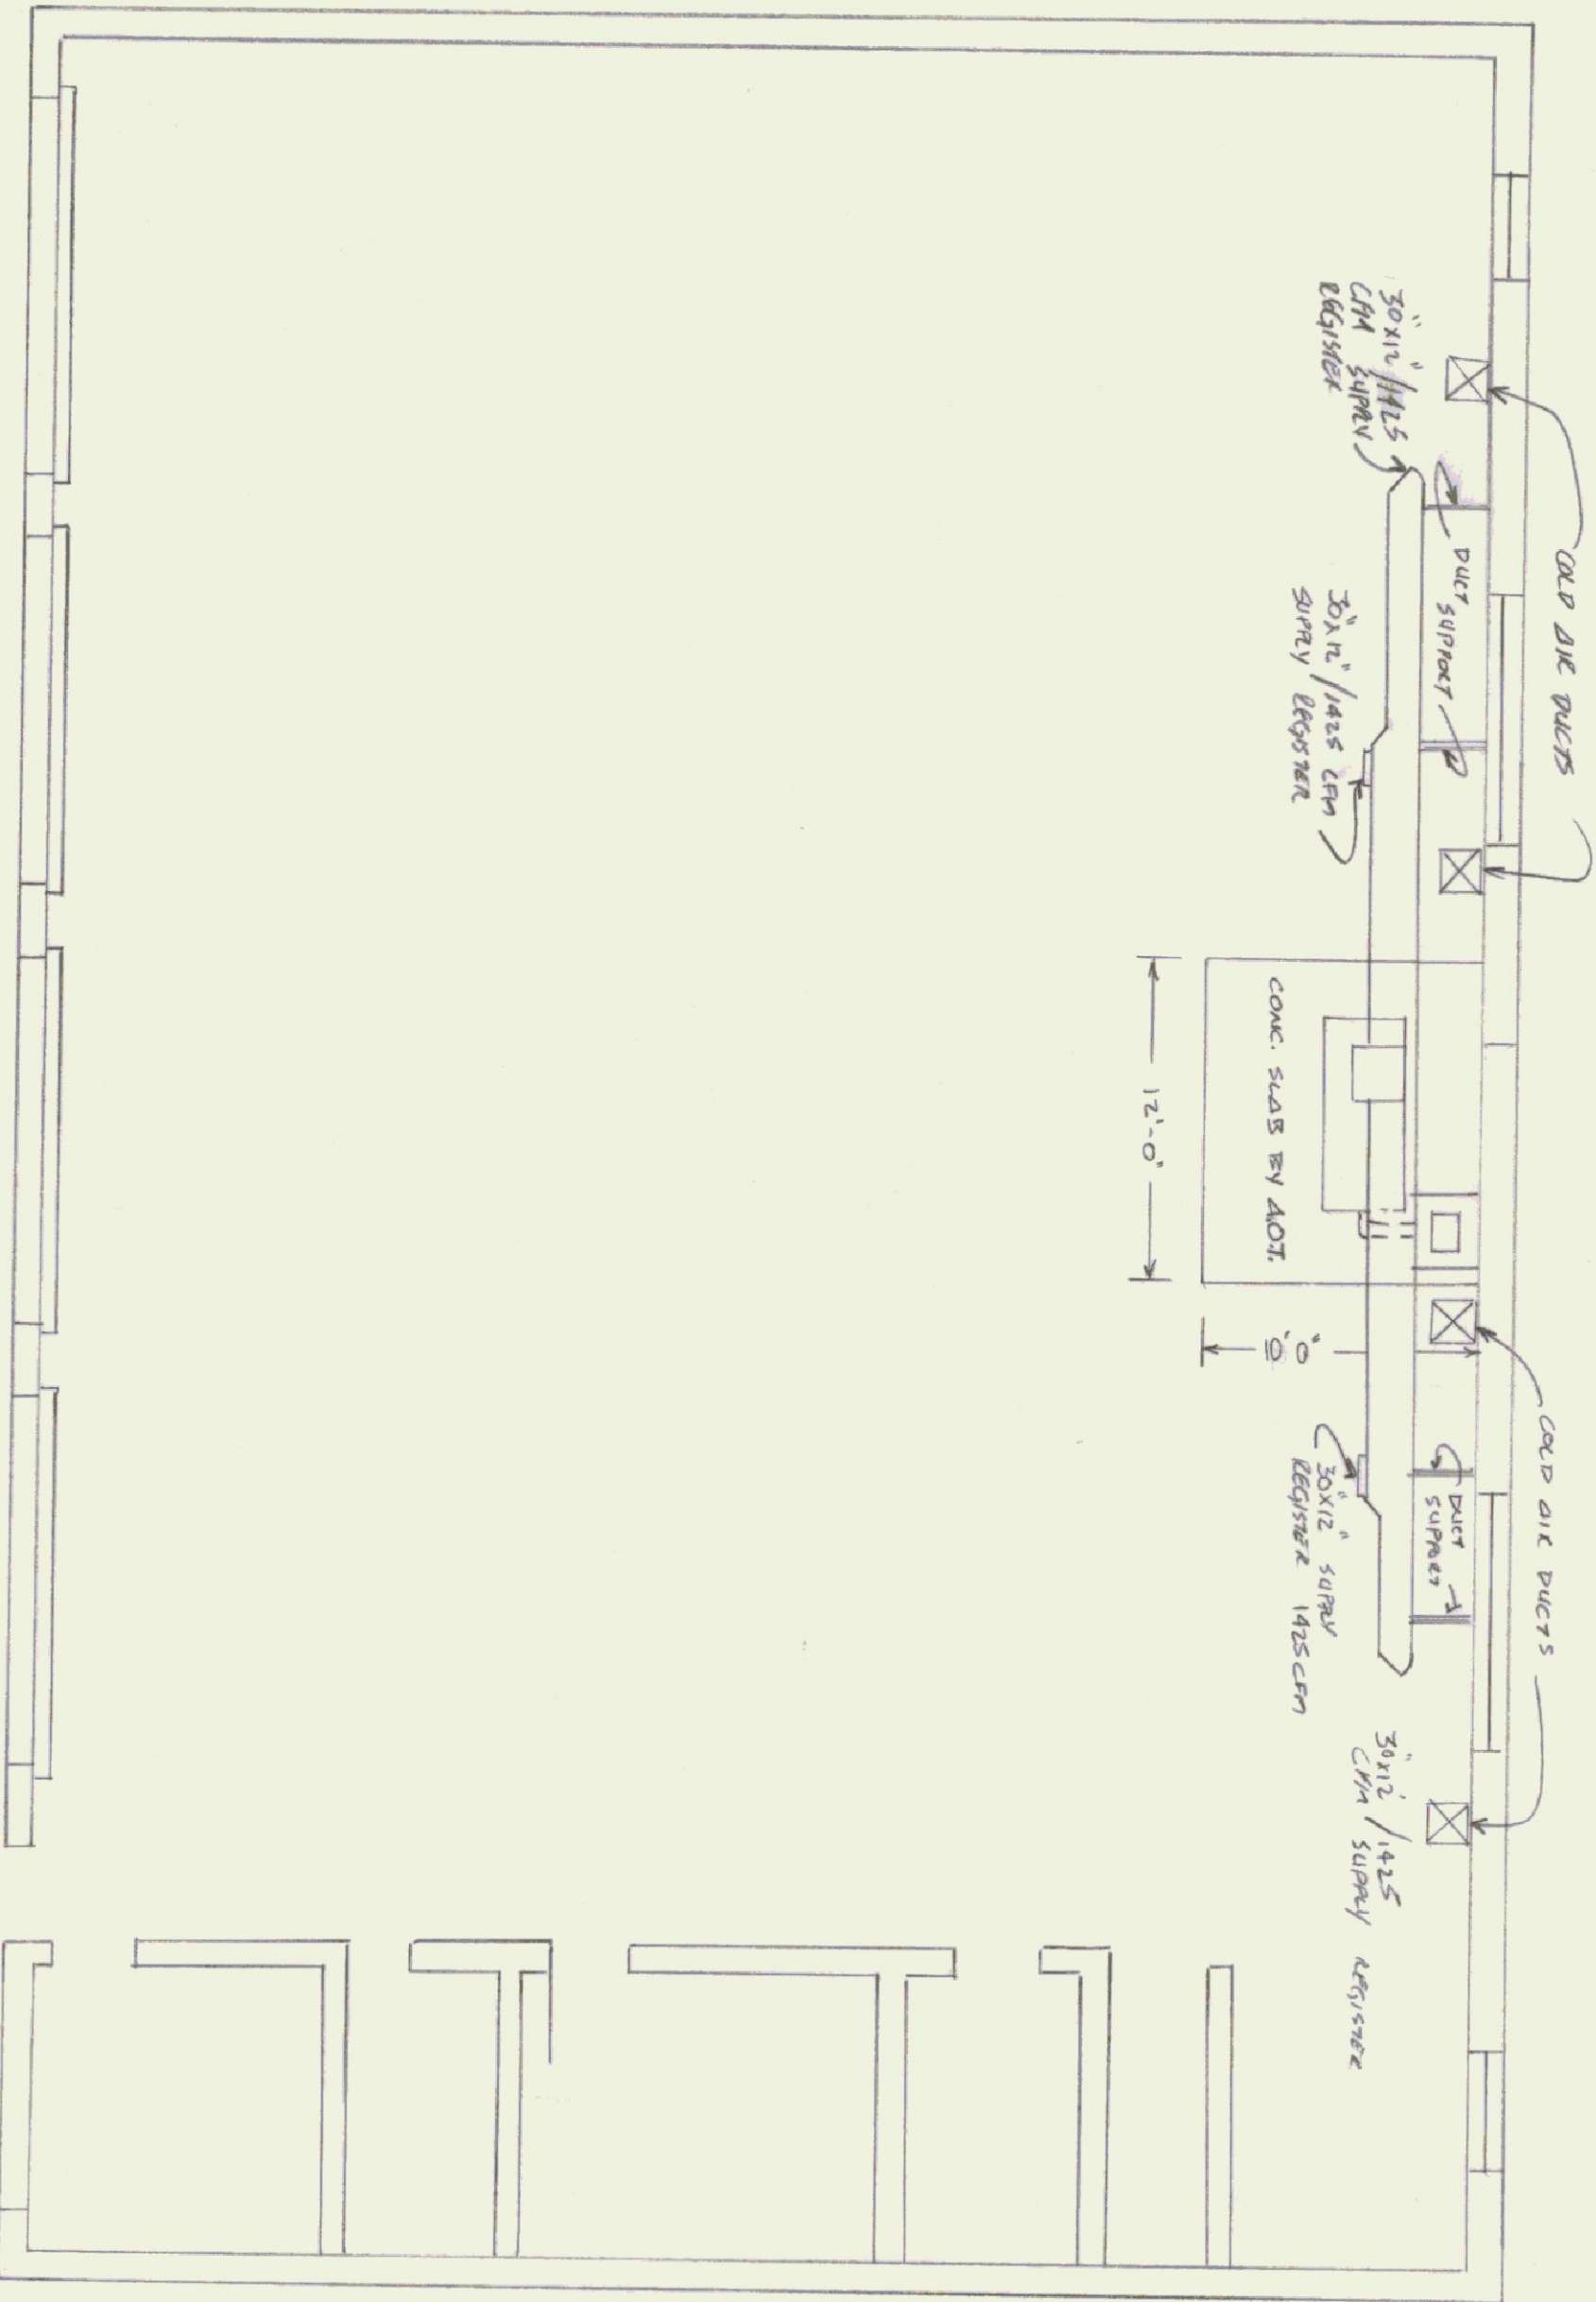


NOTE 3:  
 1/ SUPPLY REGISTERS ARE ADJUSTABLE DOUBLE DEFLECTOR  
 VOLUME DAMPER, ALUMINUM - CARIES HOIST 6821 OR  
 EQUAL. FRAME ALUMINUM OR STEEL BRASS VOLUME - DAMPER BEHIND EACH DEFLECTOR  
 2/ PROVIDE STIFFENING RIBS IN ALL DUCT-WORK.  
 3/ PROVIDE FILTERS IN ALL RETURN AIR DUCTS.

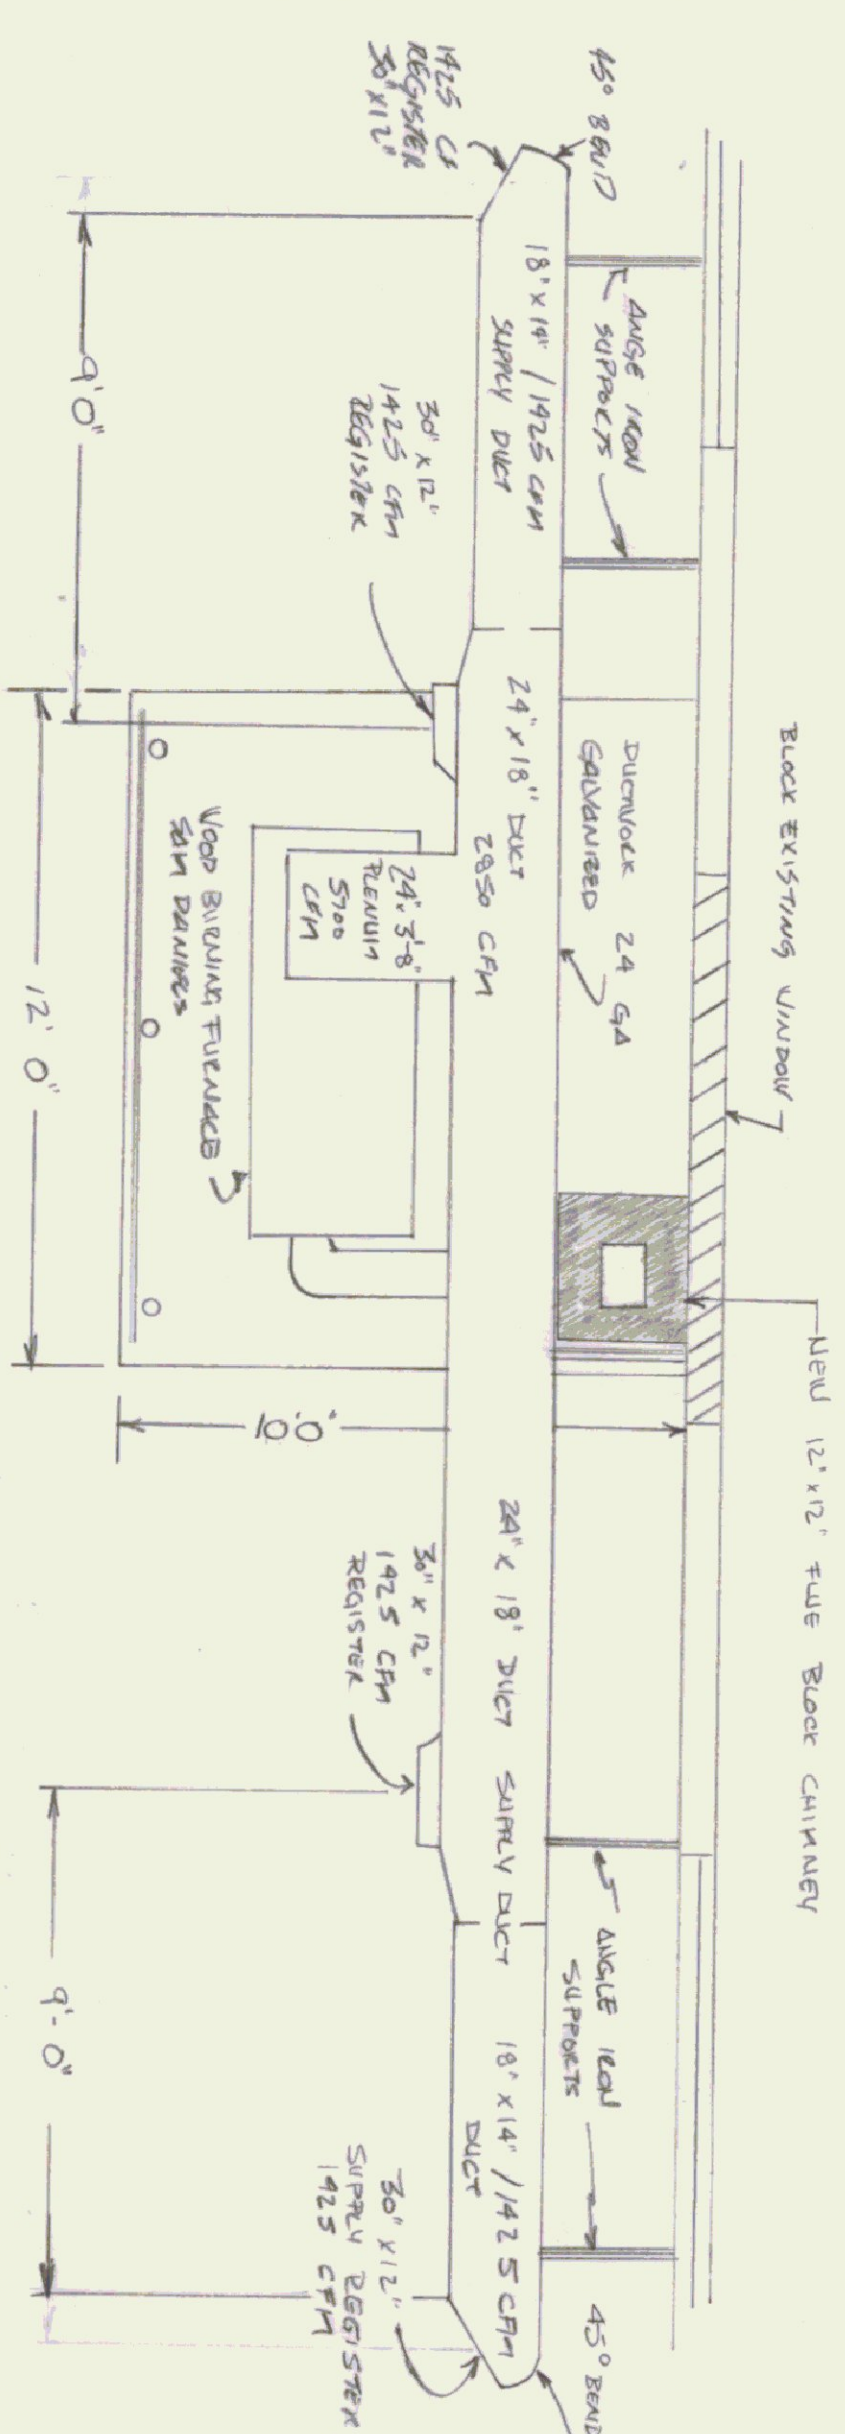

FLOOR PLAN  
 SCALE 1/8" = 1'0"

PLAN OF FURNACE @ SLABS  
 SCALE 1/4" = 1'0"

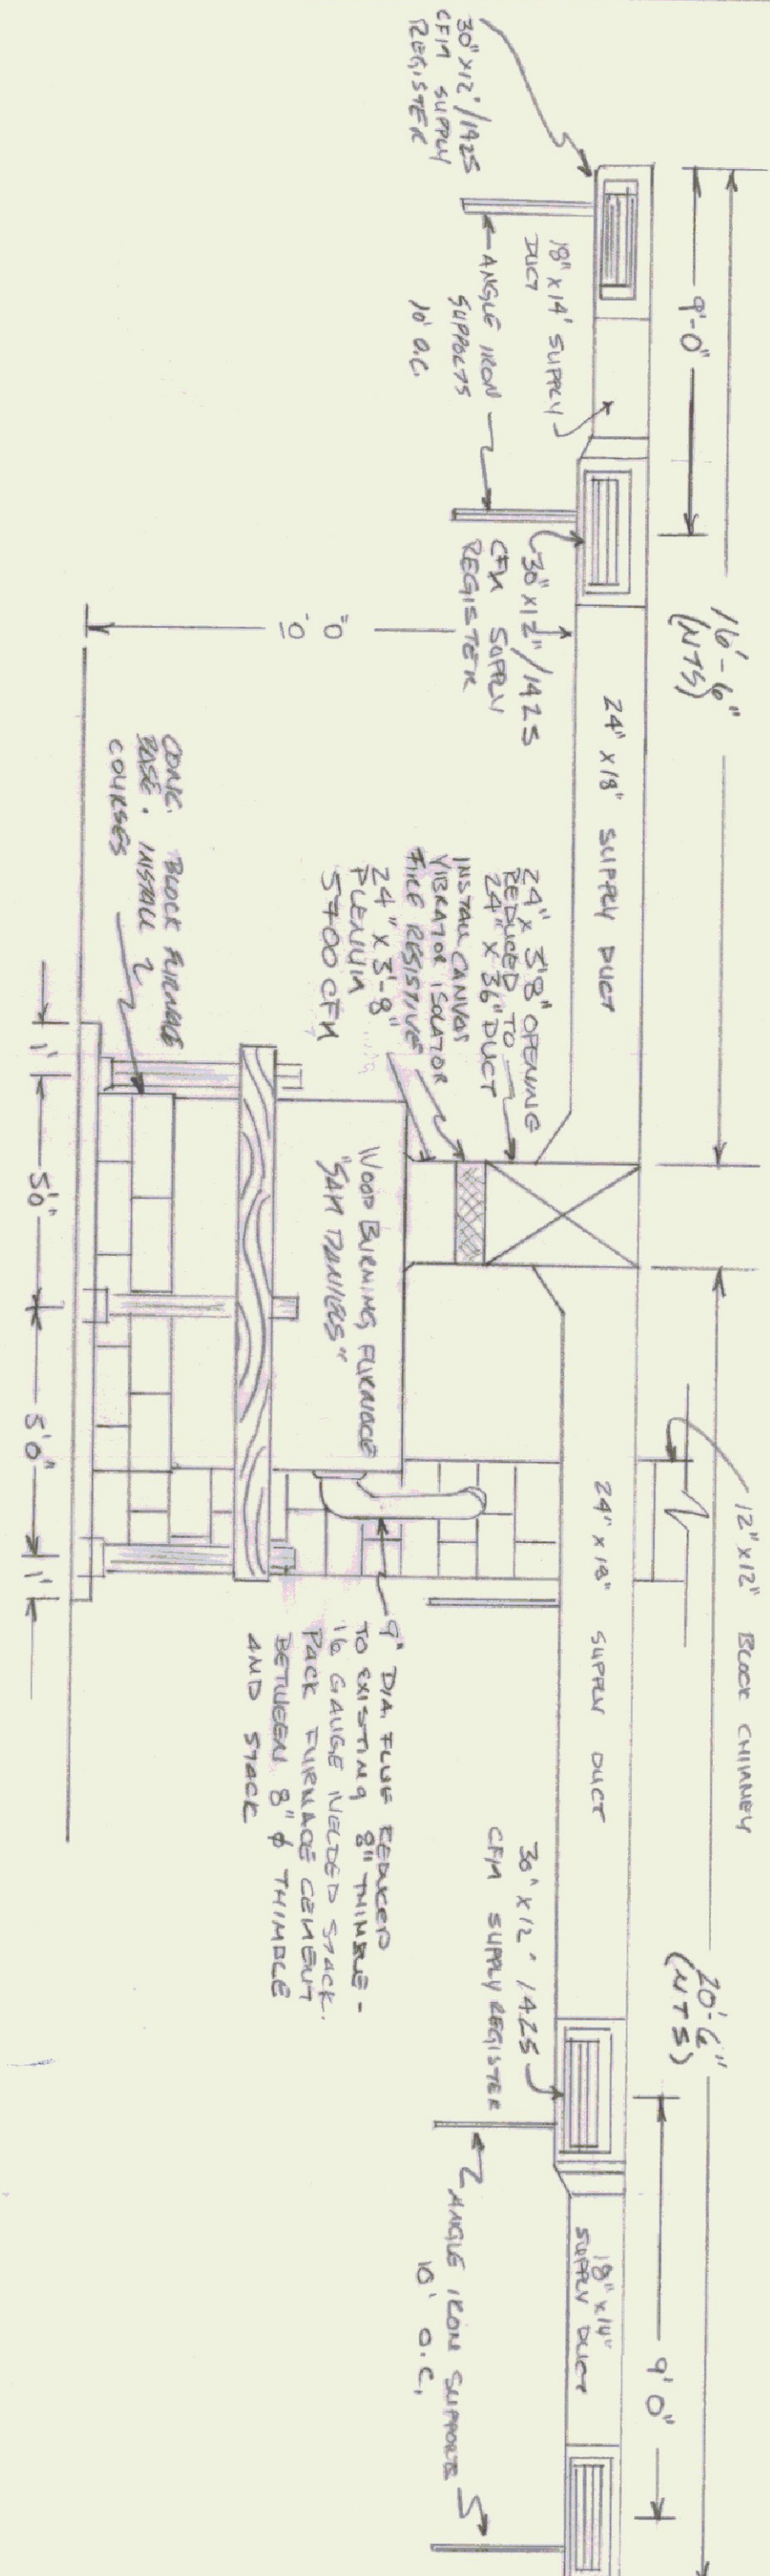

ELEVATION C FRONT OF FURNACE  
 1/4" = 1'0"

|                                   |                    |                            |          |
|-----------------------------------|--------------------|----------------------------|----------|
| STATE OF VERMONT                  |                    |                            |          |
| DIVISION OF STATE BUILDINGS       |                    |                            |          |
| AGENCY OF ADMINISTRATION          |                    |                            |          |
| MONTPELIER, VERMONT               |                    |                            |          |
| WOOD BURNING FURNACE INSTALLATION |                    |                            |          |
| GARAGE AT MOORESVILLE             |                    |                            |          |
| AGENCY OF TRANSPORTATION          |                    |                            |          |
| DATE:<br>10-5-81                  | SCALE:<br>AS NOTED | REVISIONS:<br>5 NOV 81 HSK | DWG. NO. |
| DRAWN BY:<br>SL                   | APPROVED BY:       |                            | OF       |