


HEATING PLAN
(5 BAY)

SCALE: 3/8"=1'-0"

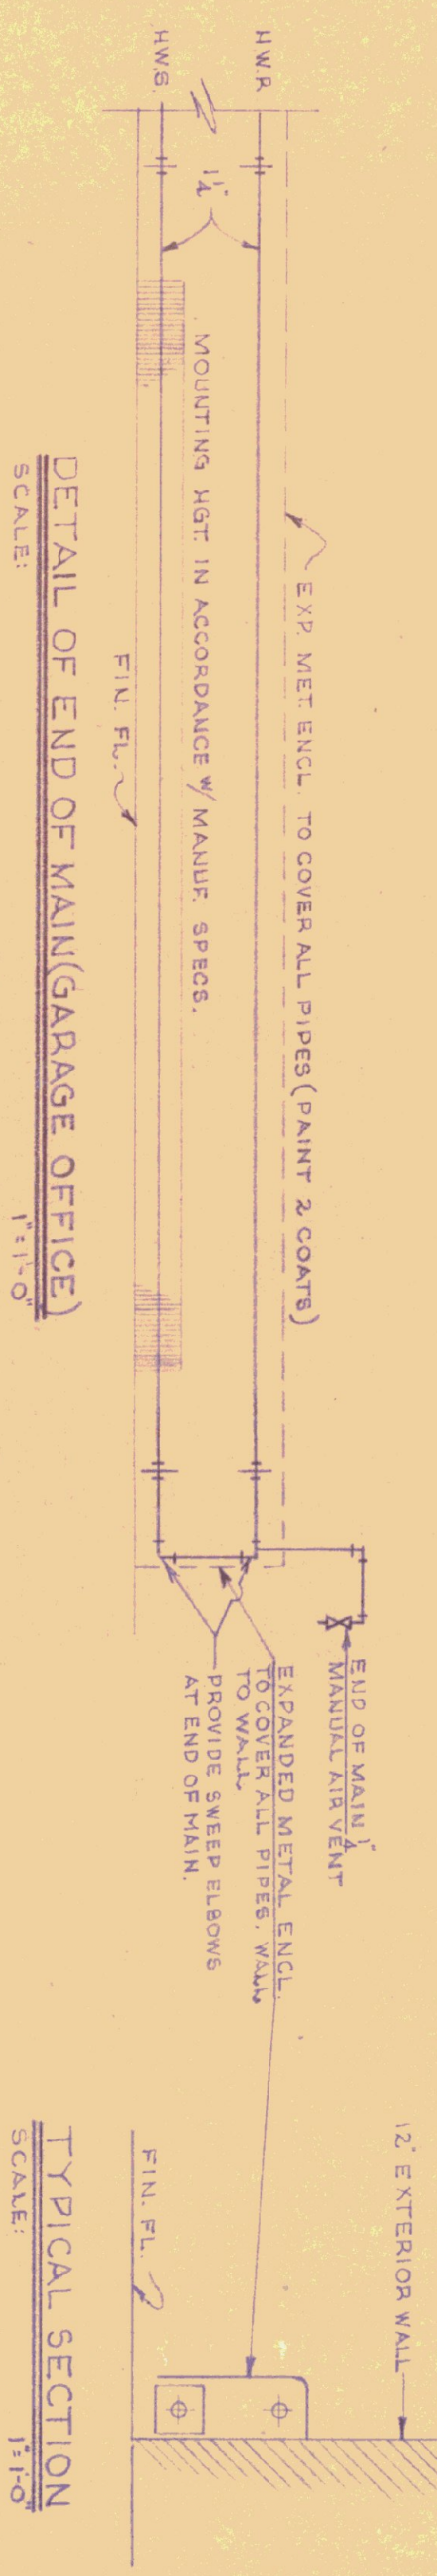


DETAIL OF END OF MAIN (GARAGE OFFICE)

SCALE: 1/2"=1'-0"

TYPICAL SECTION

SCALE: 1/2"=1'-0"

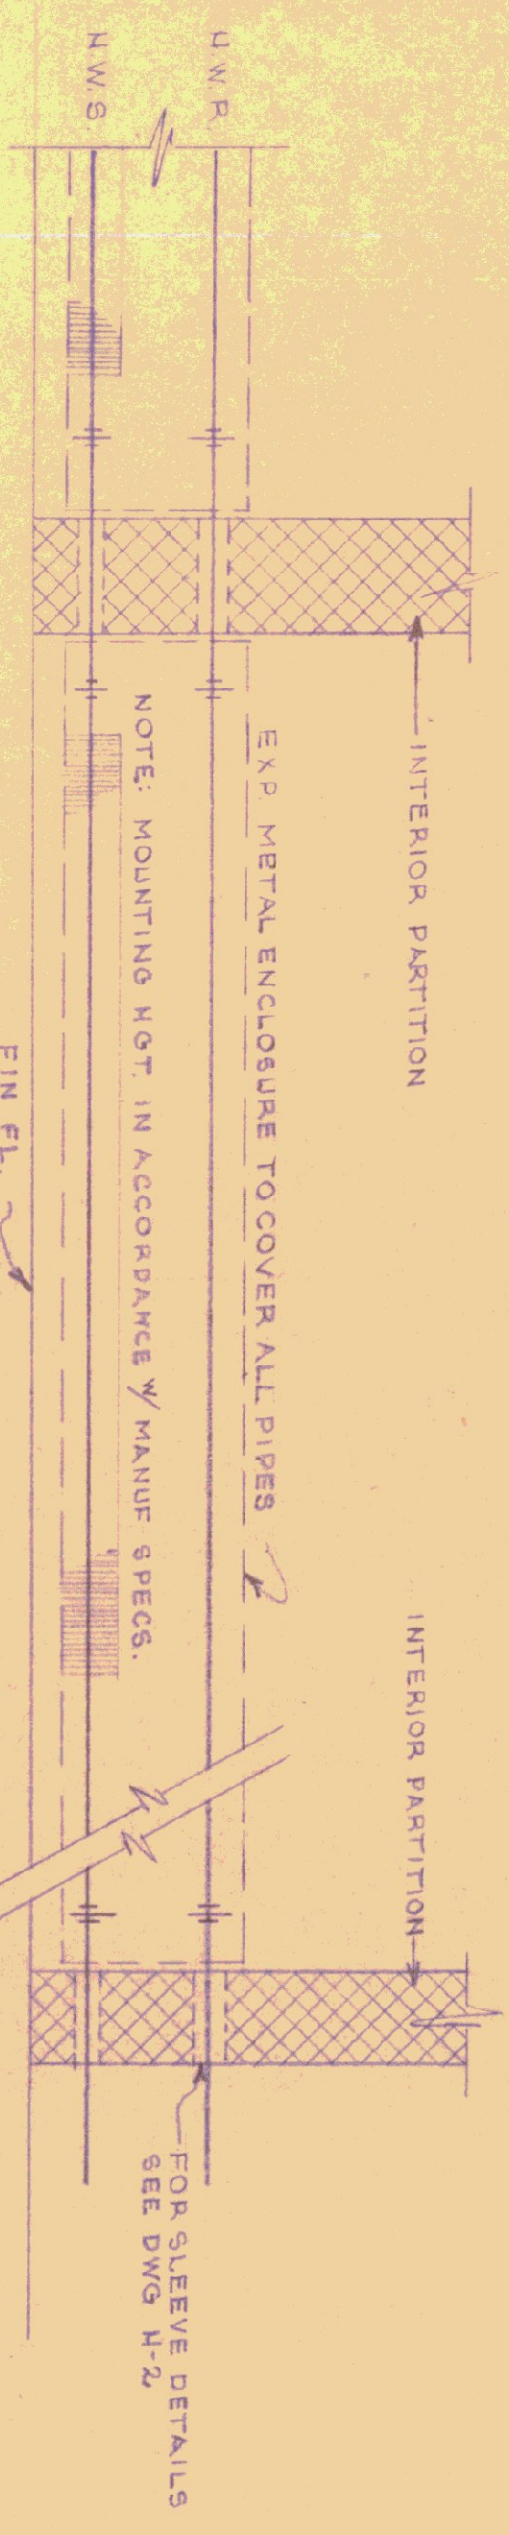

TYPICAL BASEBOARD RADIATION PIPING

SCALE: 1/2"=1'-0"

PLUMBING PLAN

SCALE: 1/4"=1'-0"

PLUMBING ISOMETRIC DIAGRAM



SEE DRAWING H-2 FOR SCHEDULE & GENERAL NOTES

- LEGEND**
- H.W.S. ---
 - H.W.R. ---
 - 5/8" ---
 - 3/4" ---
 - 1" ---
 - 1 1/2" ---
 - 2" ---
 - 3" ---
 - 4" ---
 - 6" ---
 - 8" ---
 - 10" ---
 - 12" ---
 - 14" ---
 - 16" ---
 - 18" ---
 - 20" ---
 - 24" ---
 - 30" ---
 - 36" ---
 - 42" ---
 - 48" ---
 - 54" ---
 - 60" ---
 - 72" ---
 - 84" ---
 - 96" ---
 - 108" ---
 - 120" ---
 - 144" ---
 - 168" ---
 - 192" ---
 - 216" ---
 - 240" ---
 - 270" ---
 - 300" ---
 - 324" ---
 - 360" ---
 - 408" ---
 - 456" ---
 - 504" ---
 - 540" ---
 - 576" ---
 - 30672" ---