


FLOOR PLAN
SCALE: 1/8" = 1'-0"

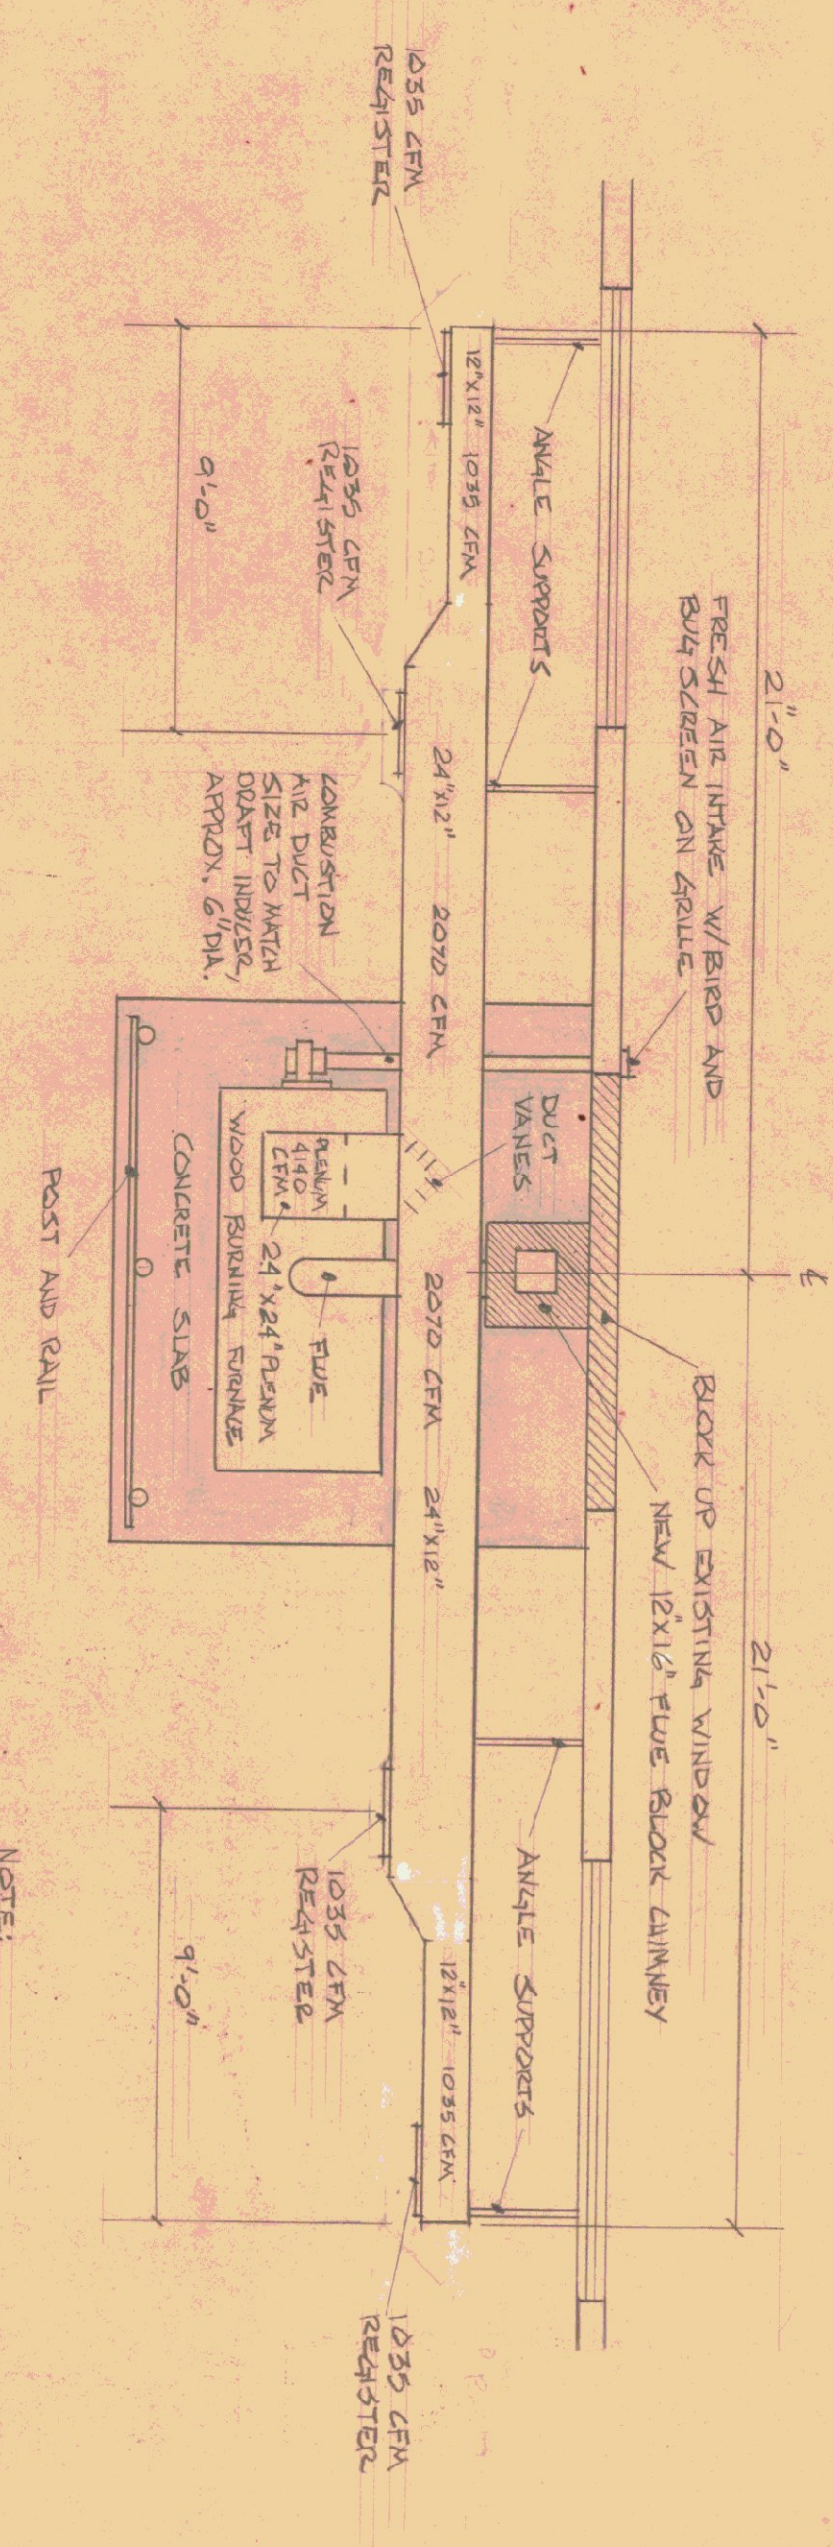

NOTES:
FOR ADDITIONAL DETAILS SEE
TYPICAL DETAIL SHEET N° 2

PLAN AT FURNACE SLAB SCALE 1/4" = 1'-0"

STATE OF VERMONT DIVISION OF STATE BUILDINGS AGENCY OF ADMINISTRATION VERMONT			
WOOD BURNING FURNACE INSTALLATION AT THE AGENCY OF TRANSPORTATION AND LYNDON, VERMONT			
DATE:	SCALE:	REVISIONS:	DWG. NO.
7-28-80	AS NOTED	10-11-80 KH	1 OF 3
DRAWN BY:	APPROVED BY:		
UK/HANSON	[Signature]		